

INDEX OF SHEETS

SHEET NO.	DESCRIPTION
1	TITLE SHEET
2	INDEX OF SHEETS

STATE OF TEXAS DEPARTMENT OF TRANSPORTATION


PLANS OF PROPOSED STATE HIGHWAY IMPROVEMENT FEDERAL AID PROJECT: STP 2023(050)HES MCLENNAN COUNTY **FM 3051**

ROADWAY:	FT= 8299.79	MI.= 1.572
BRIDGE:	FT= 0.00	MI.= 0.000
TOTAL:	FT= 8,299.79	MI.= 1.572

LIMITS: FROM: 0.15 MILES WEST OF CARSON LN TO BRAZOS RIVER

FOR THE CONSTRUCTION OF SAFETY CONSISTING OF INSTALL CONCRETE MEDIAN BARRIER

BEGIN PROJECT
CSJ 2311-01-044
STA. 0+00.00
REF. MRKR. 568+1.49

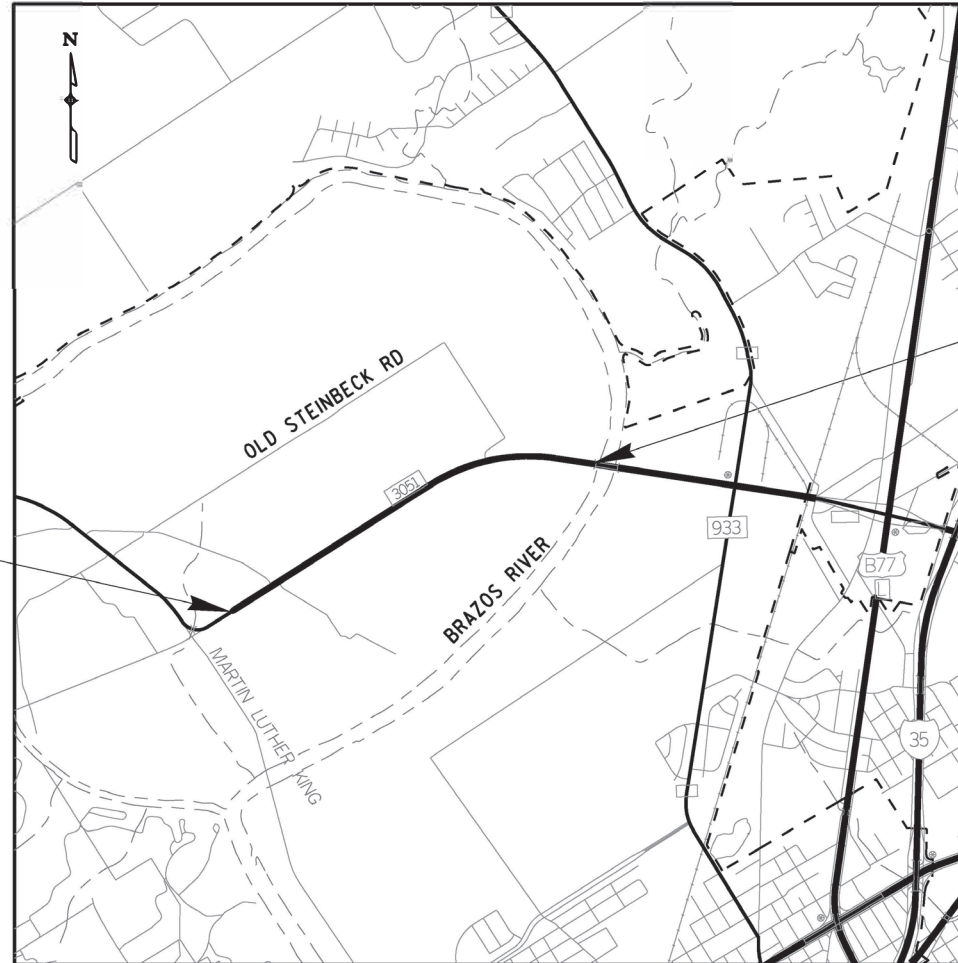

END PROJECT
CSJ 2311-01-044
STA. 82+99.79
REF. MRKR. 570+1.025

1" = 4000.0'

EXCEPTIONS: NONE
EQUATIONS: NONE
RR CROSSINGS: NONE
SCALE: 1" = 4000.00'

SPECIFICATIONS ADOPTED BY THE TEXAS DEPARTMENT OF TRANSPORTATION, NOVEMBER 1, 2014 AND SPECIFICATION ITEMS LISTED AND DATED AS FOLLOWS, WILL GOVERN ON THIS PROJECT: REQUIRED CONTRACT PROVISIONS FOR ALL FEDERAL - AID CONSTRUCTION CONTRACTS (FORM FHWA 1273, JULY 2022).

DESIGN	FED. RD. DIV. NO.	FEDERAL AID PROJECT NO.		HIGHWAY NO.
GRAPHICS	6	STP 2023(050)HES		FM 3051
CHECK	STATE	DISTRICT	COUNTY	SHEET NO.
CHECK	TEXAS	WACO	MCLENNAN	1
CHECK	CONTROL	SECTION	JOB	
	2311	01	044	

DESIGN SPEED = 50 MPH

YEAR	ADT
2020	20003
2040	28004



Recommended for Letting **10/25/2022**

DocuSigned by:
[Signature], P.E.
6D9791C615CF49B...
Area Engineer

Recommended for Letting **10/26/2022**

[Signature], P.E.
Director of Transportation Planning & Development

Approved for Letting **10/26/2022**

DocuSigned by:
Stanley Swiatek
B69BD796DD564C9...
District Engineer

pw: \\+xdot+.pro.jectw\seon\line.com:TXDOT3\Documents\09 - WAC\Design Projects\231101044\4 - Design\Master\Boundary Cont\100-Master Sheets

p:\xdo\project\wiseon\line.com\TXDOT3\Documents\09 - WAC\Design Projects\231101044\4 - Design\Plan\2022\General\INDEX OF SHEETS.dwg 7:51 PM


NODE

SHEET NO. DESCRIPTION

GENERAL	
1	TITLE SHEET
2	INDEX OF SHEETS
3	TYPICAL SECTION
4, 4A-4C	GENERAL NOTES
5	ESTIMATE & QUANTITY
6	CONSOLIDATED SUMMARIES
7	CRASH CUSHION SUMMARY SHEET
TRAFFIC CONTROL PLAN	
8	SEQUENCE OF CONSTRUCTION
TRAFFIC CONTROL PLAN STANDARDS	
9-20	BC (1)-21 THRU BC (12)-21
21	TCP (1-1)-18
22	TCP (1-2)-18
23	TCP (2-1)-18
24	TCP (2-2)-18
25	TCP (5-1)-18
26	WZ (RS)-22
ROADWAY DETAILS	
27-31	PLAN LAYOUT
ROADWAY DETAILS STANDARDS	
32	GF (31)-19
33-34	GF (31)TRTL3-20
35	GF (31)MS-19
36	RAIL-ADJ(B)-19
37	BED-14
38-39	SSCB(2)-10
40	SSCB(5)-10
41	SGT (11S)31-18
42	SGT (12S)31-18
43	SGT (15)31-20
44	QGELITE (M10) (N) -20
45	REACT (M) -21
46	SMTC (N) -16
47	TAU-II-R (N) -16
48	TE (HMAC) -11
49	MBGF-19
50	MBGF (TR) -19
51	MBGF (MS) -19
52	BED(28)-19
53-58	D&OM(1)-20 THRU D&OM(6)-20
59	D&OM(VIA)-20
ENVIRONMENTAL ISSUES	
60	SW3P
61	EPIC
ENVIRONMENTAL ISSUES STANDARDS	
62	EC (1)-16
63-72	TA-BMP (WACO DISTRICT STANDARD)

NOTES:

■ THE STANDARD SHEET SPECIFICALLY IDENTIFIED ABOVE
 HAVE BEEN SELECTED BY ME OR UNDER MY DIRECT
 SUPERVISION AS BEING APPLICABLE TO THIS PROJECT.

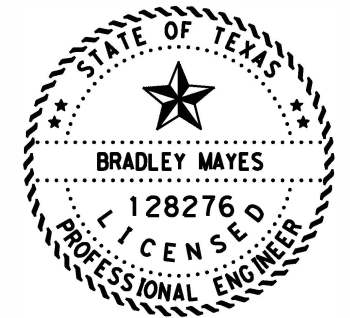


Bradley Mayes 10/25/2022
 SIGNATURE OF REGISTRANT & DATE




INDEX OF SHEETS

CHANGE ORDER	FED. RD. DIV. NO.	CONT	SECT	JOB	HIGHWAY
	6	23II	01	044	FM 305I
	STATE	DIST	COUNTY		SHEET NO.
	TEXAS	WAC	MCLENNAN		2

pw: \\txdot\projectwiseonline.com:TXDOT3\Documents\09 - WAC\Design Projects\231101044\4 - Design\Plan\2022\General\Typical Section.dwg 9:06 PM
 NODE

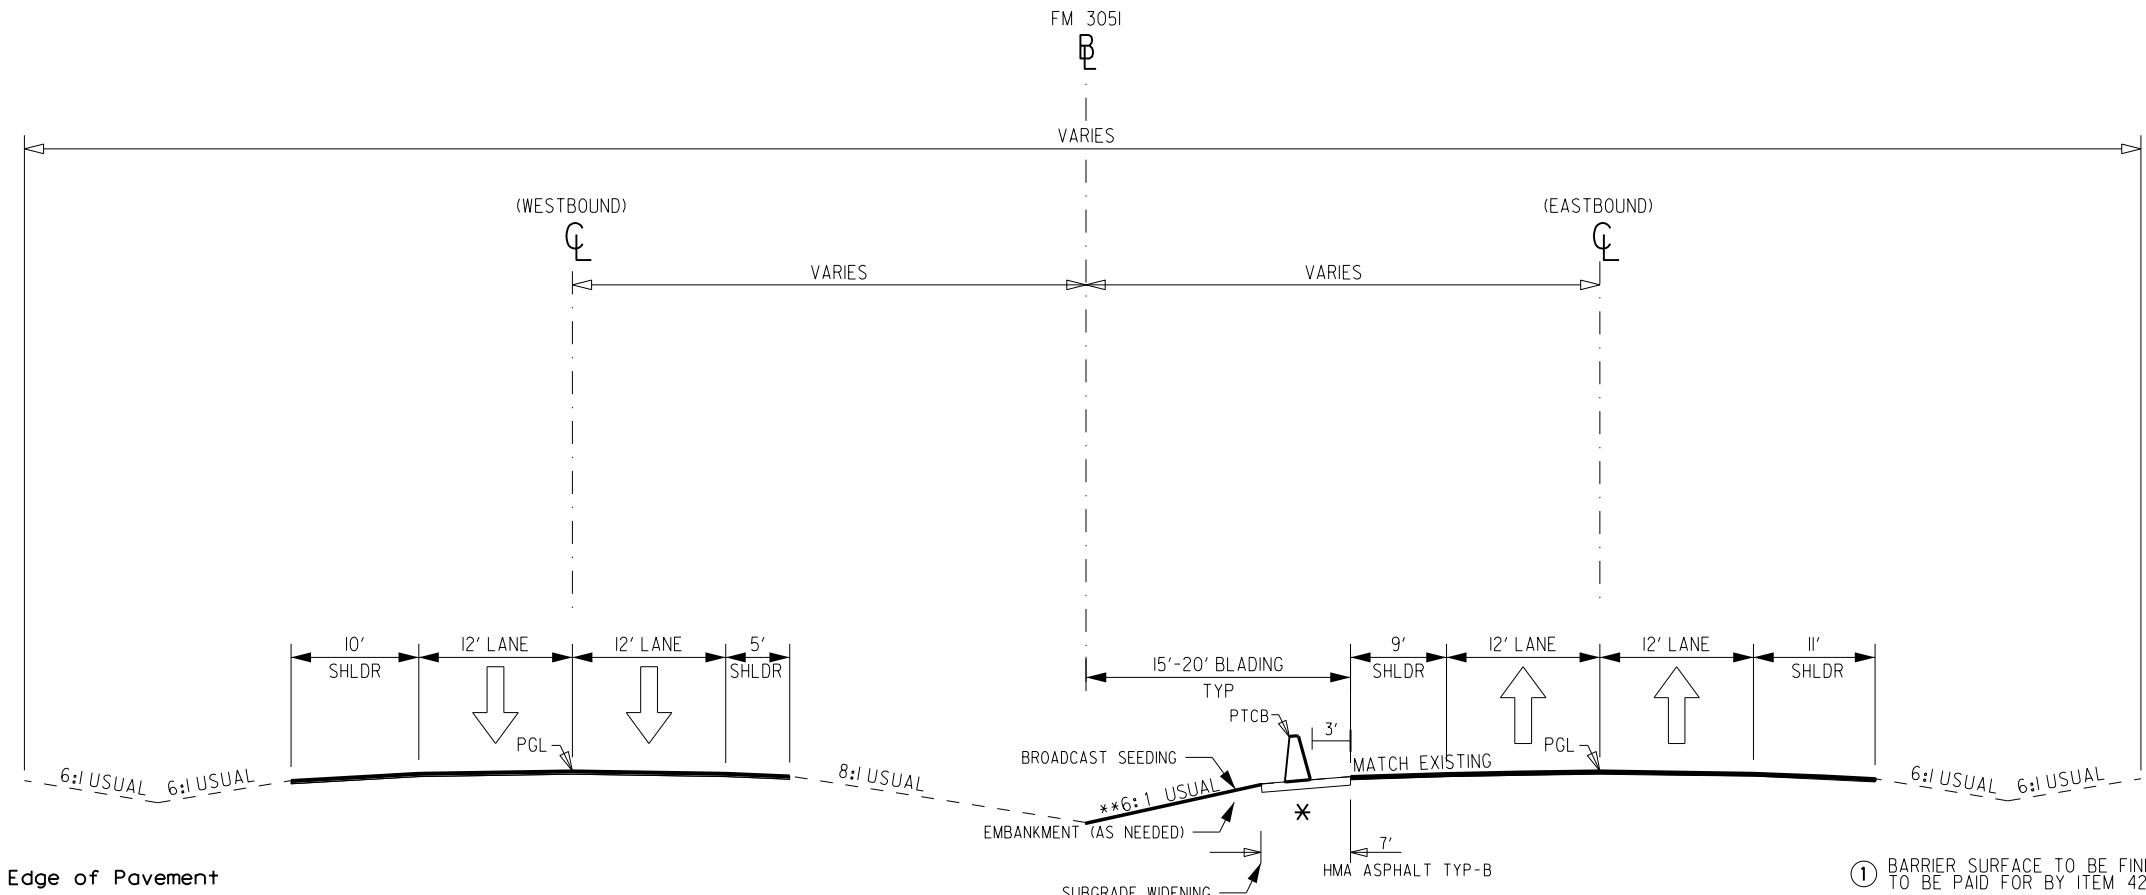


- ① BARRIER SURFACE TO BE FINISHED AS SPECIFIED BY SSCB(2)-10 TO BE PAID FOR BY ITEM 427-6002
- ② SEAL SSCB CONNECTIONS WITH CLB CONC. TO BE PAID FOR BY ITEM 420-6012
- ③ BARRIER TO BE PINNED AS SHOWN ON SSCB(5)-10 STANDARD

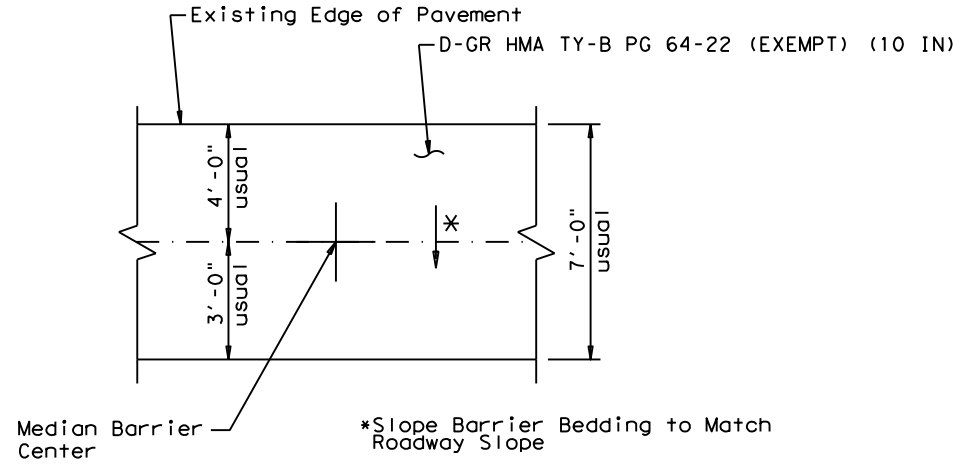


PROPOSED TYPICAL SECTION

CSJ 2311-01-044, FROM STA. 0+00.00 TO STA 82+99.79

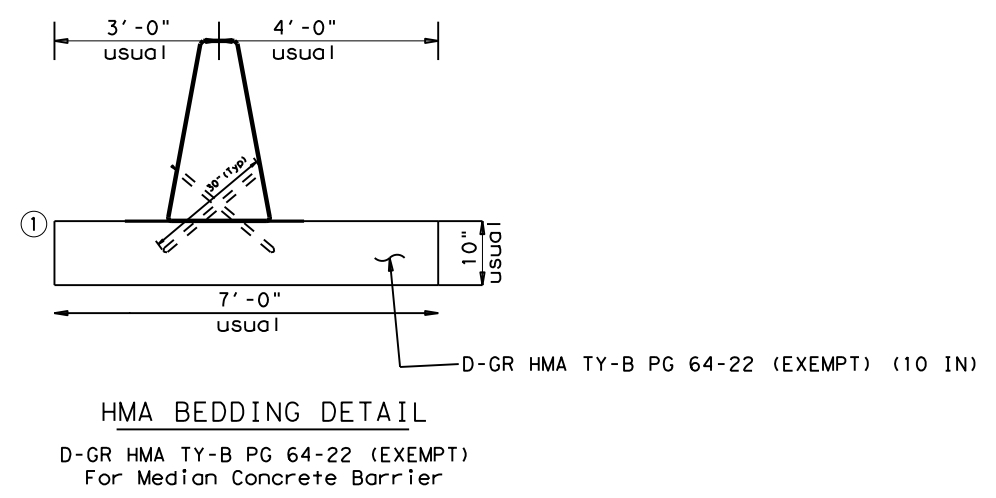

** SLOPE FROM BACK OF BARRIER BEDDING TO BOTTOM OF DITCHLINE

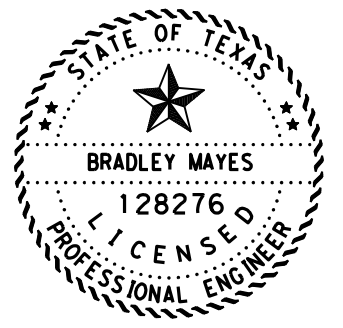

Bradley Mayes 10/25/2022
 SIGNATURE OF REGISTRANT & DATE



TYPICAL SECTION

SCALE: 1" = 15' FEET
 HORIZ. SHEET 1 OF 1

CHANGE ORDER	FED. RD. DIV. NO.	CONT	SECT	JOB	HIGHWAY
	6	2311	01	044	FM 3051
	STATE	DIST	COUNTY		SHEET NO.
	TEXAS	WAC	MCLENNAN		3

BASIS OF ESTIMATE TABLES

Table 1: Basis of Estimate for Erosion Control Items				
Item	Description	Rate	Basis	Quantities
*166	FERTILIZER			
	FERTILIZER (20-10-10) (PERMANENT)	300 LBS / AC	2.01 AC	0.30 TON
168	VEGETATIVE WATERING			
	(3 APPLICATIONS - PERM)	13,100 GAL/AC/APP	2.01 AC	79.5 MG

Table 6: Basis of Estimate for Asphalt Pavements				
Item	Description	Rate	Basis	Quantities
3076	DENSE-GRADED HOT MIX ASPHALT			
	TY-B PG 64-22	110 LB / SY / IN	5,407 SY	2,974 TON
	TACK COAT	0.1 GAL/SY/LIFT OF HMAC	5,407 SY	1,636 GAL

*Tack Rate for all interlayer tack use

GENERAL

The construction, operation and maintenance of the proposed project will be consistent with the state implementation plan as prepared by the Texas Commission on Environmental Quality.

The disturbed area for this project, as shown on the plans is 2.01 acres. However, the Total Disturbed Area (TDA) will establish the required authorization for storm water discharges. The TDA of this project will be determined by the sum of the disturbed area in all project locations in the contract, and all disturbed area on all Project-Specific Locations (PSL) located in the project limits and/or within 1 mile of the project limits. The department will obtain an authorization to discharge storm water from the Texas Commission on Environmental Quality (TCEQ) for the construction site as shown on the plans, according to the TDA of the project. The Contractor will obtain any required authorization from the TCEQ for the discharge of storm water from any PSL for construction support activities on or off of the project row according to the TDA of the project. When the TDA for the project exceeds 1 acre, provide a copy of the appropriate application of permit (NOI, or Construction Site Notice) to the Engineer, for any PSL located in the project limits or within 1 mile of the project limits. Follow the directives and adhere to all requirements set forth in the TCEQ, Texas Pollution Discharge Elimination System, Construction General Permit (TPDES, CGP).

Contractor questions on this project are to be emailed to the Waco District at the following address:

Bill Compton - Wacoprebid@txdot.gov, 254-867-2770, 100 S. Loop Dr., Waco, TX
 Carmen Chau - Wacoprebid@txdot.gov, 254-867-2794, 100 S. Loop Dr., Waco, TX

Or Via phone or in person to the following individual(s):
 Area Engineer's: Clayton Zacha, P.E. 254-867-2707
 Assistant Area Engineer's: Jeff Jackson

All Contractor questions will be reviewed by the Area Engineer or Assistant Area Engineer. Once a response is developed, it will be posted to TxDOT's Public FTP at the following Address:
[https://ftp.dot.state.tx.us/pub/txdot-info/Pre-Letting%20 Responses/](https://ftp.dot.state.tx.us/pub/txdot-info/Pre-Letting%20Responses/)

All questions submitted that generate a response will be posted through this site. The site is organized by District, Project Type (Construction or Maintenance), Letting Date, CCSJ/Project Name.

GENERAL NOTES

ITEM 5: CONTROL OF THE WORK

Provide the Engineer with a weekly work schedule of planned activities including anticipated quantities of materials to be placed daily (CY of each concrete placement, tons of HMAC to be placed daily, etc.). Schedules will be provided for the following week as part of each week's project meetings or by 5PM on Thursday as approved by the Engineer. Failure to provide notifications are required here may be deemed as insufficient notice per item 5.10.

Provide the Engineer Daily by 3PM the planned activities for the following day including location, quantities of materials to be placed, etc. in a format acceptable to the Engineer.

Submit all fabrication and shop drawings per TxDOT's online shop drawing submittal system and copy the Area Engineer on the email submittal, unless otherwise directed.

Where a precast or cast-in-place concrete element is shown in the plans, Contractor may submit a precast concrete alternate in accordance with "Standard Operating Procedure for Alternate Precast Proposal Submission" found online at:

<https://www.txdot.gov/inside-txdot/forms-publications/consultants-Contractors/publications/bridge.html#design>.

Acceptance or denial of an alternate is at the sole discretion of the Department. Contractor is responsible for impacts to the project schedule and cost resulting from the use of alternates.

Underground utilities owned by the Texas Department of Transportation may be present within the Right-Of-Way on this project. For signal, illumination, surveillance, and communications & control maintained by TxDOT, call the TxDOT Traffic Signal Office (254)867-2808 for locates a minimum of 48 hours in advance of excavation. For irrigation systems, call TxDOT Landscape Office (254)867-2726 for locates a minimum of 48 hours in advance of excavation. If city or town owned irrigation facilities are present, call the appropriate department of the local city or town a minimum of 48 hours in advance of excavation. The Contractor is liable for all damages when utilities are

damaged due to Contractor's negligence including, but not limited to, repair or replacement at the Contractor's expense.

ITEM 6: CONTROL OF MATERIALS

To comply with the latest provisions of Build America, Buy America Act (BABA Act) of the Bipartisan Infrastructure Law, the contractor must submit a notarized original of the TxDOT Construction Material Buy America Certification Form for all items classified as construction materials. This form is not required for materials classified as a manufactured product.

Refer to the Buy America Material Classification Sheet for clarification on material categorization.

The Buy America Material Classification Sheet is located at the below link.

<https://www.txdot.gov/business/resources/materials/buy-america-material-classification-sheet.html> for clarification on material categorization.

References to manufacturer's trade name or catalog numbers are for the purpose of identification only and the Contractor will be permitted to furnish like materials of other manufacturers provided they are of equal quality and comply with specifications for this project.

ITEM 7: LEGAL RELATIONS AND RESPONSIBILITIES

No significant traffic generator events identified.

If utilizing private property for waste disposal sites, field office sites, equipment storage sites or for any other purpose involved with this project, provide to the Engineer written proof of the property owner's approval of the use of this property. This proof may be in the form of a letter or agreement signed by the property owner or other documents acceptable to the Engineer. Provide such proof prior to occupying the site.

Personal vehicles of the Contractor's employees will not be parked within the right of way at any time including any section closed to public traffic, unless the vehicle is being utilized for construction procedures. However, the Contractor's employees may park on the right of way at the sites where the Contractor has his office, equipment and materials storage yard.

ITEM 8: PROSECUTION AND PROGRESS

This Project will be a Standard Workweek in accordance with Article 8.3.1.4.

Meet bi-weekly or at intervals as agreed upon with the Engineer to notify him or her of planned work for the upcoming 3-week period.

For this project, provide a Bar Chart progress schedule.

Submit the schedule in both PDF and in a base software electronic file format acceptable to TxDOT to allow for import and analysis into TxDOT's current scheduling software.

ITEM 132: EMBANKMENT

Excavated material from the project site has not been determined to be suitable for embankment. The bidder assumes all risk for the use of excavated materials for embankment and is expected to meet all material requirements for embankment regardless of the source.

ITEM 150: BLADING

The limits of blading and grading operations will be to the minimum width and length necessary to accomplish the required work. The Contractor will limit the removal of permanent grass that is already established at the proper lines and grades.

All Blading work will be accomplished in such a manner as to maintain / restore drainage patterns. Any Blading work that impedes drainage will be repaired at the Contractor's expense.

ITEM 164: SEEDING FOR EROSION CONTROL

Contractor will mow or disc wheat and or oats in spring prior to vegetation going to seed.

Permanent seed mixes for both urban and rural projects including sand or clay soils in the Waco District will be bid and installed to include a minimum of one & one-half (1.5) pounds per acre Green Sprangletop seed and four (4) pounds per acre Bermudagrass seed, with other seed types also being included and quantities remaining unchanged.

ITEM 500: MOBILIZATION

Material On Hand (MOH) will not be used in calculating partial payments for Mobilization.

ITEM 502: BARRICADES, SIGNS, AND TRAFFIC HANDLING

The Contractor Force Account "Safety Contingency" that has been established for this project is intended to be utilized for work zone enhancements, to improve the effectiveness of the Traffic Control Plan, that could not be foreseen in the project planning and design stage. These enhancements will be mutually agreed upon by the Engineer and the Contractor's Responsible Person based on weekly or more frequent traffic management reviews on the project. The Engineer may choose to use existing bid items if it does not slow the implementation of enhancement.

Access will be provided to all business and residences at all times. Where turning radii are limited during phased construction at intersections, provide all weather surfaces such as RAP or base in turning movements to accommodate and to protect the traffic from edge drop-offs. Materials, labor, maintenance and removal for these temporary accesses and radii will not be paid for directly but will be considered subsidiary to the various bid items.

The Contractor Responsible Person(s) (CRP) for Work Zone Traffic Controls will inspect and ensure any deficiencies are corrected each and every day throughout the duration of this contract.

Any misaligned or damaged traffic control devices will be repaired as soon as practical after deficiency is discovered.

In addition to providing a Contractor's Responsible Person and a phone number for emergency contact, have an employee(s) available to respond on the project for emergencies and for taking corrective measures within One (1) Hour.

ITEM 504: FIELD OFFICE

Furnish one Asphalt Mix Control Laboratory (Type D) for this project.

ITEM 506: TEMPORARY EROSION, SEDIMENTATION AND ENVIRONMENTAL CONTROLS

Take all practicable precautions to prevent debris from being discharged into the Waters of Texas or a designated wetland. Install Best Management Practices before demolition begins and maintain them during the demolition. Remove any debris or construction material that escapes containment devices and are discharged into the restricted areas before the next rain event or within 24 hours of the discharge.

Provide SW3P Signs. Obtain from the Engineer a copy of the project's completed TPDES Storm Water Program Construction Site Notice and Contractor Site Notice. Laminate the sheets and bond with adhesive to 36" X 36" sign blanks. Ensure the sheets remain dry. Apply Type C Blue reflective sheeting as the background and add the text "SW3P" in 5" white lettering, centered at the top. Attach the signs to approved temporary mounts and locate at each of the project limits just inside the right of way line at a readable height or as directed by the Engineer. If the sign cannot be placed outside the clear zone, it must adhere to the TMUTCD. SW3P signs, maintenance, and reposting (for replacement or as needed to ensure readability) will be subsidiary to Item 502.

Leave all right of way areas undisturbed until actual construction is to be performed in said areas.

No soil disturbing activities will begin on any section of TxDOT ROW without adequate sedimentation controls first being installed and functioning at adjacent drainage outfalls. Begin and continuously prosecute the repairs, additions and maintenance of erosion and sedimentation control devices within seven days after the Contractor receives each Form 2118, Field Inspection and Maintenance Report, from the Engineer. Failure of the Contractor to fulfill either of the above requirements places TxDOT in potential non-compliance with permit requirements and may result in withholding estimates or stopping work or both until all environmental permit requirements are fulfilled.

Concrete Washouts are required per the CGP. The Concrete Washout Area(s) structural controls must consist of temporary berms, temporary shallow pits, and/or temporary storage tanks to prevent contaminated runoff and must be lined as to prevent contamination of underlying soil. Ensure pits properly maintained including removal of concrete as not to allow overflow. The location(s) of washout area will be approved by the Engineer. When washout pits are no longer needed, they will be removed, and area will be restored to original condition. This work, materials and labor will not be measured or paid for directly but will be subsidiary to Item 506, "Temporary Erosion, Sedimentation, and Environmental Controls."

Cleaning and sweeping of open roadways due to material spillage or loss from Contractor equipment or tires will be the responsibility of the Contractor at no cost to TxDOT. This work will not be charged as Item 738, "Cleaning and Sweeping Highways". Cleaning and sweeping of roadways will be completed as directed, including multiple times per day, if necessary, to maintain acceptable roadways for the traveling public and to meet environmental regulations. Construction activities will cease when material deposited on the roadway is not properly removed or when equipment is not available as needed. Adequate construction exits will be planned, constructed, and maintained by the Contractor per Item 506, "Temporary Erosion, Sedimentation, and Environmental Controls".

ITEM 512: PORTABLE TRAFFIC BARRIER

Department-furnished concrete traffic barrier units are at a TxDOT yard near the project location or other locations within fifty (50) miles of the project as directed. Barrier provided by TxDOT will be single slope. The Contractor will furnish equipment necessary to load the units at the stockpile locations.

The current locations for barrier are:

Loop 340 stockpile, or the US 84 Bellmead Yard

For designated source portable barrier, the Department will provide the connection hardware. Should adequate hardware not be available, the Contractor will acquire the hardware, provide to the Department and be reimbursed via force account.

ITEM 540: METAL BEAM GUARD FENCE

Furnish steel posts throughout the project except as specifically noted in the plans.

Wooden block out will not be allowed.

ITEMS 542 & 544: REMOVING METAL BEAM GUARD FENCE & GUARDRAIL END TREATMENTS

W-Beam elements, steel posts, and composite material block-outs deemed salvageable will remain the property of the State and will be dismantled and returned to the TxDOT Maintenance yard within fifty (50) miles of project as directed. All other guard fence, and SGT's deemed non-salvageable will become the property of the Contractor.

ITEM 544: GUARDRAIL END TREATMENTS

The use of wooden block-outs will not be allowed.

ITEM 644: SMALL ROADSIDE SIGN ASSEMBLIES

Bolt Clamp type will be used on Texas Triangular Slip Base System.

As practical with new construction, leave the existing sign assemblies in place until the proposed foundation, post and sign are in installed, and then remove the old sign assemblies.

Do not leave any sign foundation holes open overnight. Ensure all holes drilled are at least the minimum required depth with no loose material remaining in the hole.

Stake proposed sign locations and receive approval before installation of sign foundations.

Existing Mile Markers Signs are to be relocated to their original location(s) as they were prior to the beginning of the project.

Expanded foam foundations are not permitted.

Cut the bottom of all posts square.

For sign types which design details are not shown on these plans, fabricate according to the "STANDARD HIGHWAY SIGN DESIGNS FOR TEXAS".

Removed material that is deemed salvageable (signs and posts) will be the property of TxDOT. Deliver salvageable material to the TxDOT Maintenance Office. Remove unsalvageable material.

The Contractor will relocate the existing double sided street name signs and furnish the post mounted brackets for the street name signs to be paid for as part of the proposed Stop Signs (R1-1). Existing street name signs will be mounted above Stop signs. If damaged while being relocated, the Contractor will furnish new double sided street name sign at their own expense.

ITEM 658: DELINEATOR AND OBJECT MARKER ASSEMBLIES

All flexible and GF2 delineators will have a tubular body.

The delineator assembly BRF Class A (D-SW) and (D-SY) are to be single delineators (Class I) attached to a flat, plastic bracket to facilitate the mounting of the delineator on top of the bridge rail at the locations shown on the plans. Submit a sample for approval before ordering materials.

ITEM 3076: DENSE-GRADED HOT-MIX ASPHALT

Use aggregate that meets the Surface Aggregate Classification (SAC) requirement of Class_B_.

Maximum stripping of 0% is required.

Dense-Graded Hot-Mix Asphalt used as concrete pavement underlayment is deemed as "Exempt Production".

RAP from Contractor owned sources may be used if the RAP is fractionated.

ITEM 6001: PORTABLE CHANGEABLE MESSAGE SIGN

This project will require "full matrix" type portable changeable message signs.

Ensure that the Contractor's Responsible Person for traffic control can revise messages within thirty (30) minutes of notification.

Furnish 2 portable changeable message signs. The portable changeable message sign(s) will be used for all lane closures and freeway closures as shown on the traffic control plan standard sheets.

Supply portable changeable message sign(s) in accordance with the Traffic Control Plan standard sheets and Article 6f.55 of the Texas Manual on Uniform Traffic Control Devices for Streets and Highways Part VI.

ITEM 6185: TRUCK MOUNTED ATTENUATORS

The total number of truck mounted attenuators (TMA) required when utilizing the traffic control standards are shown in the tables below.

TCP 1 Series	Scenario	Required TMA
(1-1)-18 / (1-2)-18		1

TCP 2 Series	Scenario	Required TMA
(2-1)-18 / (2-2)-18	All	1

Shadow vehicles equipped for truck mounted attenuators (TMA) for stationary operations will be paid for by the day and must be available for use at any time as determined by the Engineer.

The Contractor will be responsible for determining if one or more of these operations will be ongoing at the same time to determine the total number of TMA needed for the project for those times per plan requirements. Additional TMAs used that are not specified in the plans in which the Contractor expects compensation will require prior approval from the Engineer.



Estimate & Quantity Sheet

CONTROLLING PROJECT ID 2311-01-044

DISTRICT Waco
HIGHWAY FM 3051

COUNTY McLennan

CONTROL SECTION JOB				2311-01-044		TOTAL EST.	TOTAL FINAL
PROJECT ID				A00184043			
COUNTY				McLennan			
HIGHWAY				FM 3051			
ALT	BID CODE	DESCRIPTION	UNIT	EST.	FINAL		
	112-6001	SUBGRADE WIDENING (ORD COMP)	STA	72.900		72.900	
	132-6003	EMBANKMENT (FINAL)(ORD COMP)(TY B)	CY	1,665.000		1,665.000	
	150-6001	BLADING	STA	72.900		72.900	
	164-6007	BROADCAST SEED (PERM) (URBAN) (CLAY)	SY	9,275.000		9,275.000	
	168-6001	VEGETATIVE WATERING	MG	79.500		79.500	
	420-6012	CL B CONC (MISC)	CY	8.000		8.000	
	427-6002	CONCRETE PAINT FINISH	SF	60,632.000		60,632.000	
	432-6045	RIPRAP (MOW STRIP)(4 IN)	CY	60.000		60.000	
	496-6030	REMOVE STR (BOLLARD)	EA	17.000		17.000	
	500-6001	MOBILIZATION	LS	1.000		1.000	
	502-6001	BARRICADES, SIGNS AND TRAFFIC HANDLING	MO	2.000		2.000	
	506-6038	TEMP SEDMT CONT FENCE (INSTALL)	LF	100.000		100.000	
	506-6039	TEMP SEDMT CONT FENCE (REMOVE)	LF	100.000		100.000	
	512-6013	PORT CTB (DES SOURCE)(SGL SLP)(TY 1)	LF	6,750.000		6,750.000	
	540-6002	MTL W-BEAM GD FEN (STEEL POST)	LF	850.000		850.000	
	540-6006	MTL BEAM GD FEN TRANS (THRIE-BEAM)	EA	2.000		2.000	
	540-6010	MTL W-BEAM GD FEN ADJUSTMENT	LF	100.000		100.000	
	540-6023	MTL BEAM GD FEN TRANS(THRIE BEAM)28"	EA	2.000		2.000	
	542-6001	REMOVE METAL BEAM GUARD FENCE	LF	386.000		386.000	
	544-6001	GUARDRAIL END TREATMENT (INSTALL)	EA	4.000		4.000	
	544-6003	GUARDRAIL END TREATMENT (REMOVE)	EA	2.000		2.000	
	545-6007	CRASH CUSH ATTEN (INSTL)(L)(N)(TL3)	EA	8.000		8.000	
	644-6068	RELOCATE SM RD SN SUP&AM TY 10BWG	EA	10.000		10.000	
	658-6061	INSTL DEL ASSM (D-SW)SZ 1(BRF)GF2	EA	16.000		16.000	
	658-6071	INSTL DEL ASSM (D-SY)SZ (BRF)CTB (BI)	EA	76.000		76.000	
	3076-6003	D-GR HMA TY-B PG64-22 (EXEMPT)	TON	2,974.000		2,974.000	
	3076-6066	TACK COAT	GAL	1,657.000		1,657.000	
	6001-6002	PORTABLE CHANGEABLE MESSAGE SIGN	EA	2.000		2.000	
	6185-6002	TMA (STATIONARY)	DAY	120.000		120.000	
	18	ENVIRONMENTAL: CONTRACTOR FORCE ACCOUNT WORK (PARTICIPATING)	LS	1.000		1.000	
		SAFETY CONTINGENCY: CONTRACTOR FORCE ACCOUNT WORK (PARTICIPATING)	LS	1.000		1.000	


pw: \\+xdot.projectwiseonline.com:TXDOT3\Documents\09 - WAC\Design Projects\231101044\4 - Design\Plan\2022\General\CONSOLIDATED_SUMMARY.BM: @gnpm
 NODE

SUMMARY OF ROADWAY ITEMS												
LOCATION	112 6001	132 6003	150 6001	164 6007	168 6001	420 6012	427 6002	432 6045	496 6030	506 6038	506 6039	512 6013
	SUBGRADE WIDENING (ORD COMP)	EMBANKMENT (FINAL) (ORD COMP) (TY B)	BLADING	BROADCAST SEED (PERM) (URBAN) (CLAY)	VEGETATIVE WATERING	CL B CONC (MISC)	CONCRETE PAINT FINISH	RIPRAP (MOW STRIP) (4 IN)	REMOVE STR (BOLLARD)	TEMP SEDMT CONT FENCE (INSTALL)	TEMP SEDMT CONT FENCE (REMOVE)	PORT CTB (DES SOURCE) (SGL SLP) (TY 1)
	STA	CY	STA	SY	MG	CY	SF	CY	EA	LF	LF	LF
BEGIN TO STA 10+00	8.8	168	8.8	1184		1	7576					690
STA 10+00 TO STA 20+00	10	242	10	1250		1	8000					1000
STA 20+00 TO STA 30+00	10	242	10	1250		1	8000		17			1000
STA 30+00 TO STA 40+00	10	242	10	1250		1	8000					1000
STA 40+00 TO STA 50+00	8.4	188	8.4	1131		1	7240					720
STA 50+00 TO STA 60+00	9	203	9	1128		1	7216					810
STA 60+00 TO STA 70+00	10	242	10	1250		1	8000					1000
STA 70+00 TO STA 80+00	6.7	138	6.7	832		1	6600	16				530
STA 80+00 TO STA 90+00								44				
PROJECT TOTALS	72.9	1665	72.9	9275	79.5	8	60632	60	17	100	100	6750

SUMMARY OF ROADWAY ITEMS													
LOCATION	540 6002	540 6006	540 6010	540 6023	542 6001	544 6001	544 6003	545 6007	644 6068	658 6061	658 6071	3076 6003	3076 6066
	MTL W-BEAM GD FEN (STEEL POST)	MTL BEAM GD FEN TRANS (THRIE-BEAM)	MTL W-BEAM GD FEN ADJUSTMENT	MTL BEAM GD FEN TRANS (THRIE BEAM) 28"	REMOVE METAL BEAM GUARD FENCE	GUARDRAIL END TREATMENT (INSTALL)	GUARDRAIL END TREATMENT (REMOVE)	CRASH CUSH ATTEN (INSTL) (L) (N) (TL3)	RELOCATE SM RD SN SUP&AM TY 10BWG	INSTL DEL ASSM (D-SW) SZ 1 (BRF) GF2	INSTL DEL ASSM (D-SY) SZ (BRF) CTB (BI)	D-GR HMA TY-B PG64-22 (EXEMPT)	TACK COAT
	LF	EA	LF	EA	LF	EA	EA	EA	EA	EA	EA	TON	GAL
BEGIN TO STA 10+00								3			9	319	162
STA 10+00 TO STA 20+00											10	428	233
STA 20+00 TO STA 30+00											10	428	233
STA 30+00 TO STA 40+00											10	428	233
STA 40+00 TO STA 50+00								2			10	332	196
STA 50+00 TO STA 60+00								1			10	368	210
STA 60+00 TO STA 70+00								1			10	428	233
STA 70+00 TO STA 80+00	200					2		1		4	7	243	157
STA 80+00 TO STA 90+00	650	2	100	2	386	2	2			12			
PROJECT TOTALS	850	2	100	2	386	4	2	8	10	16	76	2974	1657

• TO BE USED AS DIRECTED

SUMMARY OF TMA AND PCMS		
LOCATION	6185 6002	6001 6002
	TMA (STATIONARY)	PORTABLE CHANGEABLE MESSAGE SIGN
	DAY	EA
CSJ: 2311-01-044	120	2
PROJECT TOTALS	120	2



CONSOLIDATED SUMMARIES

CHANGE ORDER	FED. RD. DIV. NO.	CONT	SECT	JOB	HIGHWAY
	6	2311	01	044	FM 3051
	STATE	DIST	COUNTY		SHEET NO.
	TEXAS	WAC	McLENNAN		6

DISCLAIMER:
 The use of this standard is governed by the "Texas Engineering Practice Act". No warranty of any kind is made by TxDOT for any purpose whatsoever.
 TxDOT assumes no responsibility for the conversion of this standard to other formats or for incorrect results or damages resulting from its use.

LOC NO.	TCP PHASE	PLAN SHEET NUMBER	LOCATION	STA	TEST LEVEL	DIRECTION OF TRAFFIC (UNI/BI)	FOUNDATION PAD		BACKUP SUPPORT			AVAILABLE SITE LENGTH	CRASH CUSHION											
							PROPOSED MATERIAL	PROPOSED THICKNESS	DESCRIPTION	WIDTH	HEIGHT		INSTALL	REMOVE	MOVE / RESET		L	L	R	R	S	S		
															MOVE/RESET	FROM LOC. #	N	W	N	W	N	W		
1	NA	1	RUN 1	STA 0+28	TL-3	BI	ASPH	10"	PCTB	24"	42"	27' 10"	1					1						
1	NA	1	RUN 1	STA 5+08	TL-3	BI	ASPH	10"	PCTB	24"	42"	27' 10"	1					1						
2	NA	1	RUN 2	STA 8+25	TL-3	BI	ASPH	10"	PCTB	24"	42"	27' 10"	1					1						
2	NA	3	RUN 2	STA 40+99	TL-3	BI	ASPH	10"	PCTB	24"	42"	27' 10"	1					1						
3	NA	3	RUN 3	STA 42+97	TL-3	BI	ASPH	10"	PCTB	24"	42"	27' 10"	1					1						
3	NA	3	RUN 3	STA 58+06	TL-3	BI	ASPH	10"	PCTB	24"	42"	27' 10"	1					1						
4	NA	4	RUN 4	STA 60+20	TL-3	BI	ASPH	10"	PCTB	24"	42"	27' 10"	1					1						
4	NA	4	RUN 4	STA 75+39	TL-3	BI	ASPH	10"	PCTB	24"	42"	27' 10"	1					1						
												TOTALS	8											


LEGEND:
 L=LOW MAINTENANCE
 R=REUSABLE
 S=SACRIFICIAL
 N=NARROW
 W=WIDE

FOR DEFINITIONS SEE THE "CRASH CUSHION CATEGORIZATION CHART.PDF" AT THE DESIGN DIVISION (ROADWAY STANDARDS) WEBSITE. USE QUICK LINKS TO ACCESS ATTENUATORS / CRASH CUSHIONS SECTION.
<http://www.dot.state.tx.us/insdot/orgchart/cmd/cserve/standard/rdwylse.htm>

CRASH CUSHION SUMMARY SHEET

FILE: CCSS.dgn	DN: TxDOT	CK:	CK:
© TxDOT	CONT	SECT	JOB
REVISIONS	2311	01	044
	DIST	COUNTY	
	WAC	MCLENNAN	
	FEDERAL AID PROJECT	SHEET NO.	
		7	

VICINITY MAP

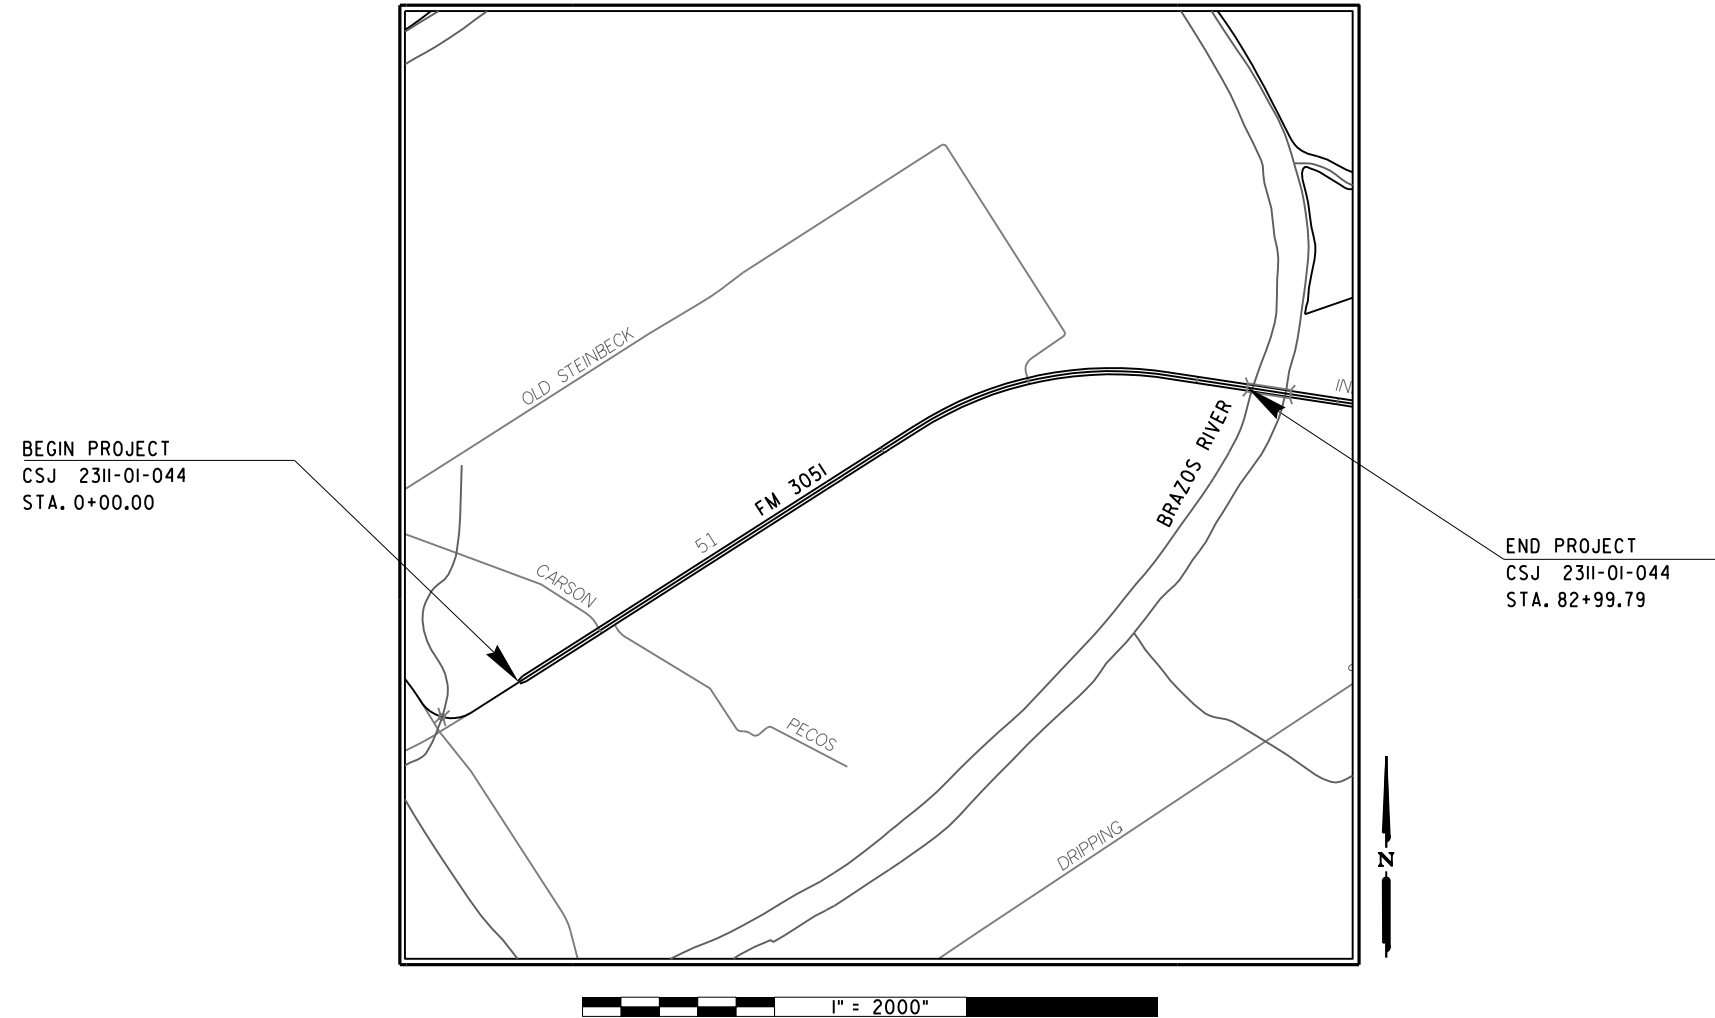

GENERAL

- A. INSTALL ALL SIGNS, BARRICADES AND TRAFFIC CONTROL DEVICES AS SHOWN AND IN ACCORDANCE WITH THE STANDARD BC SHEETS AND AS DIRECTED.
- B. ADDITIONAL SIGNS, BARRICADES OR TRAFFIC CONTROL DEVICES OTHER THAN THOSE SPECIFIED MAY BE REQUIRED FOR THE SAFE MOVEMENT OF TRAFFIC THROUGH THE PROJECT. PAYMENT FOR ALL SUCH SIGNS, BARRICADES OR TRAFFIC CONTROL DEVICES WILL BE CONSIDERED DISTRICT APPROVED TO THE ITEM "BARRICADES, SIGNS AND TRAFFIC HANDLING".
- C. WORK SITES SHOULD BE CAREFULLY MONITORED TO ENSURE THAT TRAFFIC CONTROL MEASURES ARE OPERATING EFFECTIVELY AND THAT ALL DEVICES USED ARE CLEARLY VISIBLE, CLEAN AND IN GOOD REPAIR.
- D. THE CONTRACTOR WILL PROVIDE SAFE ACCESS TO AND FROM ALL PRIVATE PROPERTY AT ALL TIMES AND IN ALL WEATHER CONDITIONS.
- E. THE CONTRACTOR WILL BE REQUIRED TO SUBMIT A DETAILED SCHEDULE OF WORK PRIOR TO THE BEGINNING OF CONSTRUCTION WHICH GENERALLY CONFORMS TO THE SEQUENCE SHOWN ON THE TCP SEQUENCE OF OPERATION BELOW.
- F. COMPLETE ALL WORK ON PROJECT AS SHOWN ON THE VARIOUS PLAN SHEETS AND IN COMPLIANCE WITH THE GENERAL NOTES OF THIS CONTRACT.
- G. ANY REQUEST TO ALTER THE SEQUENCE OF OPERATION OR TRAFFIC CONTROL PLAN WILL BE SUBMITTED TO THE ENGINEER FOR WRITTEN APPROVAL.


NOTES:

1. ALL TRAFFIC CONTROL DEVICES WILL CONFORM WITH THE TEXAS "MANUAL ON UNIFORM TRAFFIC CONTROL DEVICES FOR STREETS AND HIGHWAYS" (TMUTCD), AND WILL BE MAINTAINED AS DIRECTED. ADDITIONAL GUIDELINES FOR TRAFFIC CONTROL DEVICES MAY BE FOUND IN THE TMUTCD.
2. FOR CHANNELING DEVICE PLACEMENT AND SPACING FOR ALL PHASES, REFER TO THE TCP STANDARDS.

SEQUENCE OF CONSTRUCTION

THE CONTRACTOR WILL BE REQUIRED TO SUBMIT A DETAILED SCHEDULE OF WORK TO THE AREA ENGINEER PRIOR TO THE BEGINNING OF CONSTRUCTION, WHICH GENERALLY CONFORMS TO THE FOLLOWING SEQUENCE:

1. PROVIDE AND INSTALL ALL SIGNS, BARRICADES, AND TRAFFIC CONTROL DEVICES IN ACCORDANCE WITH THE TRAFFIC CONTROL STANDARDS.
2. SUBGRADE WIDENING 7'
3. INSTALL 3 LIFTS OF HMA BARRIER BEDDING AND REGRADE MEDIAN FROM THE EDGE OF BEDDING TO THE CENTERLINE OF MEDIAN.
4. INSTALL CONCRETE BARRIER, GUARD FENCE AND SEEDING.
5. FINAL CLEANUP.
6. UPON APPROVAL FROM THE ENGINEER REMOVE WORKZONE BARRICADES.

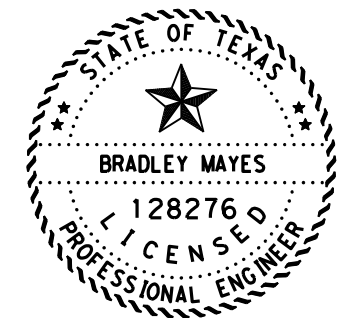

Bradley Mayes 10/26/2022
SIGNATURE OF REGISTRANT & DATE



SEQUENCE OF CONSTRUCTION

SHEET 1 OF 1

CHANGE ORDER	FED. RD. DIV. NO.	CONT	SECT	JOB	HIGHWAY
	6	2311	01	044	FM 3051
	STATE	DIST	COUNTY		SHEET NO.
	TEXAS	WAC	MCLENNAN		8

pw: \\ttdot.com\project\wseon\lme.com\TXDOT3\Documents\09 - WAC\Design\Project\231101044\4 - Design\Plan\Sequence of Construction\1023.dgn
 NODE

DATE: 10/5/2022 11:57:49 AM
 FILE: \\txdot.projectwiseonline.com:TXDOT3\Documents\09 - WAC\Design Projects\23101044 - Design\Plan Set\23101044.dgn
 DISCLAIMER: The use of this standard is governed by the "Texas Engineering Practice Act". No warranty of any kind is made by TxDOT or any purpose whatsoever. TxDOT assumes no responsibility for the conversion of this standard to any other format or for the use of this standard in any project.

BARRICADE AND CONSTRUCTION (BC) STANDARD SHEETS GENERAL NOTES:

- The Barricade and Construction Standard Sheets (BC sheets) are intended to show typical examples for placement of temporary traffic control devices, construction pavement markings, and typical work zone signs. The information contained in these sheets meet or exceed the requirements shown in the "Texas Manual on Uniform Traffic Control Devices" (TMUTCD).
- The development and design of the Traffic Control Plan (TCP) is the responsibility of the Engineer.
- The Contractor may propose changes to the TCP that are signed and sealed by a licensed professional engineer for approval. The Engineer may develop, sign and seal Contractor proposed changes.
- The Contractor is responsible for installing and maintaining the traffic control devices as shown in the plans. The Contractor may not move or change the approximate location of any device without the approval of the Engineer.
- Geometric design of lane shifts and detours should, when possible, meet the applicable design criteria contained in manuals such as the American Association of State Highway and Transportation Officials (AASHTO), "A Policy on Geometric Design of Highways and Streets," the TxDOT "Roadway Design Manual" or engineering judgment.
- When projects abut, the Engineer(s) may omit the END ROAD WORK, TRAFFIC FINES DOUBLE, and other advance warning signs if the signing would be redundant and the work areas appear continuous to the motorists. If the adjacent project is completed first, the Contractor shall erect the necessary warning signs as shown on these sheets, the TCP sheets or as directed by the Engineer. The BEGIN ROAD WORK NEXT X MILES sign shall be revised to show appropriate work zone distance.
- The Engineer may require duplicate warning signs on the median side of divided highways where median width will permit and traffic volumes justify the signing.
- All signs shall be constructed in accordance with the details found in the "Standard Highway Sign Designs for Texas," latest edition. Sign details not shown in this manual shall be shown in the plans or the Engineer shall provide a detail to the Contractor before the sign is manufactured.
- The temporary traffic control devices shown in the illustrations of the BC sheets are examples. As necessary, the Engineer will determine the most appropriate traffic control devices to be used.
- Where highway construction or maintenance work is being undertaken, other than mobile operations as defined by the Texas Manual on Uniform Traffic Control Devices, CSJ limit signs are required. CSJ limit signs are shown on BC(2). The OBEY WARNING SIGNS STATE LAW sign, STAY ALERT TALK OR TEXT LATER and the WORK ZONE TRAFFIC FINES DOUBLE sign with plaque shall be erected in advance of the CSJ limits. The BEGIN ROAD WORK NEXT X MILES, CONTRACTOR and END ROAD WORK signs shall be erected at or near the CSJ limits. For mobile operations, CSJ limit signs are not required.
- Traffic control devices should be in place only while work is actually in progress or a definite need exists.
- The Engineer has the final decision on the location of all traffic control devices.
- Inactive equipment and work vehicles, including workers' private vehicles must be parked away from travel lanes. They should be as close to the right-of-way line as possible, or located behind a barrier or guardrail, or as approved by the Engineer.

WORKER SAFETY NOTES:


- Workers on foot who are exposed to traffic or to construction equipment within the right-of-way shall wear high-visibility safety apparel meeting the requirements of ISEA "American National Standard for High-Visibility Apparel," or equivalent revisions, and labeled as ANSI 107-2004 standard performance for Class 2 or 3 risk exposure. Class 3 garments should be considered for high traffic volume work areas or night time work.
- Except in emergency situations, flagger stations shall be illuminated when flagging is used at night.

COMPLIANT WORKZONE TRAFFIC CONTROL DEVICES

- Only pre-qualified products shall be used. The "Compliant Work Zone Traffic Control Devices List" (CWZTCD) describes pre-qualified products and their sources.
- Work zone traffic control devices shall be compliant with the Manual for Assessing safety Hardware (MASH).


THE DOCUMENTS BELOW CAN BE FOUND ON-LINE AT http://www.txdot.gov
COMPLIANT WORK ZONE TRAFFIC CONTROL DEVICES LIST (CWZTCD)
DEPARTMENTAL MATERIAL SPECIFICATIONS (DMS)
MATERIAL PRODUCER LIST (MPL)
ROADWAY DESIGN MANUAL - SEE "MANUALS (ONLINE MANUALS) "
STANDARD HIGHWAY SIGN DESIGNS FOR TEXAS (SHSD)
TEXAS MANUAL ON UNIFORM TRAFFIC CONTROL DEVICES (TMUTCD)
TRAFFIC ENGINEERING STANDARD SHEETS

SHEET 1 OF 12

 Texas Department of Transportation		Traffic Safety Division Standard	
BARRICADE AND CONSTRUCTION GENERAL NOTES AND REQUIREMENTS			
BC (1) -21			
FILE:	bc-21.dgn	DN:	TxDOT
© TxDOT	November 2002	CK:	TxDOT
		DW:	TxDOT
		CK:	TxDOT
REVISIONS	CONT	SECT	JOB
4-03 7-13	2311	01	044
9-07 8-14			FM 3051
5-10 5-21			
	DIST	COUNTY	SHEET NO.
	WAC	MCLENNAN	9


DISCLAIMER: The use of this standard is governed by the "Texas Engineering Practice Act". No warranty of any kind is made by TxDOT for any purpose whatsoever. TxDOT assumes no responsibility for the conversion of units or the use of this standard in any project.

TYPICAL LOCATION OF CROSSROAD SIGNS

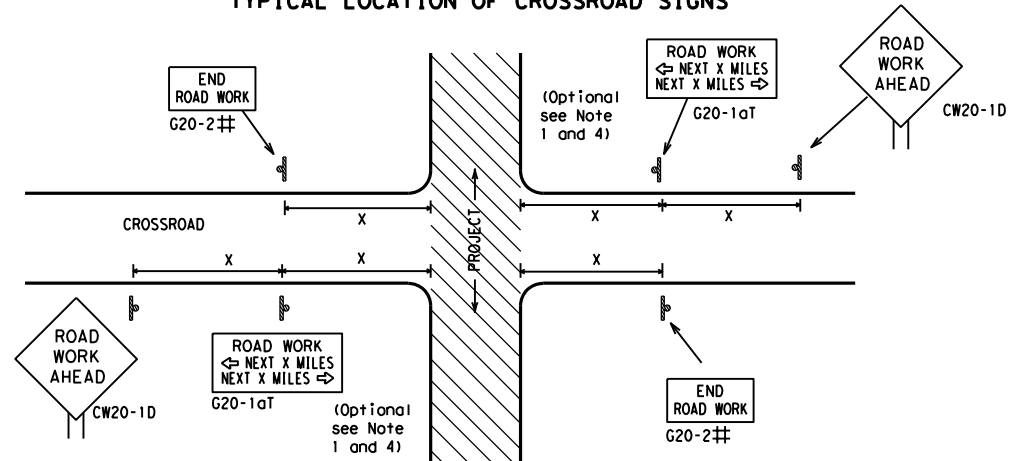

- ## May be mounted on back of "ROAD WORK AHEAD" (CW20-1D) sign with approval of Engineer. (See note 2 below)
- The typical minimum signing on a crossroad approach should be a "ROAD WORK AHEAD" (CW20-1D) sign and a (G20-2) "END ROAD WORK" sign, unless noted otherwise in plans.
 - The Engineer may use the reduced size 36" x 36" ROAD WORK AHEAD (CW20-1D) sign mounted back to back with the reduced size 36" x 18" "END ROAD WORK" (G20-2) sign on low volume crossroads (see Note 4 under "Typical Construction Warning Sign Size and Spacing"). See the "Standard Highway Sign Designs for Texas" manual for sign details. The Engineer may omit the advance warning signs on low volume crossroads. The Engineer will determine whether a road is low volume as per TMUTCD Part 5. This information shall be shown in the plans.
 - Based on existing field conditions, the Engineer/Inspector may require additional signs such as FLAGGER AHEAD, LOOSE GRAVEL, or other appropriate signs. When additional signs are required, these signs will be considered part of the minimum requirements. The Engineer/Inspector will determine the proper location and spacing of any sign not shown on the BC sheets, Traffic Control Plan sheets or the Work Zone Standard Sheets.
 - The "ROAD WORK NEXT X MILES" (G20-1aT) sign shall be required at high volume crossroads to advise motorists of the length of construction in either direction from the intersection. The Engineer will determine whether a roadway is considered high volume.
 - Additional traffic control devices may be shown elsewhere in the plans for higher volume crossroads.
 - When work occurs in the intersection area, appropriate traffic control devices, as shown elsewhere in the plans or as determined by the Engineer/Inspector, shall be in place.

T-INTERSECTION

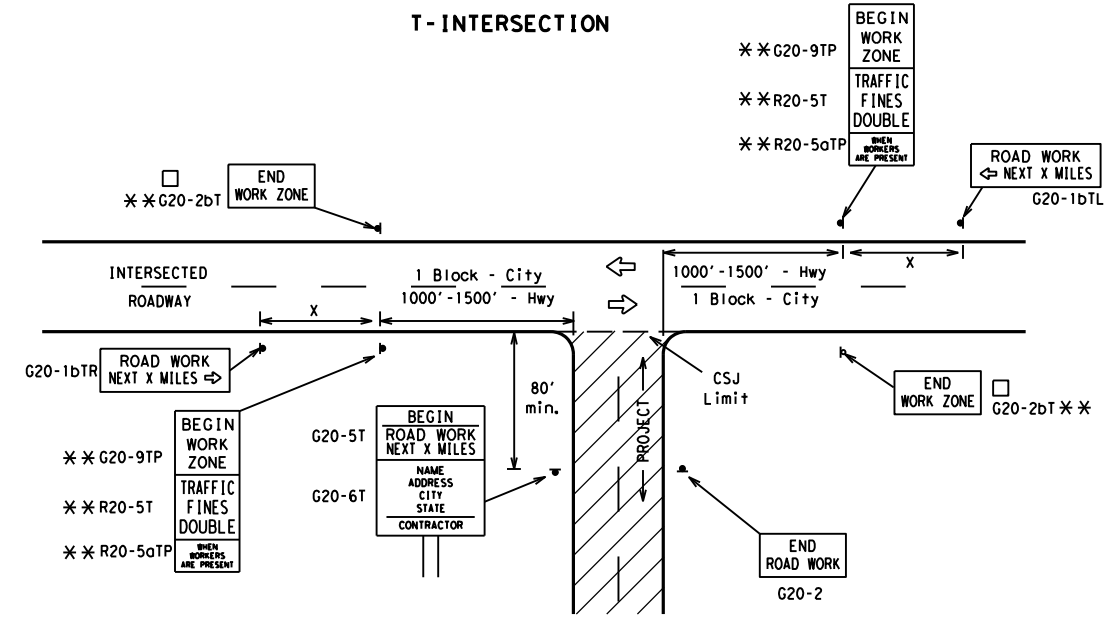

CSJ LIMITS AT T-INTERSECTION

- The Engineer will determine the types and location of any additional traffic control devices, such as a flagger and accompanying signs, or other signs, that should be used when work is being performed at or near an intersection.
- If construction closes the road at a T-intersection, the Contractor shall place the "CONTRACTOR NAME" (G20-6T) sign behind the Type 3 Barricades for the road closure (see BC(10) also). The "ROAD WORK NEXT X MILES" left arrow (G20-1bTL) and "ROAD WORK NEXT X MILES" right arrow (G20-1bTR) signs shall be replaced by the detour signing called for in the plans.

TYPICAL CONSTRUCTION WARNING SIGN SIZE AND SPACING^{1,5,6}

Sign Number or Series	SIZE		SPACING	
	Conventional Road	Expressway/Freeway	Posted Speed MPH	Sign Δ Spacing "x" Feet (Apprx.)
CW20 ⁴	48" x 48"	48" x 48"	30	120
CW21			35	160
CW22			40	240
CW23			45	320
CW25			50	400
CW1, CW2, CW7, CW8, CW9, CW11, CW14	36" x 36"	48" x 48"	55	500 ²
CW3, CW4, CW5, CW6, CW8-3, CW10, CW12	48" x 48"	48" x 48"	60	600 ²
			65	700 ²
			70	800 ²
			75	900 ²
			80	1000 ²
			*	* ³


* For typical sign spacings on divided highways, expressways and freeways, see Part 6 of the "Texas Manual on Uniform Traffic Control Devices" (TMUTCD) typical application diagrams or TCP Standard Sheets.

Δ Minimum distance from work area to first Advance Warning sign nearest the work area and/or distance between each additional sign.

GENERAL NOTES


- Special or larger size signs may be used as necessary.
- Distance between signs should be increased as required to have 1500 feet advance warning.
- Distance between signs should be increased as required to have 1/2 mile or more advance warning.
- 36" x 36" "ROAD WORK AHEAD" (CW20-1D) signs may be used on low volume crossroads at the discretion of the Engineer as per TMUTCD Part 5. See Note 2 under "Typical Location of Crossroad Signs".
- Only diamond shaped warning sign sizes are indicated.
- See sign size listing in "TMUTCD", Sign Appendix or the "Standard Highway Sign Designs for Texas" manual for complete list of available sign design sizes.

WORK AREAS IN MULTIPLE LOCATIONS WITHIN CSJ LIMITS

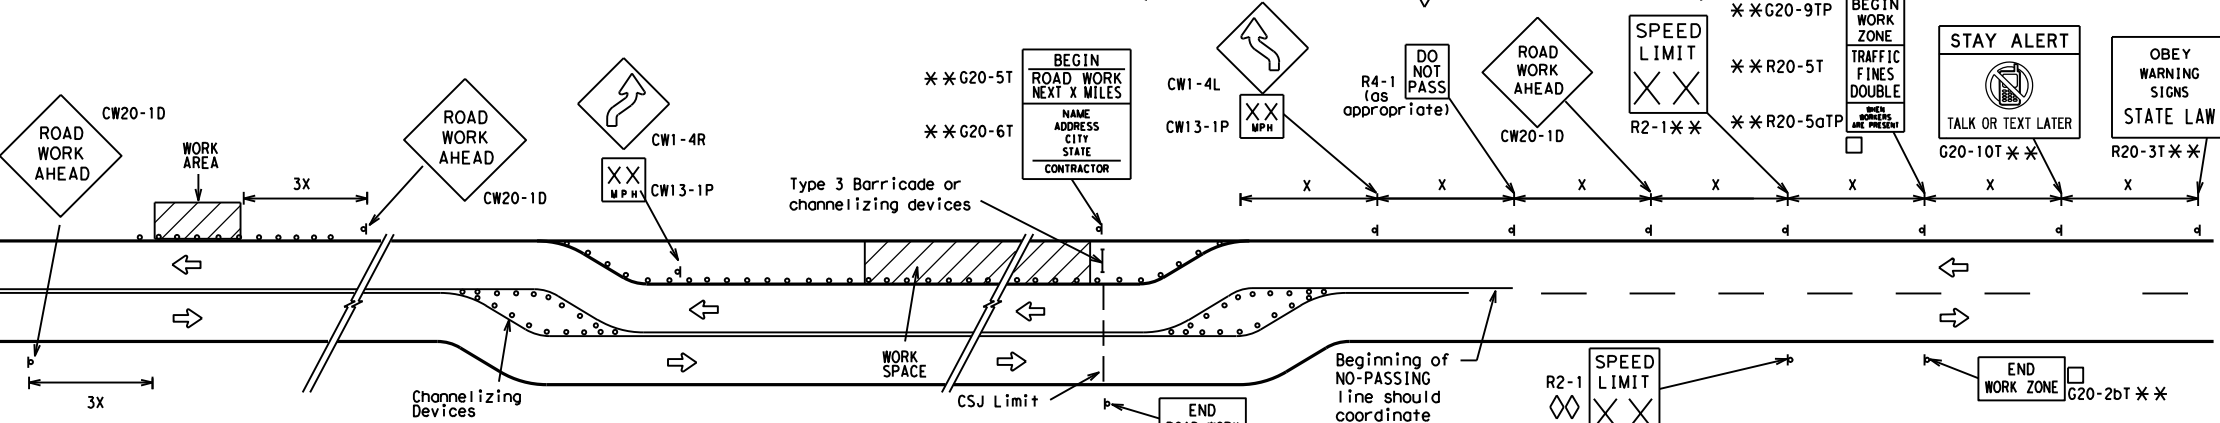


When extended distances occur between minimal work spaces, the Engineer/Inspector should ensure additional "ROAD WORK AHEAD" (CW20-1D) signs are placed in advance of these work areas to remind drivers they are still within the project limits. See the applicable TCP sheets for exact location and spacing of signs and channelizing devices.

SAMPLE LAYOUT OF SIGNING FOR WORK BEGINNING DOWNSTREAM OF THE CSJ LIMITS

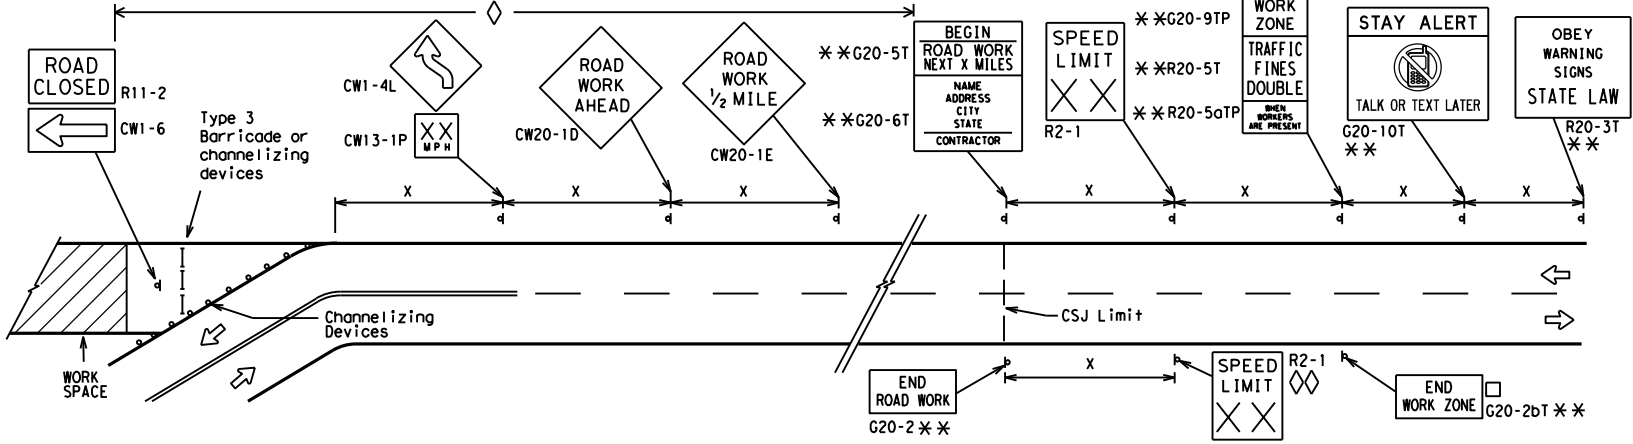

SAMPLE LAYOUT OF SIGNING FOR WORK BEGINNING AT THE CSJ LIMITS

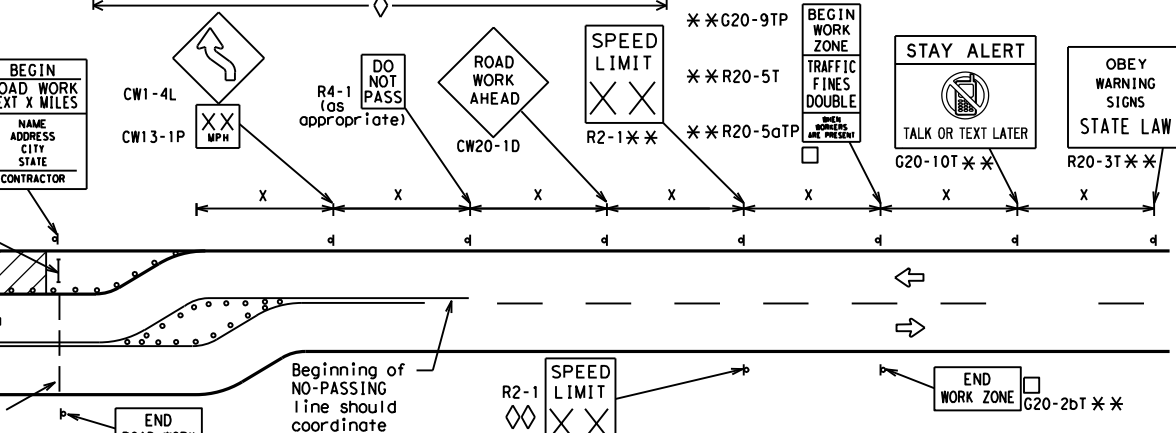

NOTES

- The Contractor shall determine the appropriate distance to be placed on the G20-1 series signs and "BEGIN ROAD WORK NEXT X MILES" (G20-5T) sign for each specific project. This distance shall replace the "x" and shall be rounded to the nearest whole mile with the approval of the Engineer. No decimals shall be used.
- The "BEGIN WORK ZONE" (G20-9TP) and "END WORK ZONE" (G20-2bT) shall be used as shown on the sample layout when advance signs are required outside the CSJ Limits. They inform the motorist of entering or leaving a part of the work zone lying outside the CSJ Limits where traffic fines may double if workers are present.
 - CSJ limit signing is required for highway construction and maintenance work, with the exception of mobile operations.
 - Area for placement of "ROAD WORK AHEAD" (CW20-1D) sign and other signs or devices as called for on the Traffic Control Plan.
 - Contractor will install a regulatory speed limit sign at the end of the work zone.

LEGEND

—	Type 3 Barricade
○ ○ ○	Channelizing Devices
■	Sign
X	See Typical Construction Warning Sign Size and Spacing chart or the TMUTCD for sign spacing requirements.

SHEET 2 OF 12



BARRICADE AND CONSTRUCTION PROJECT LIMIT


BC(2)-21

FILE: bc-21.dgn	DN: TxDOT	CK: TxDOT	DW: TxDOT	CK: TxDOT
© TxDOT November 2002	CONT	SECT	JOB	HIGHWAY
REVISIONS	2311	01	044	FM 3051
9-07 8-14	DIST	COUNTY	SHEET NO.	
7-13 5-21	WAC	MCLENNAN	10	

TYPICAL APPLICATION OF WORK ZONE SPEED LIMIT SIGNS

Work zone speed limits shall be regulatory, established in accordance with the "Procedures for Establishing Speed Zones," and approved by the Texas Transportation Commission, or by City Ordinance when within Incorporated City Limits.

Reduced speeds should only be posted in the vicinity of work activity and not throughout the entire project. Regulatory work zone speed signs (R2-1) shall be removed or covered during periods when they are not needed.

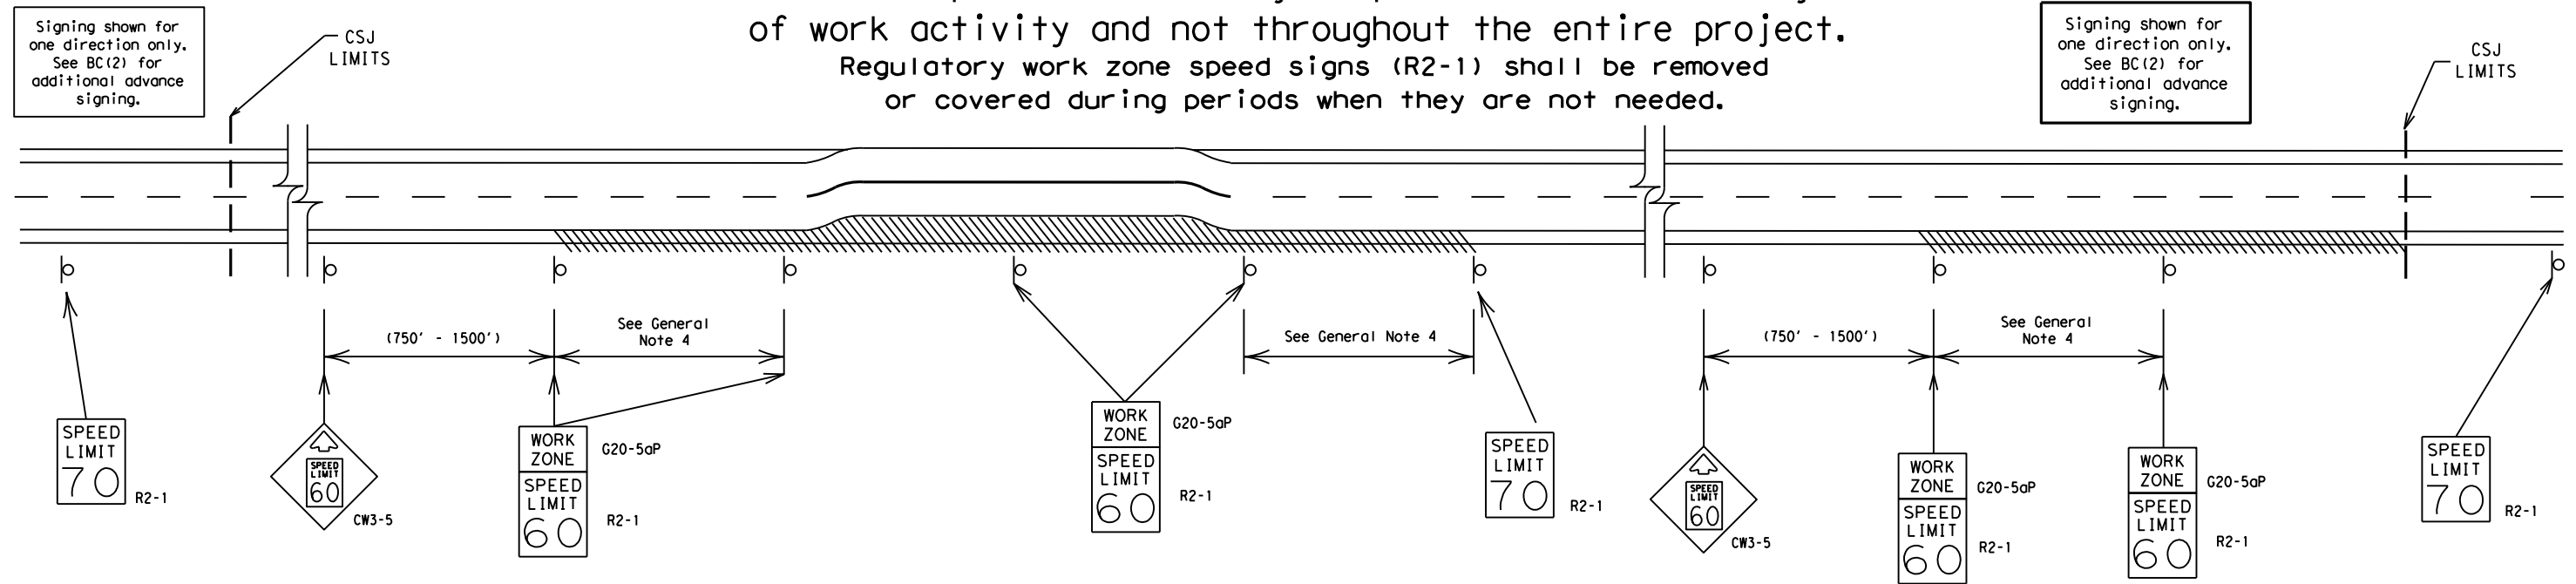

GUIDANCE FOR USE:

LONG/INTERMEDIATE TERM WORK ZONE SPEED LIMITS

This type of work zone speed limit should be included on the design of the traffic control plans when restricted geometrics with a lower design speed are present in the work zone and modification of the geometrics to a higher design speed is not feasible.

Long/Intermediate Term Work Zone Speed Limit signs, when approved as described above, should be posted and visible to the motorist when work activity is present. Work activity may also be defined as a change in the roadway that requires a reduced speed for motorists to safely negotiate the work area, including:

- rough road or damaged pavement surface
- substantial alteration of roadway geometrics (diversions)
- construction detours
- grade
- width
- other conditions readily apparent to the driver

As long as any of these conditions exist, the work zone speed limit signs should remain in place.

SHORT TERM WORK ZONE SPEED LIMITS

This type of work zone speed limit may be included on the design of the traffic control plans when workers or equipment are not behind concrete barrier, when work activity is within 10 feet of the traveled way or actually in the traveled way.

Short Term Work Zone Speed Limit signs should be posted and visible to the motorists only when work activity is present. When work activity is not present, signs shall be removed or covered. (See Removing or Covering on BC(4)).

GENERAL NOTES

- Regulatory work zone speed limits should be used only for sections of construction projects where speed control is of major importance.
- Regulatory work zone speed limit signs shall be placed on supports at a 7 foot minimum mounting height.
- Speed zone signs are illustrated for one direction of travel and are normally posted for each direction of travel.
- Frequency of work zone speed limit signs should be:

40 mph and greater	0.2 to 2 miles
35 mph and less	0.2 to 1 mile
- Regulatory speed limit signs shall have black legend and border on a white reflective background (See "Reflective Sheeting" on BC(4)).
- Fabrication, erection and maintenance of the "ADVANCE SPEED LIMIT" (CW3-5) sign, "WORK ZONE" (G20-5aP) plaque and the "SPEED LIMIT" (R2-1) signs shall not be paid for directly, but shall be considered subsidiary to Item 502.
- Turning signs from view, laying signs over or down will not be allowed, unless as otherwise noted under "REMOVING OR COVERING" on BC(4).
- Techniques that may help reduce traffic speeds include but are not limited to:
 - Law enforcement.
 - Flagger stationed next to sign.
 - Portable changeable message sign (PCMS).
 - Low-power (drone) radar transmitter.
 - Speed monitor trailers or signs.
- Speeds shown on details above are for illustration only. Work Zone Speed Limits should only be posted as approved for each project.
- For more specific guidance concerning the type of work, work zone conditions and factors impacting allowable regulatory construction speed zone reduction see TxDOT form #1204 in the TxDOT e-form system.

DISCLAIMER: The use of this standard is governed by the "Texas Engineering Practice Act". No warranty of any kind is made by TxDOT for any purpose whatsoever. TxDOT assumes no responsibility for the conversion of units or for the accuracy of any data or information contained herein.

DATE: 10/5/2022 11:57:49 AM
FILE: \\txdot.projectwiseonline.com:TXDOT13\Documents\09 - WAC\Design Projects\1010413 - BARRICADE AND CONSTRUCTION WORK ZONE SPEED LIMIT.dgn


SHEET 3 OF 12

		Traffic Safety Division Standard	
<h2>BARRICADE AND CONSTRUCTION WORK ZONE SPEED LIMIT</h2>			
<h3>BC (3) - 21</h3>			
FILE:	bc-21.dgn	DW:	TxDOT
© TxDOT	November 2002	CONT SECT	JOB HIGHWAY
REVISIONS		2311 01	044 FM 3051
9-07 8-14		DIST	COUNTY SHEET NO.
7-13 5-21		WAC	MCLENNAN 11

DISCLAIMER: The use of this standard is governed by the "Texas Engineering Practice Act". No warranty of any kind is made by TxDOT for any purpose whatsoever. TxDOT assumes no responsibility for the conversion of this standard to other formats or for incorrect results or damages resulting from its use.

DATE: 10/5/2022 11:57:50 AM
 FILE: pw:\txdot\project\wiseonline.com:TXDOT3\Documents\09 - WAC\Design Projects\231101044\4 - Design\Plan Set\2 - TCP\TCP_Standards\bc-21.dgn


TYPICAL MINIMUM CLEARANCES FOR LONG TERM AND INTERMEDIATE TERM SIGNS

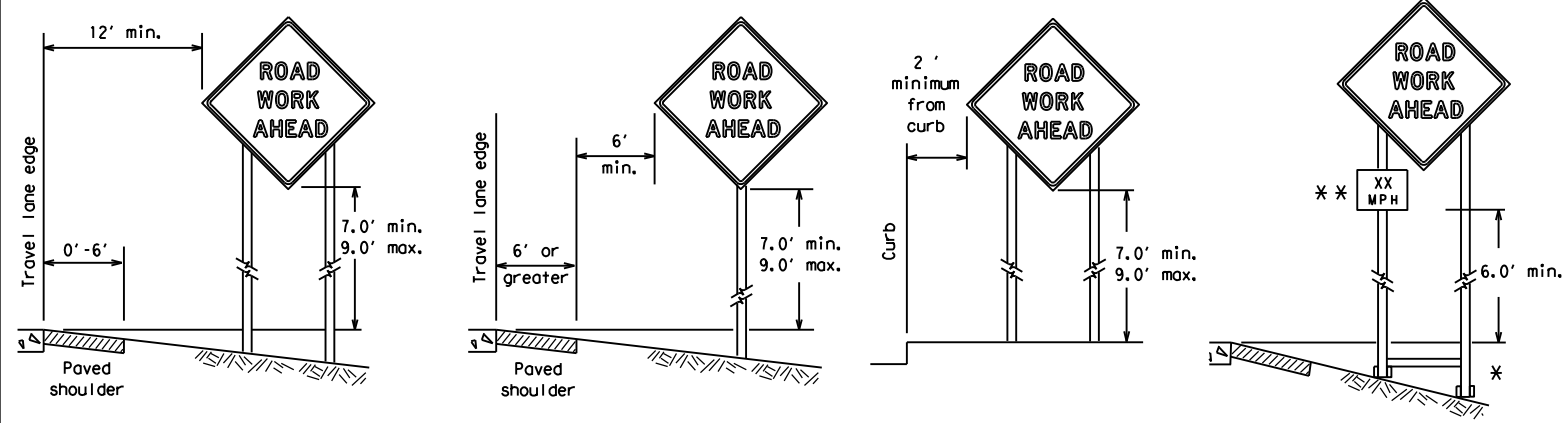

* When placing skid supports on unlevel ground, the leg post lengths must be adjusted so the sign appears straight and plumb. Objects shall NOT be placed under skids as a means of leveling.

** When plaques are placed on dual-leg supports, they should be attached to the upright nearest the travel lane. Supplemental plaques (advisory or distance) should not cover the surface of the parent sign.

ATTACHMENT FOR SIGN SUPPORTS

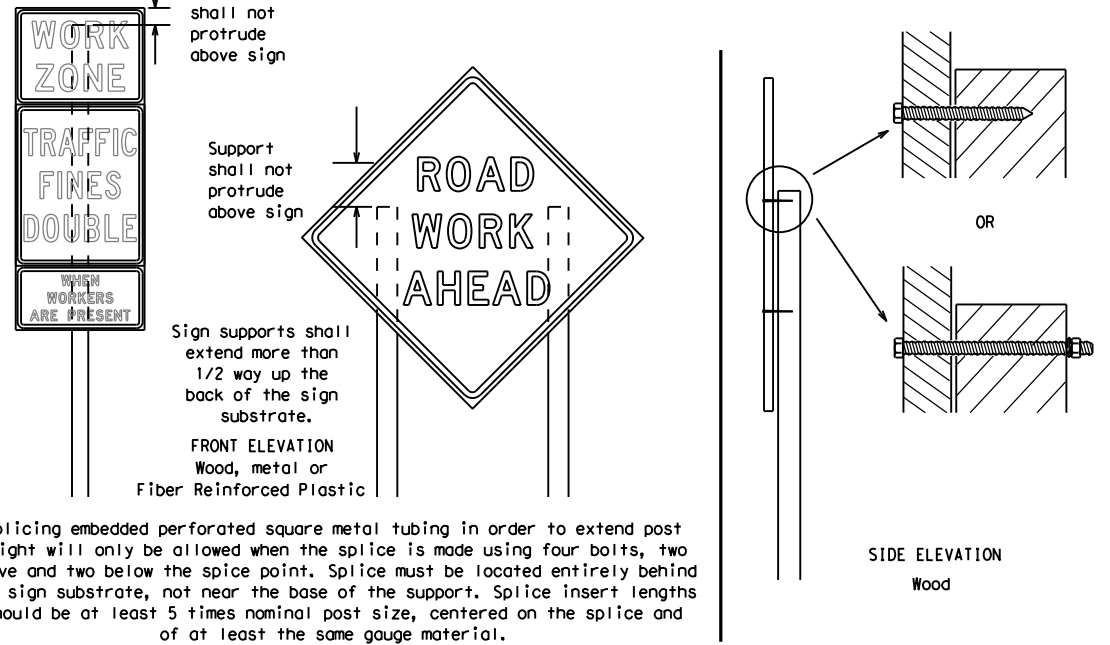

Splicing embedded perforated square metal tubing in order to extend post height will only be allowed when the splice is made using four bolts, two above and two below the splice point. Splice must be located entirely behind the sign substrate, not near the base of the support. Splice insert lengths should be at least 5 times nominal post size, centered on the splice and of at least the same gauge material.

GENERAL NOTES FOR WORK ZONE SIGNS

- Contractor shall install and maintain signs in a straight and plumb condition and/or as directed by the Engineer.
- Wooden sign posts shall be painted white.
- Barricades shall NOT be used as sign supports.
- All signs shall be installed in accordance with the plans or as directed by the Engineer. Signs shall be used to regulate, warn, and guide the traveling public safely through the work zone.
- The Contractor may furnish either the sign design shown in the plans or in the "Standard Highway Sign Designs for Texas" (SHSD). The Engineer/Inspector may require the Contractor to furnish other work zone signs that are shown in the TMUTCD but may have been omitted from the plans. Any variation in the plans shall be documented by written agreement between the Engineer and the Contractor's Responsible Person. All changes must be documented in writing before being implemented. This can include documenting the changes in the Inspector's TxDOT diary and having both the Inspector and Contractor initial and date the agreed upon changes.
- The Contractor shall furnish sign supports listed in the "Compliant Work Zone Traffic Control Device List" (CWZTCD) for small roadside signs. Supports for temporary large roadside signs shall meet the requirements detailed on the Temporary Large Roadside Signs (TLRS) standard sheets. The Contractor shall install the sign support in accordance with the manufacturer's recommendations. If there is a question regarding installation procedures, the Contractor shall furnish the Engineer a copy of the manufacturer's installation recommendations so the Engineer can verify the correct procedures are being followed.
- The Contractor is responsible for installing signs on approved supports and replacing signs with damaged or cracked substrates and/or damaged or marred reflective sheeting as directed by the Engineer/Inspector.
- Identification markings may be shown only on the back of the sign substrate. The maximum height of letters and/or company logos used for identification shall be 1 inch.
- The Contractor shall replace damaged wood posts. New or damaged wood sign posts shall not be spliced.

DURATION OF WORK (as defined by the "Texas Manual on Uniform Traffic Control Devices" Part 6)

- The types of sign supports, sign mounting height, the size of signs, and the type of sign substrates can vary based on the type of work being performed. The Engineer is responsible for selecting the appropriate size sign for the type of work being performed. The Contractor is responsible for ensuring the sign support, sign mounting height and substrate meets manufacturer's recommendations in regard to crashworthiness and duration of work requirements.
 - Long-term stationary - work that occupies a location more than 3 days.
 - Intermediate-term stationary - work that occupies a location more than one daylight period up to 3 days, or nighttime work lasting more than one hour.
 - Short-term stationary - daytime work that occupies a location for more than 1 hour in a single daylight period.
 - Short, duration - work that occupies a location up to 1 hour.
 - Mobile - work that moves continuously or intermittently (stopping for up to approximately 15 minutes.)

SIGN MOUNTING HEIGHT

- The bottom of Long-term/Intermediate-term signs shall be at least 7 feet, but not more than 9 feet, above the paved surface, except as shown for supplemental plaques mounted below other signs.
- The bottom of Short-term/Short Duration signs shall be a minimum of 1 foot above the pavement surface but no more than 2 feet above the ground.
- Long-term/Intermediate-term Signs may be used in lieu of Short-term/Short Duration signing.
- Short-term/Short Duration signs shall be used only during daylight and shall be removed at the end of the workday or raised to appropriate Long-term/Intermediate sign height.
- Regulatory signs shall be mounted at least 7 feet, but not more than 9 feet, above the paved surface regardless of work duration.

SIZE OF SIGNS

- The Contractor shall furnish the sign sizes shown on BC (2) unless otherwise shown in the plans or as directed by the Engineer.

SIGN SUBSTRATES

- The Contractor shall ensure the sign substrate is installed in accordance with the manufacturer's recommendations for the type of sign support that is being used. The CWZTCD lists each substrate that can be used on the different types and models of sign supports.
- "Mesh" type materials are NOT an approved sign substrate, regardless of the tightness of the weave.
- All wooden individual sign panels fabricated from 2 or more pieces shall have one or more plywood cleat, 1/2" thick by 6" wide, fastened to the back of the sign and extending fully across the sign. The cleat shall be attached to the back of the sign using wood screws that do not penetrate the face of the sign panel. The screws shall be placed on both sides of the splice and spaced at 6" centers. The Engineer may approve other methods of splicing the sign face.

REFLECTIVE SHEETING

- All signs shall be retroreflective and constructed of sheeting meeting the color and retro-reflectivity requirements of DMS-8300 for rigid signs or DMS-8310 for roll-up signs. The web address for DMS specifications is shown on BC(1).
- White sheeting, meeting the requirements of DMS-8300 Type A, shall be used for signs with a white background.
- Orange sheeting, meeting the requirements of DMS-8300 Type B_{FL} or Type C_{FL}, shall be used for rigid signs with orange backgrounds.

SIGN LETTERS

- All sign letters and numbers shall be clear, and open rounded type uppercase alphabet letters as approved by the Federal Highway Administration (FHWA) and as published in the "Standard Highway Sign Design for Texas" manual. Signs, letters and numbers shall be of first class workmanship in accordance with Department Standards and Specifications.

REMOVING OR COVERING

- When sign messages may be confusing or do not apply, the signs shall be removed or completely covered.
- Long-term stationary or intermediate stationary signs installed on square metal tubing may be turned away from traffic 90 degrees when the sign message is not applicable. This technique may not be used for signs installed in the median of divided highways or near any intersections where the sign may be seen from approaching traffic.
- Signs installed on wooden skids shall not be turned at 90 degree angles to the roadway. These signs should be removed or completely covered when not required.
- When signs are covered, the material used shall be opaque, such as heavy mil black plastic, or other materials which will cover the entire sign face and maintain their opaque properties under automobile headlights at night, without damaging the sign sheeting.
- Burlap shall NOT be used to cover signs.
- Duct tape or other adhesive material shall NOT be affixed to a sign face.
- Signs and anchor stubs shall be removed and holes backfilled upon completion of work.

SIGN SUPPORT WEIGHTS


- Where sign supports require the use of weights to keep from turning over, the use of sandbags with dry, cohesionless sand should be used.
- The sandbags will be tied shut to keep the sand from spilling and to maintain a constant weight.
- Rock, concrete, iron, steel or other solid objects shall not be permitted for use as sign support weights.
- Sandbags should weigh a minimum of 35 lbs and a maximum of 50 lbs.
- Sandbags shall be made of a durable material that tears upon vehicular impact. Rubber (such as tire inner tubes) shall NOT be used.
- Rubber ballasts designed for channelizing devices should not be used for ballast on portable sign supports. Sign supports designed and manufactured with rubber bases may be used when shown on the CWZTCD list.
- Sandbags shall only be placed along or laid over the base supports of the traffic control device and shall not be suspended above ground level or hung with rope, wire, chains or other fasteners. Sandbags shall be placed along the length of the skids to weigh down the sign support.
- Sandbags shall NOT be placed under the skid and shall not be used to level sign supports placed on slopes.

FLAGS ON SIGNS

- Flags may be used to draw attention to warning signs. When used, the flag shall be 16 inches square or larger and shall be orange or fluorescent red-orange in color. Flags shall not be allowed to cover any portion of the sign face.

STOP/SLOW PADDLES

- STOP/SLOW paddles are the primary method to control traffic by flaggers. The STOP/SLOW paddle size should be 24" x 24".
- STOP/SLOW paddles shall be retroreflective when used at night.
- STOP/SLOW paddles may be attached to a staff with a minimum length of 6' to the bottom of the sign.
- Any lights incorporated into the STOP or SLOW paddle faces shall only be as specifically described in Section 6E.03 Hand Signaling Devices in the TMUTCD.

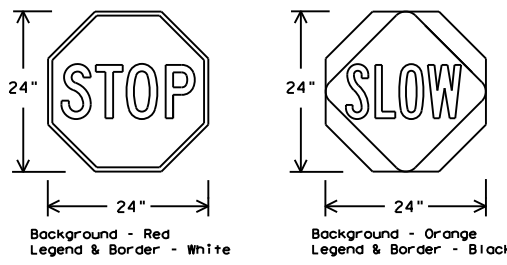

SHEETING REQUIREMENTS (WHEN USED AT NIGHT)		
USAGE	COLOR	SIGN FACE MATERIAL
BACKGROUND	RED	TYPE B OR C SHEETING
BACKGROUND	ORANGE	TYPE B _{FL} OR C _{FL} SHEETING
LEGEND & BORDER	WHITE	TYPE B OR C SHEETING
LEGEND & BORDER	BLACK	ACRYLIC NON-REFLECTIVE FILM

CONTRACTOR REQUIREMENTS FOR MAINTAINING PERMANENT SIGNS WITHIN THE PROJECT LIMITS

- Permanent signs are used to give notice of traffic laws or regulations, call attention to conditions that are potentially hazardous to traffic operations, show route designations, destinations, directions, distances, services, points of interest, and other geographical, recreational, specific service (LOGO), or cultural information. Drivers proceeding through a work zone need the same, if not better route guidance as normally installed on a roadway without construction.
- When permanent regulatory or warning signs conflict with work zone conditions, remove or cover the permanent signs until the permanent sign message matches the roadway condition. For details for covering large guide signs see the TS-CD standard.
- When existing permanent signs are moved and relocated due to construction purposes, they shall be visible to motorists at all times.
- If existing signs are to be relocated on their original supports, they shall be installed on crashworthy bases as shown on the SMD Standard sheets. The signs shall meet the required mounting heights shown on the BC Sheets or the SMD Standards. This work should be paid for under the appropriate pay item for relocating existing signs.
- If permanent signs are to be removed and relocated using temporary supports, the Contractor shall use crashworthy supports as shown on the BC standard sheets, TLRS standard sheets or the CWZTCD list. The signs shall meet the required mounting heights shown on the BC, or the SMD standard sheets during construction. This work should be paid for under the appropriate pay item for relocating existing signs.
- Any sign or traffic control device that is struck or damaged by the Contractor or his/her construction equipment shall be replaced as soon as possible by the Contractor to ensure proper guidance for the motorists. This will be subsidiary to Item 502.






BARRICADE AND CONSTRUCTION TEMPORARY SIGN NOTES

BC (4) - 21

FILE:	bc-21.dgn	DN:	TxDOT	CR:	TxDOT	OW:	TxDOT	CK:	TxDOT
© TxDOT	November 2002	CONT	SECT	JOB	HIGHWAY				
REVISIONS		2311	01	044	FM 3051				
9-07	8-14	DIST	COUNTY		SHEET NO.				
7-13	5-21	WAC	MCLENNAN		12				

DATE: 10/5/2022 11:57:50 AM
 FILE: \\txdot.projectwiseonline.com:TXDOT3\Documents\09 - WAC\Design Projects\231101044\4 - Design Plan Set\2\CP\CP_Standards\BC-21.dgn
 DISCLAIMER: The use of this standard is governed by the "Texas Engineering Practice Act". No warranty of any kind is made by TxDOT for any purpose whatsoever. TxDOT assumes no responsibility for the conversion of this standard to other formats or for incorrect results obtained from its use.

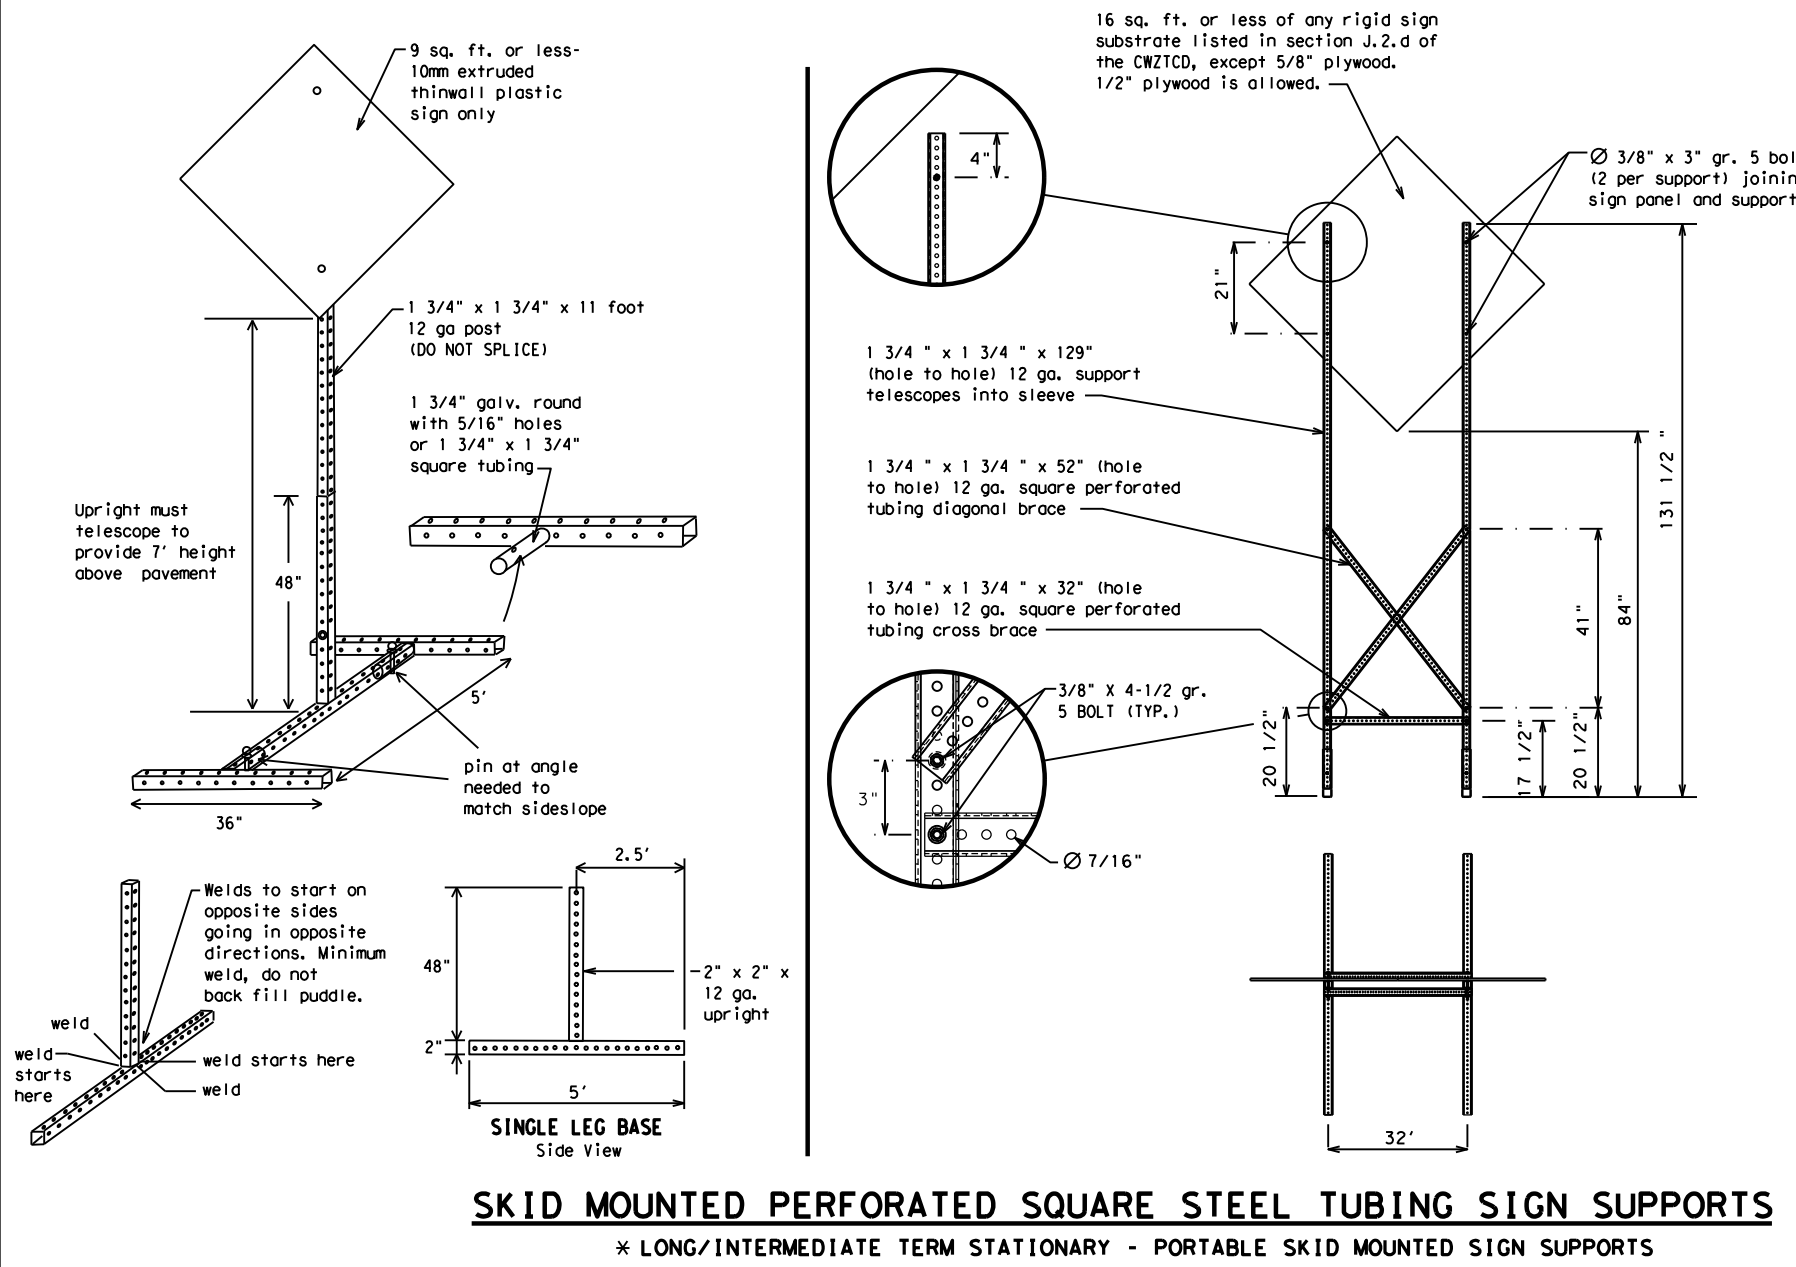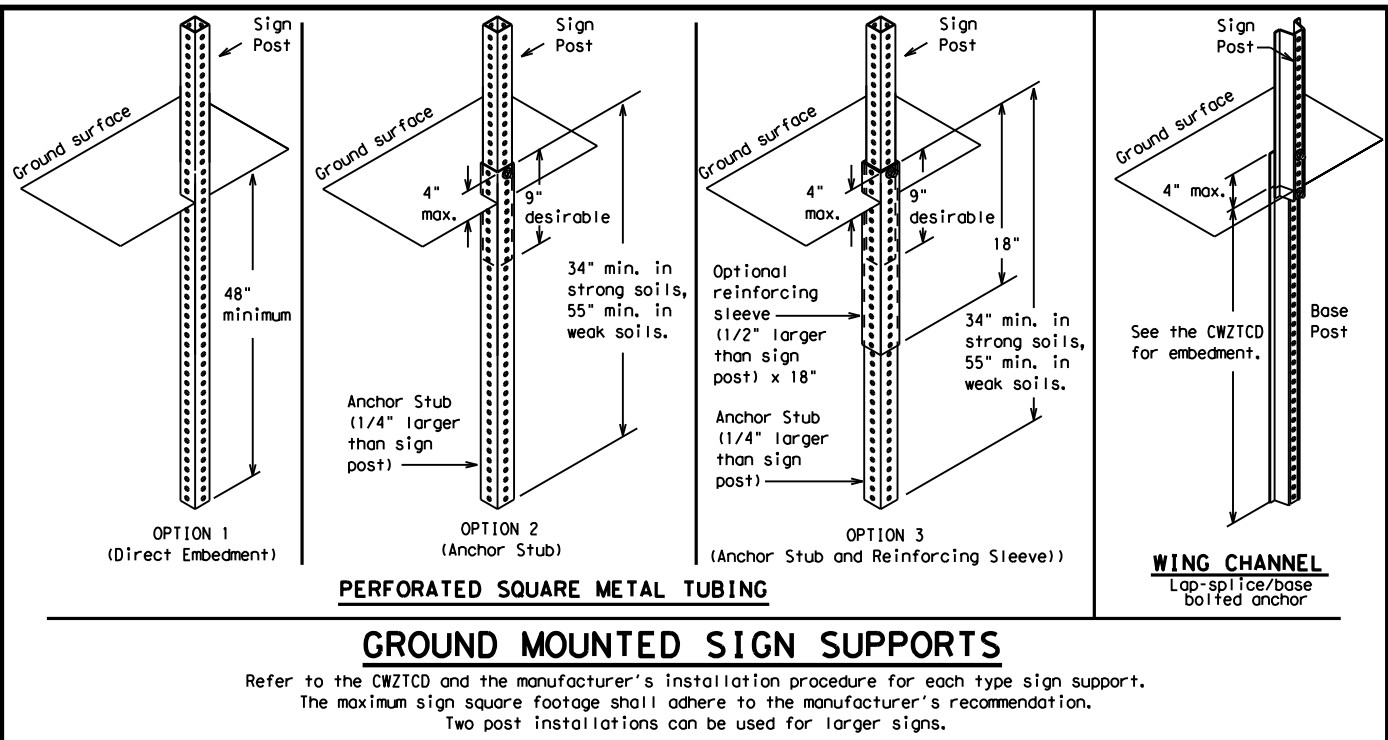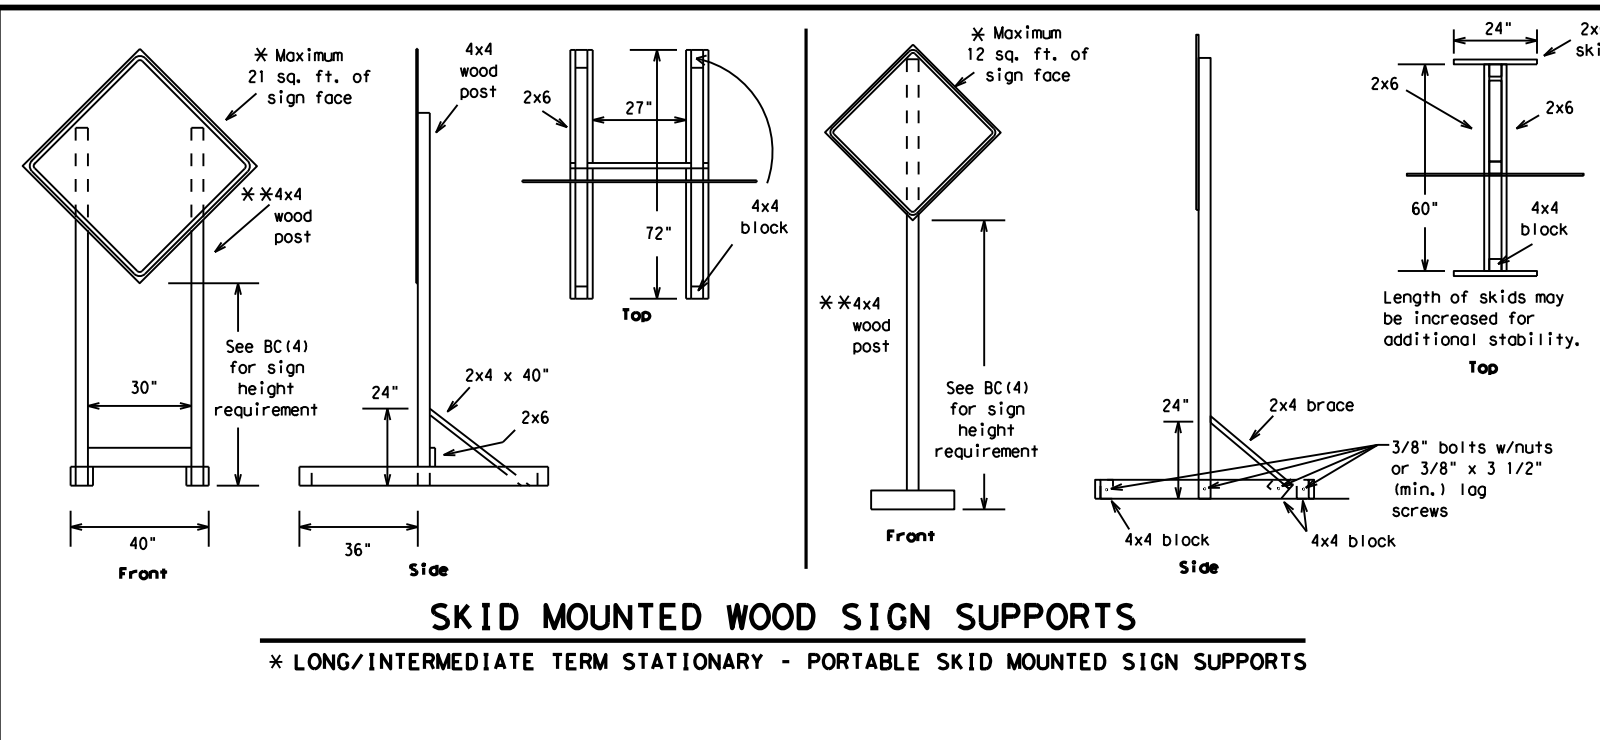

WEDGE ANCHORS
 Both steel and plastic Wedge Anchor Systems as shown on the SMD Standard Sheets may be used as temporary sign supports for signs up to 10 square feet of sign face. They may be set in concrete or in sturdy soils if approved by the Engineer. (See web address for "Traffic Engineering Standard Sheets" on BC(1)).

OTHER DESIGNS
 MORE DETAILS OF APPROVED LONG/INTERMEDIATE AND SHORT TERM SUPPORTS CAN BE FOUND ON THE CWZTCD LIST. SEE BC(1) FOR WEBSITE LOCATION.

GENERAL NOTES

- Nails may be used in the assembly of wooden sign supports, but 3/8" bolts with nuts or 3/8" x 3 1/2" lag screws must be used on every joint for final connection.
- No more than 2 sign posts shall be placed within a 7 ft. circle, except for specific materials noted on the CWZTCD List.
- When project is completed, all sign supports and foundations shall be removed from the project site. This will be considered subsidiary to Item 502.

* See BC(4) for definition of "Work Duration."
 ** Wood sign posts MUST be one piece. Splicing will NOT be allowed. Posts shall be painted white.
 See the CWZTCD for the type of sign substrate that can be used for each approved sign support.

SHEET 5 OF 12

Traffic Safety Division Standard

BARRICADE AND CONSTRUCTION TYPICAL SIGN SUPPORT

BC(5) - 21

FILE: bc-21.dgn	DN: TxDOT	CK: TxDOT	DW: TxDOT	CR: TxDOT
©TxDOT November 2002	CONT	SECT	JOB	HIGHWAY
REVISIONS	2311	01	044	FM 3051
9-07 8-14	DIST	COUNTY	SHEET NO.	
7-13 5-21	WAC	MCLENNAN	13	

WHEN NOT IN USE, REMOVE THE PCMS FROM THE RIGHT-OF-WAY OR PLACE THE PCMS BEHIND BARRIER OR GUARDRAIL WITH SIGN PANEL TURNED PARALLEL TO TRAFFIC

RECOMMENDED PHASES AND FORMATS FOR PCMS MESSAGES DURING ROADWORK ACTIVITIES

(The Engineer may approve other messages not specifically covered here.)

PORTABLE CHANGEABLE MESSAGE SIGNS

- The Engineer/Inspector shall approve all messages used on portable changeable message signs (PCMS).
- Messages on PCMS should contain no more than 8 words (about four to eight characters per word), not including simple words such as "TO," "FOR," "AT," etc.
- Messages should consist of a single phase, or two phases that alternate. Three-phase messages are not allowed. Each phase of the message should convey a single thought, and must be understood by itself.
- Use the word "EXIT" to refer to an exit ramp on a freeway; i.e., "EXIT CLOSED." Do not use the term "RAMP."
- Always use the route or interstate designation (IH, US, SH, FM) along with the number when referring to a roadway.
- When in use, the bottom of a stationary PCMS message panel should be a minimum 7 feet above the roadway, where possible.
- The message term "WEEKEND" should be used only if the work is to start on Saturday morning and end by Sunday evening at midnight. Actual days and hours of work should be displayed on the PCMS if work is to begin on Friday evening and/or continue into Monday morning.
- The Engineer/Inspector may select one of two options which are available for displaying a two-phase message on a PCMS. Each phase may be displayed for either four seconds each or for three seconds each.
- Do not "flash" messages or words included in a message. The message should be steady burn or continuous while displayed.
- Do not present redundant information on a two-phase message; i.e., keeping two lines of the message the same and changing the third line.
- Do not use the word "Danger" in message.
- Do not display the message "LANES SHIFT LEFT" or "LANES SHIFT RIGHT" on a PCMS. Drivers do not understand the message.
- Do not display messages that scroll horizontally or vertically across the face of the sign.
- The following table lists abbreviated words and two-word phrases that are acceptable for use on a PCMS. Both words in a phrase must be displayed together. Words or phrases not on this list should not be abbreviated, unless shown in the TMUTCD.
- PCMS character height should be at least 18 inches for trailer mounted units. They should be visible from at least 1/2 (.5) mile and the text should be legible from at least 600 feet at night and 800 feet in daylight. Truck mounted units must have a character height of 10 inches and must be legible from at least 400 feet.
- Each line of text should be centered on the message board rather than left or right justified.
- If disabled, the PCMS should default to an illegible display that will not alarm motorists and will only be used to alert workers that the PCMS has malfunctioned. A pattern such as a series of horizontal solid bars is appropriate.

Phase 1: Condition Lists

Road/Lane/Ramp Closure List

FREEWAY CLOSED X MILE	FRONTAGE ROAD CLOSED
ROAD CLOSED AT SH XXX	SHOULDER CLOSED XXX FT
ROAD CLSD AT FM XXXX	RIGHT LN CLOSED XXX FT
RIGHT X LANES CLOSED	RIGHT X LANES OPEN
CENTER LANE CLOSED	DAYTIME LANE CLOSURES
NIGHT LANE CLOSURES	I-XX SOUTH EXIT CLOSED
VARIOUS LANES CLOSED	EXIT XXX CLOSED X MILE
EXIT CLOSED	RIGHT LN TO BE CLOSED
MALL DRIVEWAY CLOSED	X LANES CLOSED TUE - FRI
XXXXXXXX BLVD CLOSED	

Other Condition List

ROADWORK XXX FT	ROAD REPAIRS XXXX FT
FLAGGER XXXX FT	LANE NARROWS XXXX FT
RIGHT LN NARROWS XXXX FT	TWO-WAY TRAFFIC XX MILE
MERGING TRAFFIC XXXX FT	CONST TRAFFIC XXX FT
LOOSE GRAVEL XXXX FT	UNEVEN LANES XXXX FT
DETOUR X MILE	ROUGH ROAD XXXX FT
ROADWORK PAST SH XXXX	ROADWORK NEXT FRI-SUN
BUMP XXXX FT	US XXX EXIT X MILES
TRAFFIC SIGNAL XXXX FT	LANES SHIFT *

* LANES SHIFT in Phase 1 must be used with STAY IN LANE in Phase 2.

Phase 2: Possible Component Lists

Action to Take/Effect on Travel List

MERGE RIGHT	FORM X LINES RIGHT
DETOUR NEXT X EXITS	USE XXXXX RD EXIT
USE EXIT XXX	USE EXIT I-XX NORTH
STAY ON US XXX SOUTH	USE I-XX E TO I-XX N
TRUCKS USE US XXX N	WATCH FOR TRUCKS
WATCH FOR TRUCKS	EXPECT DELAYS
EXPECT DELAYS	PREPARE TO STOP
REDUCE SPEED XXX FT	END SHOULDER USE
USE OTHER ROUTES	WATCH FOR WORKERS
STAY IN LANE *	

Location List

AT FM XXXX
BEFORE RAILROAD CROSSING
NEXT X MILES
PAST US XXX EXIT
XXXXXXXX TO XXXXXX
US XXX TO FM XXXX

Warning List

SPEED LIMIT XX MPH
MAXIMUM SPEED XX MPH
MINIMUM SPEED XX MPH
ADVISORY SPEED XX MPH
RIGHT LANE EXIT
USE CAUTION
DRIVE SAFELY
DRIVE WITH CARE

** Advance Notice List

TUE-FRI XX AM-X PM
APR XX-XX X PM-X AM
BEGINS MONDAY
BEGINS MAY XX
MAY X-X XX PM - XX AM
NEXT FRI-SUN
XX AM TO XX PM
NEXT TUE AUG XX
TONIGHT XX PM-XX AM

** See Application Guidelines Note 6.

APPLICATION GUIDELINES

- Only 1 or 2 phases are to be used on a PCMS.
- The 1st phase (or both) should be selected from the "Road/Lane/Ramp Closure List" and the "Other Condition List".
- A 2nd phase can be selected from the "Action to Take/Effect on Travel, Location, General Warning, or Advance Notice Phase Lists".
- A Location Phase is necessary only if a distance or location is not included in the first phase selected.
- If two PCMS are used in sequence, they must be separated by a minimum of 1000 ft. Each PCMS shall be limited to two phases, and should be understandable by themselves.
- For advance notice, when the current date is within seven days of the actual work date, calendar days should be replaced with days of the week. Advance notification should typically be for no more than one week prior to the work.

WORDING ALTERNATIVES

- The words RIGHT, LEFT and ALL can be interchanged as appropriate.
- Roadway designations IH, US, SH, FM and LP can be interchanged as appropriate.
- EAST, WEST, NORTH and SOUTH (or abbreviations E, W, N and S) can be interchanged as appropriate.
- Highway names and numbers replaced as appropriate.
- ROAD, HIGHWAY and FREEWAY can be interchanged as needed.
- AHEAD may be used instead of distances if necessary.
- FT and MI, MILE and MILES interchanged as appropriate.
- AT, BEFORE and PAST interchanged as needed.
- Distances or AHEAD can be eliminated from the message if a location phase is used.

PCMS SIGNS WITHIN THE R.O.W. SHALL BE BEHIND GUARDRAIL OR CONCRETE BARRIER OR SHALL HAVE A MINIMUM OF FOUR (4) PLASTIC DRUMS PLACED PERPENDICULAR TO TRAFFIC ON THE UPSTREAM SIDE OF THE PCMS, WHEN EXPOSED TO ONE DIRECTION OF TRAFFIC. WHEN EXPOSED TO TWO WAY TRAFFIC, THE FOUR DRUMS SHOULD BE PLACED WITH ONE DRUM AT EACH OF THE FOUR CORNERS OF THE UNIT.

FULL MATRIX PCMS SIGNS

- When Full Matrix PCMS signs are used, the character height and legibility/visibility requirements shall be maintained as listed in Note 15 under "PORTABLE CHANGEABLE MESSAGE SIGNS" above.
- When symbol signs, such as the "Flagger Symbol" (CW20-7) are represented graphically on the Full Matrix PCMS sign and, with the approval of the Engineer, it shall maintain the legibility/visibility requirement listed above.
- When symbol signs are represented graphically on the Full Matrix PCMS, they shall only supplement the use of the static sign represented, and shall not substitute for, or replace that sign.
- A full matrix PCMS may be used to simulate a flashing arrow board provided it meets the visibility, flash rate and dimming requirements on BC(7), for the same size arrow.

DISCLAIMER: The use of this standard is governed by the "Texas Engineering Practice Act". No warranty of any kind is made by TxDOT for any purpose whatsoever. TxDOT assumes no responsibility for the conversion of this standard to other formats or for misinterpretation of the standard. Designation Set 2 - PCMS Standard BC(6)-21.dgn

DATE: 10/5/2022 11:57:50 AM
FILE: \\txdot\projectwiseonline.com:TXDOT3\Documents\09 - WAC\Design Projects\2311010414 - Design\Plan Set 2 - PCMS Standard BC(6)-21.dgn

WORD OR PHRASE	ABBREVIATION	WORD OR PHRASE	ABBREVIATION
Access Road	ACCS RD	Major	MAJ
Alternate	ALT	Miles	MI
Avenue	AVE	Miles Per Hour	MPH
Best Route	BEST RTE	Minor	MNR
Boulevard	BLVD	Monday	MON
Bridge	BRDG	Normal	NORM
Cannot	CANT	North	N
Center	CTR	Northbound	(route) N
Construction Ahead	CONST AHD	Parking	PKING
CROSSING	XING	Road	RD
Detour Route	DETOUR RTE	Right Lane	RT LN
Do Not	DONT	Saturday	SAT
East	E	Service Road	SERV RD
Eastbound	(route) E	Shoulder	SHLDR
Emergency	EMER	Slippery	SLIP
Emergency Vehicle	EMER VEH	South	S
Entrance, Enter	ENT	Southbound	(route) S
Express Lane	EXP LN	Speed	SPD
Expressway	EXPWY	Street	ST
XXXX Feet	XXXX FT	Sunday	SUN
Fog Ahead	FOG AHD	Telephone	PHONE
Freeway	FRWY, FWY	Temporary	TEMP
Freeway Blocked	FWY BLKD	Thursday	THURS
Friday	FRI	To Downtown	TO DWNTN
Hazardous Driving	HAZ DRIVING	Traffic	TRAF
Hazardous Material	HAZMAT	Travelers	TRVLR
High-Occupancy Vehicle	HOV	Tuesday	TUES
Hour(s)	HR, HRS	Time Minutes	TIME MIN
Information	INFO	Upper Level	UPR LEVEL
It Is	ITS	Vehicles (s)	VEH, VEHS
Junction	JCT	Warning	WARN
Left	LFT	Wednesday	WED
Left Lane	LFT LN	Weight Limit	WT LIMIT
Lane Closed	LN CLOSED	West	W
Lower Level	LWR LEVEL	Westbound	(route) W
Maintenance	MAINT	Wet Pavement	WET PVMT
		Will Not	WONT

Roadway designation # IH-number, US-number, SH-number, FM-number

<h3>BARRICADE AND CONSTRUCTION PORTABLE CHANGEABLE MESSAGE SIGN (PCMS)</h3>			
<h2>BC (6) - 21</h2>			
FILE:	bc-21.dgn	DN:	TxDOT
© TxDOT	November 2002	CONT:	2311
REVISIONS		SECT:	01
9-07	8-14	JOB:	044
7-13	5-21	HIGHWAY:	FM 3051
		DIST:	WAC
		COUNTY:	MCLENNAN
		SHEET NO.:	14

DISCLAIMER: The use of this standard is governed by the "Texas Engineering Practice Act". No warranty of any kind is made by TxDOT for any purpose whatsoever. TxDOT assumes no responsibility for the conversion of this standard to other formats or for incorrect results or damages resulting from its use.

DATE: 10/5/2022 11:57:51 AM
 FILE: \\txdot.projectwiseonline.com:TXDOT3\Documents\09 - WAC\Design Projects\231101044\4 - Design\Plan Set\2 - Design\Plan Set\2 - Design\Plan Set\bc-21.dgn

GENERAL NOTES

- For long term stationary work zones on freeways, drums shall be used as the primary channelizing device.
- For intermediate term stationary work zones on freeways, drums should be used as the primary channelizing device but may be replaced in tangent sections by vertical panels, or 42" two-piece cones. In tangent sections, one-piece cones may be used with the approval of the Engineer but only if personnel are present on the project at all times to maintain the cones in proper position and location.
- For short term stationary work zones on freeways, drums are the preferred channelizing device but may be replaced in tapers, transitions and tangent sections by vertical panels, two-piece cones or one-piece cones as approved by the Engineer.
- Drums and all related items shall comply with the requirements of the current version of the "Texas Manual on Uniform Traffic Control Devices" (TMUTCD) and the "Compliant Work Zone Traffic Control Devices List" (CWZTCD).
- Drums, bases, and related materials shall exhibit good workmanship and shall be free from objectionable marks or defects that would adversely affect their appearance or serviceability.
- The Contractor shall have a maximum of 24 hours to replace any plastic drums identified for replacement by the Engineer/Inspector. The replacement device must be an approved device.

GENERAL DESIGN REQUIREMENTS




- Pre-qualified plastic drums shall meet the following requirements:
- Plastic drums shall be a two-piece design; the "body" of the drum shall be the top portion and the "base" shall be the bottom.
 - The body and base shall lock together in such a manner that the body separates from the base when impacted by a vehicle traveling at a speed of 20 MPH or greater but prevents accidental separation due to normal handling and/or air turbulence created by passing vehicles.
 - Plastic drums shall be constructed of lightweight flexible, and deformable materials. The Contractor shall NOT use metal drums or single piece plastic drums as channelization devices or sign supports.
 - Drums shall present a profile that is a minimum of 18 inches in width at the 36 inch height when viewed from any direction. The height of drum unit (body installed on base) shall be a minimum of 36 inches and a maximum of 42 inches.
 - The top of the drum shall have a built-in handle for easy pickup and shall be designed to drain water and not collect debris. The handle shall have a minimum of two widely spaced 9/16 inch diameter holes to allow attachment of a warning light, warning reflector unit or approved compliant sign.
 - The exterior of the drum body shall have a minimum of four alternating orange and white retroreflective circumferential stripes not less than 4 inches nor greater than 8 inches in width. Any non-reflectorized space between any two adjacent stripes shall not exceed 2 inches in width.
 - Bases shall have a maximum width of 36 inches, a maximum height of 4 inches, and a minimum of two footholds of sufficient size to allow base to be held down while separating the drum body from the base.
 - Plastic drums shall be constructed of ultra-violet stabilized, orange, high-density polyethylene (HDPE) or other approved material.
 - Drum body shall have a maximum unballasted weight of 11 lbs.
 - Drum and base shall be marked with manufacturer's name and model number.

RETROREFLECTIVE SHEETING

- The stripes used on drums shall be constructed of sheeting meeting the color and retroreflectivity requirements of Departmental Materials Specification DMS-8300, "Sign Face Materials." Type A or Type B reflective sheeting shall be supplied unless otherwise specified in the plans.
- The sheeting shall be suitable for use on and shall adhere to the drum surface such that, upon vehicular impact, the sheeting shall remain adhered in-place and exhibit no delaminating, cracking, or loss of retroreflectivity other than that loss due to abrasion of the sheeting surface.

BALLAST


- Unballasted bases shall be large enough to hold up to 50 lbs. of sand. This base, when filled with the ballast material, should weigh between 35 lbs (minimum) and 50 lbs (maximum). The ballast may be sand in one to three sandbags separate from the base, sand in a sand-filled plastic base, or other ballasting devices as approved by the Engineer. Stacking of sandbags will be allowed, however height of sandbags above pavement surface may not exceed 12 inches.
- Bases with built-in ballast shall weigh between 40 lbs. and 50 lbs. Built-in ballast can be constructed of an integral crumb rubber base or a solid rubber base.
- Recycled truck tire sidewalls may be used for ballast on drums approved for this type of ballast on the CWZTCD list.
- The ballast shall not be heavy objects, water, or any material that would become hazardous to motorists, pedestrians, or workers when the drum is struck by a vehicle.
- When used in regions susceptible to freezing, drums shall have drainage holes in the bottoms so that water will not collect and freeze becoming a hazard when struck by a vehicle.
- Ballast shall not be placed on top of drums.
- Adhesives may be used to secure base of drums to pavement.

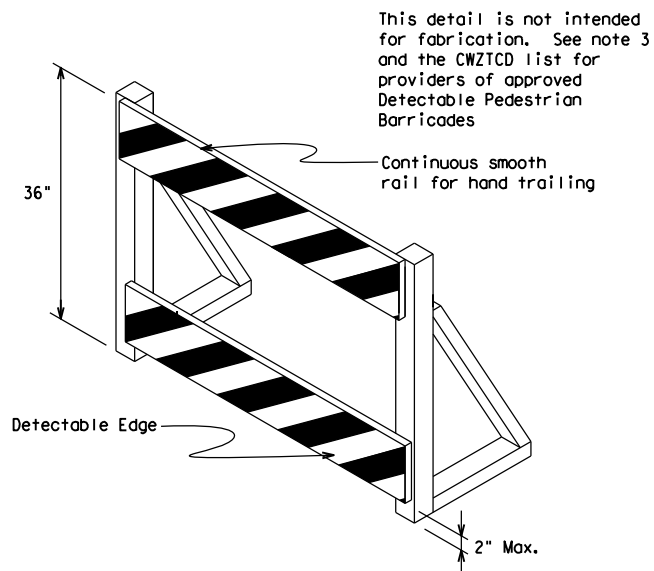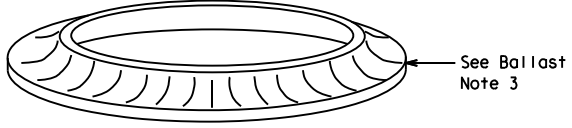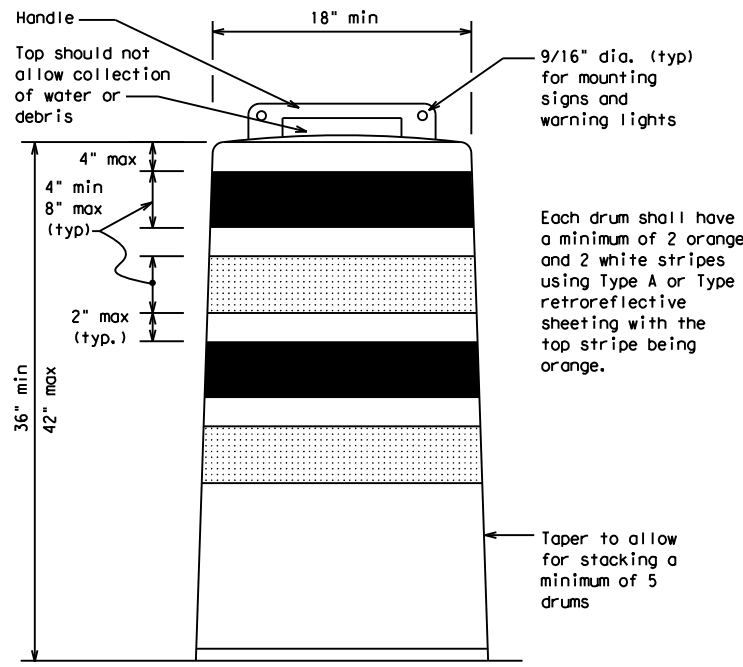


This detail is not intended for fabrication. See note 3 and the CWZTCD list for providers of approved Detectable Pedestrian Barricades

DETECTABLE PEDESTRIAN BARRICADES

- When existing pedestrian facilities are disrupted, closed, or relocated in a TTC zone, the temporary facilities shall be detectable and include accessibility features consistent with the features present in the existing pedestrian facility. Refer to WZ(BTS-2) for Pedestrian Control requirements for Sidewalk Diversions, Sidewalk Detours and Crosswalk Closures.
- Where pedestrians with visual disabilities normally use the closed sidewalk, a Detectable Pedestrian Barricade shall be placed across the full width of the closed sidewalk instead of a Type 3 Barricade.
- Detectable pedestrian barricades similar to the one pictured above, longitudinal channelizing devices, some concrete barriers, and wood or chain link fencing with a continuous detectable edging can satisfactorily delineate a pedestrian path.
- Tape, rope, or plastic chain strung between devices are not detectable, do not comply with the design standards in the "Americans with Disabilities Act Accessibility Guidelines (ADAAG)" and should not be used as a control for pedestrian movements.
- Warning lights shall not be attached to detectable pedestrian barricades.
- Detectable pedestrian barricades should use 8" nominal barricade rails as shown on BC(10) provided that the top rail provides a smooth continuous rail suitable for hand trailing with no splinters, burrs, or sharp edges.

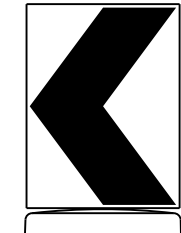

18" x 24" Sign
(Maximum Sign Dimension)
Chevron CW1-8, Opposing Traffic Lane Divider, Driveway sign D70a, Keep Right R4 series or other signs as approved by Engineer

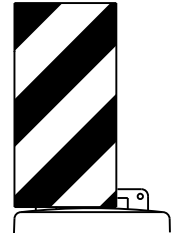

12" x 24" Vertical Panel
mount with diagonals sloping down towards travel way

Plywood, Aluminum or Metal sign substrates shall NOT be used on plastic drums

SIGNS, CHEVRONS, AND VERTICAL PANELS MOUNTED ON PLASTIC DRUMS


- Signs used on plastic drums shall be manufactured using substrates listed on the CWZTCD.
- Chevrons and other work zone signs with an orange background shall be manufactured with Type B_{FL} or Type C_{FL} Orange sheeting meeting the color and retroreflectivity requirements of DMS-8300, "Sign Face Material," unless otherwise specified in the plans.
- Vertical Panels shall be manufactured with orange and white sheeting meeting the requirements of DMS-8300 Type A or Type B. Diagonal stripes on Vertical Panels shall slope down toward the intended traveled lane.
- Other sign messages (text or symbolic) may be used as approved by the Engineer. Sign dimensions shall not exceed 18 inches in width or 24 inches in height, except for the R9 series signs discussed in note 8 below.
- Signs shall be installed using a 1/2 inch bolt (nominal) and nut, two washers, and one locking washer for each connection.
- Mounting bolts and nuts shall be fully engaged and adequately torqued. Bolts should not extend more than 1/2 inch beyond nuts.
- Chevrons may be placed on drums on the outside of curves, on merging tapers or on shifting tapers. When used in these locations, they may be placed on every drum or spaced not more than on every third drum. A minimum of three (3) should be used at each location called for in the plans.
- R9-9, R9-10, R9-11 and R9-11a Sidewalk Closed signs which are 24 inches wide may be mounted on plastic drums, with approval of the Engineer.

SHEET 8 OF 12

<p>BARRICADE AND CONSTRUCTION CHANNELIZING DEVICES</p> <p>BC (8) - 21</p>			
FILE:	bc-21.dgn	DN:	TxDOT
© TxDOT	November 2002	CONT:	2311
REVISIONS:		SECT:	01
4-03	8-14	JOB:	O44
9-07	5-21	HIGHWAY:	FM 3051
7-13		DIST:	WAC
		COUNTY:	MCLENNAN
		SHEET NO.:	16


DISCLAIMER: The use of this standard is governed by the "Texas Engineering Practice Act". No warranty of any kind is made by TxDOT for any purpose whatsoever. TxDOT assumes no responsibility for the conversion of this standard to other formats or for incorrect results or damages resulting from its use.

DATE: 10/5/2022 11:57:52 AM
 FILE: \\txdot.projectwiseonline.com - WAC\Design Projects\231101044\4 - Design\Plan Set\2 - TCP\TCP_Standards\bc-21.dgn

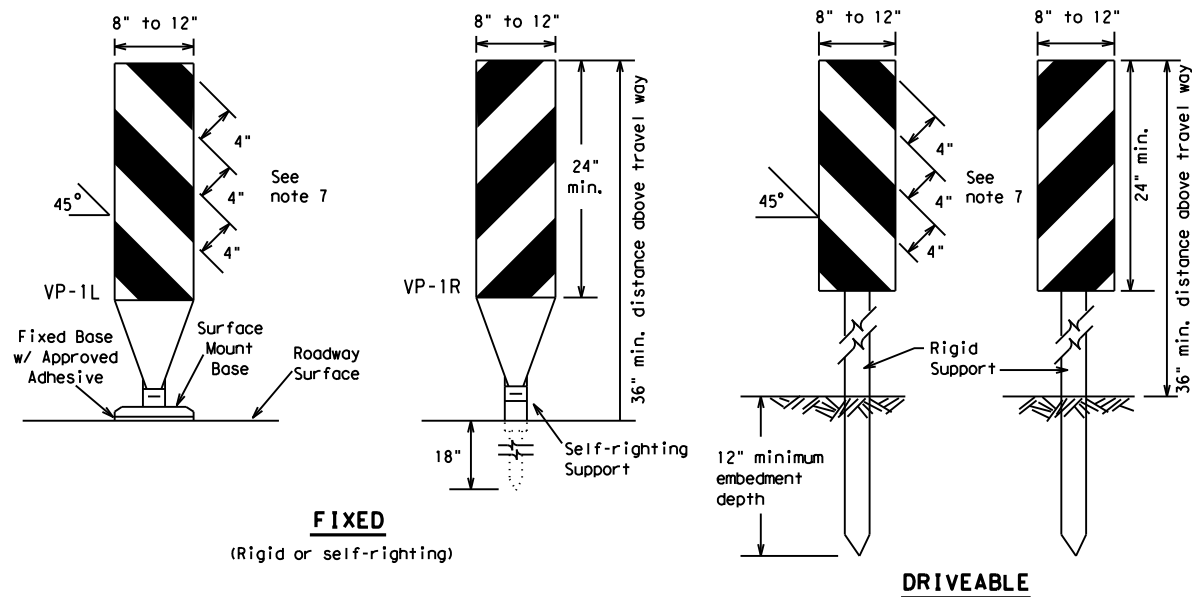

FIXED
(Rigid or self-righting)


DRIVEABLE

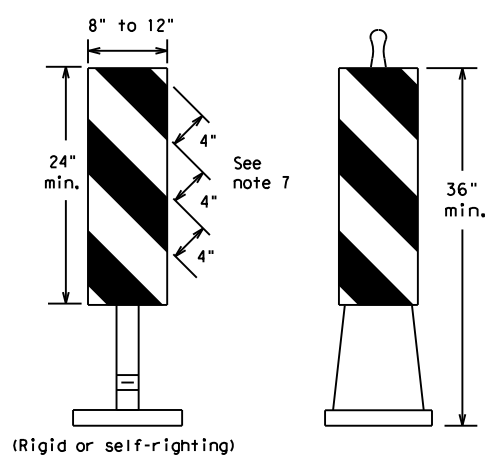

PORTABLE


VERTICAL PANELS (VPs)

- Vertical Panels (VP's) are normally used to channelize traffic or divide opposing lanes of traffic.
- VP's may be used in daytime or nighttime situations. They may be used at the edge of shoulder drop-offs and other areas such as lane transitions where positive daytime and nighttime delineation is required. The Engineer/Inspector shall refer to the Roadway Design Manual for additional requirements on the use VP's for drop-offs.
- VP's should be mounted back to back if used at the edge of cuts adjacent to two-way two lane roadways. Stripes are to be reflective orange and reflective white and should always slope downward toward the travel lane.
- VP's used on expressways and freeways or other high speed roadways, may have more than 270 square inches of retroreflective area facing traffic.
- Self-righting supports are available with portable base. See "Compliant Work Zone Traffic Control Devices List" (CWZTCD).
- Sheeting for the VP's shall be retroreflective Type A or Type B conforming to Departmental Material Specification DMS-8300, unless noted otherwise.
- Where the height of reflective material on the vertical panel is 36 inches or greater, a panel stripe of 6 inches shall be used.

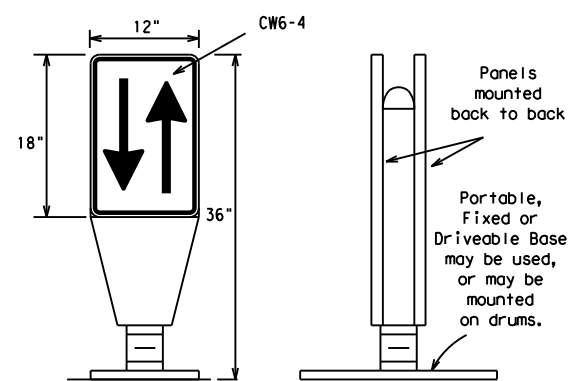


OPPOSING TRAFFIC LANE DIVIDERS (OTLD)

- Opposing Traffic Lane Dividers (OTLD) are delineation devices designed to convert a normal one-way roadway section to two-way operation. OTLD's are used on temporary centerlines. The upward and downward arrows on the sign's face indicate the direction of traffic on either side of the divider. The base is secured to the pavement with an adhesive or rubber weight to minimize movement caused by a vehicle impact or wind gust.
- The OTLD may be used in combination with 42" cones or VPs.
- Spacing between the OTLD shall not exceed 500 feet. 42" cones or VPs placed between the OTLD's should not exceed 100 foot spacing.
- The OTLD shall be orange with a black non-reflective legend. Sheeting for the OTLD shall be retroreflective Type B_{FL} or Type C_{FL} conforming to Departmental Material Specification DMS-8300, unless noted otherwise. The legend shall meet the requirements of DMS-8300.

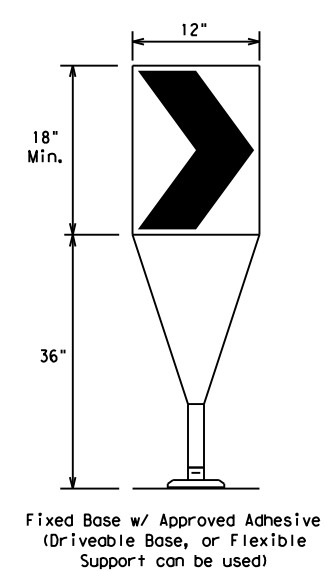

- The chevron shall be a vertical rectangle with a minimum size of 12 by 18 inches.
- Chevrons are intended to give notice of a sharp change of alignment with the direction of travel and provide additional emphasis and guidance for vehicle operators with regard to changes in horizontal alignment of the roadway.
- Chevrons, when used, shall be erected on the outside of a sharp curve or turn, or on the far side of an intersection. They shall be in line with and at right angles to approaching traffic. Spacing should be such that the motorist always has three in view, until the change in alignment eliminates its need.
- To be effective, the chevron should be visible for at least 500 feet.
- Chevrons shall be orange with a black nonreflective legend. Sheeting for the chevron shall be retroreflective Type B_{FL} or Type C_{FL} conforming to Departmental Material Specification DMS-8300, unless noted otherwise. The legend shall meet the requirements of DMS-8300.
- For Long Term Stationary use on tapers or transitions on freeways and divided highways, self-righting chevrons may be used to supplement plastic drums but not to replace plastic drums.

CHEVRONS

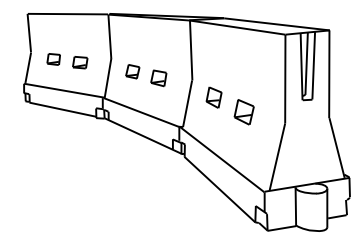

LONGITUDINAL CHANNELIZING DEVICES (LCD)

- LCDs are crashworthy, lightweight, deformable devices that are highly visible, have good target value and can be connected together. They are not designed to contain or redirect a vehicle on impact.
- LCDs may be used instead of a line of cones or drums.
- LCDs shall be placed in accordance to application and installation requirements specific to the device, and used only when shown on the CWZTCD list.
- LCDs should not be used to provide positive protection for obstacles, pedestrians or workers.
- LCDs shall be supplemented with retroreflective delineation as required for temporary barriers on BC(7) when placed roughly parallel to the travel lanes.
- LCDs used as barricades placed perpendicular to traffic should have at least one row of reflective sheeting meeting the requirements for barricade rails as shown on BC(10). Place reflective sheeting near the top of the LCD along the full length of the device.

WATER BALLASTED SYSTEMS USED AS BARRIERS

- Water ballasted systems used as barriers shall not be used solely to channelize road users, but also to protect the work space per the appropriate Manual for Assessing Safety Hardware (MASH) crashworthiness requirements based on roadway speed and barrier application.
- Water ballasted systems used to channelize vehicular traffic shall be supplemented with retroreflective delineation or channelizing devices to improve daytime/nighttime visibility. They may also be supplemented with pavement markings.
- Water ballasted systems used as barriers shall be placed in accordance to application and installation requirements specific to the device, and used only when shown on the CWZTCD list.
- Water ballasted systems used as barriers should not be used for a merging taper except in low speed (less than 45 MPH) urban areas. When used on a taper in a low speed urban area, the taper shall be delineated and the taper length should be designed to optimize road user operations considering the available geometric conditions.
- When water ballasted systems used as barriers have blunt ends exposed to traffic, they should be attenuated as per manufacturer recommendations or flared to a point outside the clear zone.

If used to channelize pedestrians, longitudinal channelizing devices or water ballasted systems must have a continuous detectable bottom for users of long canes and the top of the unit shall not be less than 32 inches in height.

HOLLOW OR WATER BALLASTED SYSTEMS USED AS LONGITUDINAL CHANNELIZING DEVICES OR BARRIERS

GENERAL NOTES

- Work Zone channelizing devices illustrated on this sheet may be installed in close proximity to traffic and are suitable for use on high or low speed roadways. The Engineer/Inspector shall ensure that spacing and placement is uniform and in accordance with the "Texas Manual on Uniform Traffic Control Devices" (TMUTCD).
- Channelizing devices shown on this sheet may have a driveable, fixed or portable base. The requirement for self-righting channelizing devices must be specified in the General Notes or other plan sheets.
- Channelizing devices on self-righting supports should be used in work zone areas where channelizing devices are frequently impacted by errant vehicles or vehicle related wind gusts making alignment of the channelizing devices difficult to maintain. Locations of these devices shall be detailed elsewhere in the plans. These devices shall conform to the TMUTCD and the "Compliant Work Zone Traffic Control Devices List" (CWZTCD).
- The Contractor shall maintain devices in a clean condition and replace damaged, nonreflective, faded, or broken devices and bases as required by the Engineer/Inspector. The Contractor shall be required to maintain proper device spacing and alignment.
- Portable bases shall be fabricated from virgin and/or recycled rubber. The portable bases shall weigh a minimum of 30 lbs.
- Pavement surfaces shall be prepared in a manner that ensures proper bonding between the adhesives, the fixed mount bases and the pavement surface. Adhesives shall be prepared and applied according to the manufacturer's recommendations.
- The installation and removal of channelizing devices shall not cause detrimental effects to the final pavement surfaces, including pavement surface discoloration or surface integrity. Driveable bases shall not be permitted on final pavement surfaces. The Engineer/Inspector shall approve all application and removal procedures of fixed bases.

Posted Speed	Formula	Minimum Desirable Taper Lengths **			Suggested Maximum Spacing of Channelizing Devices	
		10' Offset	11' Offset	12' Offset	On a Taper	On a Tangent
30	L = WS ² / 60	150'	165'	180'	30'	60'
35		205'	225'	245'	35'	70'
40		265'	295'	320'	40'	80'
45	L = WS	450'	495'	540'	45'	90'
50		500'	550'	600'	50'	100'
55		550'	605'	660'	55'	110'
60		600'	660'	720'	60'	120'
65		650'	715'	780'	65'	130'
70		700'	770'	840'	70'	140'
75		750'	825'	900'	75'	150'
80		800'	880'	960'	80'	160'

**Taper lengths have been rounded off.
 L=Length of Taper (FT.) W=Width of Offset (FT.)
 S=Posted Speed (MPH)

SUGGESTED MAXIMUM SPACING OF CHANNELIZING DEVICES AND MINIMUM DESIRABLE TAPER LENGTHS

SHEET 9 OF 12



BARRICADE AND CONSTRUCTION CHANNELIZING DEVICES

BC (9) - 21

FILE:	bc-21.dgn	DN:	TxDOT	CK:	TxDOT	DW:	TxDOT	CK:	TxDOT
© TxDOT	November 2002	CONT	SECT	JOB	SECT	HIGHWAY			
REVISIONS	2311	01	044	FM	3051				
9-07	8-14	DIST	COUNTY	SHEET NO.					
7-13	5-21	WAC	MCLENNAN	17					

DISCLAIMER: The use of this standard is governed by the "Texas Engineering Practice Act". No warranty of any kind is made by TxDOT for any purpose whatsoever. TxDOT assumes no responsibility for the conversion of this standard to other formats or for incorrect results or damages resulting from its use.
 DATE: 10/5/2022 11:57:52 AM
 FILE: \\txdotprojectwiseonline.com:TXDOT3\Documents\09 - WAC\Design Projects\231101044\4 - Design\Plan Set\2 - TCP\TCP_Standards\bc-21.dgn


TYPE 3 BARRICADES

1. Refer to the Compliant Work Zone Traffic Control Devices List (CWZTCD) for details of the Type 3 Barricades and a list of all materials used in the construction of Type 3 Barricades.
2. Type 3 Barricades shall be used at each end of construction projects closed to all traffic.
3. Barricades extending across a roadway should have stripes that slope downward in the direction toward which traffic must turn in detouring. When both right and left turns are provided, the chevron striping may slope downward in both directions from the center of the barricade. Where no turns are provided at a closed road, striping should slope downward in both directions toward the center of roadway.
4. Striping of rails, for the right side of the roadway, should slope downward to the left. For the left side of the roadway, striping should slope downward to the right.
5. Identification markings may be shown only on the back of the barricade rails. The maximum height of letters and/or company logos used for identification shall be 1".
6. Barricades shall not be placed parallel to traffic unless an adequate clear zone is provided.
7. Warning lights shall NOT be installed on barricades.
8. Where barricades require the use of weights to keep from turning over, the use of sandbags with dry, cohesionless sand is recommended. The sandbags will be tied shut to keep the sand from spilling and to maintain a constant weight. Sand bags shall not be stacked in a manner that covers any portion of a barricade rails reflective sheeting. Rock, concrete, iron, steel or other solid objects will NOT be permitted. Sandbags should weigh a minimum of 35 lbs and a maximum of 50 lbs. Sandbags shall be made of a durable material that tears upon vehicular impact. Rubber (such as tire inner tubes) shall not be used for sandbags. Sandbags shall only be placed along or upon the base supports of the device and shall not be suspended above ground level or hung with rope, wire, chains or other fasteners.
9. Sheeting for barricades shall be retroreflective Type A or Type B conforming to Departmental Material Specification DMS-8300 unless otherwise noted.


Barricades shall NOT be used as a sign support.



TYPICAL STRIPING DETAIL FOR BARRICADE RAIL

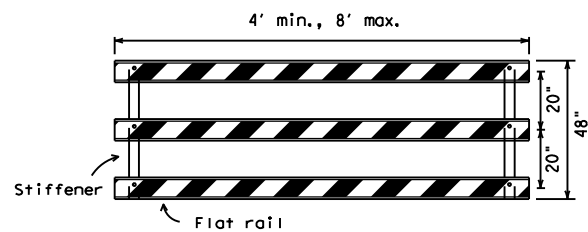


TYPICAL PANEL DETAIL FOR SKID OR POST TYPE BARRICADES

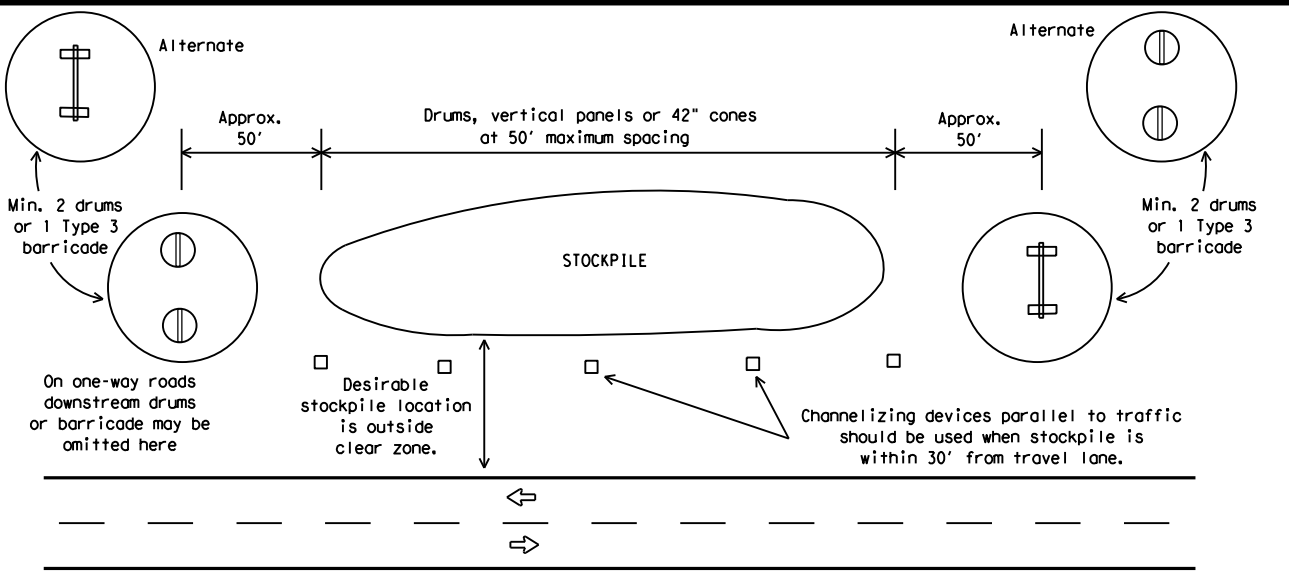


TRAFFIC CONTROL FOR MATERIAL STOCKPILES

Each roadway of a divided highway shall be barricaded in the same manner.

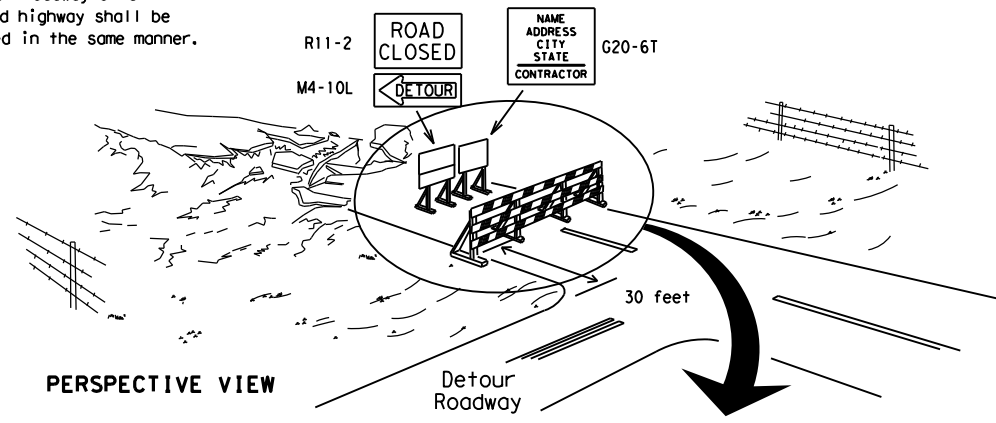

PERSPECTIVE VIEW


The three rails on Type 3 barricades shall be reflectorized orange and reflective white stripes on one side facing one-way traffic and both sides for two-way traffic. Barricade striping should slant downward in the direction of detour.

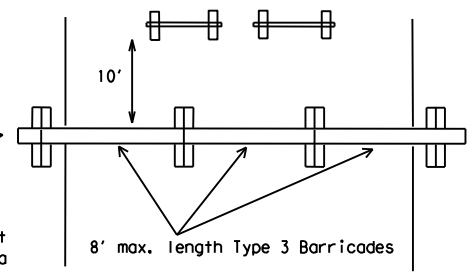


PLAN VIEW

1. Signs should be mounted on independent supports at a 7 foot mounting height in center of roadway. The signs should be a minimum of 10 feet behind Type 3 Barricades.
2. Advance signing shall be as specified elsewhere in the plans.

TYPE 3 BARRICADE (POST AND SKID) TYPICAL APPLICATION

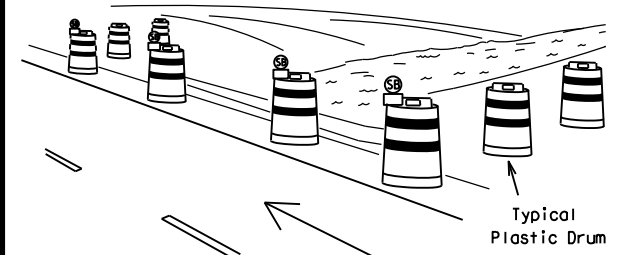

PERSPECTIVE VIEW

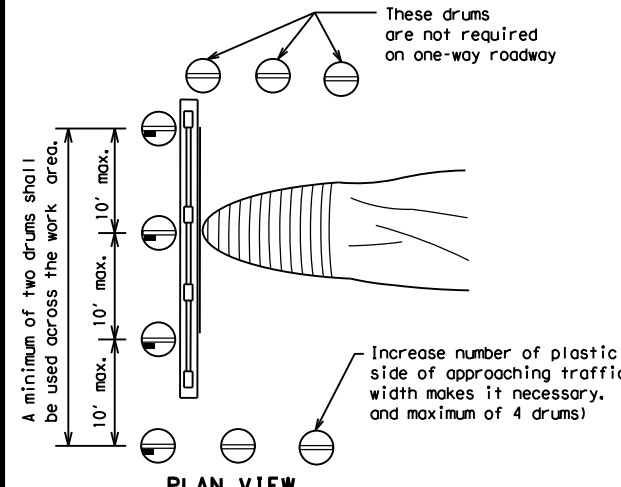


PLAN VIEW

1. Where positive redirection capability is provided, drums may be omitted.
2. Plastic construction fencing may be used with drums for safety as required in the plans.
3. Vertical Panels on flexible support may be substituted for drums when the shoulder width is less than 4 feet.
4. When the shoulder width is greater than 12 feet, steady-burn lights may be omitted if drums are used.
5. Drums must extend the length of the culvert widening.

LEGEND	
	Plastic drum
	Plastic drum with steady burn light or yellow warning reflector
	Steady burn warning light or yellow warning reflector

CULVERT WIDENING OR OTHER ISOLATED WORK WITHIN THE PROJECT LIMITS

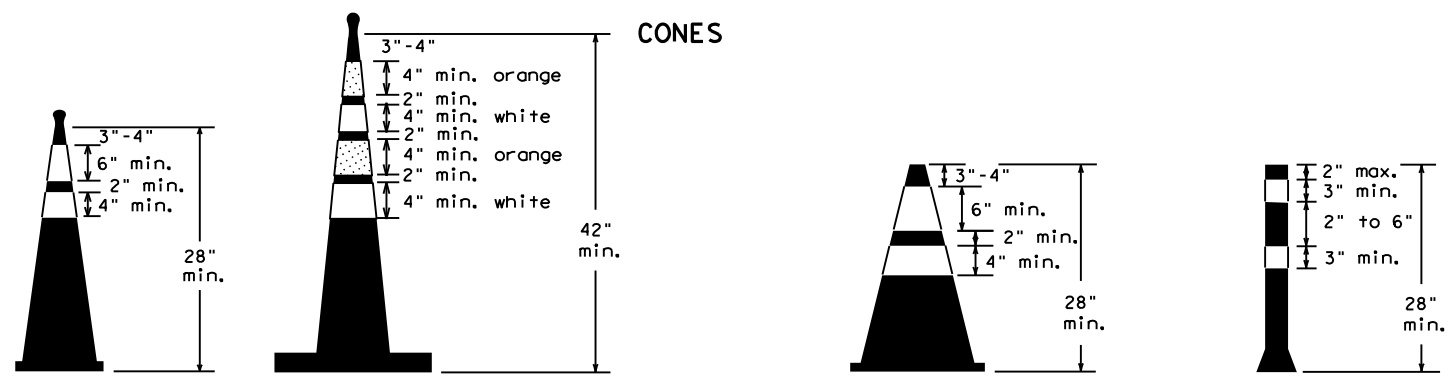

Two-Piece cones

One-Piece cones

Tubular Marker

28" Cones shall have a minimum weight of 9 1/2 lbs.
 42" 2-piece cones shall have a minimum weight of 30 lbs. including base.

1. Traffic cones and tubular markers shall be predominantly orange, and meet the height and weight requirements shown above.
2. One-piece cones have the body and base of the cone molded in one consolidated unit. Two-piece cones have a cone shaped body and a separate rubber base, or ballast, that is added to keep the device upright and in place.
3. Two-piece cones may have a handle or loop extending up to 8" above the minimum height shown, in order to aid in retrieving the device.
4. Cones or tubular markers shall have white or white and orange reflective bands as shown above. The reflective bands shall have a smooth, sealed outer surface and meet the requirements of Departmental Material Specification DMS-8300 Type A or Type B.
5. 28" cones and tubular markers are generally suitable for short duration and short-term stationary work as defined on BC(4). These should not be used for intermediate-term or long-term stationary work unless personnel is on-site to maintain them in their proper upright position.
6. 42" two-piece cones, vertical panels or drums are suitable for all work zone durations.
7. Cones or tubular markers used on each project should be of the same size and shape.



BARRICADE AND CONSTRUCTION CHANNELIZING DEVICES

BC (10) - 21

FILE: bc-21.dgn	DN: TxDOT	CK: TxDOT	OW: TxDOT	CR: TxDOT
© TxDOT November 2002	CONT	SECT	JOB	HIGHWAY
REVISIONS	2311	01	044	FM 3051
9-07 8-14	DIST	COUNTY		SHEET NO.
7-13 5-21	WAC	MCLENNAN		18

WORK ZONE PAVEMENT MARKINGS

GENERAL

- The Contractor shall be responsible for maintaining work zone and existing pavement markings, in accordance with the standard specifications and special provisions, on all roadways open to traffic within the CSJ limits unless otherwise stated in the plans.
- Color, patterns and dimensions shall be in conformance with the "Texas Manual on Uniform Traffic Control Devices" (TMUTCD).
- Additional supplemental pavement marking details may be found in the plans or specifications.
- Pavement markings shall be installed in accordance with the TMUTCD and as shown on the plans.
- When short term markings are required on the plans, short term markings shall conform with the TMUTCD, the plans and details as shown on the Standard Plan Sheet WZ(STPM).
- When standard pavement markings are not in place and the roadway is opened to traffic, DO NOT PASS signs shall be erected to mark the beginning of the sections where passing is prohibited and PASS WITH CARE signs at the beginning of sections where passing is permitted.
- All work zone pavement markings shall be installed in accordance with Item 662, "Work Zone Pavement Markings."

RAISED PAVEMENT MARKERS

- Raised pavement markers are to be placed according to the patterns on BC(12).
- All raised pavement markers used for work zone markings shall meet the requirements of Item 672, "RAISED PAVEMENT MARKERS" and Departmental Material Specification DMS-4200 or DMS-4300.

PREFABRICATED PAVEMENT MARKINGS

- Removable prefabricated pavement markings shall meet the requirements of DMS-8241.
- Non-removable prefabricated pavement markings (foil back) shall meet the requirements of DMS-8240.


MAINTAINING WORK ZONE PAVEMENT MARKINGS

- The Contractor will be responsible for maintaining work zone pavement markings within the work limits.
- Work zone pavement markings shall be inspected in accordance with the frequency and reporting requirements of work zone traffic control device inspections as required by Form 599.
- The markings should provide a visible reference for a minimum distance of 300 feet during normal daylight hours and 160 feet when illuminated by automobile low-beam headlights at night, unless sight distance is restricted by roadway geometrics.
- Markings failing to meet this criteria within the first 30 days after placement shall be replaced at the expense of the Contractor as per Specification Item 662.

REMOVAL OF PAVEMENT MARKINGS

- Pavement markings that are no longer applicable, could create confusion or direct a motorist toward or into the closed portion of the roadway shall be removed or obliterated before the roadway is opened to traffic.
- The above shall not apply to detours in place for less than three days, where flaggers and/or sufficient channelizing devices are used in lieu of markings to outline the detour route.
- Pavement markings shall be removed to the fullest extent possible, so as not to leave a discernable marking. This shall be by any method approved by TxDOT Specification Item 677 for "Eliminating Existing Pavement Markings and Markers".
- The removal of pavement markings may require resurfacing or seal coating portions of the roadway as described in Item 677.
- Subject to the approval of the Engineer, any method that proves to be successful on a particular type pavement may be used.
- Blast cleaning may be used but will not be required unless specifically shown in the plans.
- Over-painting of the markings SHALL NOT BE permitted.
- Removal of raised pavement markers shall be as directed by the Engineer.
- Removal of existing pavement markings and markers will be paid for directly in accordance with Item 677, "ELIMINATING EXISTING PAVEMENT MARKINGS AND MARKERS," unless otherwise stated in the plans.
- Black-out marking tape may be used to cover conflicting existing markings for periods less than two weeks when approved by the Engineer.

Temporary Flexible-Reflective Roadway Marker Tabs

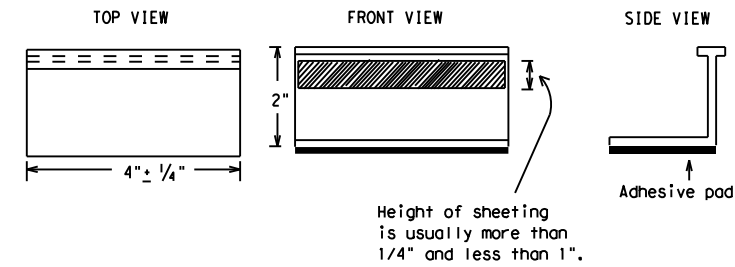

**STAPLES OR NAILS SHALL NOT BE USED TO SECURE
TEMPORARY FLEXIBLE-REFLECTIVE ROADWAY MARKER
TABS TO THE PAVEMENT SURFACE**

- Temporary flexible-reflective roadway marker tabs used as guidemarks shall meet the requirements of DMS-8242.
- Tabs detailed on this sheet are to be inspected and accepted by the Engineer or designated representative. Sampling and testing is not normally required, however at the option of the Engineer, either "A" or "B" below may be imposed to assure quality before placement on the roadway.
 - Select five (5) or more tabs at random from each lot or shipment and submit to the Construction Division, Materials and Pavement Section to determine specification compliance.
 - Select five (5) tabs and perform the following test. Affix five (5) tabs at 24 inch intervals on an asphaltic pavement in a straight line. Using a medium size passenger vehicle or pickup, run over the markers with the front and rear tires at a speed of 35 to 40 miles per hour, four (4) times in each direction. No more than one (1) out of the five (5) reflective surfaces shall be lost or displaced as a result of this test.
- Small design variances may be noted between tab manufacturers.
- See Standard Sheet WZ(STPM) for tab placement on new pavements. See Standard Sheet TCP(7-1) for tab placement on seal coat work.

RAISED PAVEMENT MARKERS USED AS GUIDEMARKS

- Raised pavement markers used as guidemarks shall be from the approved product list, and meet the requirements of DMS-4200.
- All temporary construction raised pavement markers provided on a project shall be of the same manufacturer.
- Adhesive for guidemarks shall be bituminous material hot applied or butyl rubber pad for all surfaces, or thermoplastic for concrete surfaces.

Guidemarks shall be designated as:
 YELLOW - (two amber reflective surfaces with yellow body).
 WHITE - (one silver reflective surface with white body).

DEPARTMENTAL MATERIAL SPECIFICATIONS	
PAVEMENT MARKERS (REFLECTORIZED)	DMS-4200
TRAFFIC BUTTONS	DMS-4300
EPOXY AND ADHESIVES	DMS-6100
BITUMINOUS ADHESIVE FOR PAVEMENT MARKERS	DMS-6130
PERMANENT PREFABRICATED PAVEMENT MARKINGS	DMS-8240
TEMPORARY REMOVABLE, PREFABRICATED PAVEMENT MARKINGS	DMS-8241
TEMPORARY FLEXIBLE, REFLECTIVE ROADWAY MARKER TABS	DMS-8242

A list of prequalified reflective raised pavement markers, non-reflective traffic buttons, roadway marker tabs and other pavement markings can be found at the Material Producer List web address shown on BC(1).

SHEET 11 OF 12




BARRICADE AND CONSTRUCTION PAVEMENT MARKINGS

BC(11)-21


FILE: bc-21.dgn	DN: TxDOT	CR: TxDOT	DW: TxDOT	CK: TxDOT
© TxDOT February 1998	CONT	SECT	JOB	HIGHWAY
REVISIONS	2311	01	044	FM 3051
2-98 9-07 5-21	DIST	COUNTY		SHEET NO.
1-02 7-13	WAC	MCLENNAN		19
11-02 8-14				

DISCLAIMER: The use of this standard is governed by the "Texas Engineering Practice Act". No warranty of any kind is made by TxDOT for any purpose whatsoever. TxDOT assumes no responsibility for the conversion of this standard to other formats or for incorrect results or damages resulting from its use.
 DATE: 10/5/2022 11:57:52 AM
 FILE: \\txdot.projectwiseonline.com:TXDOT3\Documents\09 - WAC\Design Projects\231101044\4 - Design\Plan Set\2 - TCP\TCP_Standards\bc-21.dgn

 PAVEMENT MARKING PATTERNS




REFLECTORIZED PAVEMENT MARKINGS - PATTERN A

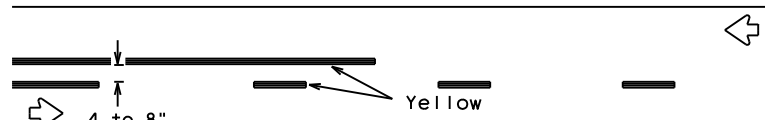


REFLECTORIZED PAVEMENT MARKINGS - PATTERN B

 Pattern A is the TXDOT Standard, however Pattern B may be used if approved by the Engineer. Prefabricated markings may be substituted for reflectORIZED pavement markings.




RAISED PAVEMENT MARKERS - PATTERN A

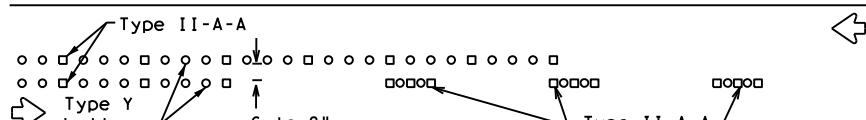


RAISED PAVEMENT MARKERS - PATTERN B

CENTER LINE & NO-PASSING ZONE BARRIER LINES FOR TWO-LANE, TWO-WAY HIGHWAYS

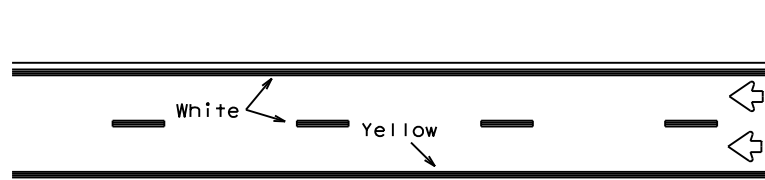


REFLECTORIZED PAVEMENT MARKINGS

Prefabricated markings may be substituted for reflectORIZED pavement markings.

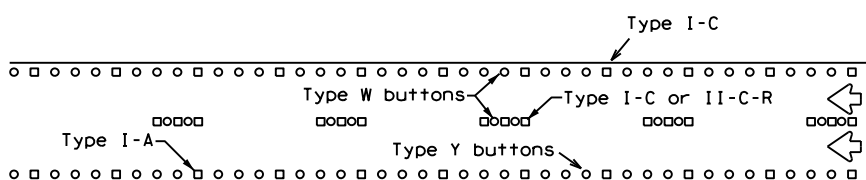


RAISED PAVEMENT MARKERS

EDGE & LANE LINES FOR DIVIDED HIGHWAY

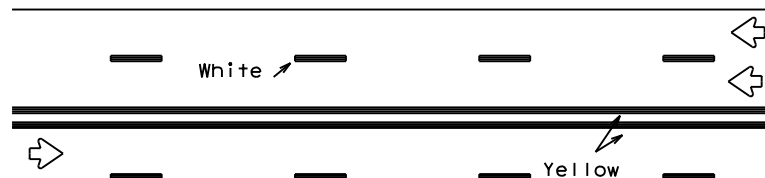


REFLECTORIZED PAVEMENT MARKINGS

Prefabricated markings may be substituted for reflectORIZED pavement markings.

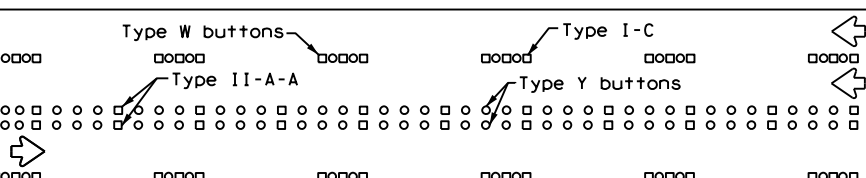


RAISED PAVEMENT MARKERS

LANE & CENTER LINES FOR MULTILANE UNDIVIDED HIGHWAYS

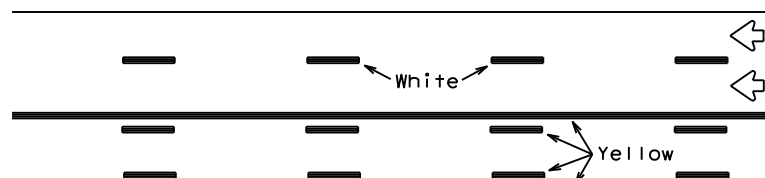

REFLECTORIZED PAVEMENT MARKINGS


Prefabricated markings may be substituted for reflectORIZED pavement markings.

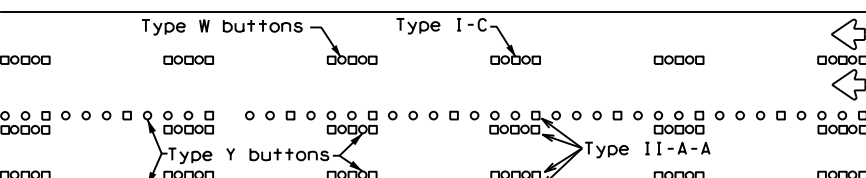



RAISED PAVEMENT MARKERS

TWO-WAY LEFT TURN LANE


STANDARD WORK ZONE PAVEMENT MARKINGS DETAILS

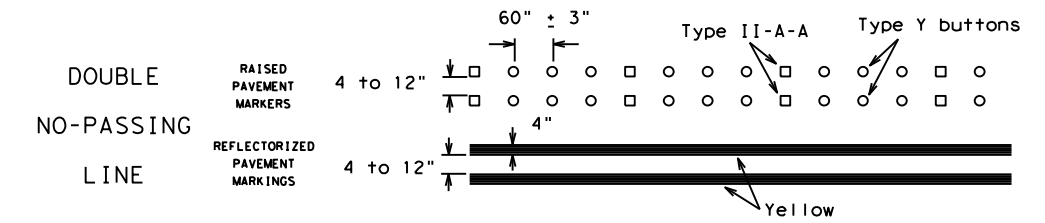


SOLID LINES

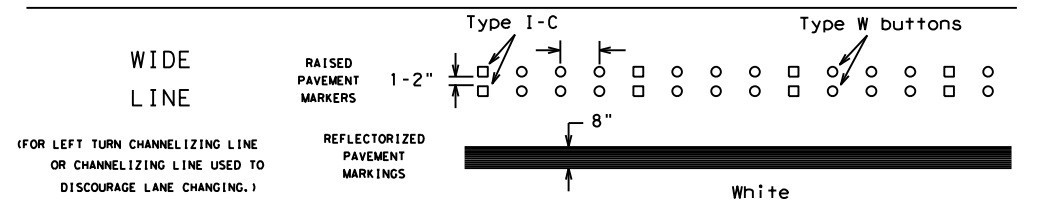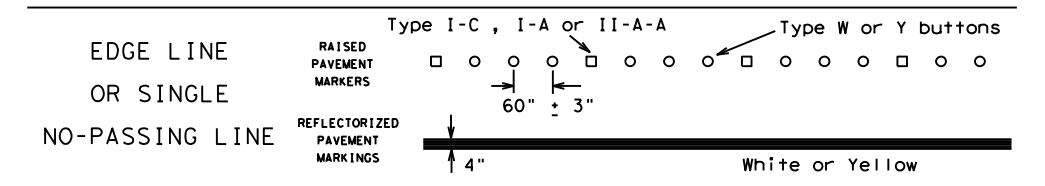

BROKEN LINES

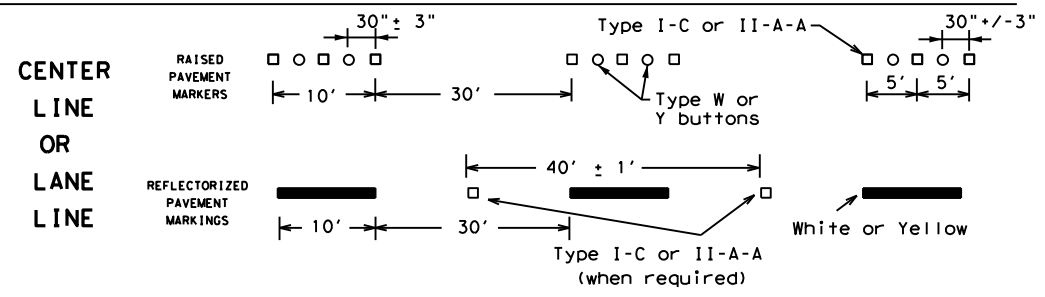


AUXILIARY OR LANEDROP LINE

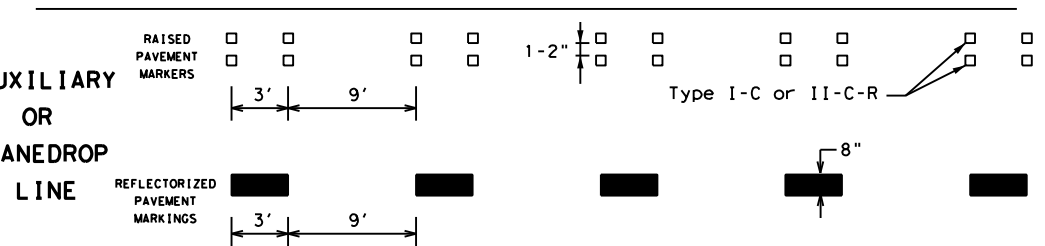

REMOVABLE MARKINGS WITH RAISED PAVEMENT MARKERS

If raised pavement markers are used to supplement REMOVABLE markings, the markers shall be applied to the top of the tape at the approximate mid length of tape used for broken lines or at 20 foot spacing for solid lines. This allows an easier removal of raised pavement markers and tape.

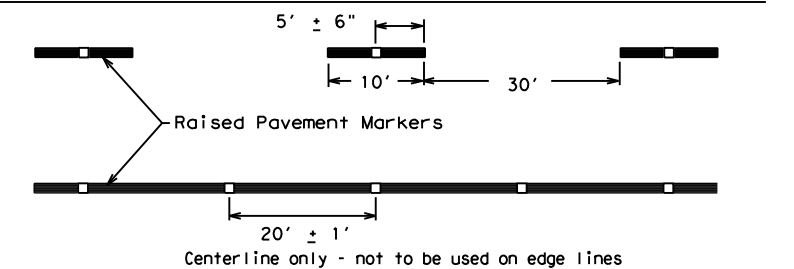

SHEET 12 OF 12



BARRICADE AND CONSTRUCTION PAVEMENT MARKING PATTERNS

BC(12)-21


Raised pavement markers used as standard pavement markings shall be from the approved products list and meet the requirements of Item 672 "RAISED PAVEMENT MARKERS."

FILE: bc-21.dgn	DN: TxDOT	CK: TxDOT	DW: TxDOT	CR: TxDOT
©TxDOT February 1998	CONT	SECT	JOB	HIGHWAY
REVISIONS	2311	01	044	FM 3051
1-97 9-07 5-21	DIST	COUNTY	SHEET NO.	
2-98 7-13	WAC	MCLENNAN	20	
11-02 8-14				

DATE: 10/5/2022 11:57:52 AM
 FILE: \\txdot.projectwiseonline.com:TXDOT3\Documents\09 - WAC\Design Projects\231101044\4 - Design\Plan Set\2 - TCP\TCP_Standards\bc-21.dgn
 DISCLAIMER: The use of this standard is governed by the "Texas Engineering Practice Act". No warranty of any kind is made by TXDOT for any purpose whatsoever. TXDOT assumes no responsibility for the conversion of this standard to other formats or for incorrect results or damages resulting from its use.


DISCLAIMER: The use of this standard is governed by the "Texas Engineering Practice Act". No warranty of any kind is made by TxDOT for any purpose whatsoever. TxDOT assumes no responsibility for the conversion of units or for the use of any of the symbols or abbreviations herein.

DATE: 10/5/2022 11:57:56 AM
FILE: \\txdot.projectwiseonline.com:TXDOT13\Documents\09 - WAC\Design Projects\13\091004\13\091004_091004.dgn

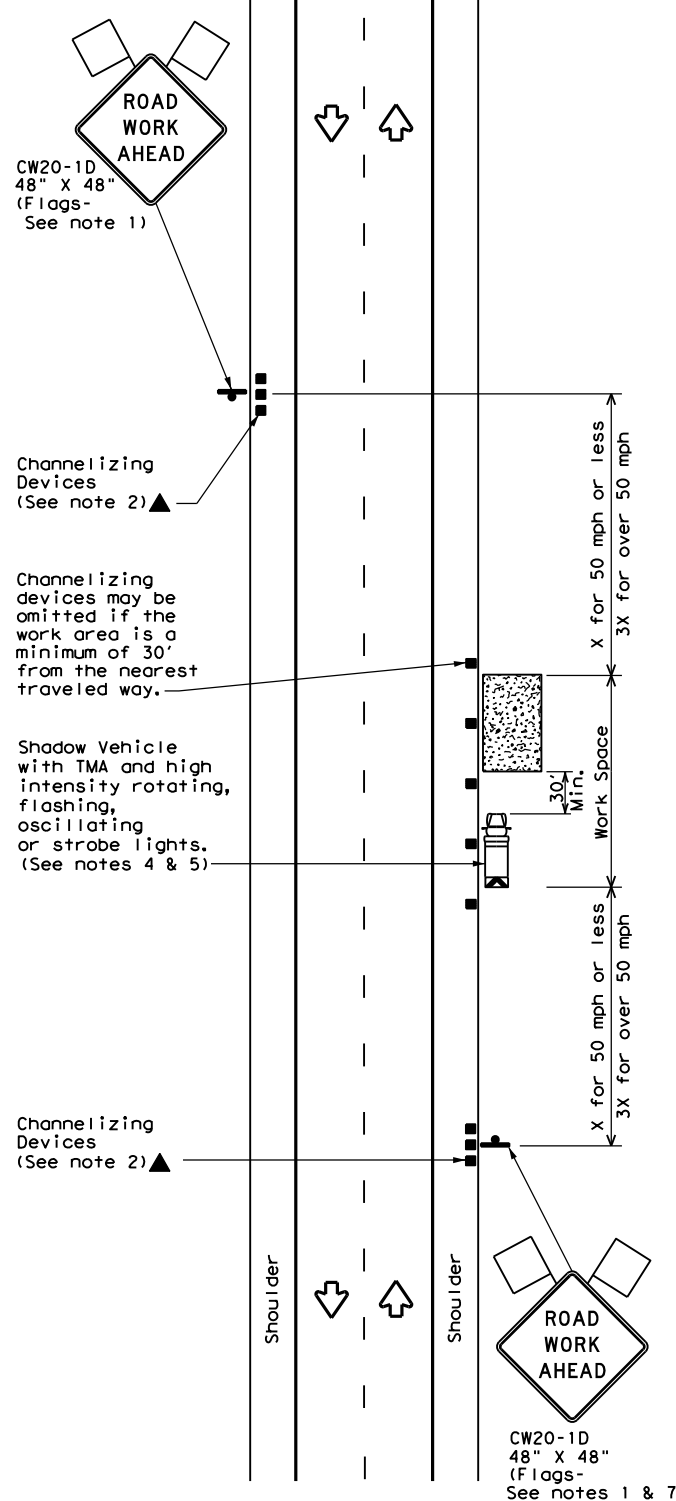


TCP (1-1a)

WORK SPACE NEAR SHOULDER
Conventional Roads

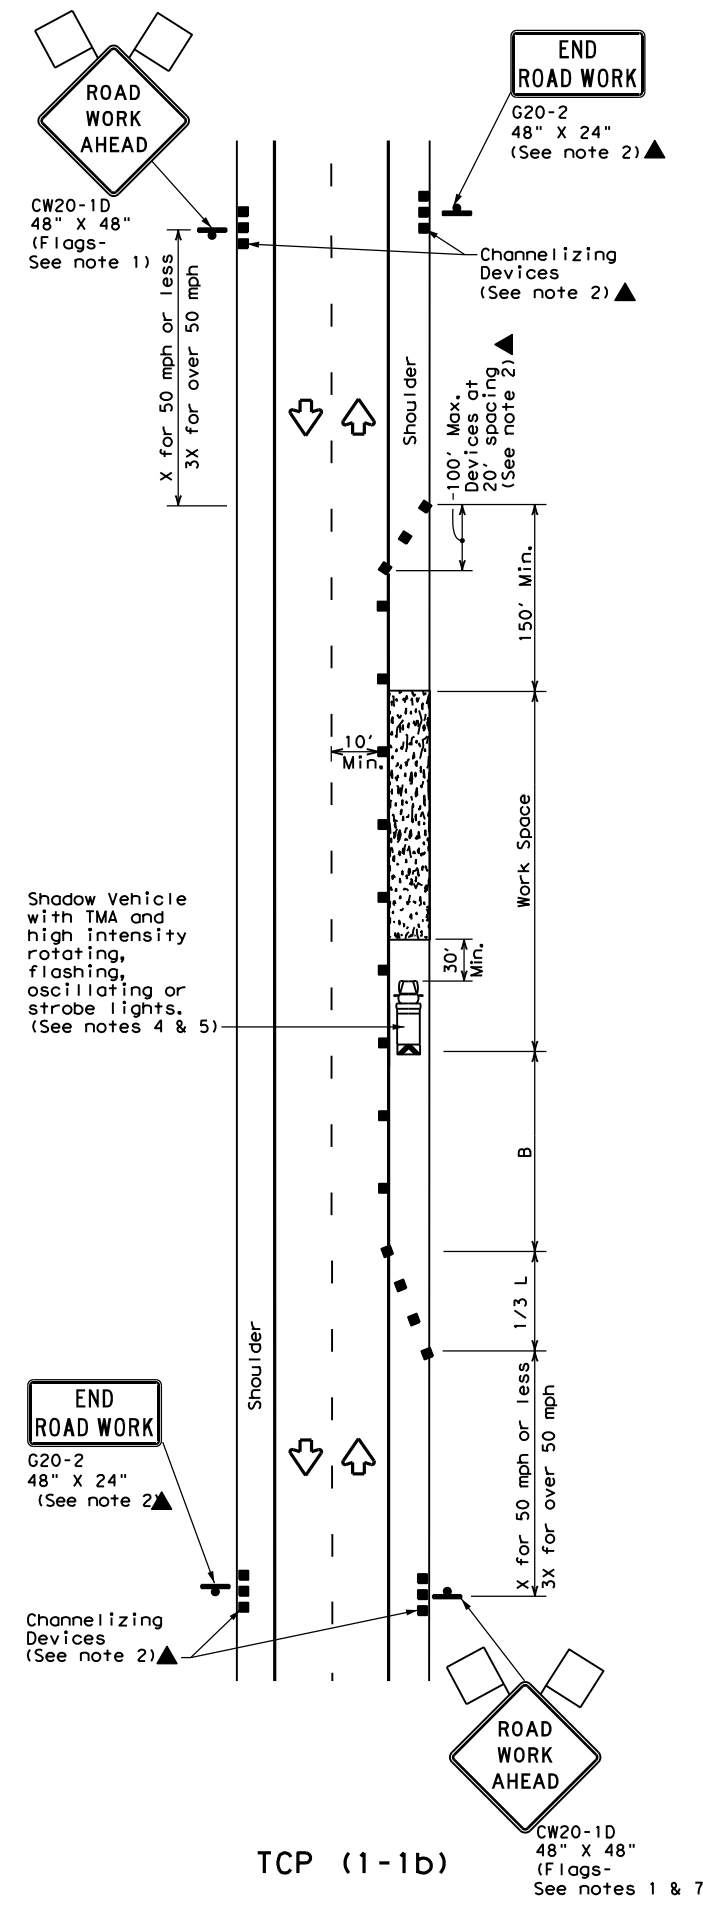

TCP (1-1b)

WORK SPACE ON SHOULDER
Conventional Roads

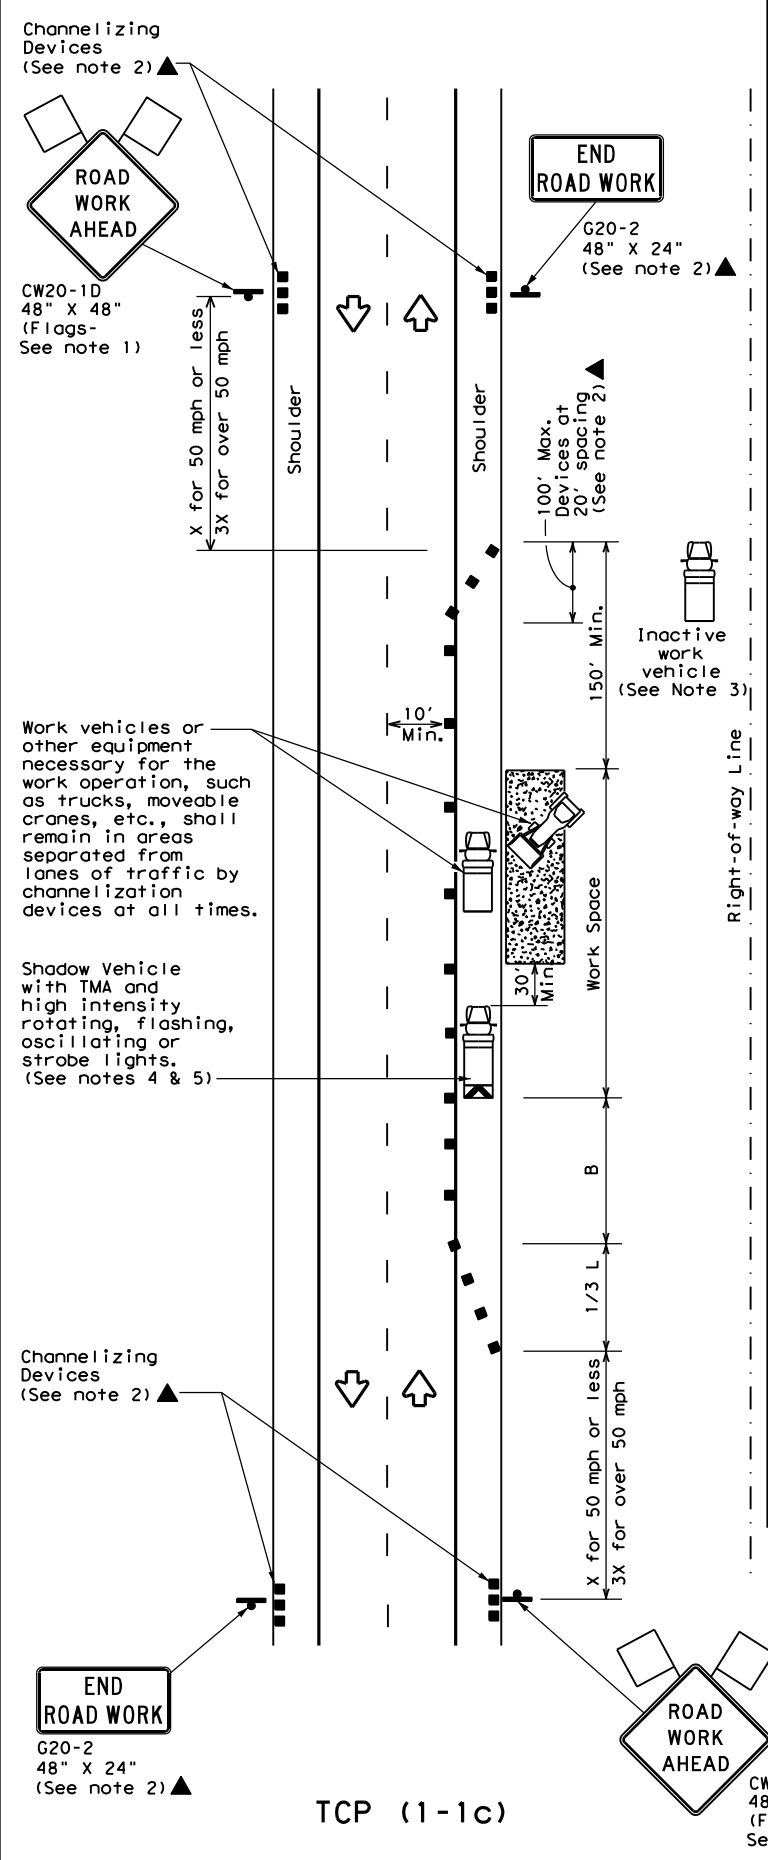

TCP (1-1c)

WORK VEHICLES ON SHOULDER
Conventional Roads

LEGEND			
	Type 3 Barricade		Channelizing Devices
	Heavy Work Vehicle		Truck Mounted Attenuator (TMA)
	Trailer Mounted Flashing Arrow Board		Portable Changeable Message Sign (PCMS)
	Sign		Traffic Flow
	Flag		Flagger

Posted Speed *	Formula	Minimum Desirable Taper Lengths **			Suggested Maximum Spacing of Channelizing Devices		Minimum Sign Spacing "X" Distance	Suggested Longitudinal Buffer Space "B"
		10' Offset	11' Offset	12' Offset	On a Taper	On a Tangent		
30	$L = \frac{WS^2}{60}$	150'	165'	180'	30'	60'	120'	90'
35		205'	225'	245'	35'	70'	160'	120'
40		265'	295'	320'	40'	80'	240'	155'
45	L = WS	450'	495'	540'	45'	90'	320'	195'
50		500'	550'	600'	50'	100'	400'	240'
55		550'	605'	660'	55'	110'	500'	295'
60		600'	660'	720'	60'	120'	600'	350'
65		650'	715'	780'	65'	130'	700'	410'
70		700'	770'	840'	70'	140'	800'	475'
75		750'	825'	900'	75'	150'	900'	540'

* Conventional Roads Only
** Taper lengths have been rounded off.
L=Length of Taper (FT) W=Width of Offset (FT) S=Posted Speed (MPH)

TYPICAL USAGE				
MOBILE	SHORT DURATION	SHORT TERM STATIONARY	INTERMEDIATE TERM STATIONARY	LONG TERM STATIONARY
	<input checked="" type="checkbox"/>	<input checked="" type="checkbox"/>		

GENERAL NOTES



- 1. Flags attached to signs where shown are REQUIRED.
- 2. All traffic control devices illustrated are REQUIRED, except those denoted with the triangle symbol may be omitted when stated elsewhere in the plans, or for routine maintenance work, when approved by the Engineer.
- 3. Inactive work vehicles or other equipment should be parked near the right-of-way line and not parked on the paved shoulder.
- 4. A Shadow Vehicle with a TMA should be used anytime it can be positioned 30 to 100 feet in advance of the area of crew exposure without adversely affecting the performance or quality of the work. If workers are no longer present but road or work conditions require the traffic control to remain in place, Type 3 Barricades or other channelizing devices may be substituted for the Shadow Vehicle and TMA.
- 5. Additional Shadow Vehicles with TMAs may be positioned off the paved surface, next to those shown in order to protect wider work spaces.
- 6. See TCP(5-1) for shoulder work on divided highways, expressways and freeways.
- 7. CW21-5 "SHOULDER WORK" signs may be used in place of CW20-1D "ROAD WORK AHEAD" signs for shoulder work on conventional roadways.

TRAFFIC CONTROL PLAN
CONVENTIONAL ROAD
SHOULDER WORK

TCP(1-1)-18

FILE: tcp1-1-18.dgn	DN:	CK:	DW:	CK:
© TxDOT December 1985	CONT	SECT	JOB	HIGHWAY
REVISIONS	2311	01	044	FM 3051
2-94 4-98	DIST	COUNTY	SHEET NO.	
8-95 2-12	WAC	MCLENNAN	21	
1-97 2-18				

DISCLAIMER: The use of this standard is governed by the "Texas Engineering Practice Act". No warranty of any kind is made by TxDOT for any purpose whatsoever. TxDOT assumes no responsibility for the conversion of units or the use of this standard in any project. WAC Design Project: 10/5/2022 11:58:00 AM FILE: \\txdot\project\wiseonline.com\TXDOT13\Documents\09 - WAC\Design Project\10/5/2022 11:58:00 AM

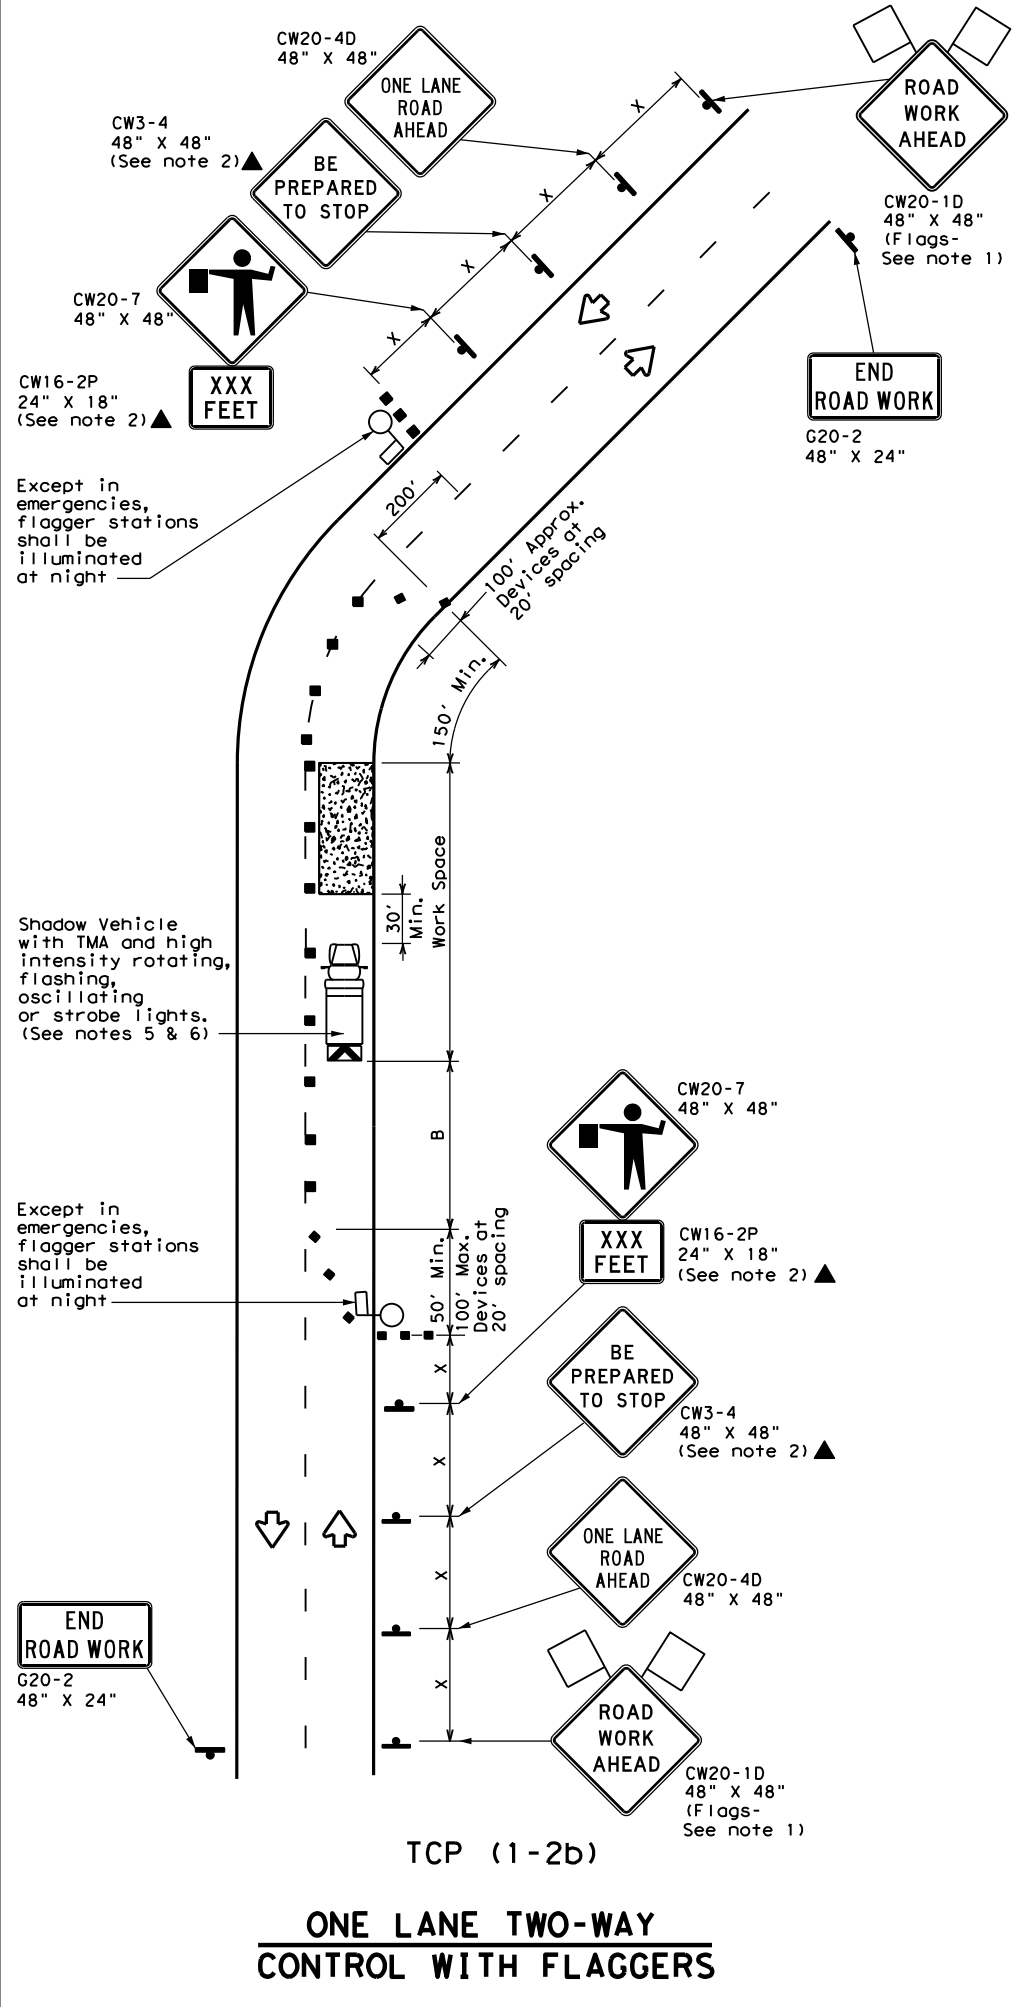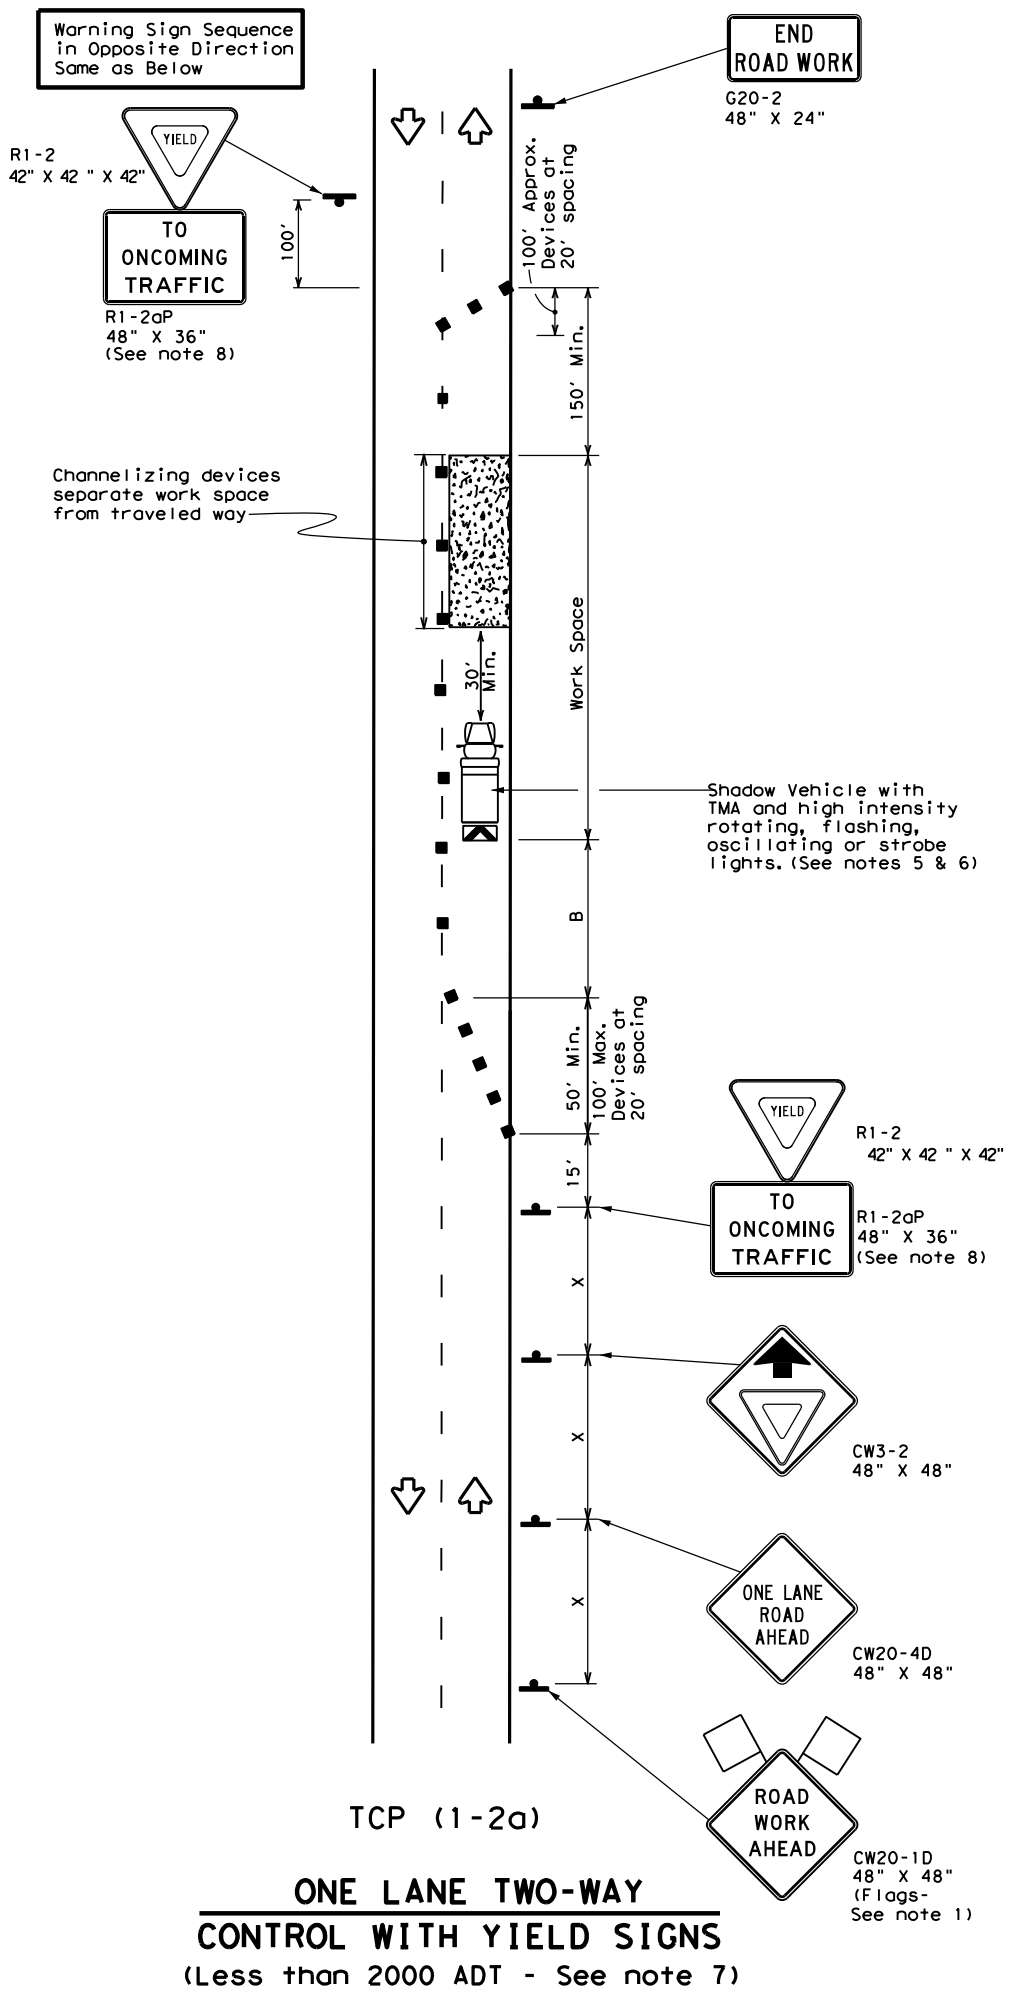

LEGEND

	Type 3 Barricade		Channelizing Devices
	Heavy Work Vehicle		Truck Mounted Attenuator (TMA)
	Trailer Mounted Flashing Arrow Board		Portable Changeable Message Sign (PCMS)
	Sign		Traffic Flow
	Flag		Flagger

Posted Speed *	Formula	Minimum Desirable Taper Lengths **			Suggested Maximum Spacing of Channelizing Devices		Minimum Sign Spacing "x" Distance	Suggested Longitudinal Buffer Space "B"	Stopping Sight Distance
		10' Offset	11' Offset	12' Offset	On a Taper	On a Tangent			
30	L = WS ² / 60	150'	165'	180'	30'	60'	120'	90'	200'
35		205'	225'	245'	35'	70'	160'	120'	250'
40		265'	295'	320'	40'	80'	240'	155'	305'
45	L = WS	450'	495'	540'	45'	90'	320'	195'	360'
50		500'	550'	600'	50'	100'	400'	240'	425'
55		550'	605'	660'	55'	110'	500'	295'	495'
60		600'	660'	720'	60'	120'	600'	350'	570'
65		650'	715'	780'	65'	130'	700'	410'	645'
70	700'	770'	840'	70'	140'	800'	475'	730'	
75	750'	825'	900'	75'	150'	900'	540'	820'	

* Conventional Roads Only
 ** Taper lengths have been rounded off.
 L=Length of Taper (FT) W=Width of Offset (FT) S=Posted Speed (MPH)

TYPICAL USAGE

MOBILE	SHORT DURATION	SHORT TERM STATIONARY	INTERMEDIATE TERM STATIONARY	LONG TERM STATIONARY
	✓	✓		

GENERAL NOTES

- Flags attached to signs where shown are REQUIRED.
 - All traffic control devices illustrated are REQUIRED, except those denoted with the triangle symbol may be omitted when stated elsewhere in the plans, or for routine maintenance work, when approved by the Engineer.
 - The CW3-4 "BE PREPARED TO STOP" sign may be installed after the CW20-4D "ONE LANE ROAD AHEAD" sign, but proper sign spacing shall be maintained.
 - Sign spacing may be increased or an additional CW20-1D "ROAD WORK AHEAD" sign may be used if advance warning ahead of the flagger or R1-2 "YIELD" sign is less than 150 feet.
 - A Shadow Vehicle with a TMA should be used anytime it can be positioned 30 to 100 feet in advance of the area of crew exposure without adversely affecting the performance or quality of the work. If workers are no longer present but road or work conditions require the traffic control to remain in place, Type 3 Barricades or other channelizing devices may be substituted for the Shadow Vehicle and TMA.
 - Additional Shadow Vehicles with TMAs may be positioned off the paved surface, next to those shown in order to protect wider work spaces.
- TCP (1-2a)**
- R1-2 "YIELD" sign traffic control may be used on projects with approaches that have adequate sight distance. For projects in urban areas, work spaces should be no longer than one half city block. In rural areas on roadways with less than 2000 ADT, work spaces should be no longer than 400 feet.
 - R1-2 "YIELD" sign with R1-2aP "TO ONCOMING TRAFFIC" plaque shall be placed on a support at a 7 foot minimum mounting height.
- TCP (1-2b)**
- Flaggers should use two-way radios or other methods of communication to control traffic.
 - Length of work space should be based on the ability of flaggers to communicate.
 - If the work space is located near a horizontal or vertical curve, the buffer distances should be increased in order to maintain adequate stopping sight distance to the flagger and a queue of stopped vehicles (see table above).
 - Channelizing devices on the center-line may be omitted when a pilot car is leading traffic and approved by the Engineer.
 - Flaggers should use 24" STOP/SLOW paddles to control traffic. Flags should be limited to emergency situations.

Texas Department of Transportation Traffic Operations Division Standard


TRAFFIC CONTROL PLAN
ONE-LANE TWO-WAY
TRAFFIC CONTROL

TCP (1-2) - 18

FILE: tcp1-2-18.dgn	DN:	CK:	DW:	CK:
© TxDOT December 1985	CON: 2311	SECT: 01	JOB: 044	HIGHWAY: FM 3051
4-90 4-98	REVISIONS		DIST: WAC	COUNTY: MCLENNAN
2-94 2-12				SHEET NO. 22
1-97 2-18				


DISCLAIMER: The use of this standard is governed by the "Texas Engineering Practice Act". No warranty of any kind is made by TxDOT for any purpose whatsoever. TxDOT assumes no responsibility for the conversion of units or for the accuracy of the information presented herein. The user of this standard is responsible for its use.

DATE: 10/5/2022 11:58:03 AM
 FILE: \\txdot.projectwiseonline.com:TXDOT3\Documents\09 - WAC\Design Projects\09-04-2022\09-04-2022.dgn

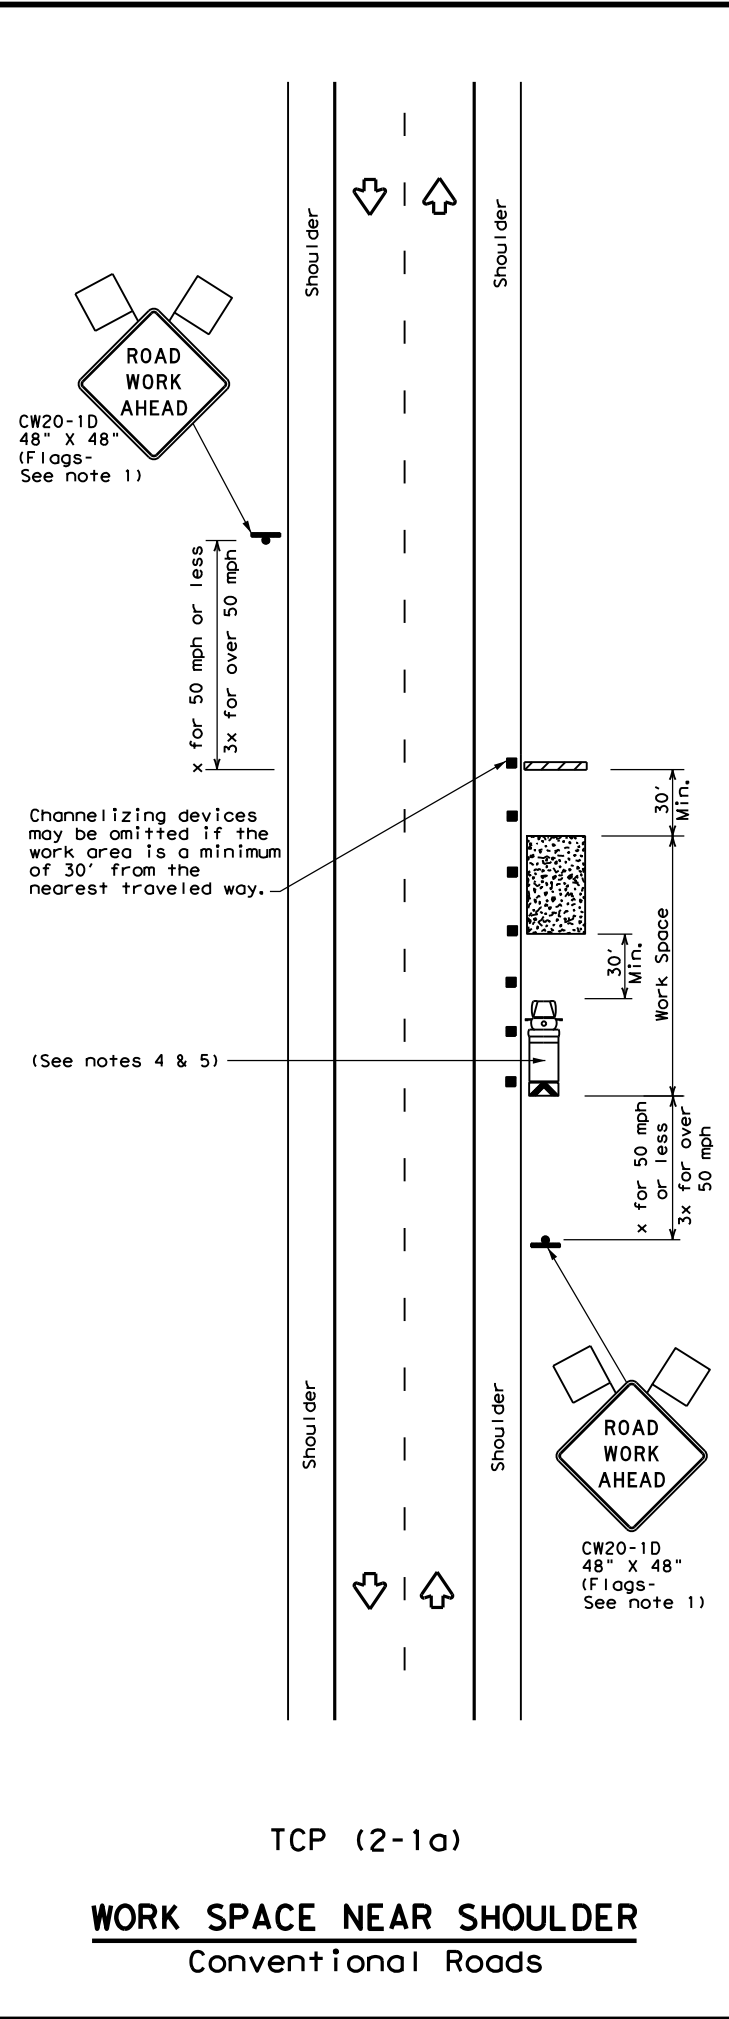


TCP (2-1a)

WORK SPACE NEAR SHOULDER
 Conventional Roads

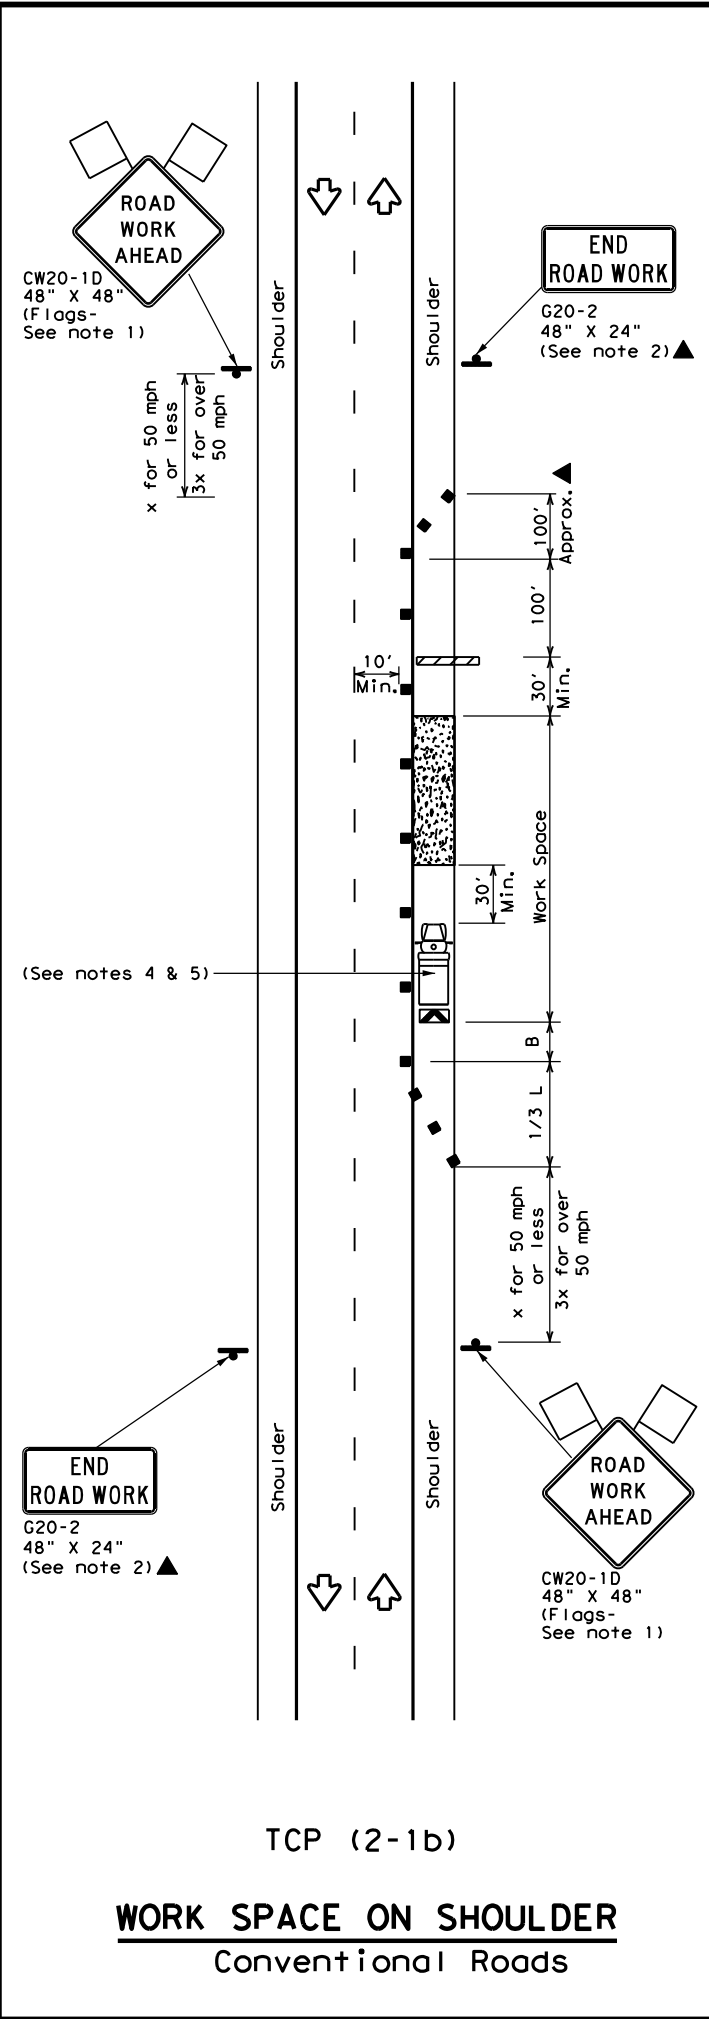

TCP (2-1b)

WORK SPACE ON SHOULDER
 Conventional Roads

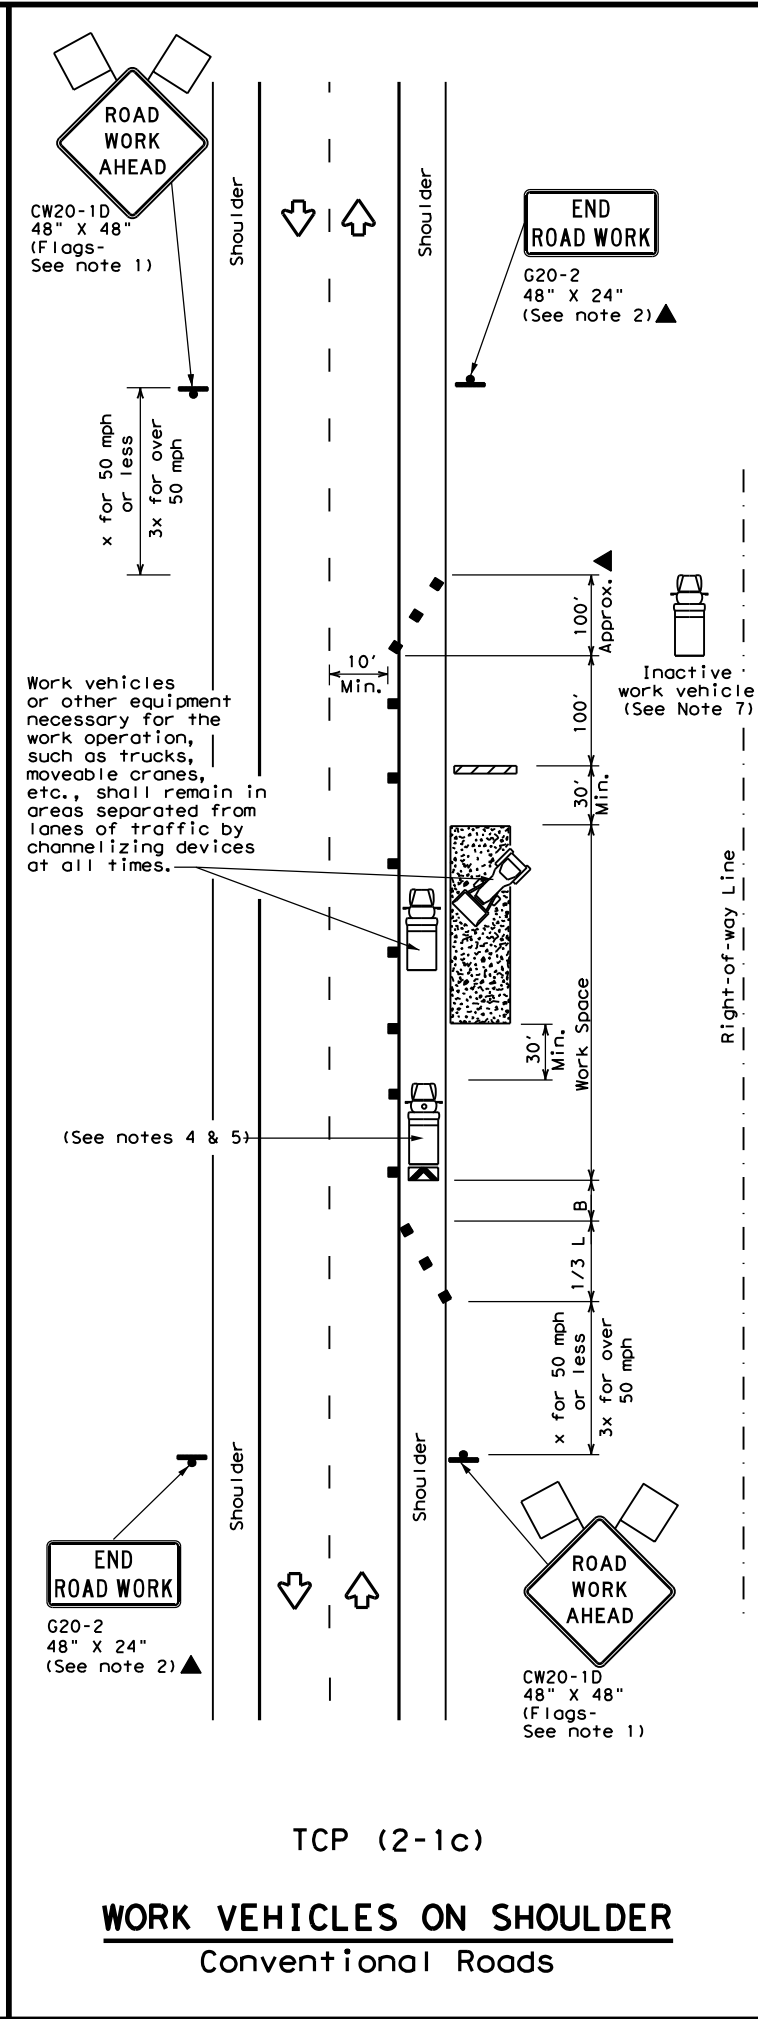

TCP (2-1c)

WORK VEHICLES ON SHOULDER
 Conventional Roads

LEGEND			
	Type 3 Barricade		Channelizing Devices
	Heavy Work Vehicle		Truck Mounted Attenuator (TMA)
	Trailer Mounted Flashing Arrow Board		Portable Changeable Message Sign (PCMS)
	Sign		Traffic Flow
	Flag		Flagger

Posted Speed *	Formula	Minimum Desirable Taper Lengths **			Suggested Maximum Spacing of Channelizing Devices		Minimum Sign Spacing "X" Distance	Suggested Longitudinal Buffer Space "B"
		10' Offset	11' Offset	12' Offset	On a Taper	On a Tangent		
30	$L = \frac{WS^2}{60}$	150'	165'	180'	30'	60'	120'	90'
35		205'	225'	245'	35'	70'	160'	120'
40		265'	295'	320'	40'	80'	240'	155'
45	$L = WS$	450'	495'	540'	45'	90'	320'	195'
50		500'	550'	600'	50'	100'	400'	240'
55		550'	605'	660'	55'	110'	500'	295'
60		600'	660'	720'	60'	120'	600'	350'
65		650'	715'	780'	65'	130'	700'	410'
70		700'	770'	840'	70'	140'	800'	475'
75		750'	825'	900'	75'	150'	900'	540'

* Conventional Roads Only
 ** Taper lengths have been rounded off.
 L=Length of Taper (FT) W=Width of Offset (FT) S=Posted Speed (MPH)

TYPICAL USAGE				
MOBILE	SHORT DURATION	SHORT TERM STATIONARY	INTERMEDIATE TERM STATIONARY	LONG TERM STATIONARY
	✓	✓	✓	✓

GENERAL NOTES

- Flags attached to signs where shown, are REQUIRED.
- All traffic control devices illustrated are REQUIRED, except those denoted with the triangle symbol may be omitted when stated in the plans, or for routine maintenance work, when approved by the Engineer.
- Stockpiled material should be placed a minimum of 30 feet from nearest traveled way.
- Shadow Vehicle with TMA and high intensity rotating, flashing, oscillating or strobe lights. A Shadow Vehicle with a TMA should be used anytime it can be positioned 30 to 100 feet in advance of the area of crew exposure without adversely affecting the performance or quality of the work. If workers are no longer present but road or work conditions require the traffic control to remain in place, Type 3 Barricades or other channelizing devices may be substituted for the Shadow Vehicle and TMA.
- Additional Shadow Vehicles with TMAs may be positioned off the paved surface, next to those shown in order to protect a wider work space.
- See TCP(5-1) for shoulder work on divided highways, expressways and freeways.
- Additional work vehicles or other equipment should be parked near the right-of-way line and not parked on the paved shoulder.
- CW21-5 "SHOULDER WORK" signs may be used in place of CW20-1D "ROAD WORK AHEAD" signs for shoulder work on conventional roadways.

Texas Department of Transportation
 Traffic Operations Division Standard



TRAFFIC CONTROL PLAN
CONVENTIONAL ROAD
SHOULDER WORK

TCP (2-1) - 18

FILE: tcp2-1-18.dgn	DN:	CK:	DW:	CK:
© TxDOT December 1985	CONT	SECT	JOB	HIGHWAY
REVISIONS	2311	01	044	FM 3051
2-94 4-98	DIST	COUNTY	SHEET NO.	
8-95 2-12	WAC	MCLENNAN	23	
1-97 2-18				

DISCLAIMER: The use of this standard is governed by the "Texas Engineering Practice Act". No warranty of any kind is made by TxDOT for any purpose whatsoever. TxDOT assumes no responsibility for the conversion of units or for the use of this standard for purposes other than those intended. See the project description for further details.

DATE: 10/5/2022 11:58:07 AM
 FILE: \\txdot\project\wiseon\line.com\TXDOT13\Documents\09 - WAC\Design\Projects\09-21-2022\09-21-2022-21-2022-21-2022.dgn

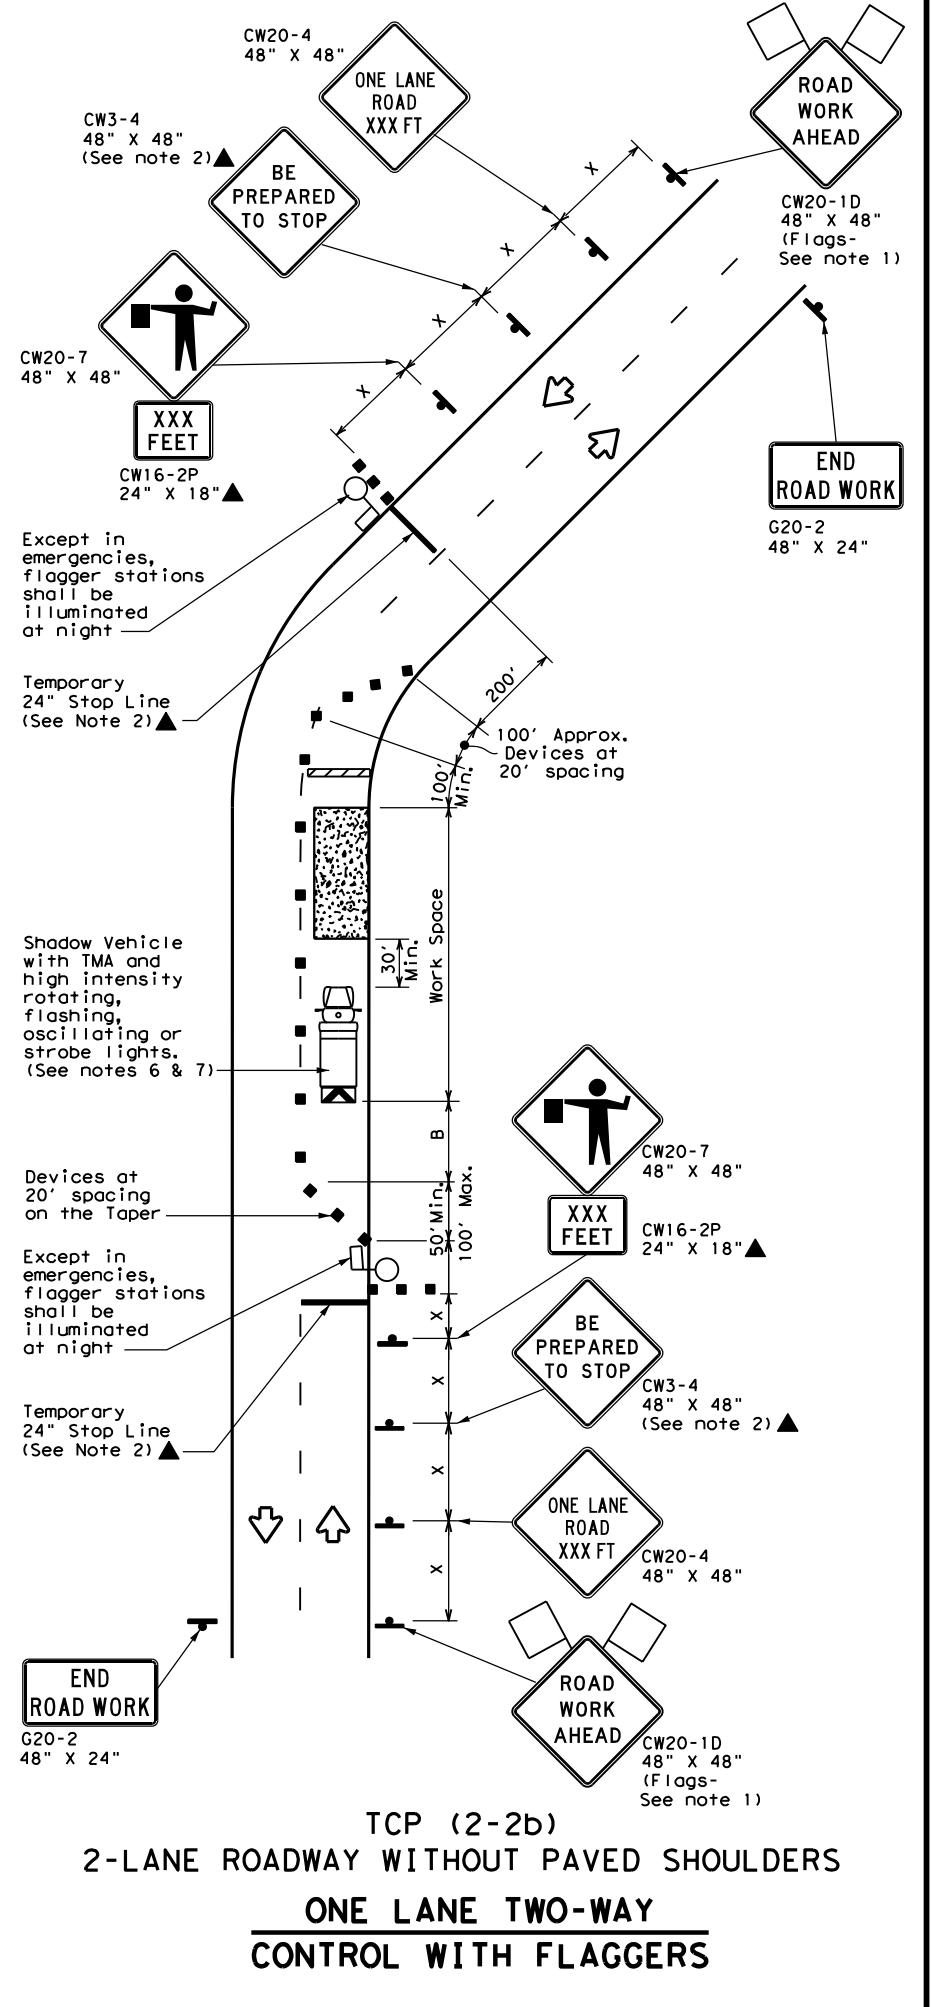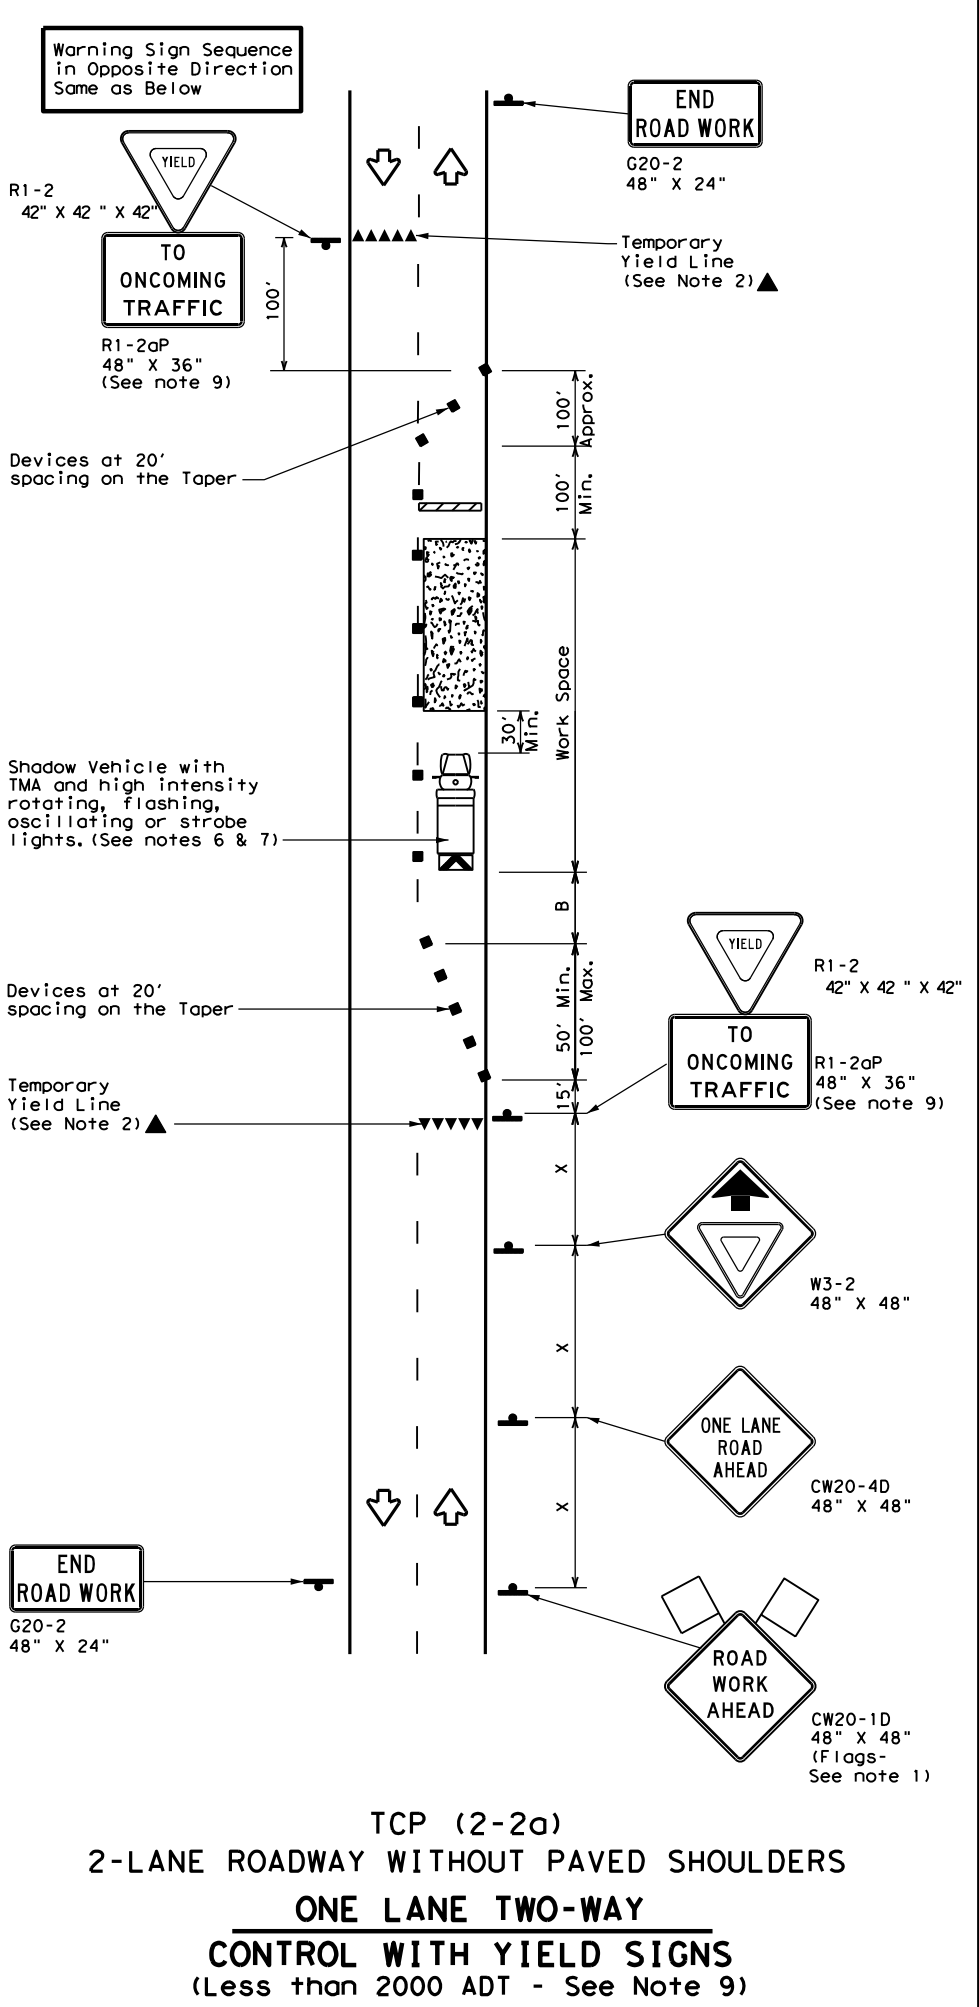

LEGEND

	Type 3 Barricade		Channelizing Devices
	Heavy Work Vehicle		Truck Mounted Attenuator (TMA)
	Trailer Mounted Flashing Arrow Board		Portable Changeable Message Sign (PCMS)
	Sign		Traffic Flow
	Flag		Flagger

Posted Speed *	Formula	Minimum Desirable Taper Lengths **			Suggested Maximum Spacing of Channelizing Devices		Minimum Sign Spacing "x" Distance	Suggested Longitudinal Buffer Space "B"	Stopping Sight Distance
		10' Offset	11' Offset	12' Offset	On a Taper	On a Tangent			
30	L = WS ² / 60	150'	165'	180'	30'	60'	120'	90'	200'
35		205'	225'	245'	35'	70'	160'	120'	250'
40		265'	295'	320'	40'	80'	240'	155'	305'
45	L = WS	450'	495'	540'	45'	90'	320'	195'	360'
50		500'	550'	600'	50'	100'	400'	240'	425'
55		550'	605'	660'	55'	110'	500'	295'	495'
60		600'	660'	720'	60'	120'	600'	350'	570'
65		650'	715'	780'	65'	130'	700'	410'	645'
70		700'	770'	840'	70'	140'	800'	475'	730'
75		750'	825'	900'	75'	150'	900'	540'	820'

* Conventional Roads Only
 ** Taper lengths have been rounded off.
 L=Length of Taper (FT) W=Width of Offset (FT) S=Posted Speed (MPH)

TYPICAL USAGE

MOBILE	SHORT DURATION	SHORT TERM STATIONARY	INTERMEDIATE TERM STATIONARY	LONG TERM STATIONARY
	✓	✓	✓	

- GENERAL NOTES**
- Flags attached to signs where shown, are REQUIRED.
 - All traffic control devices illustrated are REQUIRED, except those denoted with the triangle symbol may be omitted when stated elsewhere in the plans, or for routine maintenance work, when approved by the Engineer.
 - The CW3-4 "BE PREPARED TO STOP" sign may be installed after the CW20-4 "ONE LANE ROAD XXX FT" sign, but proper sign spacing shall be maintained.
 - Flaggers should use two-way radios or other methods of communication to control traffic.
 - Length of work space should be based on the ability of flaggers to communicate.
 - A Shadow Vehicle with a TMA should be used anytime it can be positioned 30 to 100 feet in advance of the area of crew exposure without adversely affecting the performance or quality of the work. If workers are no longer present but road or work conditions require the traffic control to remain in place, Type 3 Barricades or other channelizing devices may be substituted for the Shadow Vehicle and TMA.
 - Additional Shadow Vehicles with TMAs may be positioned off the paved surface, next to those shown in order to protect a wider work space.
- TCP (2-2a)**
- The R1-2 "YIELD" sign traffic control may be used on projects with approaches that have adequate sight distance. For projects in urban areas, work space should be no longer than one half city block. In rural areas, roadways with less than 2000 ADT, work space should be no longer than 400 feet.
 - The R1-2aP "YIELD TO ONCOMING TRAFFIC" sign shall be placed on a support at a 7 foot minimum mounting height.
- TCP (2-2b)**
- Channelizing devices on the center line may be omitted when a pilot car is leading traffic and approved by the Engineer.
 - If the work space is located near a horizontal or vertical curve, the buffer distances should be increased in order to maintain stopping sight distance to the flagger and a queue of stopped vehicles. (See table above).
 - Flaggers should use 24" STOP/SLOW paddles to control traffic. Flags should be limited to emergency situations.

Texas Department of Transportation
 Traffic Operations Division Standard

**TRAFFIC CONTROL PLAN
 ONE-LANE TWO-WAY
 TRAFFIC CONTROL**

TCP (2-2) - 18


FILE: tcp2-2-18.dgn	DN:	CK:	DW:	CK:
© TxDOT December 1985	CON: 2311	SECT: 01	JOB: 044	HIGHWAY: FM 3051
8-95 3-03	REVISIONS		DIST: COUNTY	SHEET NO.
1-97 2-12			WAC: MCLENNAN	24
4-98 2-18				

162


DATE: 10/5/2022 11:58:13 AM
 FILE: \\txdot\project\wiseonline.com:TXDOT13\Documents\09 - WAC\Design Projects\09044\09044.dwg
 DISCLAIMER: The use of this standard is governed by the "Texas Engineering Practice Act". No warranty of any kind is made by TxDOT for any purpose whatsoever. TxDOT assumes no responsibility for the conversion of units or the accuracy of the information provided herein. TxDOT reserves the right to change the standard without notice.

Warning sign and rumble strip sequence in opposite direction is same as below.

Flagger to Flagger (Length of Work Area)	ADT	# of Rumble Strip Arrays
1/8 Mile	< 4,500	1
	≥ 4,500	2
1/4 Mile	< 3,500	1
	≥ 3,500	2
1/2 Mile	< 2,600	1
	≥ 2,600	2
1 Mile	< 1,600	1
	≥ 1,600	2
> 1 Mile	N/A	2

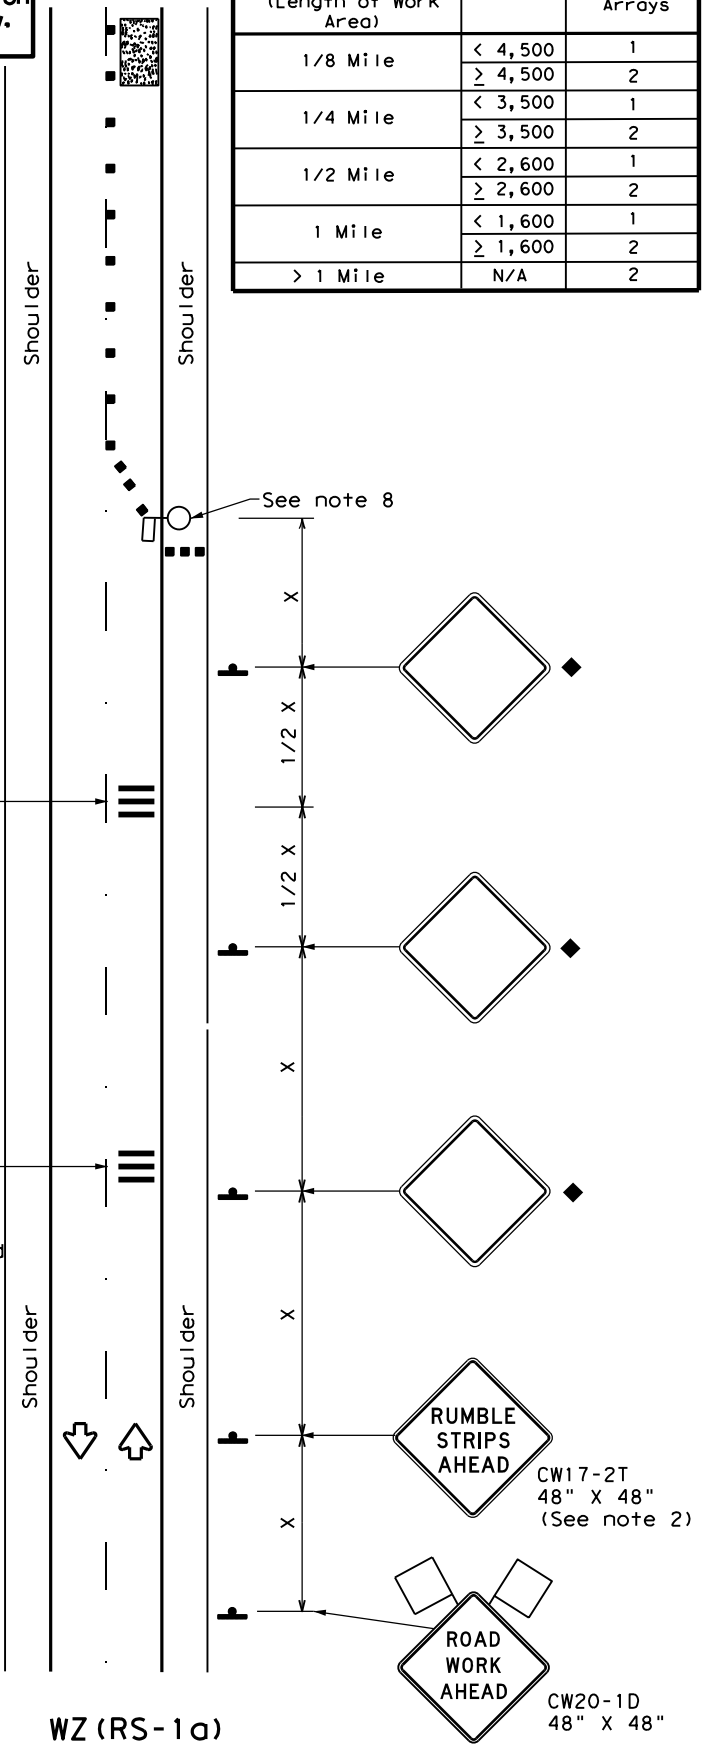

RUMBLE STRIPS ON ONE-LANE TWO-WAY APPLICATION

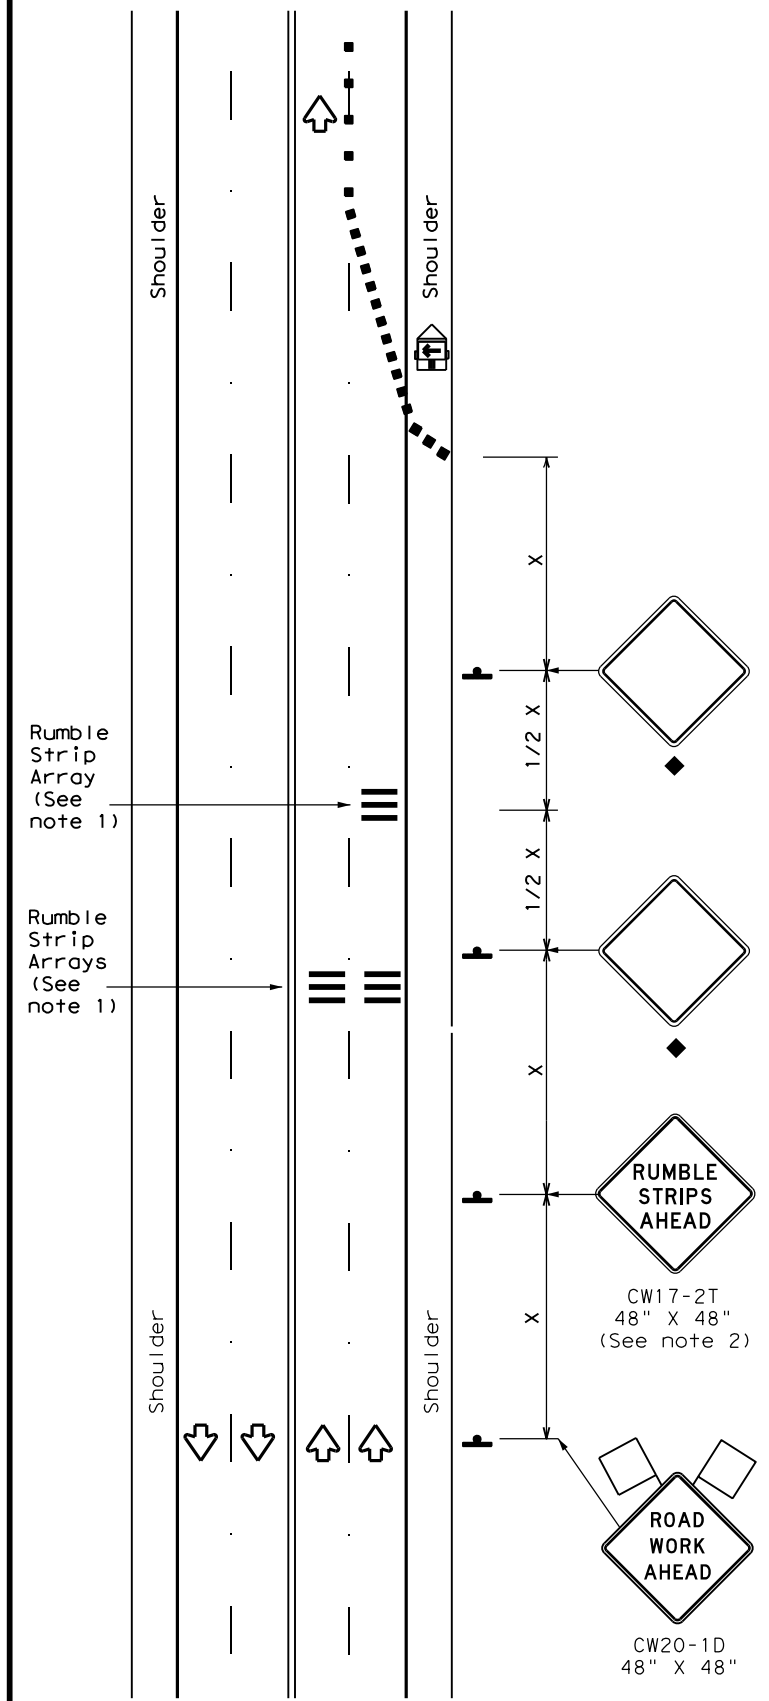

RUMBLE STRIPS FOR LANE CLOSURE ON CONVENTIONAL ROADWAY

GENERAL NOTES

- Each Rumble Strip Array should consist of three rumble strips spaced center to center at the spacing shown in Table 2, placed transverse across the lane at locations shown.
- The CW17-2T "RUMBLE STRIPS AHEAD" sign should be located after the CW20-1D "ROAD WORK AHEAD" sign and spaced as shown. If traffic is observed to be queuing, or is expected to queue beyond the Rumble Strips, the CW17-2T sign and the first Rumble Strip Array may be located upstream of the CW20-1D sign as necessary to provide needed warning.
- Temporary Rumble Strips will be considered subsidiary to Item 502, and shall be a product listed on the Compliant Work Zone Traffic Control Devices.
- Remove Temporary Rumble Strips before removing the advanced warning signs.
- Temporary Rumble Strips should not be used on horizontal curves, loose gravel, soft or bleeding asphalt, heavily rutted pavements or unpaved surfaces.
- Temporary Rumble Strips shall be installed and maintained as per manufacturer's recommendations.
- This standard sheet shall be used in conjunction with other appropriate TCP standard, TMUTCD typical application or project specific detail for the project.
- The one-lane two-way application may utilize a flagger, an Automated Flagger Assistance Device (AFAD) or a Portable Traffic Signal (PTS).
- Replace defective Temporary Rumble Strips as directed by the Engineer.
- Temporary Rumble Strips may be used on freeways or expressways based on engineering judgment and written direction from the Engineer.

Speed	Approximate distance between strips in an array
≤ 40 MPH	10'
> 40 MPH & ≤ 55 MPH	15'
= 60 MPH	20'
≥ 65 MPH	* 35' +

	Type 3 Barricade		Channelizing Devices
	Heavy Work Vehicle		Truck Mounted Attenuator (TMA)
	Trailer Mounted Flashing Arrow Panel		Portable Changeable Message Sign (PCMS)
	Sign		Traffic Flow
	Flag		Flagger

Posted Speed *	Formula	Minimum Desirable Taper Lengths **			Suggested Maximum Spacing of Channelizing Devices		Minimum Sign Spacing "X" Distance	Suggested Longitudinal Buffer Space "B"
		10' Offset	11' Offset	12' Offset	On a Taper	On a Tangent		
30	L = WS ² / 60	150'	165'	180'	30'	60'	120'	90'
35		205'	225'	245'	35'	70'	160'	120'
40		265'	295'	320'	40'	80'	240'	155'
45	L = WS	450'	495'	540'	45'	90'	320'	195'
50		500'	550'	600'	50'	100'	400'	240'
55		550'	605'	660'	55'	110'	500'	295'
60		600'	660'	720'	60'	120'	600'	350'
65		650'	715'	780'	65'	130'	700'	410'
70		700'	770'	840'	70'	140'	800'	475'
75		750'	825'	900'	75'	150'	900'	540'

* Conventional Roads Only
 ** Taper lengths have been rounded off.
 L=Length of Taper (FT) W=Width of Offset (FT)
 S=Posted Speed (MPH)

MOBILE	SHORT DURATION	SHORT TERM STATIONARY	INTERMEDIATE TERM STATIONARY	LONG TERM STATIONARY
	✓	✓		

◆ Signs are for illustrative purposes only. Signs required may vary depending on the TCP, TMUTCD Typical Application, or project specific details for the project.
 * For posted speeds in excess of 65 MPH, it is recommended that spacing is increased as speed limits increase. Increasing space between rumble strips will improve effectiveness.



Texas Department of Transportation
 Traffic Safety Division Standard

TEMPORARY RUMBLE STRIPS


WZ (RS) - 22

FILE: wzrs22.dgn	DN: TxDOT	CK: TxDOT	DW: TxDOT	CK: TxDOT
© TxDOT November 2012	CONT	SECT	JOB	HIGHWAY
REVISIONS	2311	01	044	FM 3051
2-14 1-22	DIST	COUNTY	SHEET NO.	
4-16	WAC	MCLENNAN	26	

pw: \\ttdot\projectwiseonline.com:TXDOT3\Documents\09 - WAC\Design Projects\231101044\4 - Design\Plan 138632022\roadway\Plan Sheets.dgn 8:39:55 PM
 NODE

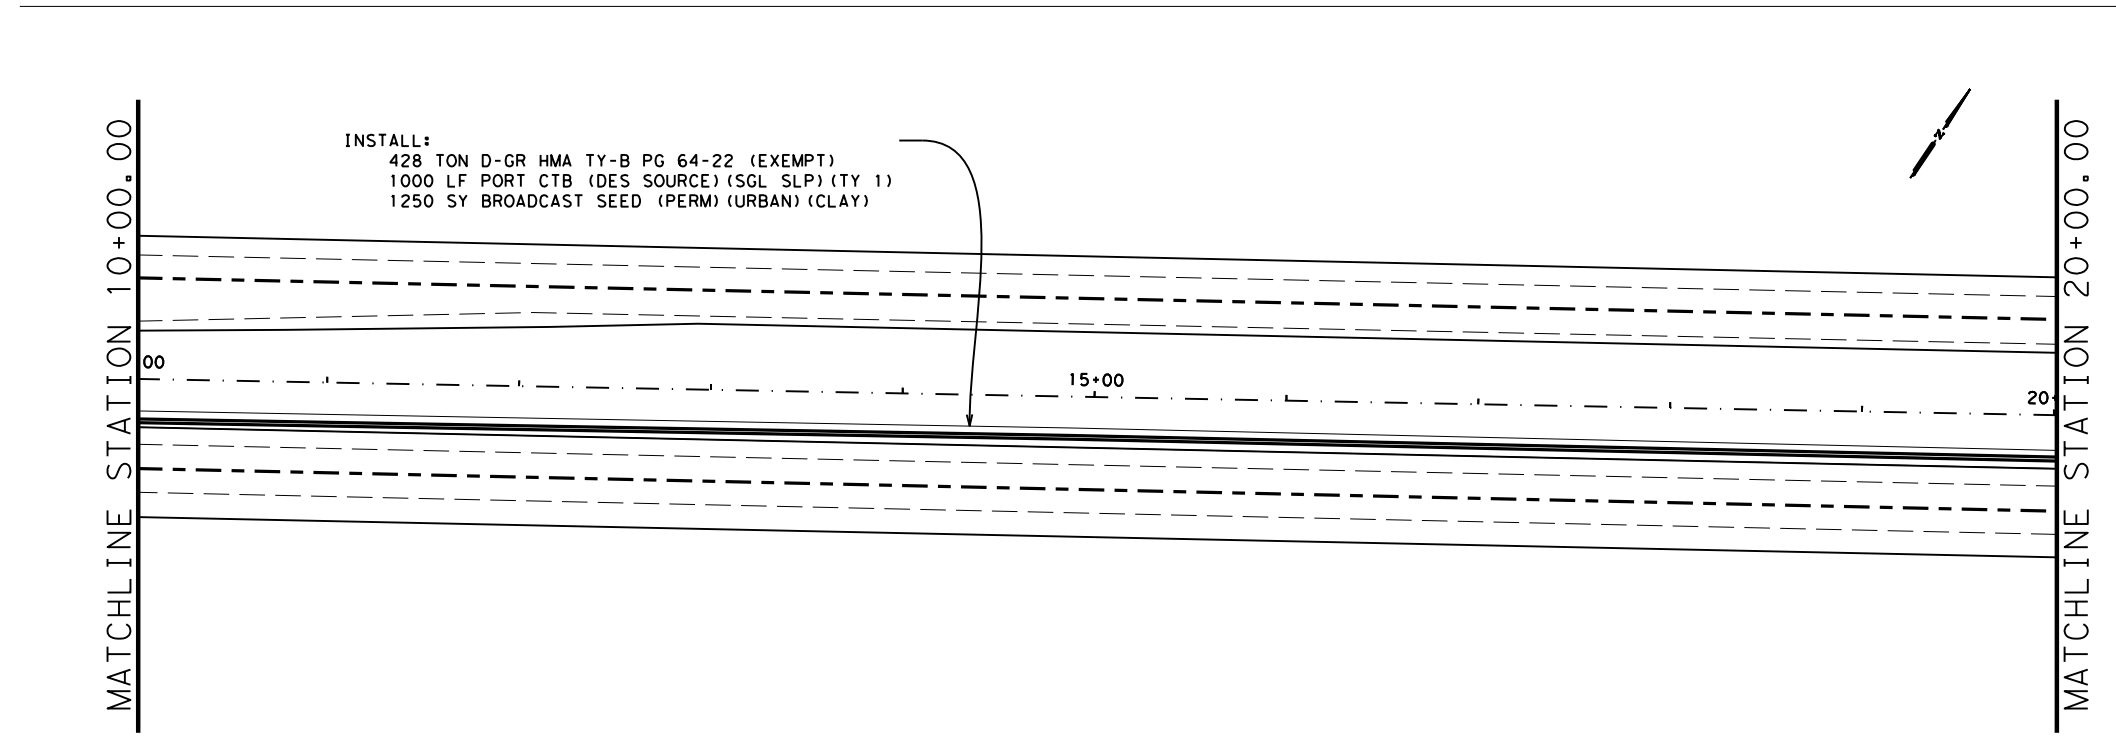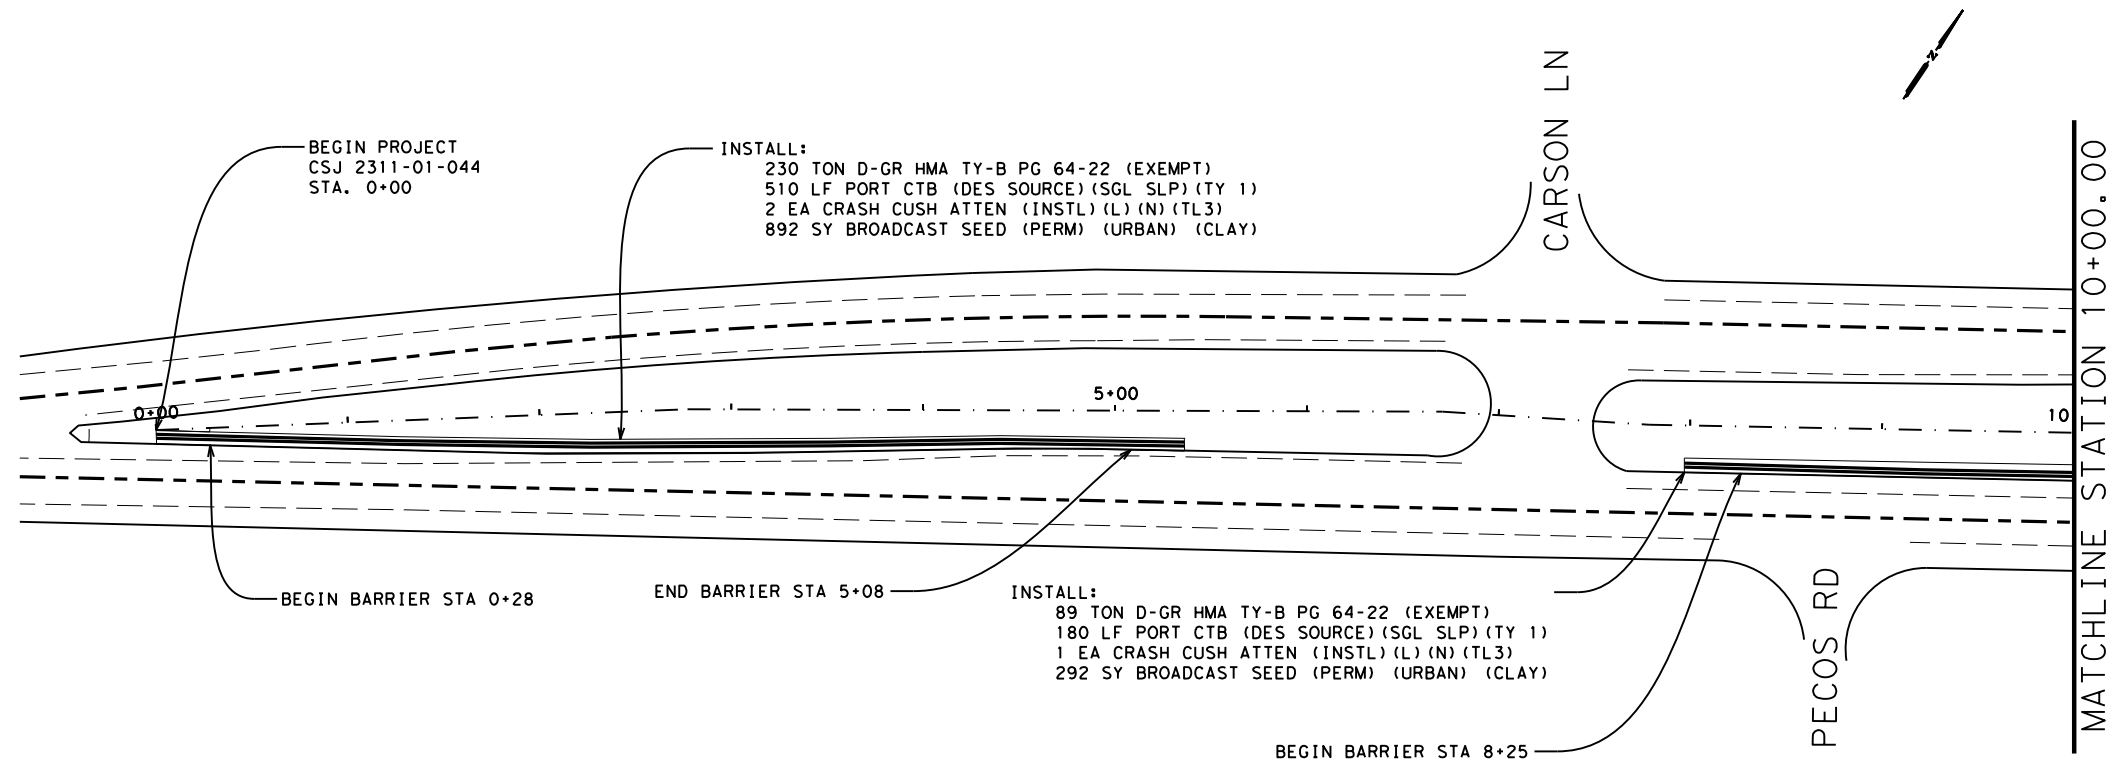

ITEM	DESCRIPTION	UNIT
0112 6001	SUBGRADE WIDENING (ORD COMP)	18.8 STA
0150 6001	BLADING	18.8 STA
0164 6007	BROADCAST SEED (PERM) (URBAN) (CLAY)	2434 SY
0427 6002	CONCRETE PAINT FINISH	15576 SF
0512 6013	PORT CTB (DES SOURCE) (SGL SLP) (TY 1)	1690 LF
0545 6007	CRASH CUSH ATTN (INSL) (L) (N) (TL3)	3 EA
3076 6003	D-GR HMA TY-B PG 64-22 (EXEMPT)	747 TON
3076 6066	TACK COAT	395 GAL

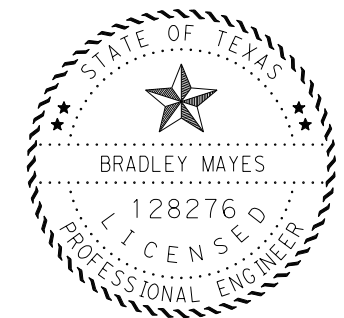

Bradley Mayes
 SIGNATURE OF REGISTRANT & DATE 10/26/2022



PLAN LAYOUT



SCALE: FEET
 1" = 100' HORIZ.

SHEET 1 OF 5

CHANGE ORDER	FED. RD. DIV. NO.	CONT	SECT	JOB	HIGHWAY
	6	2311	01	044	FM 3051
	STATE	DIST	COUNTY		SHEET NO.
	TEXAS	WAC	MCLENNAN		27

pw:\xtdot\projectwiseonline.com:TXDOT3\Documents\09 - WAC\Design Projects\Plan 1387632022\roadway\Plan Sheets.dgn 5:03:32 PM

NOTE

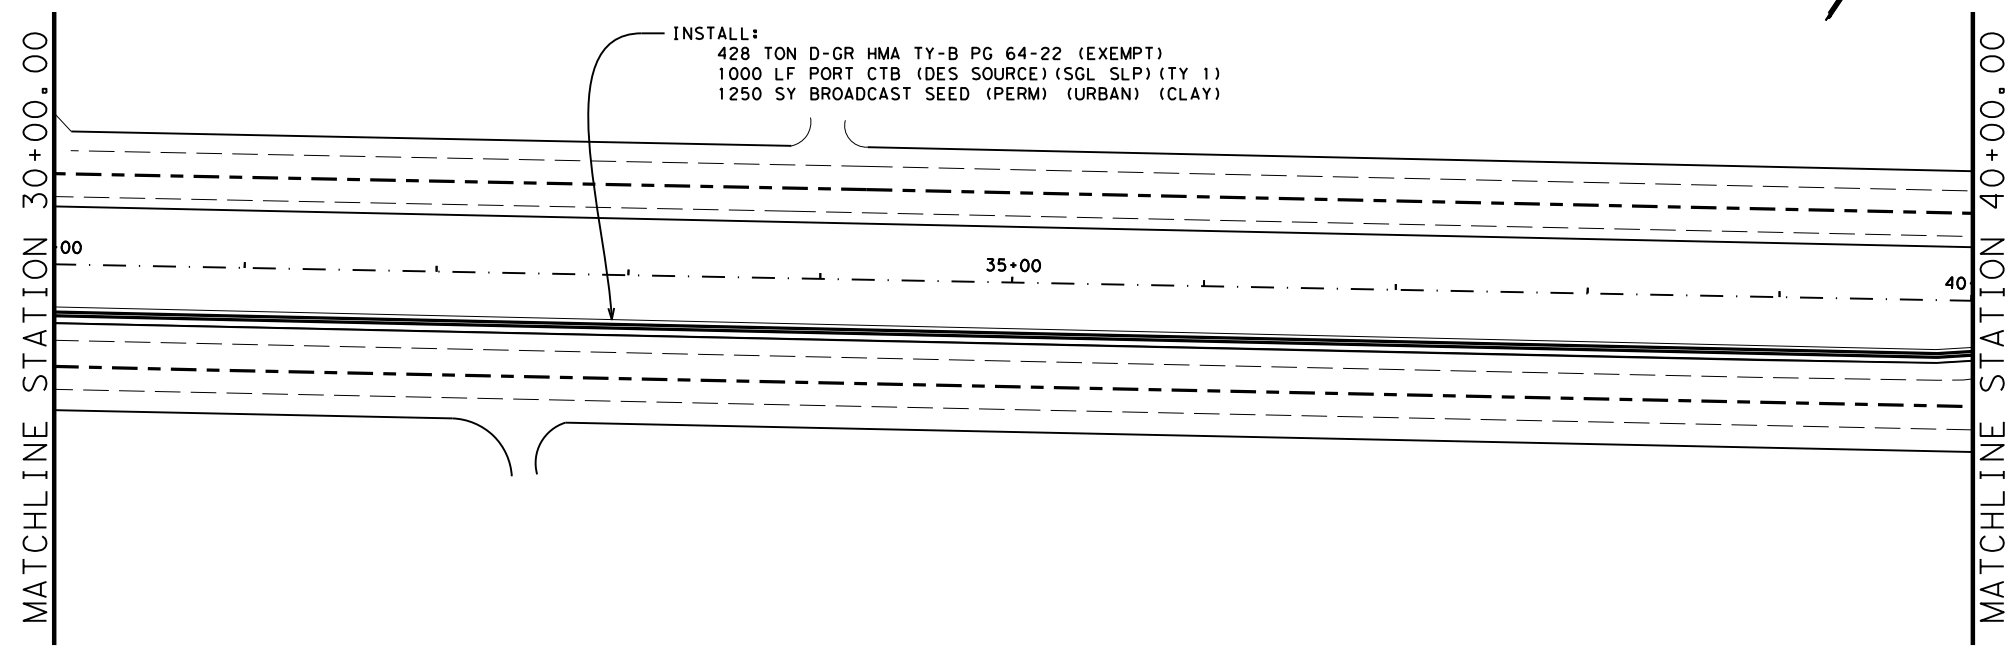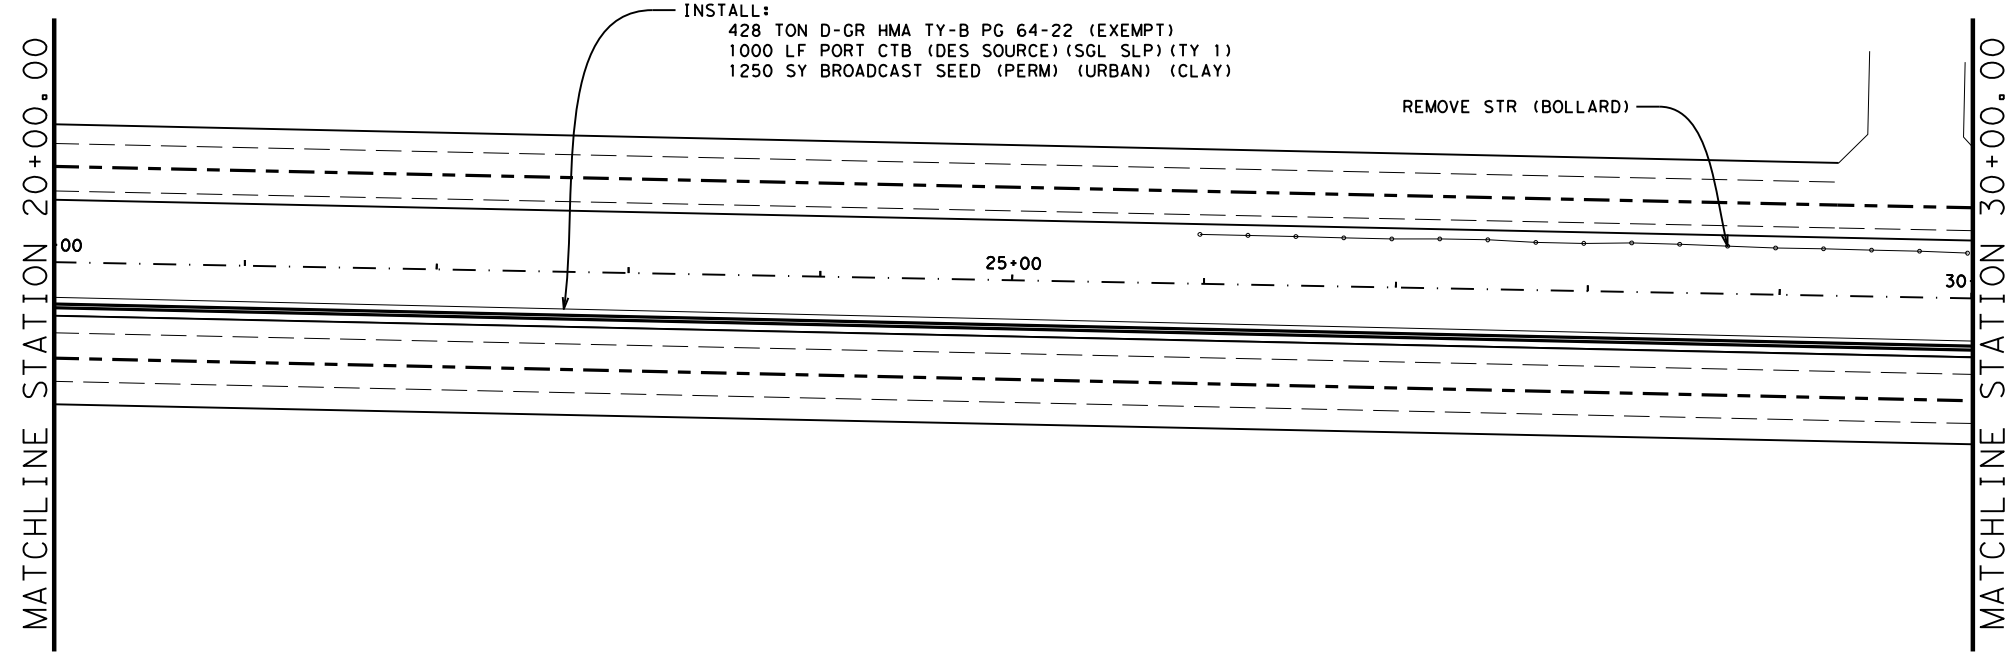

NOTES:

- ① POST & CABLE TO BE REMOVED AND PAID FOR UNDER REMOVE STR (BOLLARD)

ITEM	DESCRIPTION	UNIT
112 6001	SUBGRADE WIDENING (ORD COMP)	20 STA
0150 6001	BLADING	20 STA
0164 6007	BROADCAST SEED (PERM) (URBAN) (CLAY)	2500 SY
0427 6002	CONCRETE PAINT FINISH	16000 SF
0496 6030	REMOV STR (BOLLARD)	17 EA
0512 6013	PORT CTB (DES SOURCE) (SGL SLP) (TY 1)	2000 LF
0545 6007	CRASH CUSH ATTN (INSTR) (L) (N) (TL3)	0 EA
3076 6003	D-GR HMA TY-B PG 64-22 (EXEMPT)	856 TON
3076 6066	TACK COAT	466 GAL



Bradley Mayes 10/26/2022
SIGNATURE OF REGISTRANT & DATE





PLAN LAYOUT

SCALE: FEET
1" = 100' HORIZ.


SHEET 2 OF 5

CHANGE ORDER	FED. RD. DIV. NO.	CONT	SECT	JOB	HIGHWAY
	6	2311	01	044	FM 3051
	STATE	DIST	COUNTY		SHEET NO.
	TEXAS	WAC	MCLENNAN		28

pw:\xtdot\projectwiseonline.com:TXDOT3\Documents\09 - WAC\Design Projects\231101044\4 - Design\Plan 138632022\roadway\Plan Sheets.dgn 8:42:04 PM
 NODE

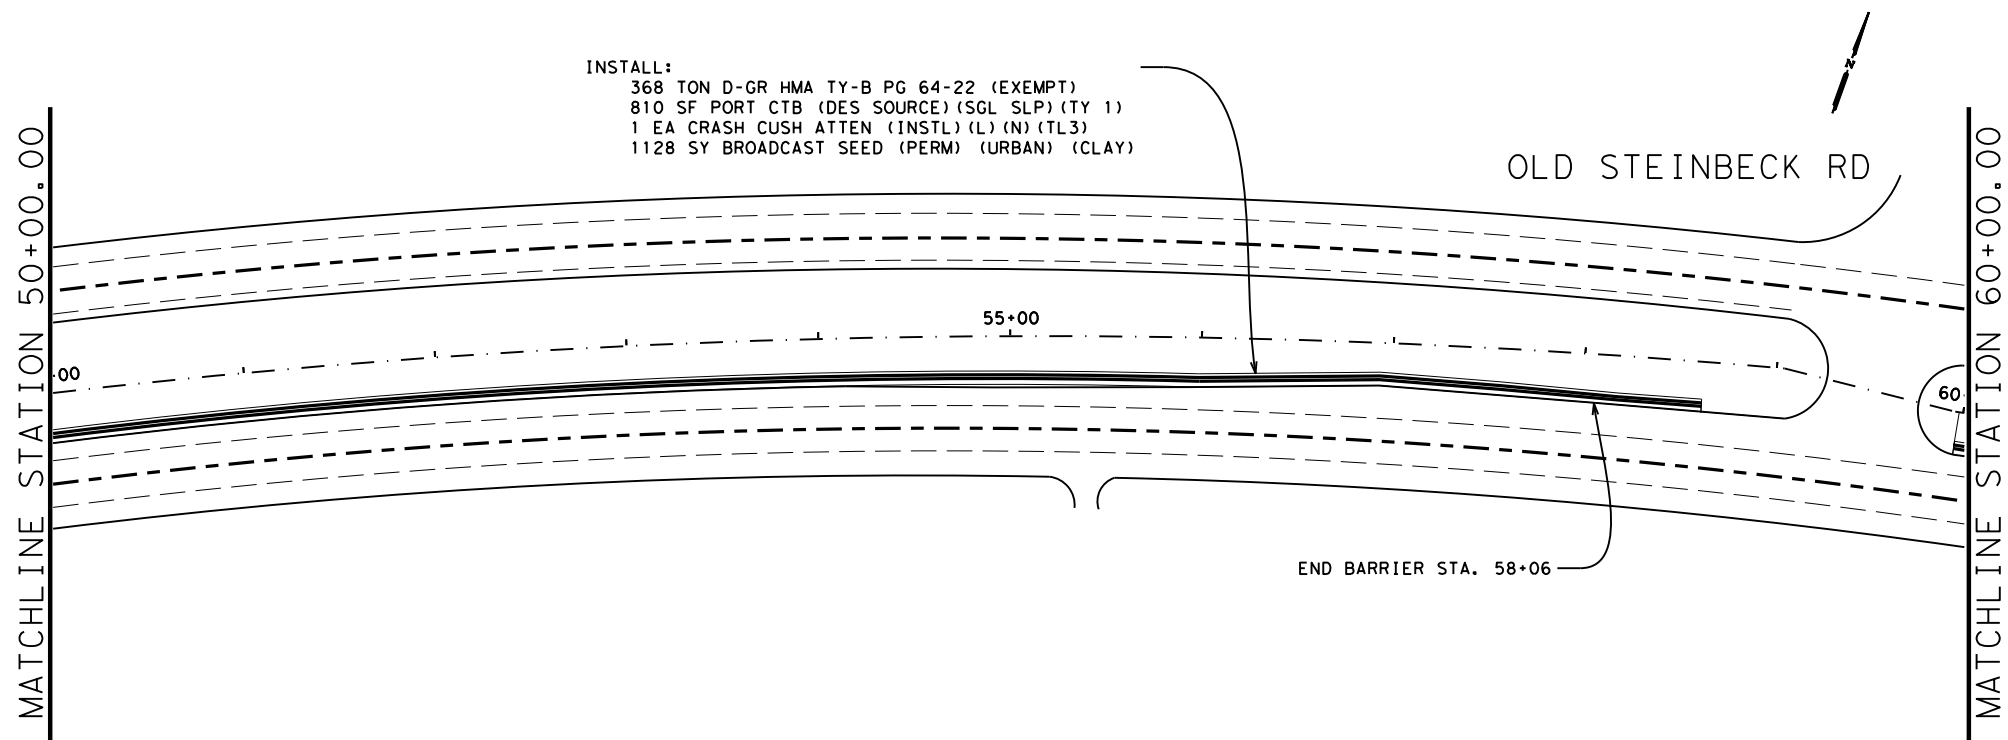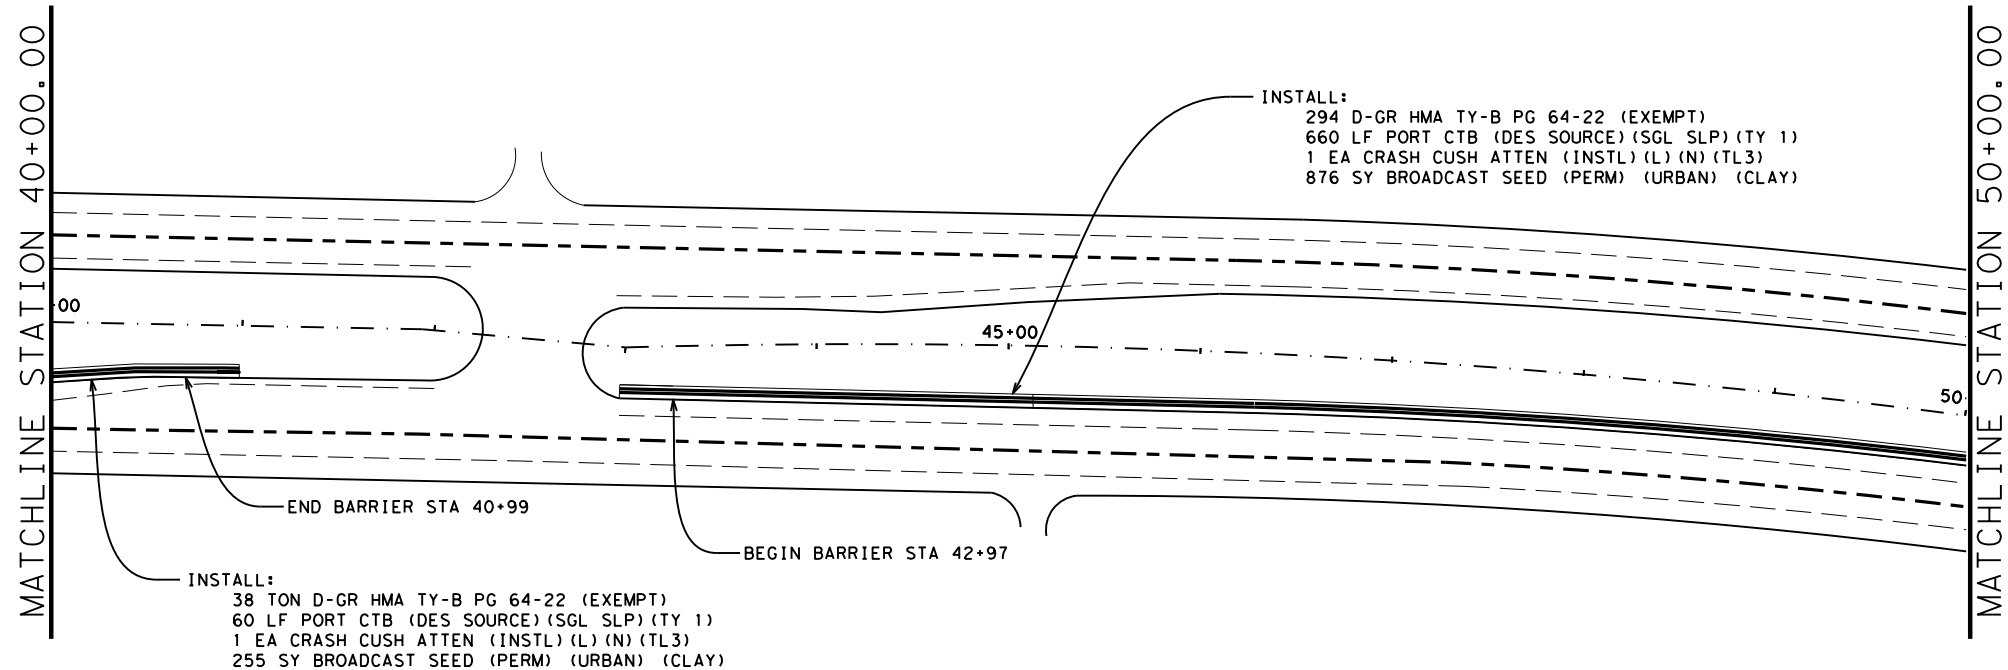

ITEM	DESCRIPTION	UNIT
112 6001	SUBGRADE WIDENING (ORD COMP)	17.4 STA
0150 6001	BLADING	17.4 STA
0164 6007	BROADCAST SEED (PERM) (URBAN) (CLAY)	2259 SY
0427 6002	CONCRETE PAINT FINISH	14456 SF
0543 6002	PORT CTB (DES SOURCE) (SGL SLP) (TY 1)	1530 LF
0543 6007	CRASH CUSH ATTN (INSL) (L) (N) (TL3)	3 EA
3076 6001	D-GR HMA TY-B PG 64-22 (EXEMPT)	700 TON
3076 6066	TACK COAT	406 GAL

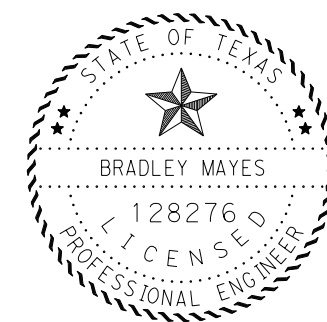

Bradley Mayes 10/26/2022
 SIGNATURE OF REGISTRANT & DATE



PLAN LAYOUT



SCALE: FEET
 1" = 100' HORIZ.

SHEET 3 OF 5


CHANGE ORDER	FED. RD. DIV. NO.	CONT	SECT	JOB	HIGHWAY
	6	2311	01	044	FM 3051
	STATE	DIST	COUNTY		SHEET NO.
	TEXAS	WAC	MCLENNAN		29

pw: \\txdot\projectwiseonline.com:TXDOT3\Documents\09 - WAC\Design Projects\231101044\4 - Design\Plan Sheets\2022\roadway\Plan Sheets.dgn 8:46:43 PM

NODE

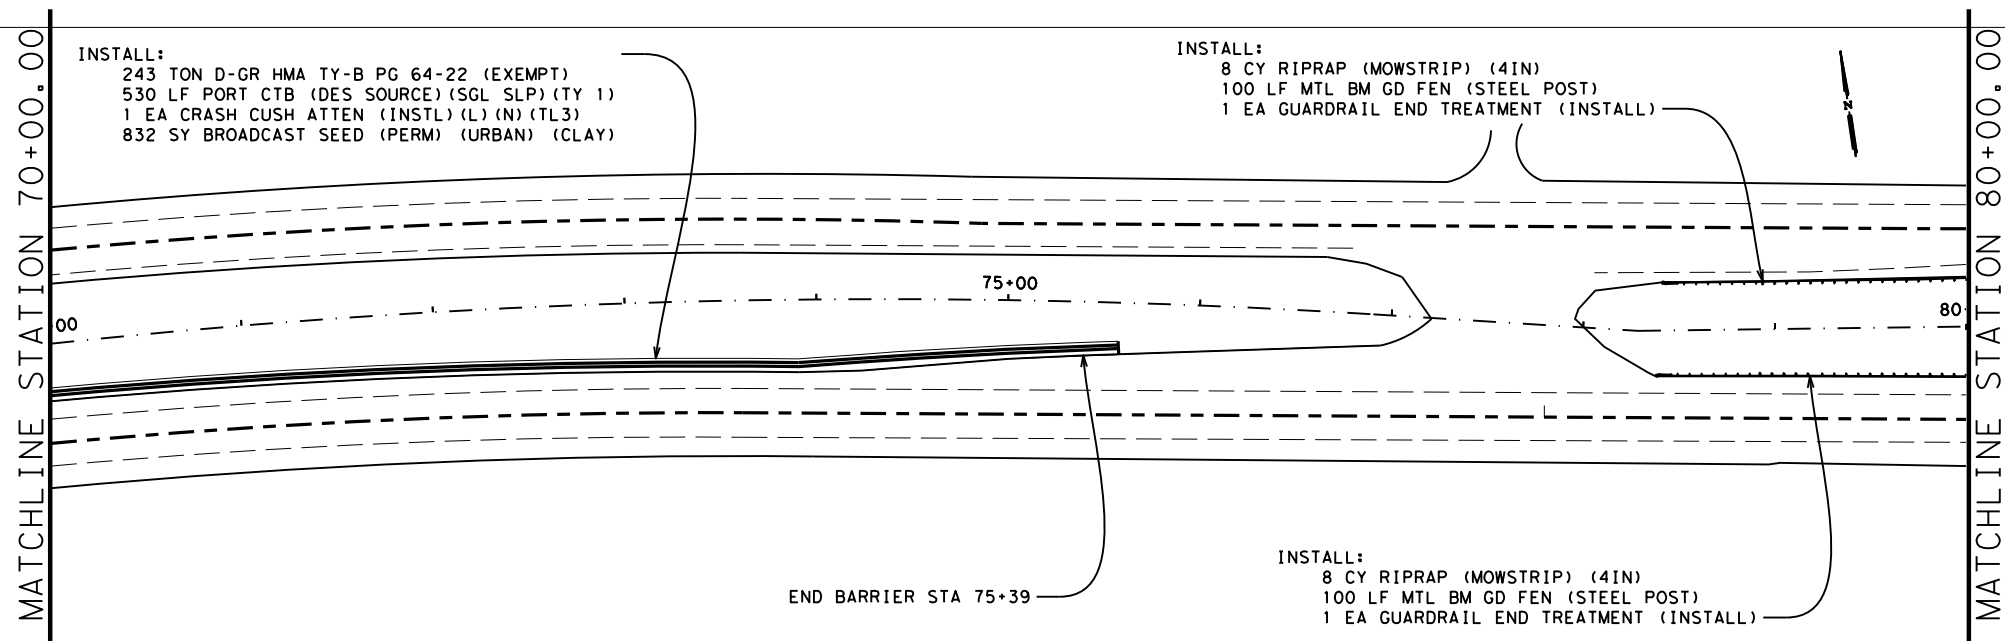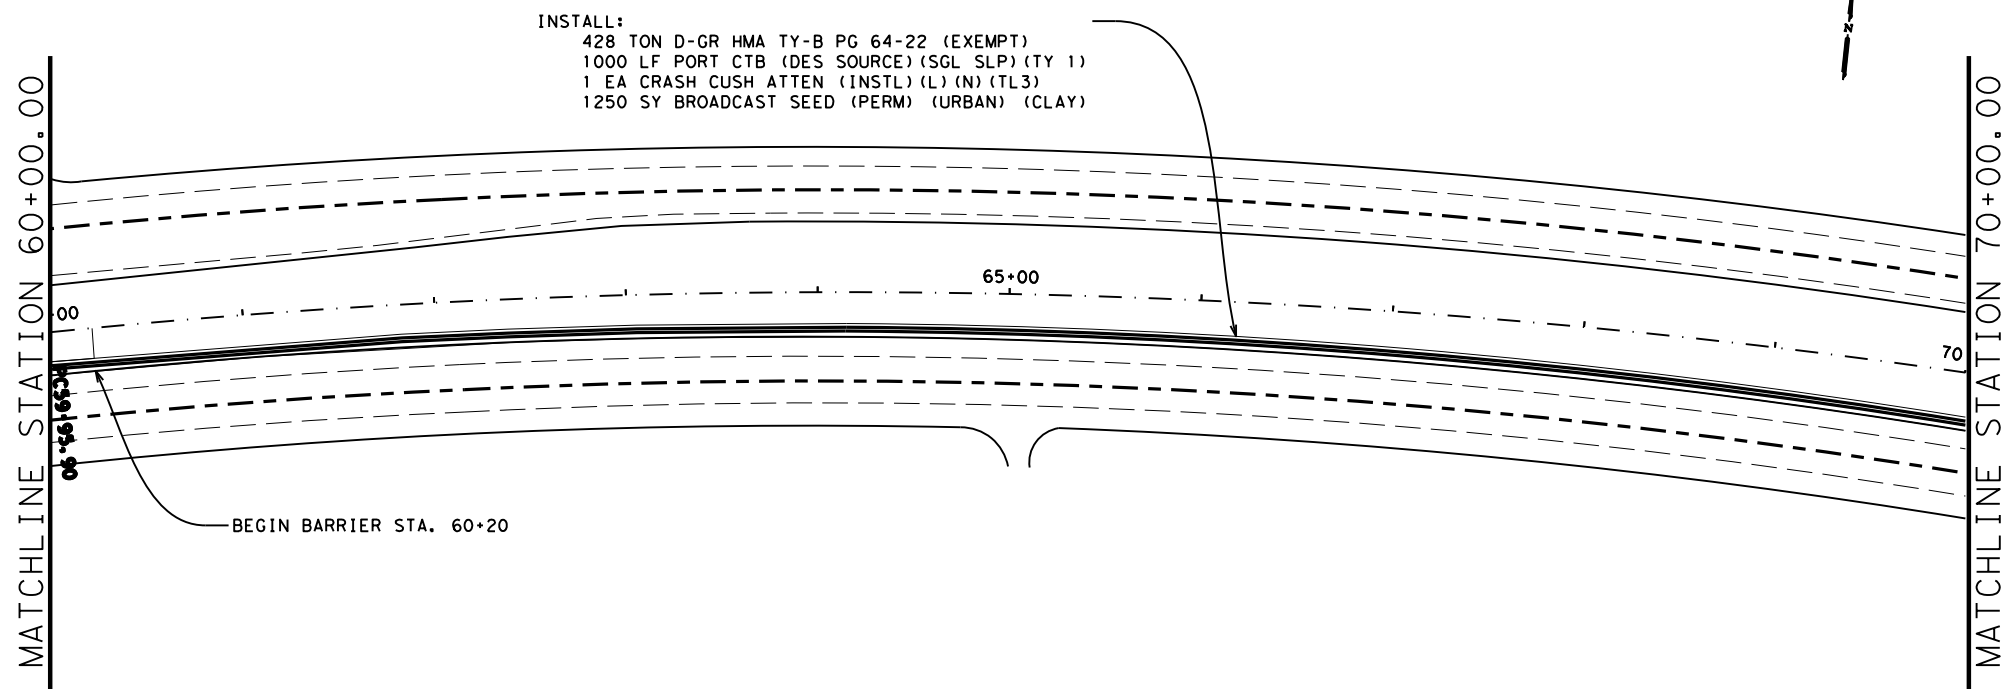

ITEM	DESCRIPTION	UNIT
112 6001	SUBGRADE WIDENING (ORD COMP)	16.7 STA
0150 6001	BLADING	16.7 STA
0164 6007	BROADCAST SEED (PERM) (URBAN) (CLAY)	2082 SY
0427 6002	CONCRETE PAINT FINISH	14600 SF
0432 6045	RIPRAP (MOWSTRIP) (4 IN)	16 CY
0540 6017	MTL BM GD FEN (STEEL POST)	200 LF
0512 6013	PORT CTB (DES SOURCE) (SGL SLP) (TY 1)	1530 LF
0545 6007	CRASH CUSH ATTN (INSL) (L) (N) (TL3)	2 EA
0544 6001	GUARDRAIL END TREATMENT (INSTALL)	2 EA
3076 6003	D-GR HMA TY-B PG 64-22 (EXEMPT)	671 TON
3076 6066	TACK COAT	390 GAL

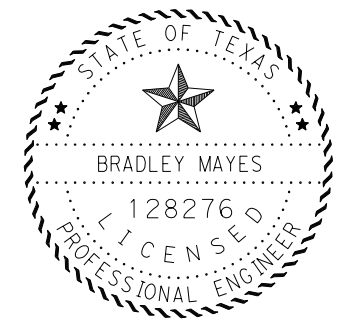

Bradley Mayes 10/26/2022
 SIGNATURE OF REGISTRANT & DATE



PLAN LAYOUT


SCALE: FEET
 1" = 100' HORIZ.

SHEET 4 OF 5

CHANGE ORDER	FED. RD. DIV. NO.	CONT	SECT	JOB	HIGHWAY
	6	2311	01	044	FM 3051
	STATE	DIST	COUNTY		SHEET NO.
	TEXAS	WAC	MCLENNAN		30

pw:\xtdot\projectwiseonline.com:TXDOT3\Documents\09 - WAC\Design Projects\231101044\4 - Design\Plan\2022\roadway\Plan Sheets.dgn 5:05:33 PM

MATCHLINE STATION 80+00.00

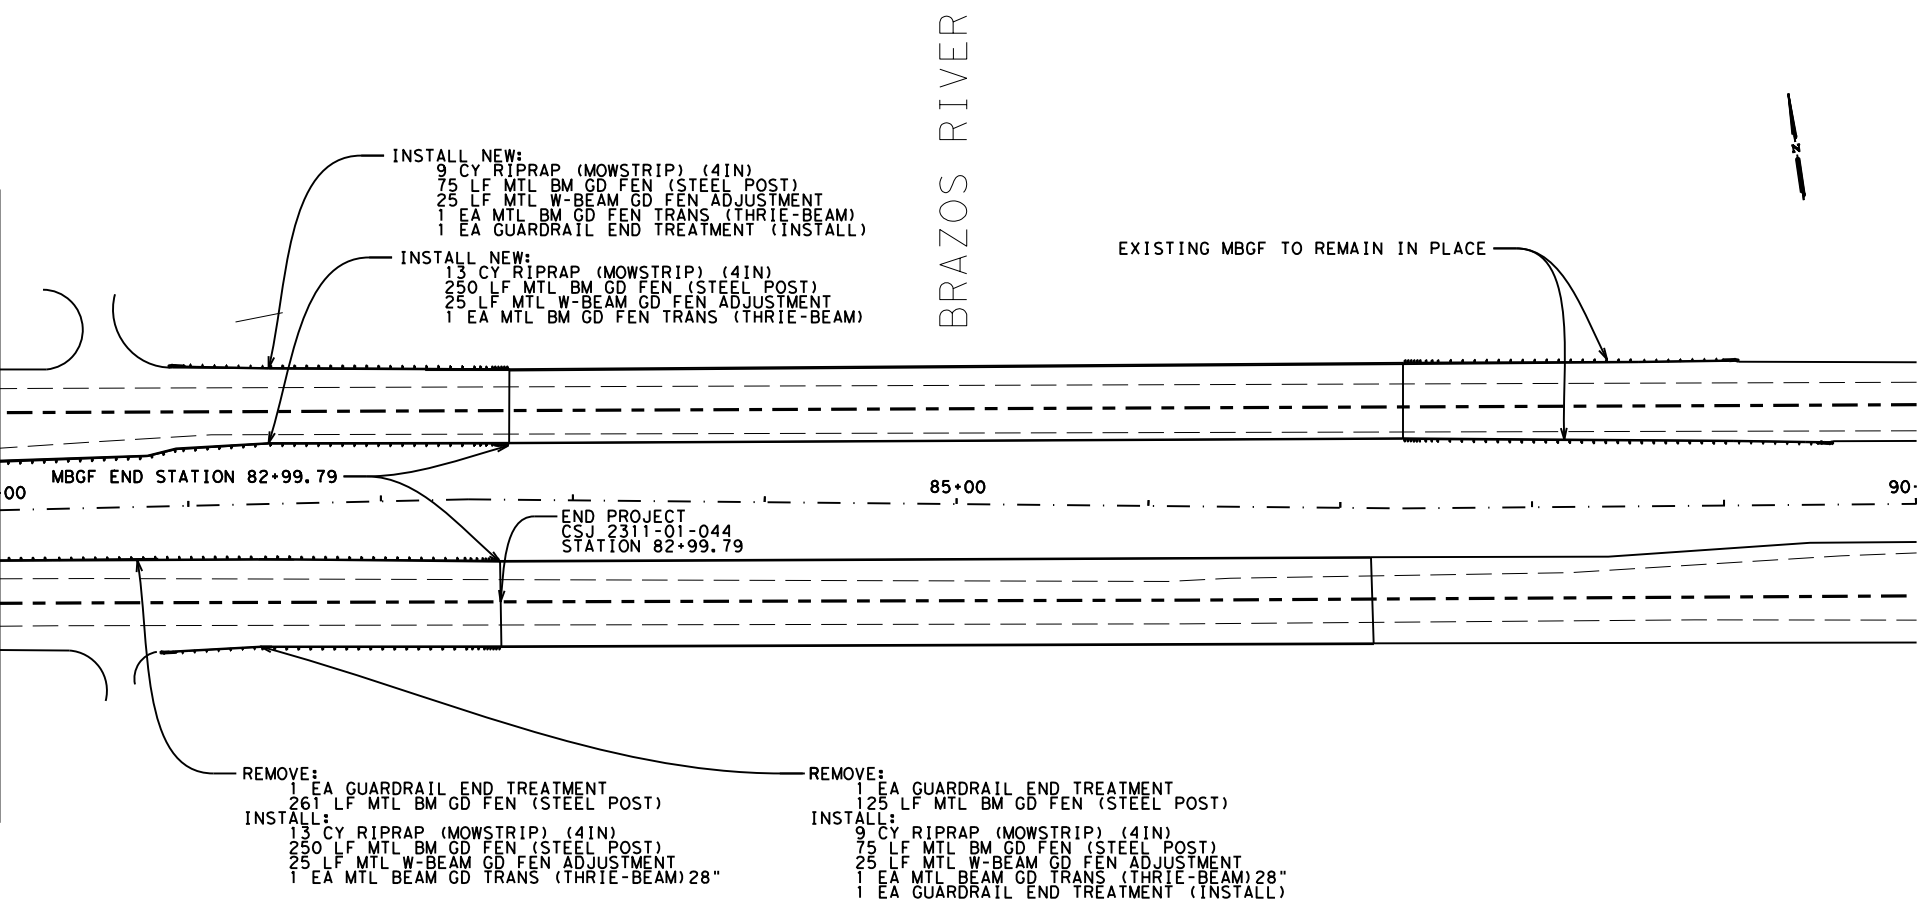

BRAZOS RIVER



INSTALL NEW:
 9 CY RIPRAP (MOWSTRIP) (4IN)
 75 LF MTL BM GD FEN (STEEL POST)
 25 LF MTL W-BEAM GD FEN ADJUSTMENT
 1 EA MTL BM GD FEN TRANS (THRIE-BEAM)
 1 EA GUARDRAIL END TREATMENT (INSTALL)

INSTALL NEW:
 13 CY RIPRAP (MOWSTRIP) (4IN)
 250 LF MTL BM GD FEN (STEEL POST)
 25 LF MTL W-BEAM GD FEN ADJUSTMENT
 1 EA MTL BM GD FEN TRANS (THRIE-BEAM)

EXISTING MBGF TO REMAIN IN PLACE

MBGF END STATION 82+99.79

85+00


90+00

END PROJECT
 CSJ 2311-01-044
 STATION 82+99.79

REMOVE:
 1 EA GUARDRAIL END TREATMENT
 261 LF MTL BM GD FEN (STEEL POST)
 INSTALL:
 13 CY RIPRAP (MOWSTRIP) (4IN)
 250 LF MTL BM GD FEN (STEEL POST)
 25 LF MTL W-BEAM GD FEN ADJUSTMENT
 1 EA MTL BEAM GD TRANS (THRIE-BEAM) 28"

REMOVE:
 1 EA GUARDRAIL END TREATMENT
 125 LF MTL BM GD FEN (STEEL POST)
 INSTALL:
 9 CY RIPRAP (MOWSTRIP) (4IN)
 75 LF MTL BM GD FEN (STEEL POST)
 25 LF MTL W-BEAM GD FEN ADJUSTMENT
 1 EA MTL BEAM GD TRANS (THRIE-BEAM) 28"
 1 EA GUARDRAIL END TREATMENT (INSTALL)

ITEM	DESCRIPTION	UNIT
0432 6045	RIPRAP (MOWSTRIP) (4 IN)	44 CY
0540 6006	MTL BM GD FEN TRANS (THRIE-BEAM)	2 EA
0540 6010	MTL W-BEAM GD FEN ADJUSTMENT	100 LF
0540 6017	MTL W-BEAM GD FEN (STEEL POST)	650 LF
0540 6023	MTL BM GD FEN TRANS (THRIE-BEAM) 28"	2 EA
0544 6001	GUARDRAIL END TREATMENT (INSTALL)	2 EA
0544 6003	GUARDRAIL END TREATMENT (REMOVE)	2 EA
0562 6001	REMOVE MEAL BEAM GUARD FENCE	386 LF

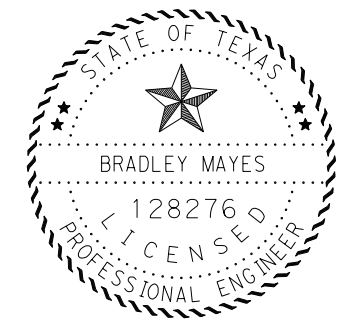

Bradley Mayes 10/26/2022
 SIGNATURE OF REGISTRANT & DATE




PLAN LAYOUT

SCALE: FEET
 1" = 100' HORIZ.

SHEET 5 OF 5


CHANGE ORDER	FED. RD. DIV. NO.	CONT	SECT	JOB	HIGHWAY
	6	2311	01	044	FM 3051
	STATE	DIST	COUNTY		SHEET NO.
	TEXAS	WAC	MCLENNAN		31

DATE: 10/5/2022
 FILE: \\txdot\project\wiseonline.com\TXDOT3\Documents\09 - WAC\Design Projects\231101044\4 - Design\Plan Set\3 - RoadwayStandards\GF(31)-19.dgn
 DISCLAIMER: THE USE OF THIS STANDARD IS GOVERNED BY THE "TEXAS ENGINEERING PRACTICE ACT". NO WARRANTY OF ANY KIND IS MADE BY TXDOT FOR ANY PURPOSE WHATSOEVER. TXDOT ASSUMES NO RESPONSIBILITY FOR THE CONVERSION OF THIS STANDARD TO OTHER FORMATS OR FOR INCORRECT RESULTS OR DAMAGES RESULTING FROM ITS USE.

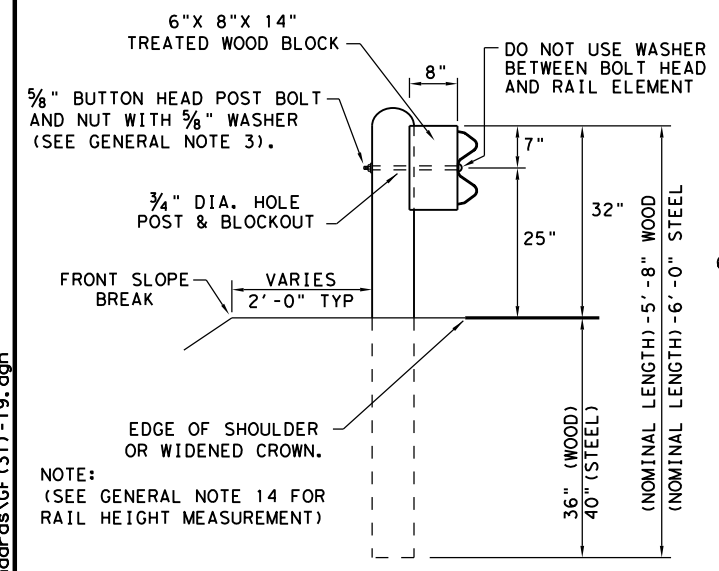


TYPICAL POST PLACEMENT


NOTE: (SEE GENERAL NOTE 14 FOR RAIL HEIGHT MEASUREMENT)

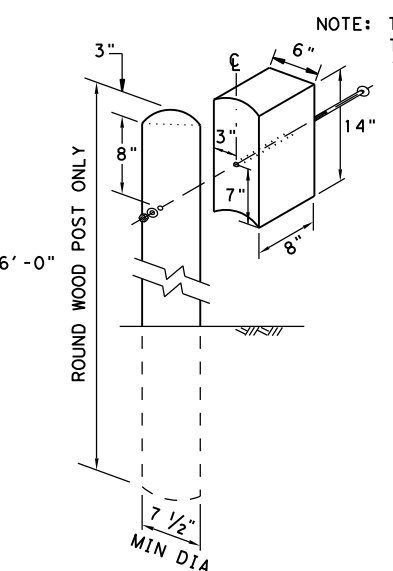


WOOD BLOCK TO ROUND WOOD POST

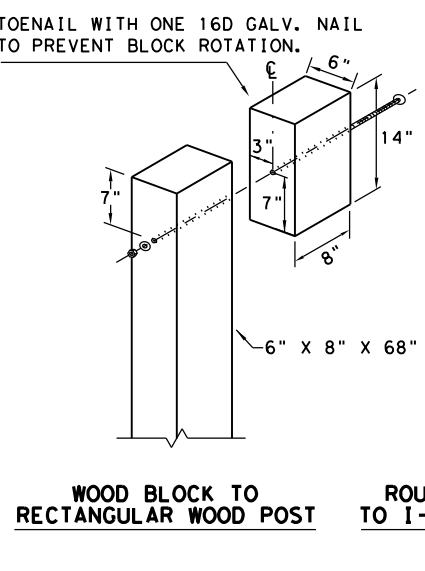

WOOD BLOCK TO RECTANGULAR WOOD POST

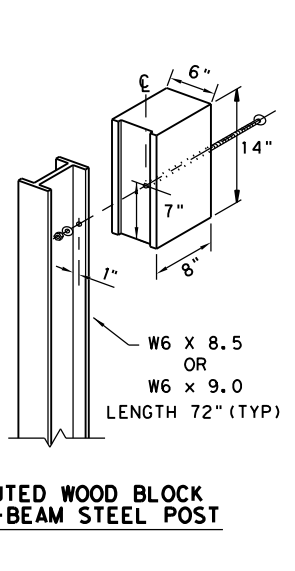


ROUTED WOOD BLOCK TO I-BEAM STEEL POST

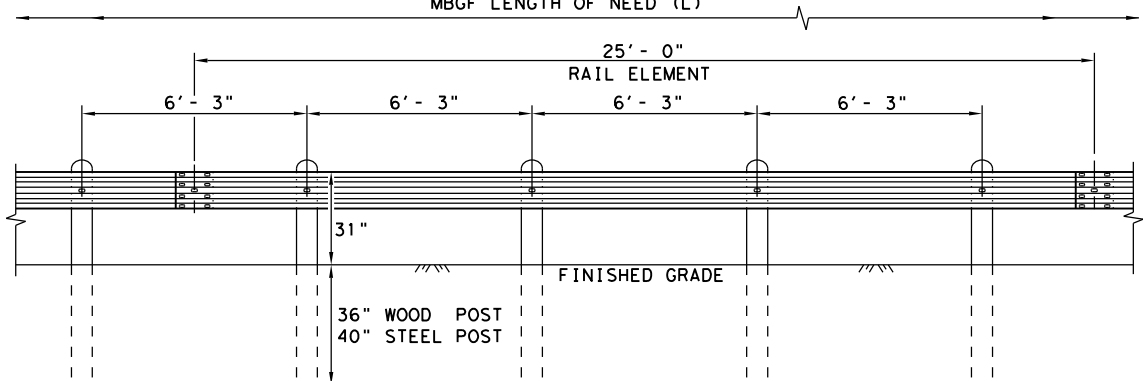


ELEVATION MID-SPAN RAIL SPLICE

NOTE: ** "WOOD" INDICATES DIMENSIONS FOR BOTH ROUND AND RECTANGULAR WOOD POST SYSTEMS.

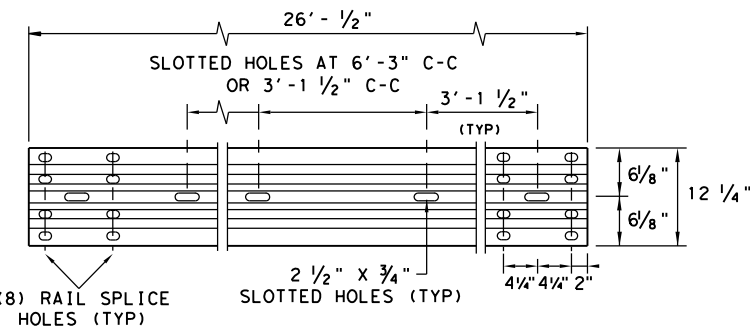


ELEVATION 25' - 0" (NOM.) W-BEAM SECTION

NOTES: SEE GENERAL NOTE 2 FOR ALLOWABLE RAIL TYPES. SEE RAIL SPLICE DETAIL FOR REQUIRED HARDWARE.

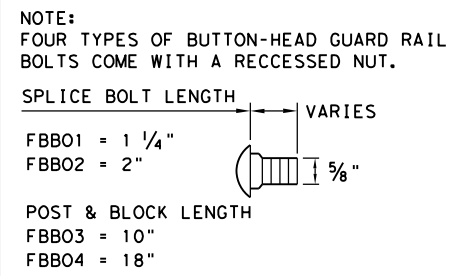

BUTTON HEAD BOLT


NOTE: SEE GENERAL NOTE 3 FOR SPLICE & POST BOLT DETAILS.

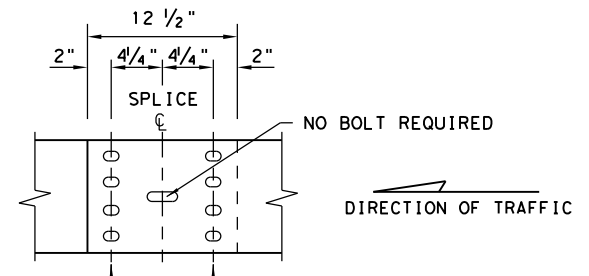

MID-SPAN RAIL SPLICE DETAIL

NOTE: GF(31), MID-SPAN RAIL SPLICES ARE REQUIRED WITH 6'-3" POST SPACINGS.

* POST(S) MAY REQUIRE FIELD MODIFICATION TO ENSURE PROPER GUARDRAIL HEIGHT.

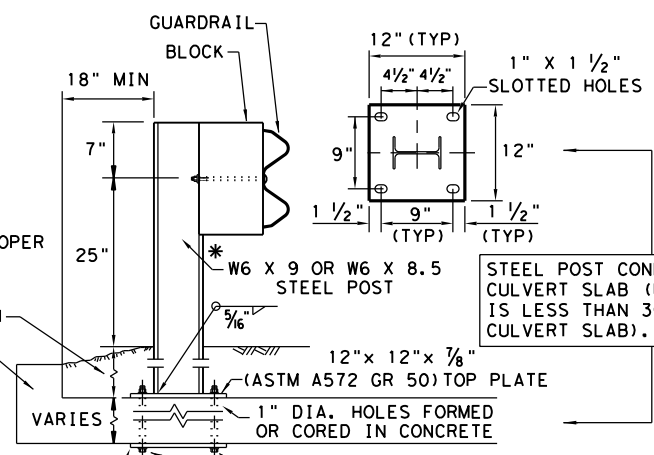

LOW FILL CULVERT POST

NOTE: TWO INSTALLATION OPTIONS.

- BOLT-THROUGH OPTION:** REQUIRES A 6" MIN. SLAB THICKNESS. 7/8" DIA (ASTM A449) HEAVY HEX BOLTS WITH TWO HARDENED WASHER EACH AND HEAVY HEX NUTS. NOTE: BOLT LENGTH = SLAB PLUS 2 1/4" MIN.
- EPOXY ANCHOR OPTION:** THIS OPTION MAY ONLY BE USED IF THE CULVERT SLAB IS 9" MIN. THICK. THREADED ANCHOR RODS MUST BE 7/8" DIA. ASTM A449 OR A193 GRADE B7 WITH HEAVY HEX NUT, AND ONE HARDENED WASHER EACH. EMBED ANCHOR RODS 6" WITH HILTI HIT RE 500 EPOXY ADHESIVE. OTHER TYPE III CLASS C EPOXY ADHESIVES MEETING THE REQUIREMENTS OF DMS-6100, "EPOXIES AND ADHESIVES", MAY BE USED IF IT CAN BE DEMONSTRATED THAT THEY MEET OR EXCEED THE STRENGTH OF HILTI HIT RE 500 WITH THE SAME EMBEDMENT DEPTH AND THREADED ROD DIA. FOLLOW THE MANUFACTURER'S REQUIREMENTS FOR INSTALLING EPOXIED THREADED RODS. EXTEND RODS 1/4" MIN. BEYOND NUT.

NOTE: CULVERTS OF 25 FT. OR LESS, SEE GF(31)LS STANDARD FOR "LONG SPAN" OPTION.


GENERAL NOTES

- THE TYPE OF POST (ROUND WOOD POST, RECTANGULAR WOOD POST, OR STEEL POST) WILL BE AS SHOWN IN THE PLANS. THE EXACT POSITION OF MBGF SHALL BE SHOWN IN THE PLANS OR AS DIRECTED BY THE ENGINEER. STEEL POSTS TO BE GALVANIZED IN ACCORDANCE WITH ITEM 445, "GALVANIZING."
- RAIL ELEMENTS SHALL MEET THE REQUIREMENTS OF ITEM 540, "METAL BEAM GUARD FENCE" EXCEPT AS MODIFIED IN THE PLANS. THE CONTRACTOR MAY FURNISH RAIL ELEMENTS OF 25'-0", OR 12'-6" (NOM.) LENGTHS. RAIL ELEMENTS MAY HAVE SLOTTED HOLES AT 3'-1 1/2" C-C OR 6'-3" C-C. A SPECIAL LENGTH OF RAIL MAY BE MANUFACTURED TO ACCOMMODATE THE DOWNSTREAM ANCHOR TERMINAL (DAT) AND THE TRANSITION SECTIONS OF GUARDRAIL.
- BUTTON HEAD "POST BOLTS & NUTS" SHALL MEET THE REQUIREMENTS OF (ASTM A307), AND SHALL BE OF SUFFICIENT LENGTH TO EXTEND THROUGH THE FULL THICKNESS OF THE NUT AND 5/8" WASHER (FWC16G) AND NOT MORE THAN 1" BEYOND IT. TRIM REMAINING BOLT LENGTH TO MEET REQUIRED LENGTH.
- FITTINGS (BOLTS, NUTS, AND WASHERS) SHALL BE GALVANIZED IN ACCORDANCE WITH ITEM 445, "GALVANIZING." FITTINGS SHALL BE SUBSIDIARY TO THE BID ITEM.
- CROWN SHALL BE WIDENED TO ACCOMMODATE THE METAL BEAM GUARD FENCE.
- THE LATERAL APPROACH TO THE GUARD FENCE, SHALL HAVE A MAXIMUM SLOPE OF 1V:10H.
- IF SHOWN ELSEWHERE IN THE PLANS OR AS DIRECTED BY THE ENGINEER, THE GUARD FENCE MAY BE FLARED AT A RATE OF 25:1 OR FLATTER.
- UNLESS OTHERWISE SHOWN IN THE PLANS, GUARD FENCE PLACED IN THE VICINITY OF CURBS SHALL BE POSITIONED SO THAT THE FACE OF CURB IS LOCATED DIRECTLY BELOW OR BEHIND THE FACE OF THE RAIL. RAIL PLACED OVER CURBS SHALL BE INSTALLED SO THAT THE POST BOLT IS LOCATED APPROXIMATELY 25 INCHES ABOVE THE GUTTER PAN OR EDGE OF SHOULDER.
- APPLICATIONS IN SOLID ROCK ARE ONLY ALLOWED WITH STEEL POSTS. IF SOLID ROCK IS ENCOUNTERED WITHIN 0 TO 18" OF THE FINISHED GRADE, DRILL A 24" DIA. HOLE, 24" INTO THE ROCK. IF SOLID ROCK IS ENCOUNTERED BELOW 18", DRILL A 12" DIA. HOLE, 12" INTO THE ROCK OR TO THE STANDARD EMBEDMENT DEPTH, WHICHEVER MAYBE LESS. ANY EXCESS POST LENGTH, AFTER MEETING THESE DEPTHS, MAY BE FIELD CUT TO ENSURE PROPER GUARDRAIL MOUNTING HEIGHT. BACKFILL WITH COARSE AGGREGATE MATERIAL.
- POSTS SHALL NOT BE SET IN CONCRETE, OF ANY DEPTH.
- SPECIAL FABRICATION WILL BE REQUIRED AT INSTALLATION LOCATIONS HAVING A CURVATURE OF LESS THAN 150 FT. RADIUS.
- UNLESS OTHERWISE SHOWN IN THE PLANS, A COMPOSITE MATERIAL BLOCK THAT MEETS THE REQUIREMENTS OF DMS-7210, "COMPOSITE MATERIAL POSTS AND BLOCKS FOR METAL BEAM GUARD FENCE" MAY BE SUBSTITUTED FOR BLOCKS OF SIMILAR DIMENSIONS. THE CONSTRUCTION DIVISION, TXDOT MAINTAINS A MATERIAL PRODUCER LIST (MPL) FOR PRODUCERS OF MATERIALS CONFORMING TO DMS-7210 ONLY PRODUCERS ON THE MPL MAY FURNISH COMPOSITE MATERIAL BLOCKS.
- FOR THE LOW FILL CULVERT OPTION, POSTS LOCATED PARTIALLY OR WHOLLY BETWEEN PRECAST BOX CULVERT UNITS, THE USE OF A CAST-IN-PLACE CONCRETE CLOSURE BETWEEN BOXES IS REQUIRED. THE LENGTH OF THE CAST-IN-PLACE CONCRETE CLOSURE SHALL ACCOMMODATE THE PLACEMENT OF THE LOW FILL CULVERT OPTION. SEE CONCRETE CLOSURE DETAILS ON BRIDGE STANDARD SCP-MD.
- GUARDRAIL HEIGHT MEASUREMENT: WHEN THE GUARDRAIL IS LOCATED ABOVE PAVEMENT, MEASURE THE HEIGHT FROM THE PAVEMENT TO THE TOP OF THE W-BEAM RAIL. WHEN THE GUARDRAIL IS LOCATED UP TO 2 FT. OFF OF THE EDGE OF PAVEMENT OR FOR A PAVEMENT OVERLAY, USE A 10-FOOT STRAIGHTEDGE TO EXTEND THE PAVEMENT/SHOULDER SLOPE TO THE BACK OF RAIL, MEASURE FROM THE BOTTOM OF STRAIGHTEDGE TO THE TOP OF RAIL. FOR GUARDRAIL LOCATED DOWN A 10:1 SLOPE, MEASURE FROM THE NOMINAL TERRAIN.

NOTE: TRANSITIONS TO BRIDGE RAILS OR TRAFFIC BARRIERS. SEE GF(31)TL3 TR STANDARD FOR HIGH-SPEED TL-3 TRANSITIONS. SEE GF(31)TL2 TR STANDARD FOR LOW-SPEED TL-2 TRANSITIONS.

				Design Division Standard
METAL BEAM GUARD FENCE TL-3 MASH COMPLIANT GF(31)-19				
FILE: gf3119.dgn	DN: TXDOT	CK: KM	DW: VP	CK: CGL/AG
© TXDOT: NOVEMBER 2019	CONT	SECT	JOB	HIGHWAY
REVISIONS	2311	01	044	FM 3051
	DIST	COUNTY	SHEET NO.	
	WAC	MCLENNAN	32	





DATE: 10/5/2022
 FILE: \\txdot\projectwiseonline.com\TXDOT3\Documents\09 - WAC\Design\Projects\231101044\4 - Design\Plan Set\3 - RoadwayStandards\GF (31) TR L3-20.dgn
 DISCLAIMER: THE USE OF THIS STANDARD IS GOVERNED BY THE "TEXAS ENGINEERING PRACTICE ACT". NO WARRANTY OF ANY KIND IS MADE BY TXDOT FOR ANY PURPOSE WHATSOEVER. TXDOT ASSUMES NO RESPONSIBILITY FOR THE CONVERSION OF THIS STANDARD TO OTHER FORMATS OR FOR INCORRECT RESULTS OR DAMAGES RESULTING FROM ITS USE.

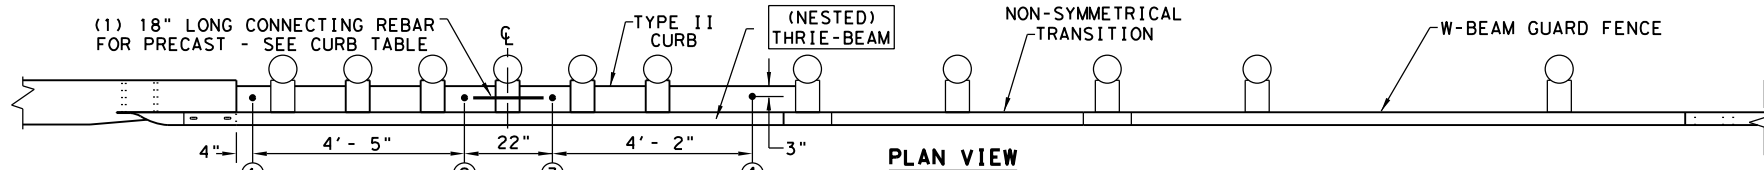

- (5) 1" DIA. HOLES.
- (5) 7/8" DIA. HEAVY HEX HEAD BOLTS (FACING TRAFFIC SIDE) (ASTM F3125 GR A325 OR A449).
- (10) 1 3/4" O.D. WASHER UNDER EACH HEX BOLT HEAD AND NUT.
- (5) 7/8" DIA. HEAVY HEX NUTS (ASTM A194 OR A563).

NOTE:
HEAVY HEX BOLT LENGTH WILL VARY DEPENDING ON WIDTH CONCRETE RAIL, LEAVE 1" OF BOLT LENGTH PAST THE 7/8" HEX NUT. TRIM AS REQUIRED.

NOTE:
CURB IS A REQUIRED COMPONENT FOR THE TRANSITION TO FUNCTION PROPERLY. SEE GENERAL NOTES: 2-4 AND 16-17.

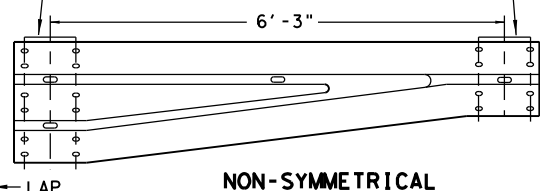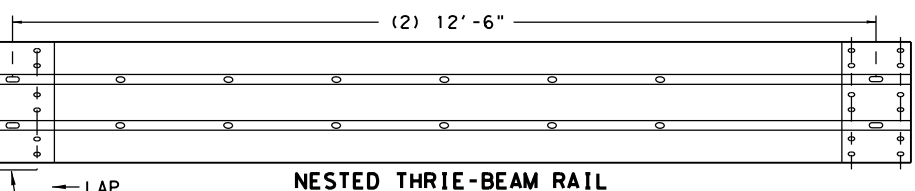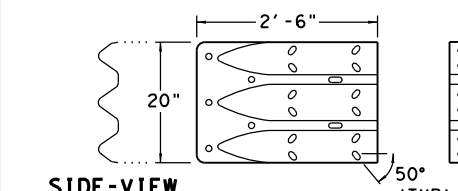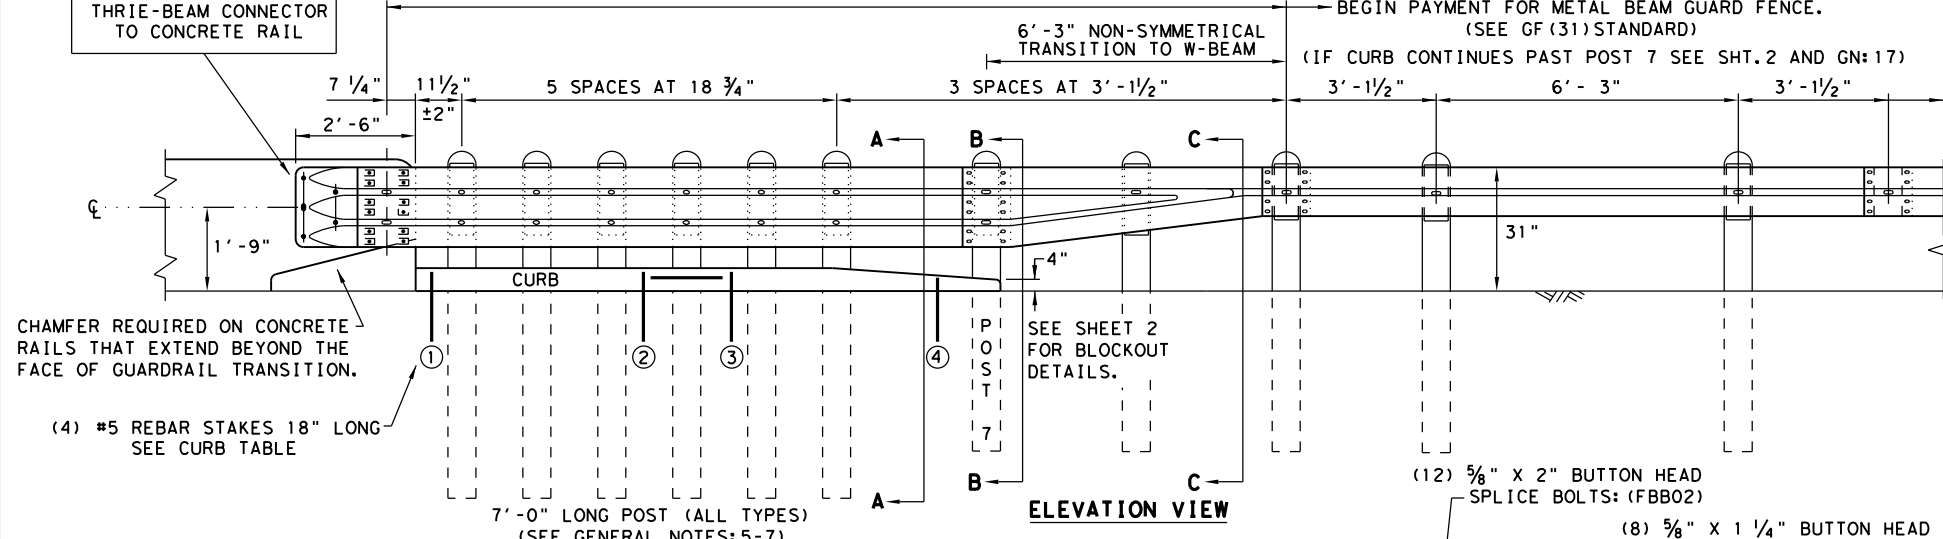


THRIE-BEAM TERMINAL CONNECTOR 10GA.
PART DESIGNATOR RTE01D
NOTE: SEE GENERAL NOTE: 9

NESTED THRIE-BEAM RAIL
PART DESIGNATOR RTM10G
(12) 5/8" X 2" BUTTON HEAD SPLICE BOLTS WITH RECESSED NUTS: (FBB02)
(12) RECTANGULAR GUARDRAIL PLATE WASHERS: (FWR03)

NON-SYMMETRICAL W-BEAM TO THRIE-BEAM TRANSITION 10GA.
PART DESIGNATOR RWT02G OR RWT02B

PLATE WASHER INSTRUCTIONS

BRIDGE APPROACH - UPSTREAM: THE NESTED RAIL LAPS OVER THE TERMINAL CONNECTOR. PLATE WASHERS ARE INSTALLED UNDER THE SPLICE NUTS AGAINST INSIDE OF CONNECTOR.
BRIDGE EXIT - DOWNSTREAM: THE TERMINAL CONNECTOR LAPS OVER THE NESTED RAIL. PLATE WASHERS ARE INSTALLED UNDER THE BOLT HEAD AGAINST OUTSIDE OF CONNECTOR.

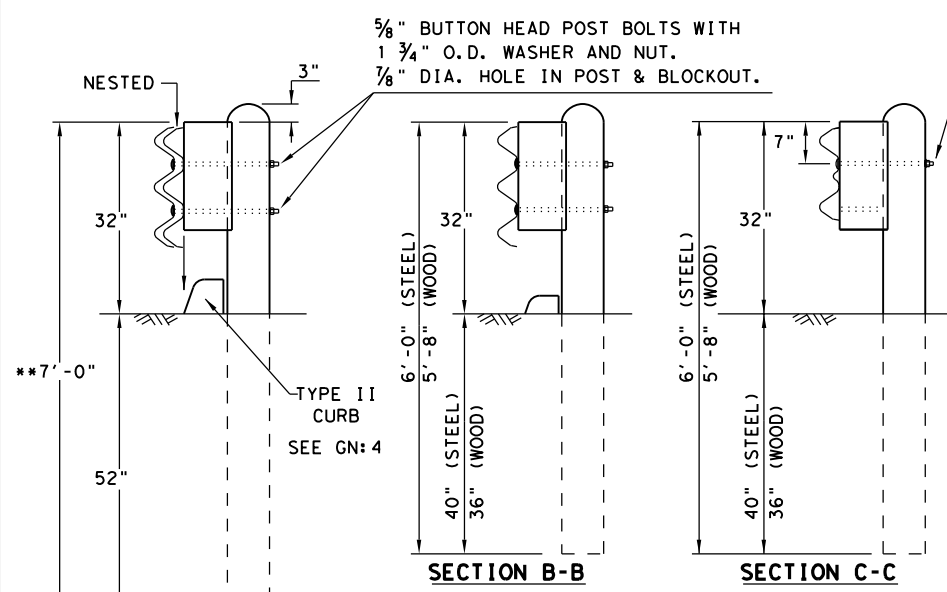


NOTE: ALL POST TYPES, SEE GENERAL NOTE: 5 & 6

NOTE: ** "WOOD" INDICATES DIMENSIONS FOR BOTH ROUND AND RECTANGULAR WOOD POST SYSTEMS.

THRIE-BEAM TERMINAL - CURB TABLE	
PRECAST CURB FULL LENGTH EQUALS 12'- 2"	
THE PRECAST CURB MAY BE FORMED INTO TWO SECTIONS.	
CURB (1) LENGTH	5'- 8"
CURB (2) LENGTH	6'- 6"
TAPER CURB (2) TO A HEIGHT OF 4" AT POST 7	
CONNECTING PRECAST CURB SECTIONS (1) & (2):	
FORM OR CORE	1" DIA. HOLE 9" LONG INTO EACH CURB END.
USE	(1) #5 GR.60 REBAR 18" LONG TO CONNECT BOTH CURBS.
SECURING PRECAST OR CAST-IN-PLACE TO FINISHED GRADE *:	
FORM OR CORE	(4) 1" DIA. HOLES, SEE PLAN AND ELEVATION VIEWS FOR HOLE LOCATIONS. DRIVE (4) #5 GR.60 REBAR STAKES 18" LONG INTO THE GROUND AND 1/2" BELOW TOP OF CURB.
	FILL HOLES WITH APPROVED GROUT MIXTURE.

* NOTES: NOT NEEDED FOR CAST-IN-PLACE. SEE TYPE II CURB DETAIL FOR REBAR AND COVER REQUIREMENTS. PERCUSSION DRILLING IS NOT PERMITTED WITH: TYPE II CURB, BRIDGE RAIL OR CONCRETE TRAFFIC RAIL.

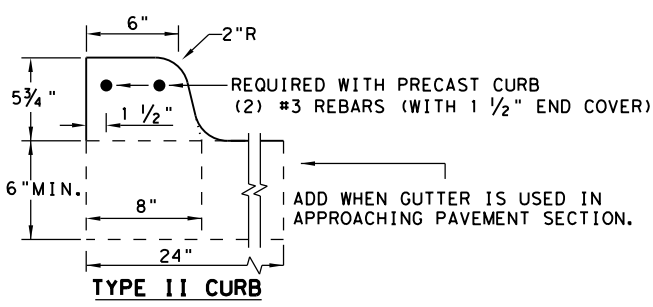

NOTE: OPTIONS FOR TYPE II CURB:
1. PRECAST
2. CAST-IN-PLACE

GENERAL NOTES

1. CONTACT THE DESIGN DIVISION FOR DRAINAGE CUT OUT OPTIONS NEEDED WITHIN THE CURB SECTION OF THE THRIE-BEAM TRANSITION. (512) 416-2678
2. CONCRETE CURB MAY BE CAST-IN-PLACE OR PRECAST AS SHOWN ON THIS SHEET. WHEN USED IN CONJUNCTION WITH THE THRIE-BEAM TRANSITIONS, CURB SHALL BE TYPE II (5- 3/4" HEIGHT); SEE CURRENT CCGG STANDARD SHEET FOR FURTHER DETAILS. IF OTHER CURB HEIGHTS ARE SHOWN IN THE PLANS IN CONJUNCTION WITH THE TRANSITION, THE CURB HEIGHT MAY BE FROM 4" TO 8" WITH A RELATIVELY VERTICAL FACE. CONCRETE CURB SHALL BE CONTINUOUS TO THE SEVENTH POST UNLESS OTHERWISE SHOWN IN THE PLANS. SEE GENERAL NOTE: 17 FOR CIRCUMSTANCES WHERE CURB CONTINUES PAST POST 7.
3. CONCRETE CURB TYPE II SUBSIDIARY TO "METAL BEAM GUARD FENCE TRANSITION". IF NO ADDITIONAL CURB IS INDICATED BEYOND THE TRANSITION, THEN ANY CURB HEIGHT GREATER THAN 4" WILL BE TAPERED DOWN BEGINNING AT THE LAST 7 FT. POST TO A MAXIMUM HEIGHT OF 4" AT POST 7. IF SHOWN ELSEWHERE IN THE PLANS, ADDITIONAL CURB UNDERNEATH GUARDRAIL WILL BE PAID FOR BY THE LINEAR FOOT.
4. UNLESS OTHERWISE SHOWN IN THE PLANS, TRANSITIONS SHALL BE PLACED WITH THE BLOCKOUT FACE IN FRONT OF OR DIRECTLY ABOVE THE CURB FACE. SEE SECTION A-A.
5. FOR ROUND WOOD POST SYSTEMS, ALL ROUND WOOD POSTS SHALL BE 7 1/2" DIA. MINIMUM THROUGHOUT THE THRIE-BEAM TRANSITION.
6. THE TYPE OF POST (ROUND WOOD POST, RECTANGULAR WOOD POST OR STEEL POST) WILL BE AS SHOWN IN THE PLANS. REFER TO GF (31) STANDARD SHEET.
7. THE POST LENGTH SHALL BE MARKED ON ALL 7'- 0" LONG POSTS BY THE MANUFACTURER. THE MARK SHALL BE LOCATED WITHIN THE TOP 1 FT. REGION OF THE POST, AT LEAST 5/8" IN HEIGHT, AND VISIBLE AFTER INSTALLATION. WOODEN POSTS SHALL BE MARKED WITH A BRAND, AND STEEL POSTS WITH A STENCIL BEFORE GALVANIZING.
8. POSTS SHALL NOT BE SET IN CONCRETE, OF ANY DEPTH.
9. RAIL ELEMENTS SHALL MEET THE REQUIREMENTS OF ITEM 540, "METAL BEAM GUARD FENCE" EXCEPT AS MODIFIED ON THE PLANS. THE THRIE-BEAM TERMINAL CONNECTOR AND THE THRIE-BEAM TRANSITION TO W-BEAM SHALL BE OF THE SAME MATERIAL, BUT SHALL NOT BE LESS THAN 10 GAUGE. CONTRACTOR SHALL VERIFY THAT THE LOCATIONS OF BOLT HOLES MATCH THOSE IN THE THRIE-BEAM TERMINAL CONNECTOR PRIOR TO ORDERING MATERIALS.
10. BUTTON HEAD "POST BOLTS & NUTS" SHALL MEET THE REQUIREMENTS OF (ASTM A307), AND SHALL BE OF SUFFICIENT LENGTH TO EXTEND THROUGH THE FULL THICKNESS OF THE NUT AND 5/8" WASHER (FWC16G) AND NOT MORE THAN 1" BEYOND IT. TRIM REMAINING BOLT LENGTH TO MEET REQUIRED LENGTH.
11. FITTINGS (BOLTS, NUTS, AND WASHERS) SHALL BE GALVANIZED IN ACCORDANCE WITH ITEM 445, "GALVANIZING". FITTINGS SHALL BE SUBSIDIARY TO THE BID ITEM.
12. CROWN SHALL BE WIDENED TO ACCOMMODATE TRANSITIONS.
13. WHERE SOLID ROCK IS ENCOUNTERED, CONTACT THE DESIGN DIVISION FOR ADDITIONAL GUIDANCE. (512) 416-2678
14. UNLESS OTHERWISE SHOWN IN THE PLANS, A COMPOSITE MATERIAL BLOCK THAT MEETS THE REQUIREMENTS OF DMS-7210, "COMPOSITE MATERIAL POSTS AND BLOCKS FOR METAL BEAM GUARD FENCE" MAY BE SUBSTITUTED FOR BLOCKS OF SIMILAR DIMENSIONS. TXDOT'S MATERIALS AND TESTS DIVISION MAINTAINS A MATERIAL PRODUCER LIST (MPL) FOR PRODUCERS OF MATERIALS CONFORMING TO DMS-7210. ONLY PRODUCERS ON THE MPL CAN FURNISH COMPOSITE MATERIAL BLOCKS.
15. REFER TO GF (31) STANDARD SHEET & BRIDGE RAILING DETAILS FOR ADDITIONAL DETAILS.
16. THE INSTALLATION OF THE TYPE II CURB IS CRITICAL FOR THE PERFORMANCE OF THE THRIE-BEAM TRANSITION SYSTEM. THE CURB PREVENTS (VEHICLE WHEEL SNAGGING) AT THE CONCRETE RAIL AND IS REQUIRED TO MEET MASH CRASH TEST CRITERIA.
17. IF CURB EXTENDS BEYOND POST 7, 25' OF NESTED W-BEAM GUARDRAIL SHALL BE INSTALLED BEYOND THE PAY LIMITS OF THRIE-BEAM TRANSITION SECTION, (SEE SHT.2). PAYMENT FOR THIS 25' SECTION WILL BE BY LINEAR FOOT, PAY ITEM "0540 6XXX MTL W-BEAM GD FEN (NESTED) (TIM POST)" OR "540 6XXX MTL W-BEAM GD FEN (NESTED) (STEEL POST)" AS APPLICABLE FOR POST TYPE. SEE SHT.2 FOR ADDITIONAL INFORMATION.


HIGH-SPEED TRANSITION
SHEET 1 OF 2

		Design Division Standard	
METAL BEAM GUARD FENCE THRIE-BEAM TRANSITION TL-3 MASH COMPLIANT GF (31) TR TL3-20			
FILE: gf31tr+1320.dgn	DN: TXDOT	CK: KM	DW: VP
© TXDOT: NOVEMBER 2020	CONT: 2311	SECT: 01	JOB: 044
REVISIONS	DIST: WAC	COUNTY: MCLENNAN	SHEET NO.: 33


DATE: 10/5/2022
 FILE: pw:\txdot\projectwiseonline.com:TXDOT3\Documents\09 - WAC\Design Projects\231101044\4 - Design\Plan Set\3. Roadway\Standards\GF (31)\TRL3-20.dgn

DISCLAIMER:
 THE USE OF THIS STANDARD IS GOVERNED BY THE "TEXAS ENGINEERING PRACTICE ACT". NO WARRANTY OF ANY KIND IS MADE BY TXDOT FOR ANY PURPOSE WHATSOEVER.
 TXDOT ASSUMES NO RESPONSIBILITY FOR THE CONVERSION OF THIS STANDARD TO OTHER FORMATS OR FOR INCORRECT RESULTS OR DAMAGES RESULTING FROM ITS USE.


REQUIRED ALTERNATIVE FOR CONTINUOUS CURB EXTENDING PAST POST 7 (SEE SHT. 1 GENERAL NOTE 17)

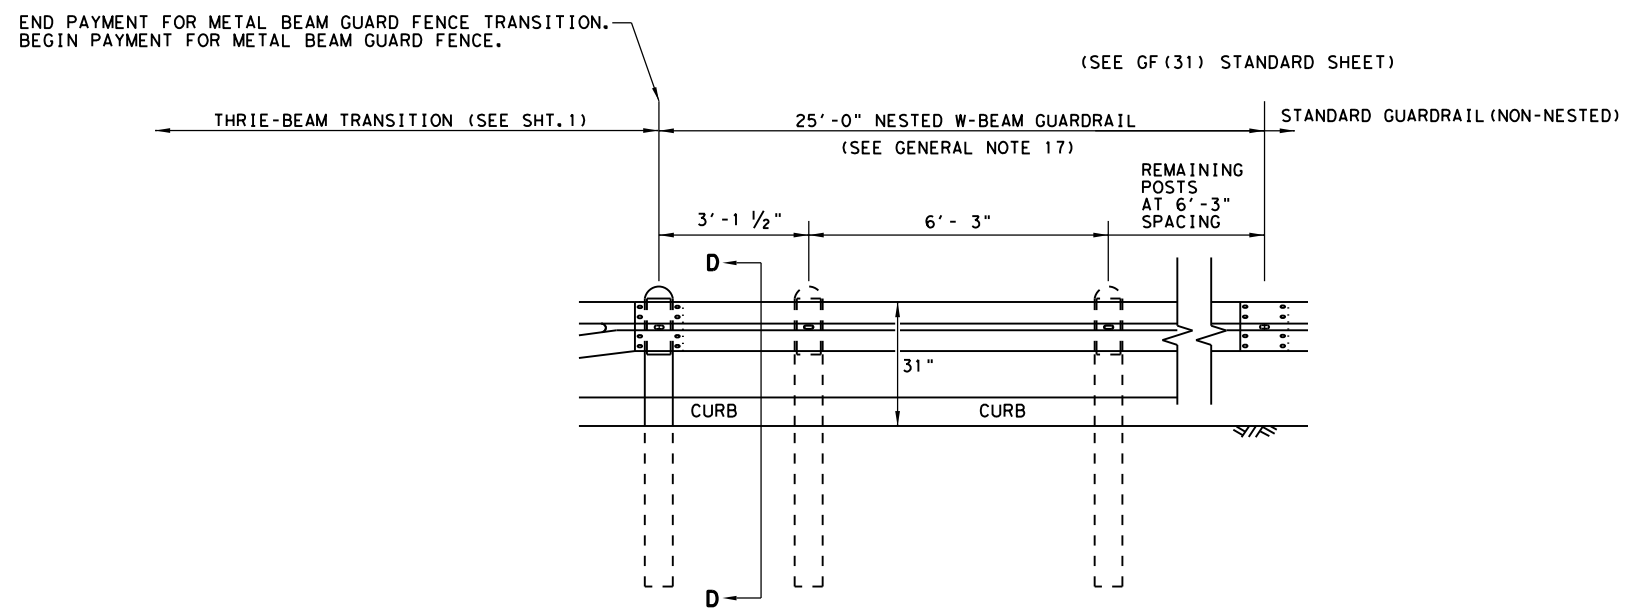

ELEVATION VIEW

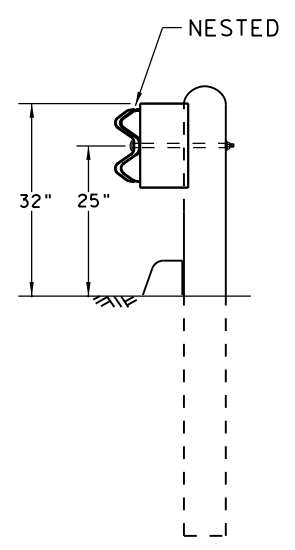

SECTION D-D

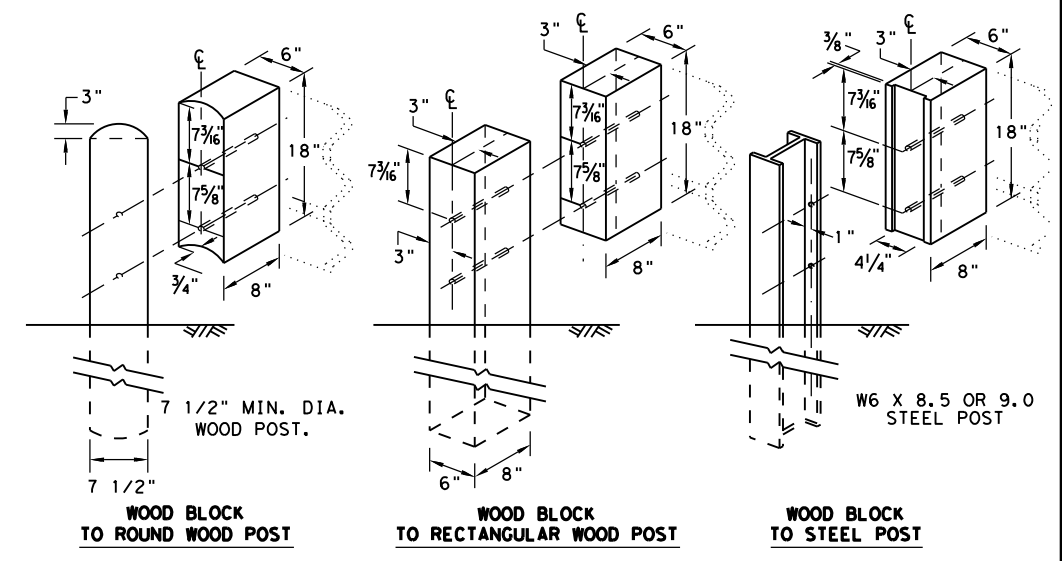


THRIE BEAM TRANSITION BLOCKOUT DETAILS

HIGH-SPEED TRANSITION

SHEET 2 OF 2


		Design Division Standard	
METAL BEAM GUARD FENCE THRIE-BEAM TRANSITION TL-3 MASH COMPLIANT GF (31) TR TL3-20			
FILE: gf31tr+1320.dgn	DN: TxDOT	CK: KM	DW: KM
©TxDOT: NOVEMBER 2020	CONT: 2311	SECT: 01	JOB: 044
REVISIONS		HIGHWAY: FM 3051	
DIST: WAC	COUNTY: MCLENNAN	SHEET NO.: 34	

DATE: 10/5/2022
 FILE: \\txdot.projectwiseonline.com\TXDOT3\Documents\09 - WAC\Design Projects\231101044\4 - Design\Plan Set\3. RoadwayStandards\GF (31)MS-19.dgn
 DISCLAIMER: THE USE OF THIS STANDARD IS GOVERNED BY THE "TEXAS ENGINEERING PRACTICE ACT". NO WARRANTY OF ANY KIND IS MADE BY TXDOT FOR ANY PURPOSE WHATSOEVER. TXDOT ASSUMES NO RESPONSIBILITY FOR THE CONVERSION OF THIS STANDARD TO OTHER FORMATS OR FOR INCORRECT RESULTS OR DAMAGES RESULTING FROM ITS USE.

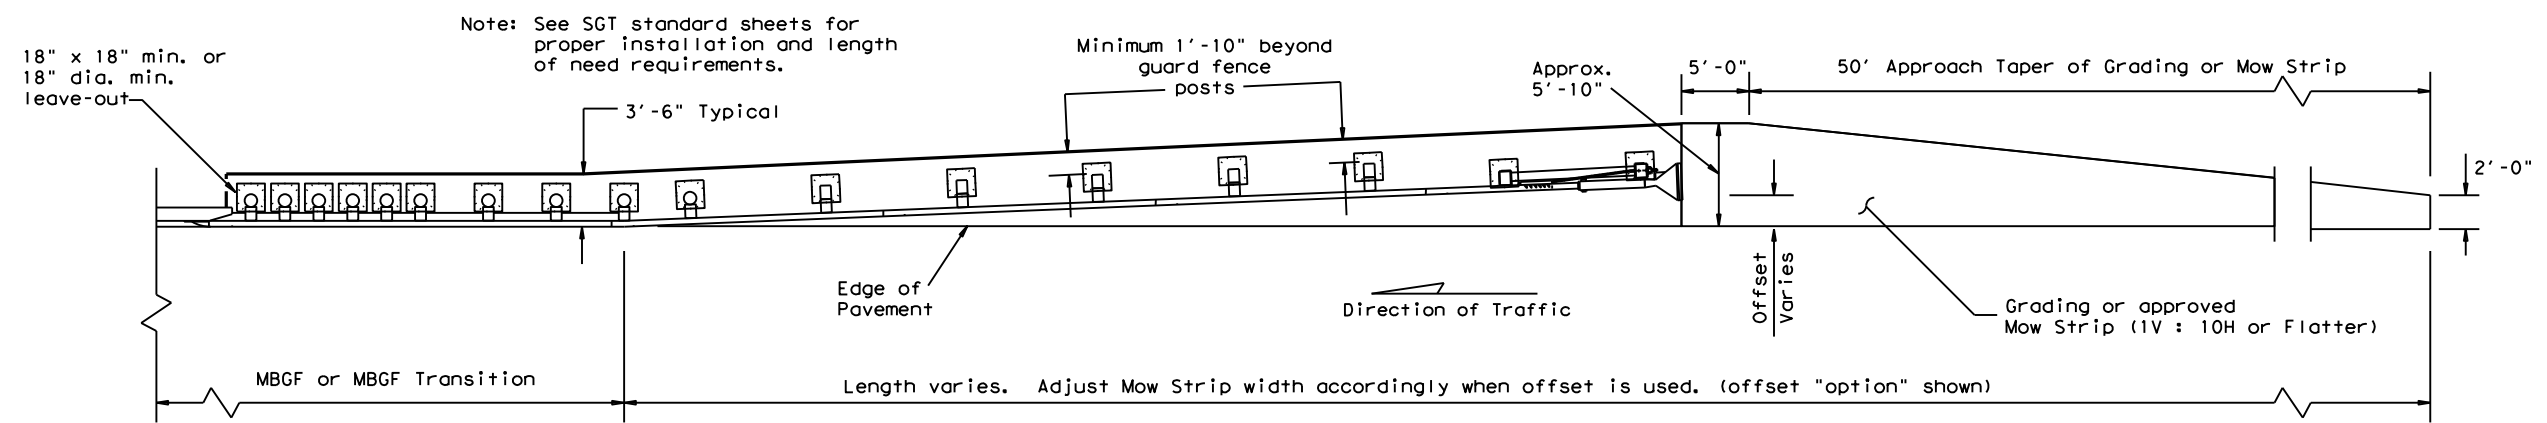


GRADING AND MOW STRIP AT GUARDRAIL END TREATMENTS

Note: Site Condition(s)
 Site conditions may exist where grading is required for the proper installation of metal guard fence and end treatments.
 Approach grading or mow strip may be decreased or eliminated, as directed by the Engineer.

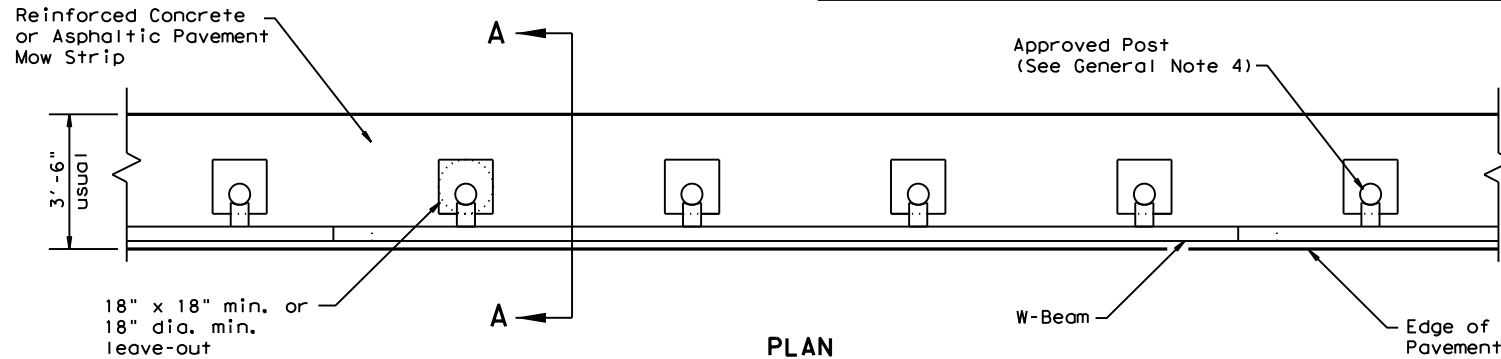


PLAN

GF(31) shown with Mow Strip
 (See GF(31) standard sheet for proper installation)

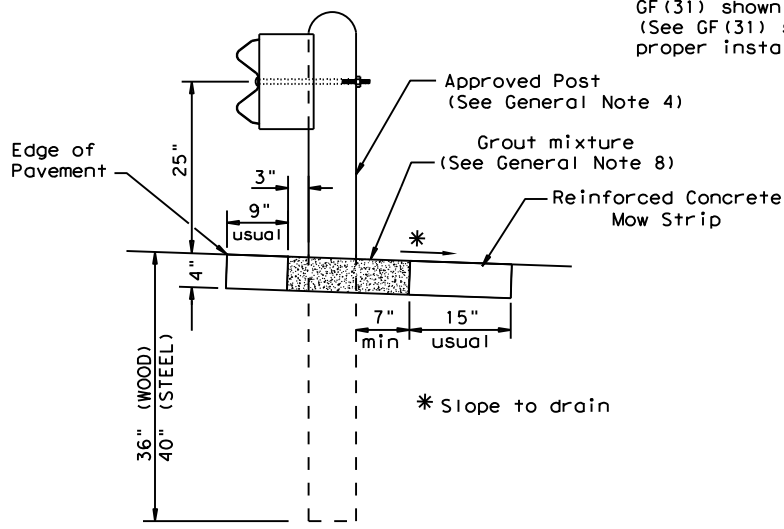

SECTION A-A


Typical

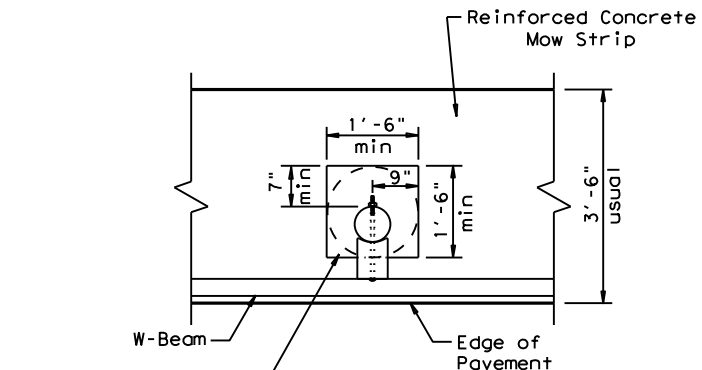

MOW STRIP DETAIL


Reinforced Concrete Mow Strip with 18" x 18" Square or 18" Dia. minimum leave-out.

Fill leave-out with Grout mixture (See General Note 8)

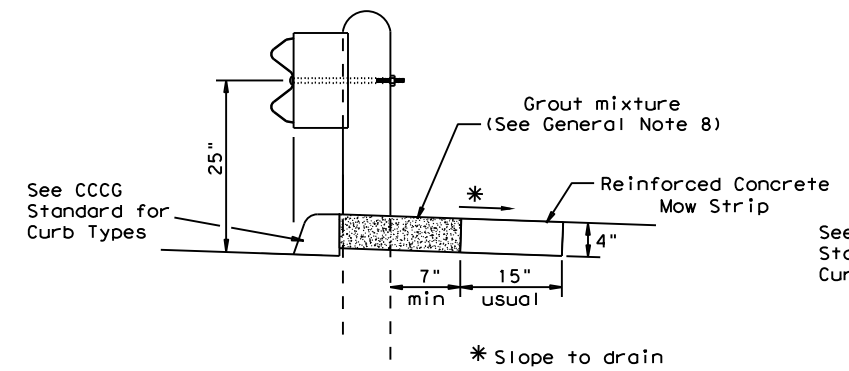


CURB OPTION (1)

This option will increase the post embedment throughout the system.

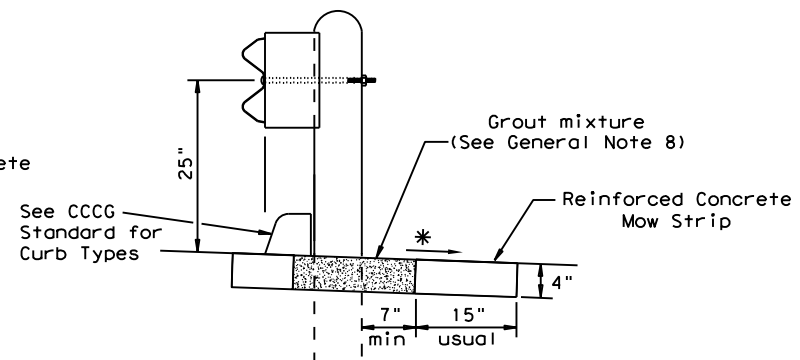

CURB OPTION (2)

Curb shown on top of mow strip

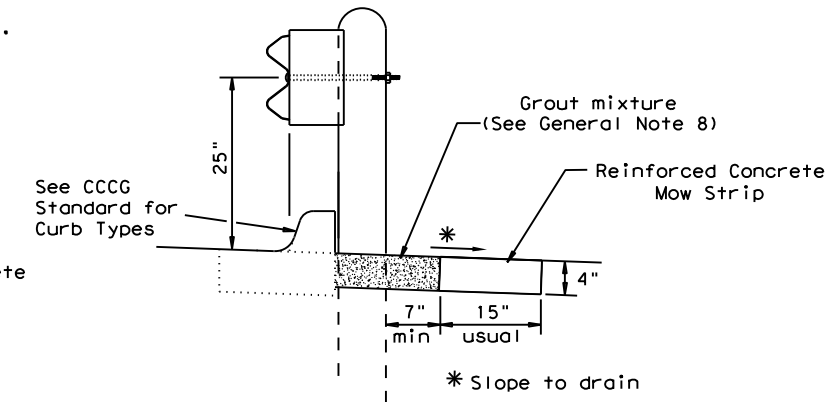


CURB OPTION (3)

GENERAL NOTES

1. This mow strip design is for use with metal beam guard fence, guard fence transitions, and guard fence end treatments. See applicable GF(31) MBGF or GF(31) Transition Standard sheet for additional information.
2. Mow strips shall be reinforced concrete with (wire mesh or synthetic fiber), as shown on the plans and will be paid for under the pertinent bid item. Reinforced concrete shall be placed in accordance with Item 432, "Riprap." The use of the synthetic fiber in lieu of steel reinforcing is acceptable, provided the fiber producer is on the Department Material Producer List (MPL), maintained by TxDOT, Construction Division.
3. The leave-out behind the post shall be a minimum of 7".
4. Only steel (W6 x 8.5 or W6 x 9.0), or 7 1/2" Dia. round wood posts are acceptable for use in the mow strip. See GF(31) Standard for additional details.
5. Other curb placement options may be used. Curbs are not considered part of the mow strip and will be paid for under other pertinent bid item.
6. Thickness of the mow strip will be 4".
7. The limits of payment for reinforced concrete will include leave-outs for the posts.
8. The leave-outs shall be filled with a Grout mixture consisting of: 2719 pounds sand, 188 pounds Type I or II cement, and 550 pounds of water per cubic yard, with a 28-day compressive strength of approximately 230 psi or less. Provide grout with a consistency that will flow into and completely fill all voids. Due to auger size, larger leave-out dimensions are acceptable from both an impact performance and maintenance repair standpoint (Suggested Maximum leave-out of 20"). Payment for furnishing and placing the grout mixture will be subsidiary to the pay item of riprap mow strip.

		Design Division Standard	
METAL BEAM GUARD FENCE (MOW STRIP) TL-3 MASH COMPLIANT GF (31)MS-19			
FILE: gf31ms19.dgn	DN: TXDOT	CK: KM	DW: VP
©TXDOT: NOVEMBER 2019	CONT	SECT	JOB
REVISIONS	2311	01	044
	DIST	COUNTY	SHEET NO.
	WAC	MCLENNAN	35

DATE: 10/5/2022
 FILE: \\txdot.projectwiseonline.com:TXDOT3\Documents\09 - WAC\Design Projects\231101044.4 - Design\Plan Set\3. Roadway\Standards\RAIL-ADJ(B)-19.dgn
 DISCLAIMER: THE USE OF THIS STANDARD IS GOVERNED BY THE "TEXAS ENGINEERING PRACTICE ACT". NO WARRANTY OF ANY KIND IS MADE BY TXDOT FOR ANY PURPOSE WHATSOEVER. TXDOT ASSUMES NO RESPONSIBILITY FOR THE CONVERSION OF THIS STANDARD TO OTHER FORMATS OR FOR INCORRECT RESULTS OR DAMAGES RESULTING FROM ITS USE.

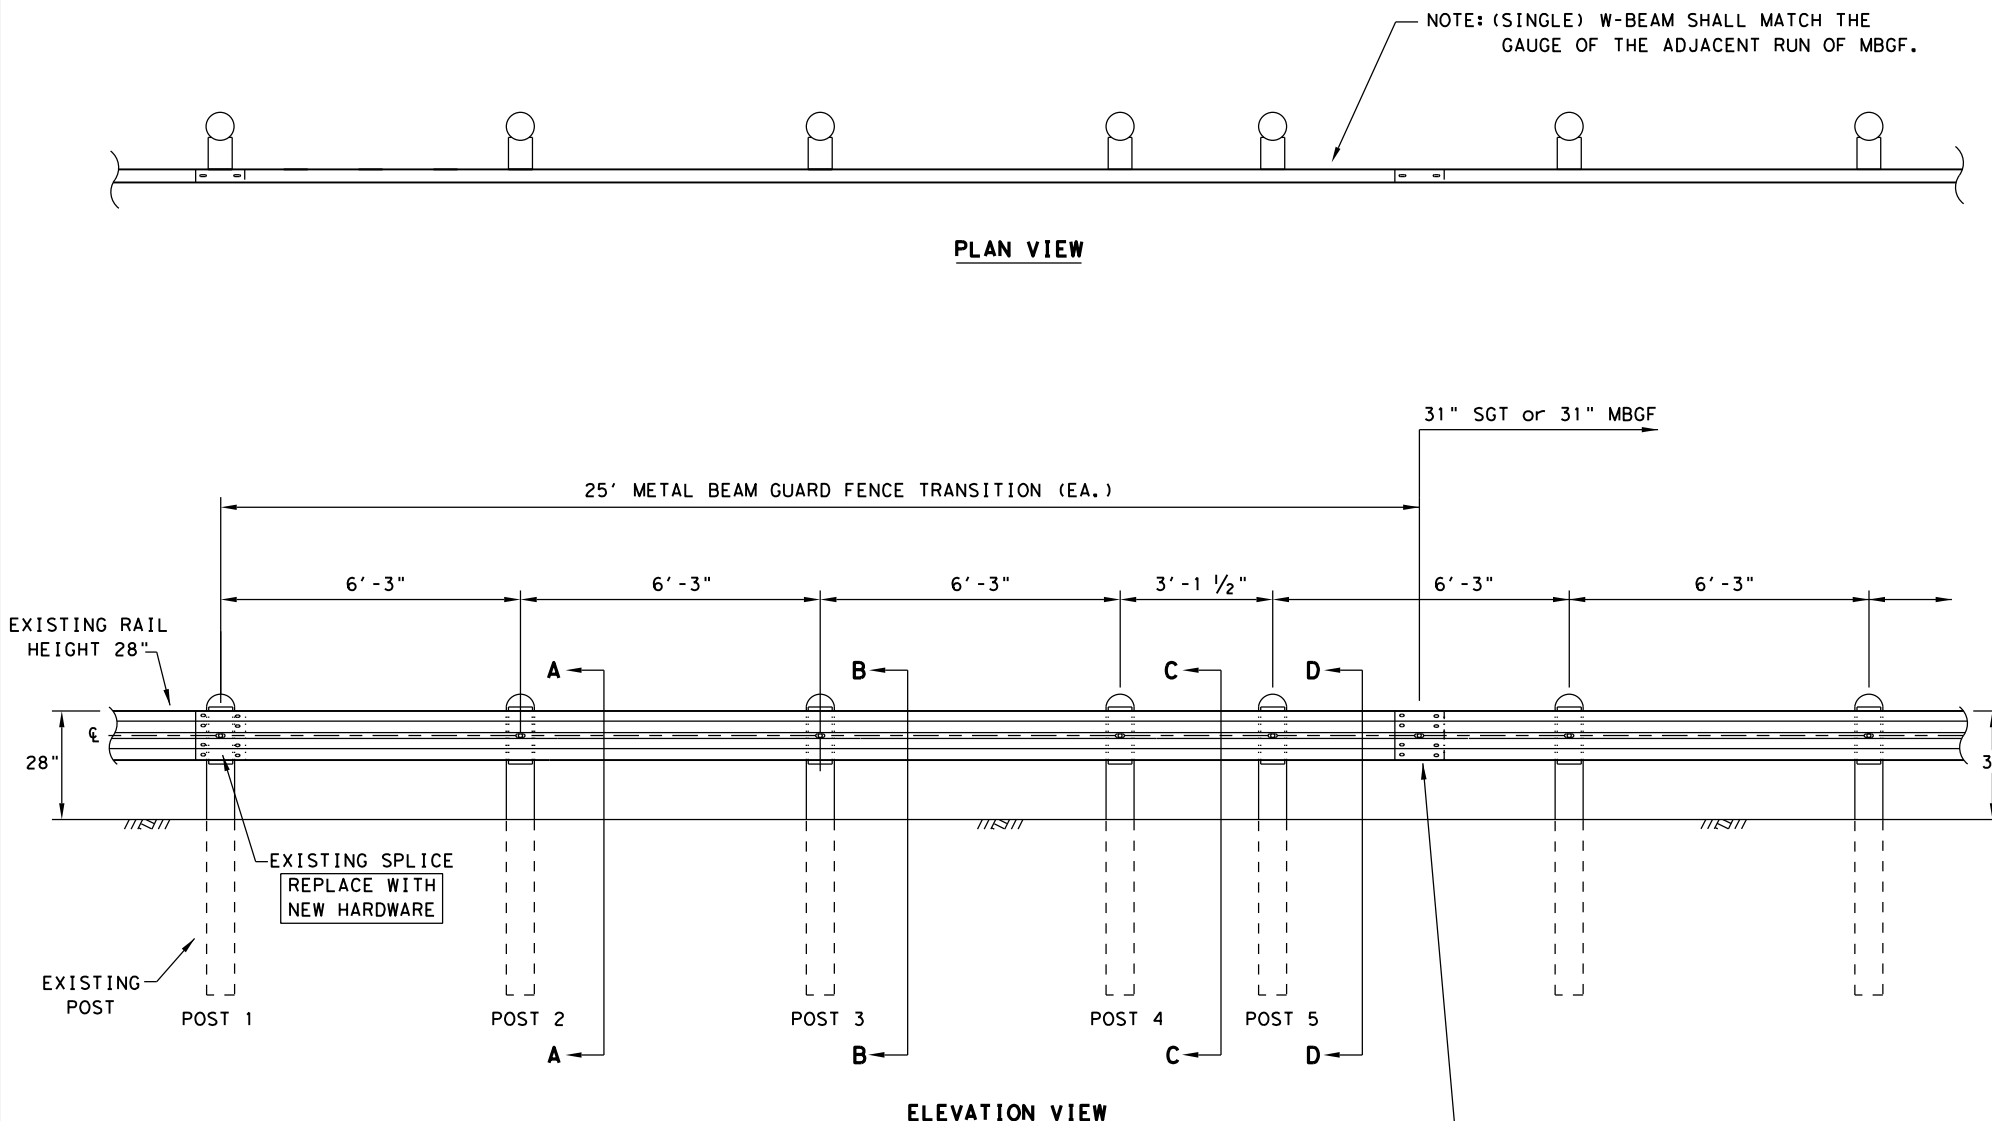

- GENERAL NOTES**
1. THE TYPE OF POST (ROUND WOOD POST, RECTANGULAR WOOD POST, OR STEEL POST) WILL BE AS SHOWN IN THE PLANS. THE EXACT POSITION OF MBGF SHALL BE AS SHOWN IN THE PLANS OR AS DIRECTED BY THE ENGINEER. STEEL POSTS TO BE GALVANIZED IN ACCORDANCE WITH ITEM 445, "GALVANIZING."
 2. RAIL ELEMENT SHALL MEET THE REQUIREMENTS OF ITEM 540, "METAL BEAM GUARD FENCE" EXCEPT AS MODIFIED IN THE PLANS. THE CONTRACTOR MAY FURNISH RAIL ELEMENTS OF 25'-0", OR 12'-6" (NOM.) LENGTHS. RAIL ELEMENTS MAY HAVE SLOTTED HOLES AT 3'-1 1/2" C-C OR 6'-3" C-C. A SPECIAL LENGTH OF RAIL MAY BE MANUFACTURED TO ACCOMMODATE THE TRANSITION SECTIONS OF GUARDRAIL.
 3. BUTTON HEAD "POST" BOLTS (ASTM A307) SHALL BE OF SUFFICIENT LENGTH TO EXTEND THROUGH THE FULL THICKNESS OF THE NUT (ASTM A563) AND 5/8" ROUND WASHER (ASTM F436) AND NOT MORE THAN 1" BEYOND IT. BUTTON HEAD "SPLICE" BOLTS (ASTM A307) ARE 5/8" X 1-1/4" WITH 5/8" NUTS (ASTM A563).
 4. FITTINGS (BOLTS, NUTS, AND WASHERS) SHALL BE GALVANIZED IN ACCORDANCE WITH ITEM 445, "GALVANIZING." FITTINGS SHALL BE SUBSIDIARY TO THE BID ITEM REQUIRING CONSTRUCTION OF THE TRANSITION.
 5. CROWN SHALL BE WIDENED TO ACCOMMODATE THE METAL BEAM GUARD FENCE.
 6. THE LATERAL APPROACH TO THE GUARD FENCE, SHALL HAVE A MAXIMUM SLOPE OF 1V:10H.
 7. IF SHOWN ELSEWHERE IN THE PLANS OR AS DIRECTED BY THE ENGINEER, THE GUARD FENCE MAY BE FLARED AT A RATE OF 25:1 OR FLATTER.
 8. APPLICATIONS IN SOLID ROCK ARE ONLY ALLOWED WITH STEEL POSTS. SEE GF(31) STANDARD FOR INSTALLATION GUIDANCE.
 9. POSTS SHALL NOT BE SET IN CONCRETE.
 10. UNLESS OTHERWISE SHOWN IN THE PLANS, A COMPOSITE MATERIAL BLOCK THAT MEETS THE REQUIREMENTS OF DMS-7210, "COMPOSITE MATERIAL POSTS AND BLOCKS FOR METAL BEAM GUARD FENCE" MAY BE SUBSTITUTED FOR BLOCKS OF SIMILAR DIMENSIONS. THE CONSTRUCTION DIVISION, TXDOT MAINTAINS A MATERIAL PRODUCER LIST (MPL) FOR PRODUCERS OF MATERIALS CONFORMING TO DMS-7210. ONLY PRODUCERS ON THE MPL MAY FURNISH COMPOSITE MATERIAL BLOCKS.
 11. REFER TO STANDARD GF(31) FOR ADDITIONAL DETAILS.
 12. RAIL HEIGHT ADJUSTMENT IS ASSESSED AT TL-3 MASH COMPLIANT FOR STEEL POST HEIGHT TRANSITION TO 28" STEEL POST GUARDRAIL.


HARDWARE LIST	
QTY	DESCRIPTION
1	25'-0" W-BEAM RAIL ELEMENT 12GA. (TYP)
5	7 1/2" DIA X 6'-0" DOMED ROUND WOOD POSTS (TYP)
5	6" X 8" X 68" RECTANGULAR WOOD POSTS (TYP)
5	W6 X 8.5 OR W6 X 9 X 72" STEEL POSTS (TYP)
5	6" X 8" X 14" WOOD BLOCKS OR COMPOSITE (TYP)
5	5/8" X 18" GUARDRAIL BOLTS AND NUTS (FBB04)
5	5/8" ROUND WASHERS (ASTM F436) (FWC160)
5	5/8" X 10" GUARDRAIL BOLTS AND NUTS (FBB03)
16	5/8" X 1-1/4" GUARDRAIL SPLICE BOLTS WITH DOUBLE RECESSED NUTS (ASTM A563) (FBB01)

POST AND BLOCK-OUT TYPES AVAILABLE

FOR WOOD POST

FOR STEEL POST

* "WOOD" INDICATES DIMENSIONS FOR BOTH ROUND AND RECTANGULAR WOOD POST SYSTEMS.

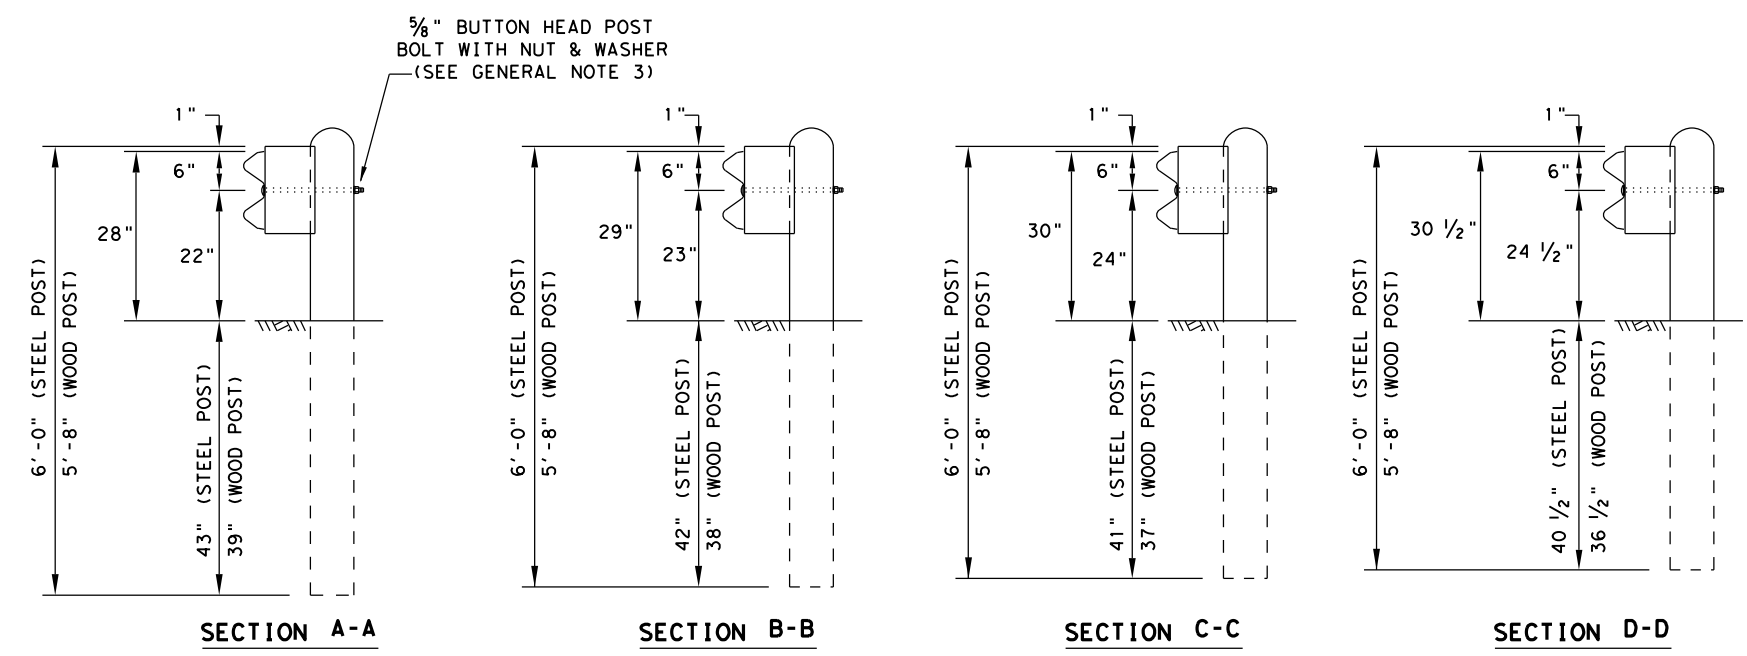

NOTE: HARDWARE SHALL MEET THE FOLLOWING REQUIREMENTS.




GUARDRAIL POST BOLTS (ASTM A307 GR. A)
 GUARDRAIL ROUND WASHERS (ASTM F436)
 GUARDRAIL DOUBLE RECESSED NUTS (ASTM A563)
 GUARDRAIL SPLICE BOLTS (ASTM A307 GR. A)
 GUARDRAIL SPLICE NUTS (ASTM A563)

		<i>Design Division Standard</i>	
METAL BEAM GUARD FENCE RAIL HEIGHT ADJUSTMENT (28" TO 31") TL-3 MASH COMPLIANT RAIL-ADJ(B)-19			
FILE: railadjb19	DN:TXDOT	CK: KM	DW: VP
©TXDOT: NOVEMBER 2019	CONT	SECT	JOB
REVISIONS	2311	01	044
	DIST	COUNTY	SHEET NO.
	WAC	MCLENNAN	36

DATE: 10/5/2022



DISCLAIMER: The use of this standard is governed by the "Texas Engineering Practice Act". No warranty of any kind is made by TxDOT for any purpose whatsoever. TxDOT assumes no responsibility for the conversion of this standard to other formats or for incorrect results or damages resulting from its use.

DATE: 10/5/2022 11:58:35 AM
 FILE: \\txdot\project\wiseonline.com:TXDOT3\Documents\09 - WAC\Design Projects\231101044\4 - Design\Plan Set\3. RoadwayStandards\BED-14.dgn

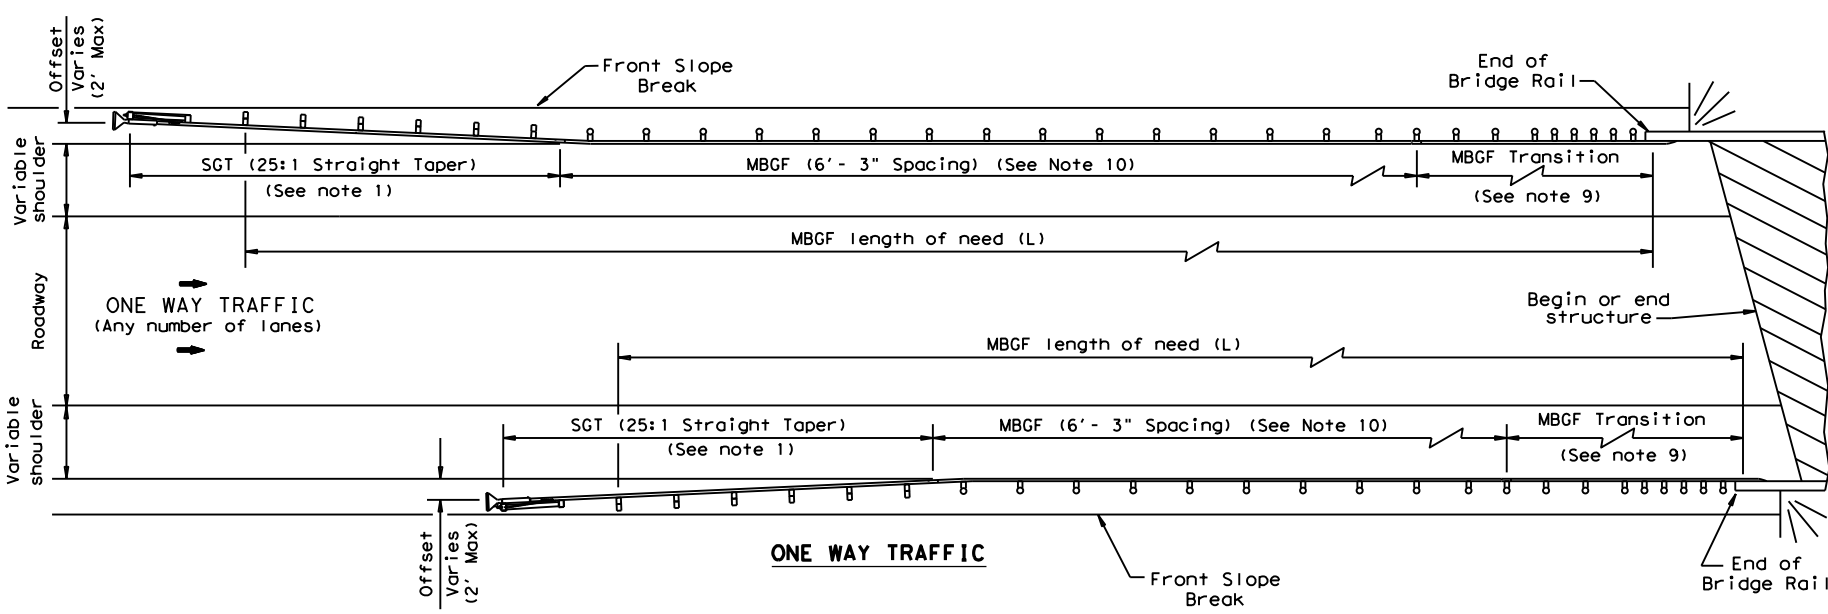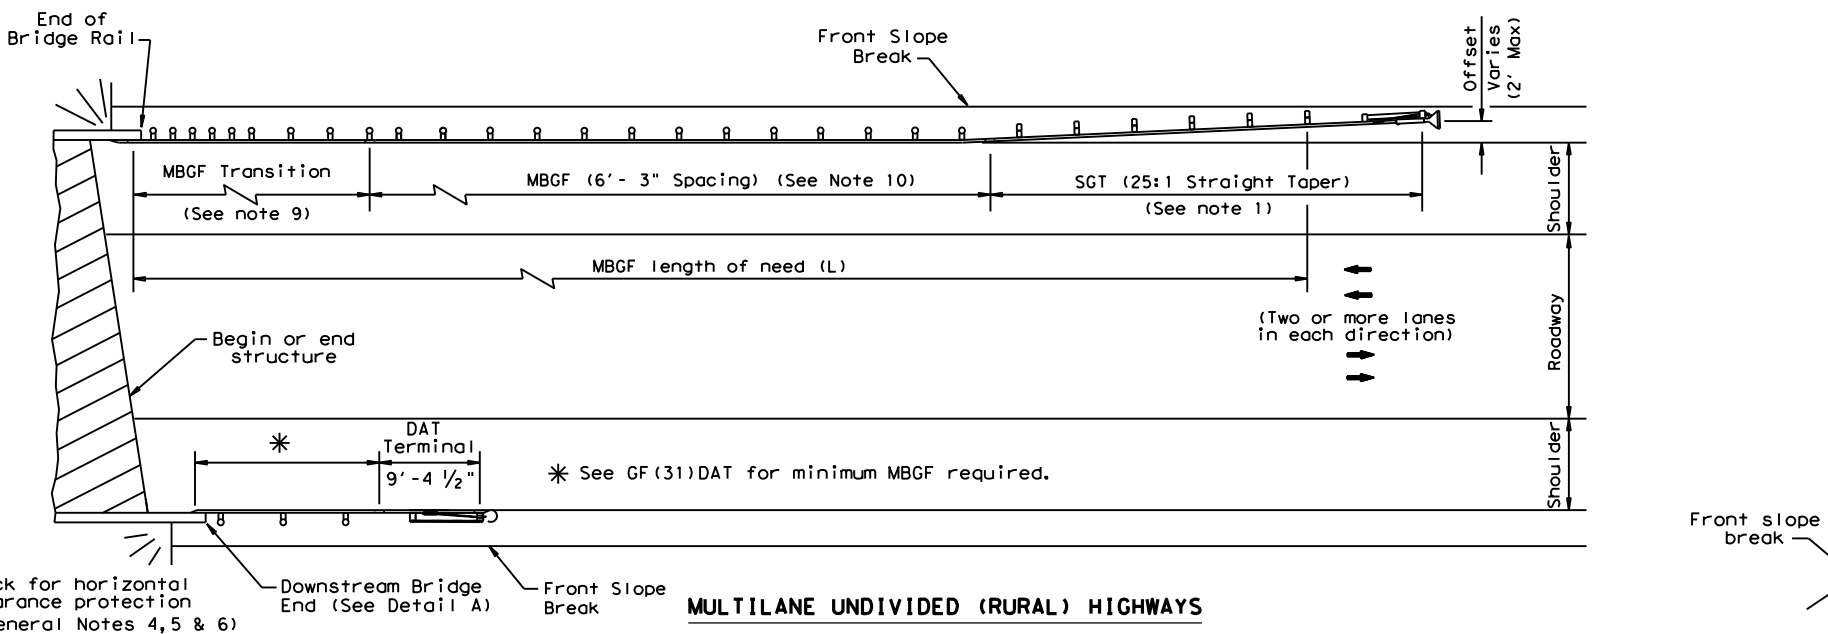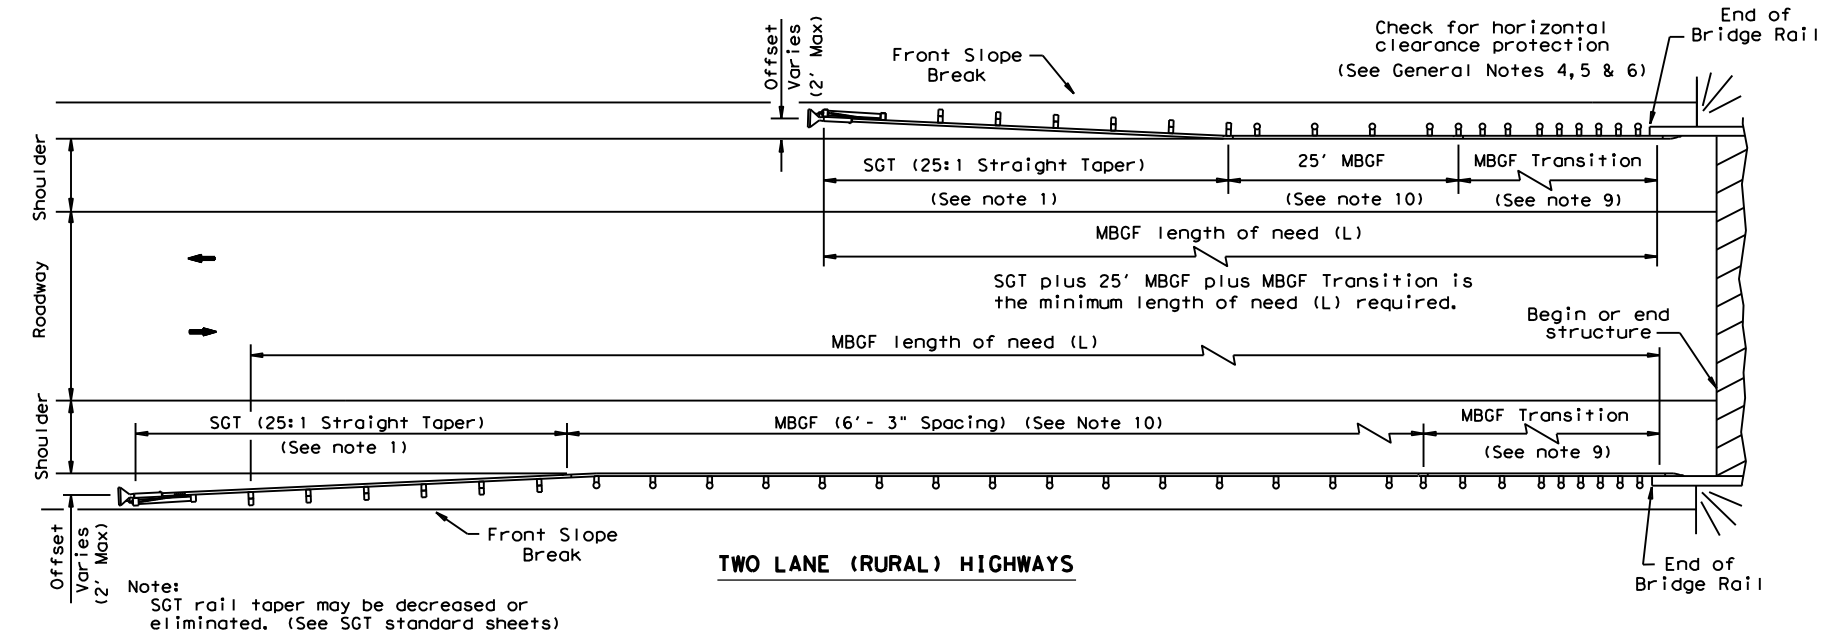

GENERAL NOTES

1. For more detail: See GF(31), SGT()31, GF(31)TR, and GF(31)TL2 standard sheets.
2. Quantities of metal beam guard fence (MBGF) at individual bridge ends are as shown in the plans.
3. Use average daily traffic (ADT) for the current year to determine MBGF length of need in accordance with the Roadway Design Manual unless otherwise specified. Where significant traffic volume growth is anticipated on low volume (0-750 ADT) highways, use length determinations for the higher volume category.
4. MBGF may not be required to shield departure end of bridge unless other obstacles within the horizontal clearance limits or opposing traffic indicate a MBGF consideration.
5. Downstream anchor terminals (DAT) are only for downstream end anchorage use, outside the horizontal clearance area of opposing traffic.
6. Direct connection of MBGF to concrete rails are only for downstream rail connections outside the horizontal clearance area of opposing traffic. (This requires a minimum of three standard line posts plus the DAT terminal, See Detail A)
7. The crown shall be widened to accommodate MBGF. Typically the "front slope" break should be 2'-0" from the back of the MBGF post. This applies to new construction on new alignment or where existing roadway cross section is to be widened to increase roadway width. This does not apply to rehabilitation work where existing roadway crown width is to be retained (See Typical Cross Section at MBGF).
8. For restrictive bridge widths: The MBGF should be properly transitioned from the existing bridge rail to the adjoining MBGF (See MBGF Transition Standards). Metal beam guard fence at these bridge locations shall be flared at the rate of 25:1 or flatter, and be of the length necessary to locate the terminal end at the 2 ft. "maximum" offset from the shoulder edge in the approach direction.
9. Transition length and post spacing will vary depending on the transition type. Transition type will be shown elsewhere in the plans.
10. A minimum 25' length of MBGF will be required.


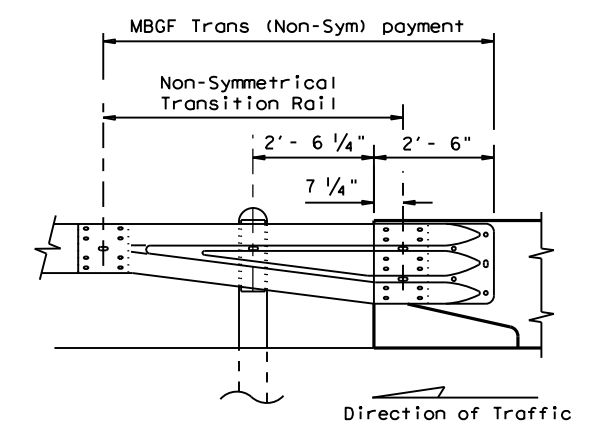
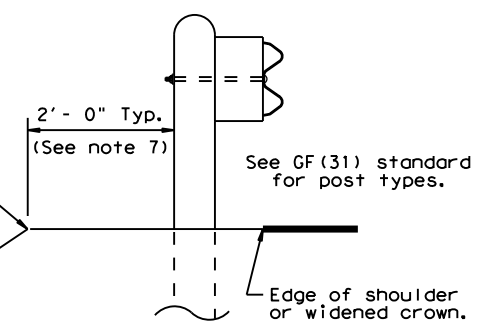


Note: All rail elements shall be lapped in the direction of adjacent traffic.

		Design Division Standard	
BRIDGE END DETAILS (METAL BEAM GUARD FENCE APPLICATIONS TO RIGID RAILS)			
BED-14			
FILE: bed14.dgn	DN: TxDOT	CK: AM	DW: BD/VP
© TxDOT: December 2011	CONT	SECT	JOB
REVISIONS	2311	01	044
REVISED APRIL 2014	DIST	COUNTY	SHEET NO.
SEE (MEMO 0414)	WAC	MCLENNAN	37



DISCLAIMER: The use of this standard is governed by the "Texas Engineering Practice Act". No warranty of any kind is made by TxDOT for any purpose whatsoever. TxDOT assumes no responsibility for the conversion of this standard to other formats or for incorrect results or damages resulting from its use.

DATE: 10/5/2022
 FILE: pw:\txdot\projectwiseonline.com:TXDOT3\Documents\09 - WAC\Design Projects\231101044V4 - Design\Plan Set\3 - RoadwayStandards\SSCB(2)-10.dgn

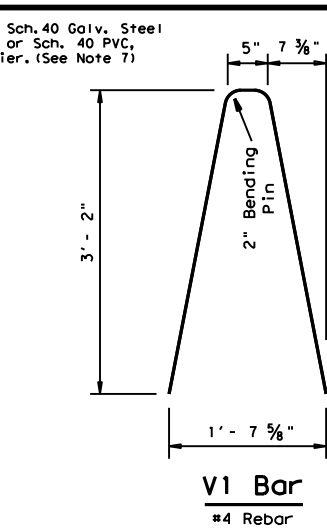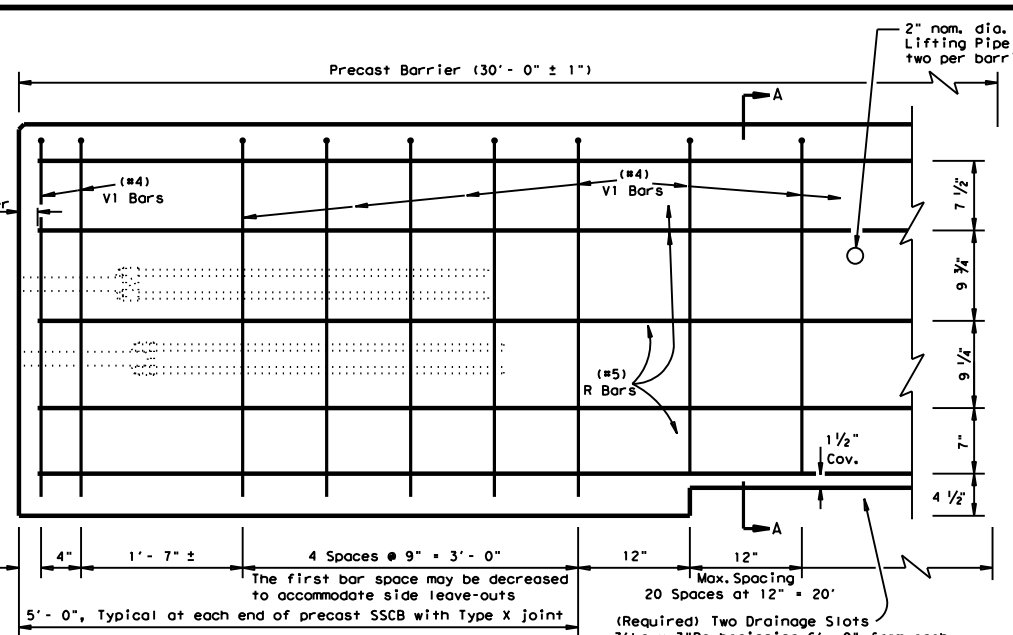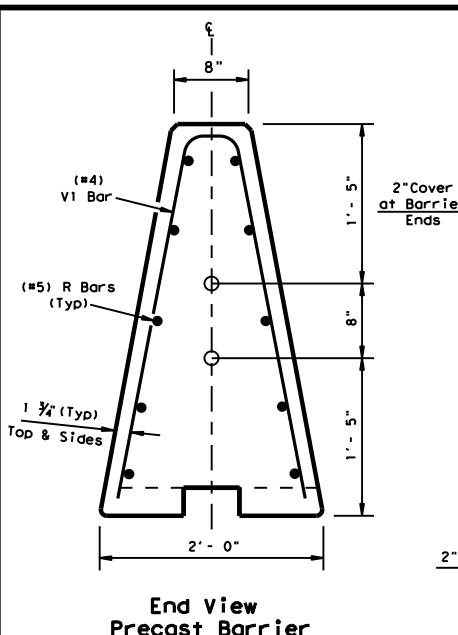


V1 Bar
 #4 Rebar

Note:
 V1 Bars above the drainage slots may be bent to accommodate 1 1/2" clear cover as directed by the Engineer.

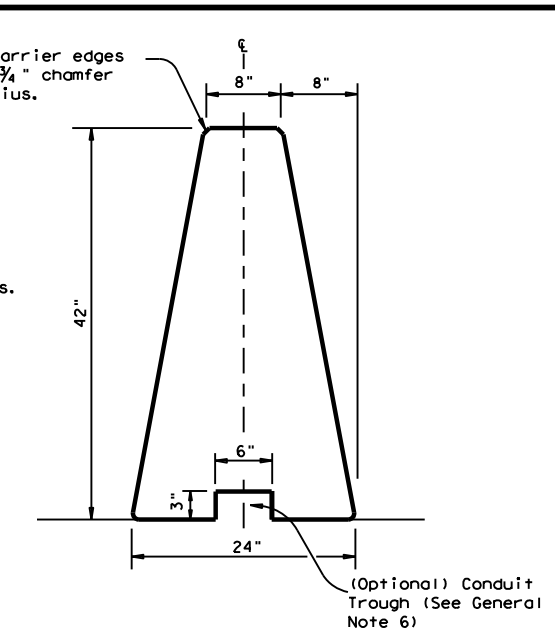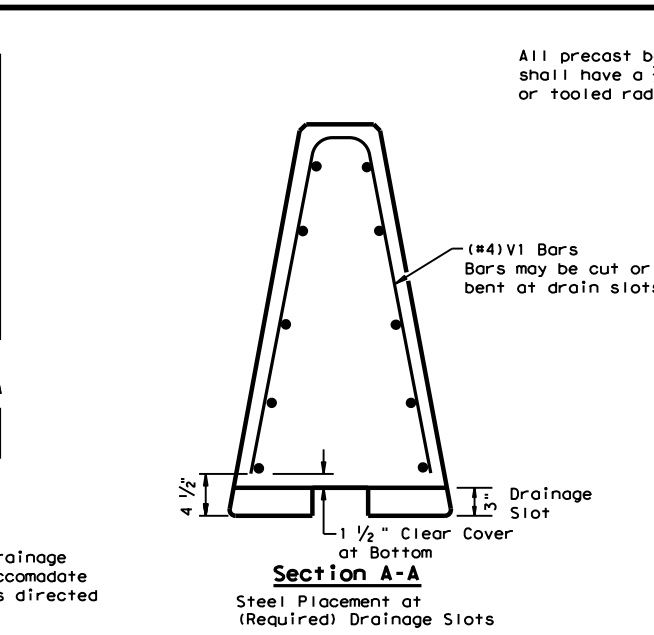


Single Slope Concrete Traffic Barrier

Precast SSCB barrier may be connected to cast-in-place SSBC. The joint connection "Types" may be used in the cast-in-place barrier, to match the precast barrier connection.

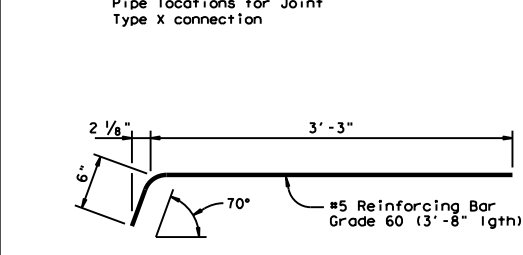


DEFORMED BAR ANCHOR DETAILS

Two (2) Bars required per assembly.
 Eight (8) required per Joint.

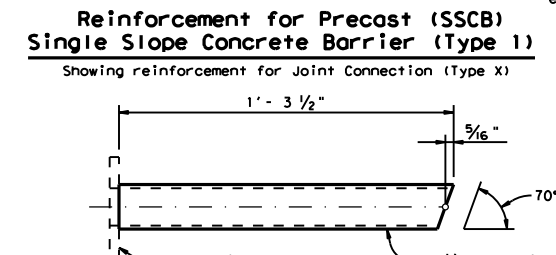


UPPER CONNECTION PIPE DETAILS

One (1) Steel Pipe required per Upper Assembly.
 Two (2) required per Joint.

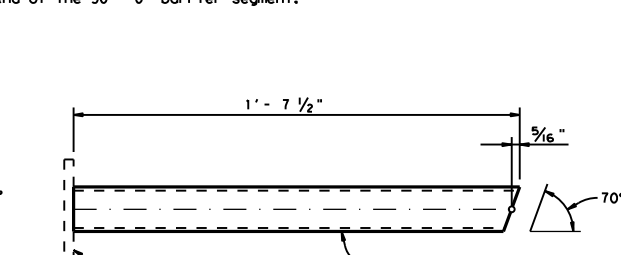


LOWER CONNECTION PIPE DETAILS

One (1) Steel Pipe required per Lower Assembly.
 Two (2) required per Joint.

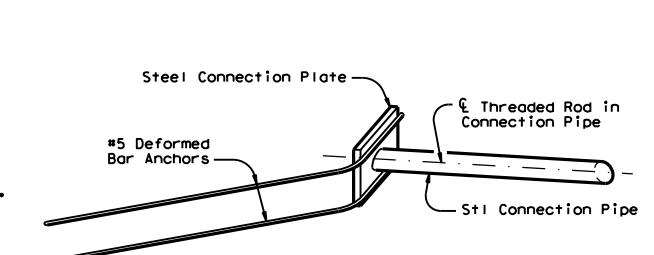


ISOMETRIC OF TYPICAL WELDED ASSEMBLY

Four (4) [2 Upper & 2 Lower] Assemblies required per Joint.

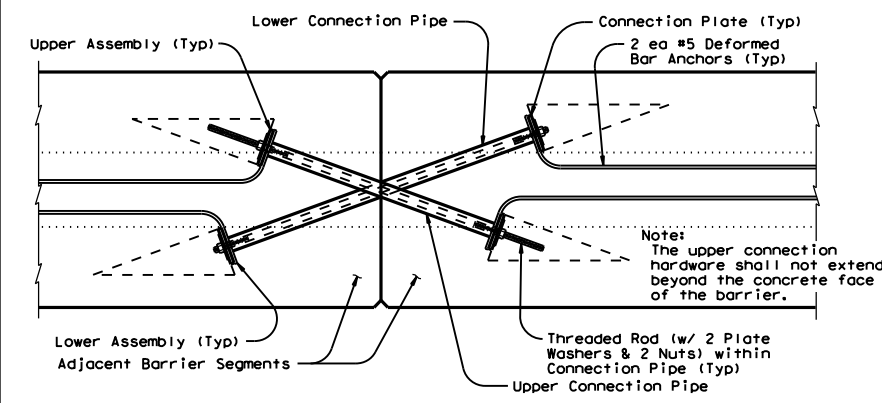


TYPE X JOINT INSTALLATION DETAIL

Barrier reinforcing and Type X Joint Leave-Out dimensions not shown for clarity.

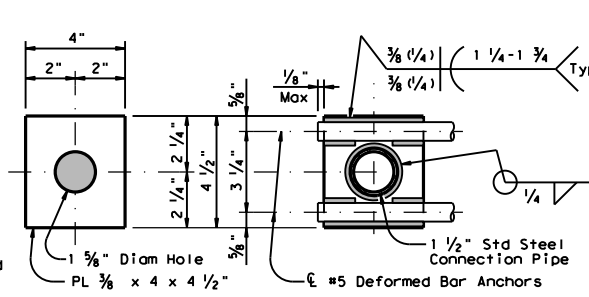

CONNECTION PLATE DETAILS


One (1) Plate required per assembly.
 Four (4) required per Joint. All steel fittings for joint Type X shall be galvanized after fabrication in accordance with Item 445.

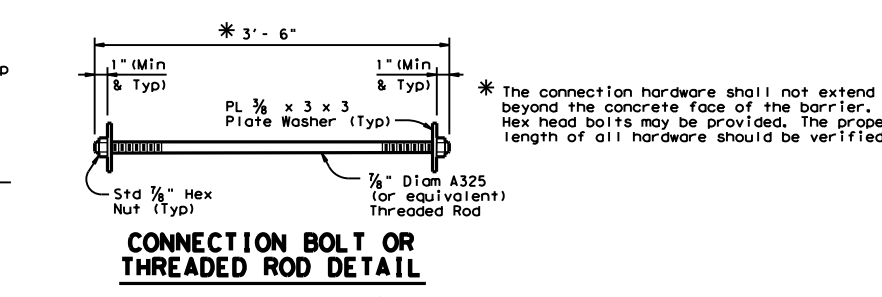

CONNECTION BOLT OR THREADED ROD DETAIL

Two (2) Threaded Rods (Or Equivalent Hex Hd. Bolts) (w/ Two (2) PL 3/8 x 3 x 3 Plate Washers & Two (2) Std Hex Nuts) required per Joint.


Weight of one precast 30 ft. (SSCB) segment = Approx. 10.5 Tons or 717 lbs per ft.

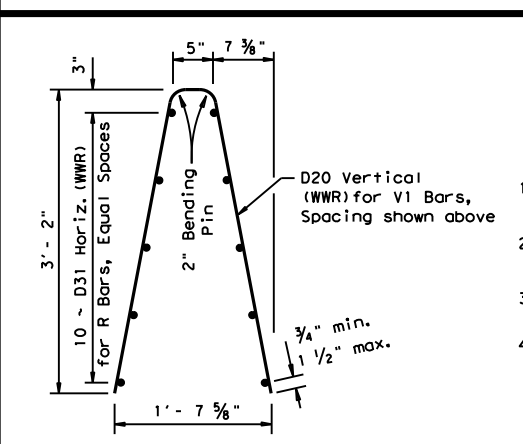

Welded Wire Reinforcement (WWR) Option for Bars R and V1

(WWR) General Notes

- Deformed Welded Wire Reinforcement (WWR) shall conform to ASTM A497.
- Welded wire cage may be cut or bent to accommodate the Type X joint connection and drainage slots, as directed by the Engineer.
- All reinforcement shall comply with Item 440, "Reinforcing Steel."
- Combinations of reinforcing steel and WWR will be permitted, as directed by the Engineer. The dimension from the end of the barrier section to the first wire shall not exceed 3".

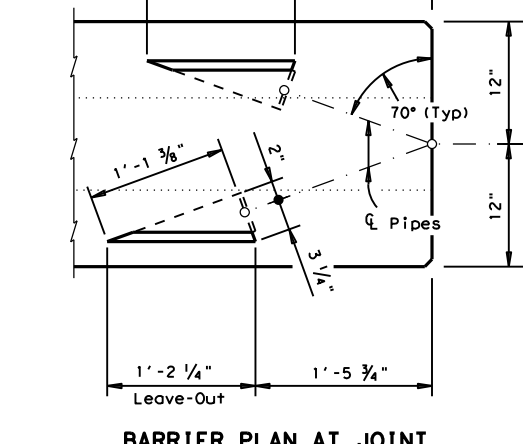

BARRIER PLAN AT JOINT

- General Notes**
- Concrete shall be Class H with a minimum compressive strength of 3,600 psi.
 - Where used, rebar reinforcement shall be Grade 60 and conform to ASTM A615.
 - Precast barrier length shall be 30 ft. unless otherwise specified on the plans.
 - All precast barrier edges shall have a 3/4" chamfer or a tooled radius.
 - All concrete, reinforcement, joint connection systems, grout etc. as shown, are considered as part of the barrier pavement.
 - Conduit trough when required shall be shown elsewhere on the plans, or as directed by the Engineer.
 - Regardless of the method of handling, barrier lifting points shall be approx. 7.5 feet from the ends of the barrier. Lifting devices and attachments to barrier sections shall be approved by the Engineer.
 - Surface finishing and grouting (where required) shall be two parts sand and one part cement with enough water to make the mixture plastic. Grouting shall be done in a manner that will assure a smooth surface. Surface finishing shall be considered subsidiary to the various bid items.
 - All steel assemblies shall be galvanized after fabrication in accordance with Item 445, "Galvanizing."


SHEET 1 OF 2

Design Division Standard


SINGLE SLOPE CONCRETE BARRIER
 PRECAST BARRIER (TYPE 1)
 SSCB(2)-10

FILE: sscb210.dgn	DN: TxDOT	CR: AM	DW: BD	CK:
© TxDOT December 2010	CONT	SECT	JOB	HIGHWAY
REVISIONS	2311	01	044	FM 3051
	DIST	COUNTY	SHEET NO.	
	WAC	MCLENNAN	38	


DATE: 10/5/2022
 FILE: \\txdot.projectwiseonline.com:TXDOT3\Documents\09 - WAC\Design Projects\231101044\4 - Design\Plan Set\3. RoadwayStandards\SSCB(2)-10.dgn
 DISCLAIMER: The use of this standard is governed by the "Texas Engineering Practice Act". No warranty of any kind is made by TxDOT for any purpose whatsoever. TxDOT assumes no responsibility for the conversion of this standard to other formats or for incorrect results or damages resulting from its use.

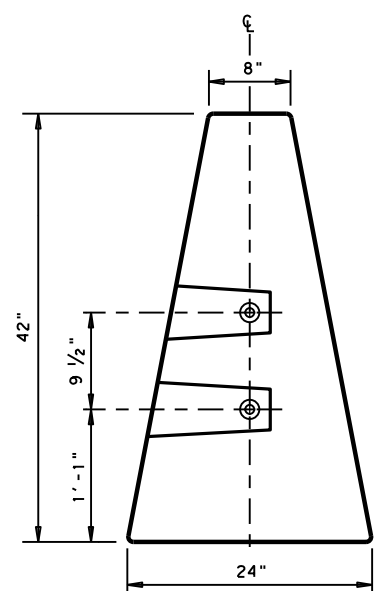

END VIEW
 "QUICK-BOLT" POCKET LOCATIONS

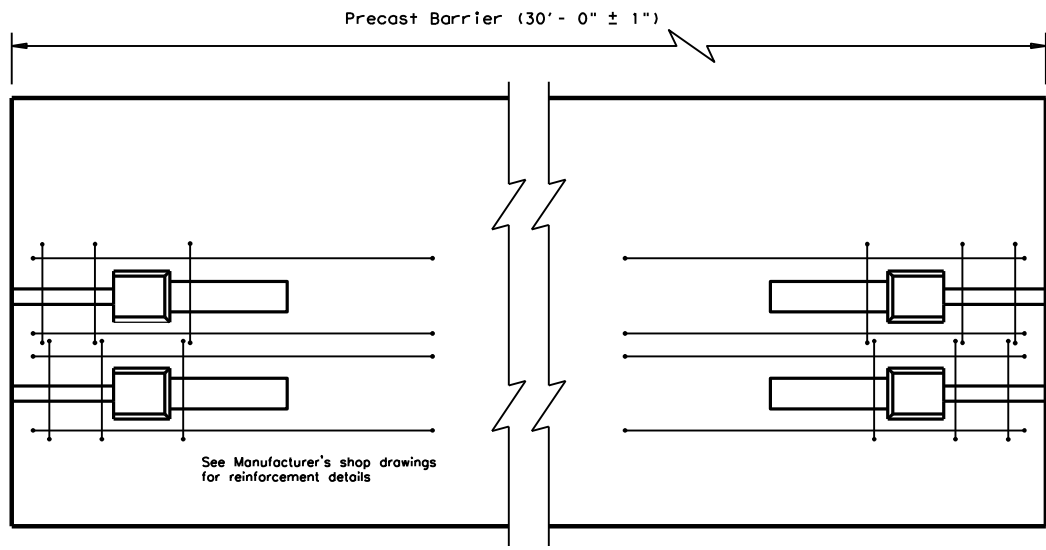


ELEVATION VIEW
 "QUICK-BOLT" (SSCB)
 See Manufacturer's shop drawing for additional details

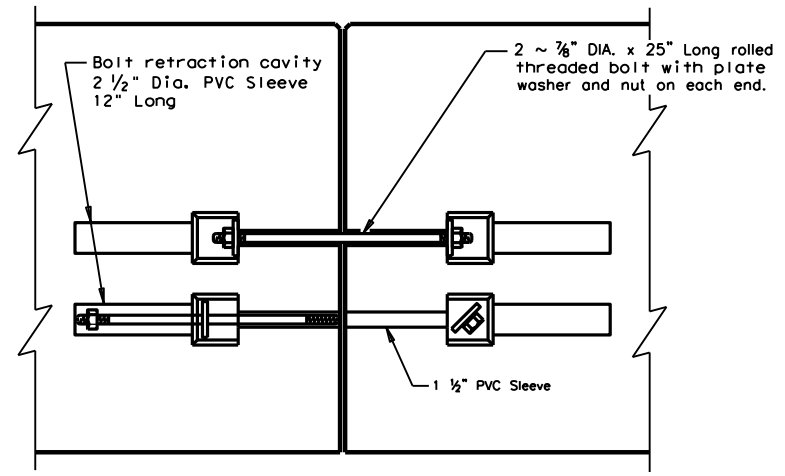


ELEVATION VIEW SHOWING JOINT CONNECTION
 "QUICK-BOLT"


Joint Connection (Type Q)

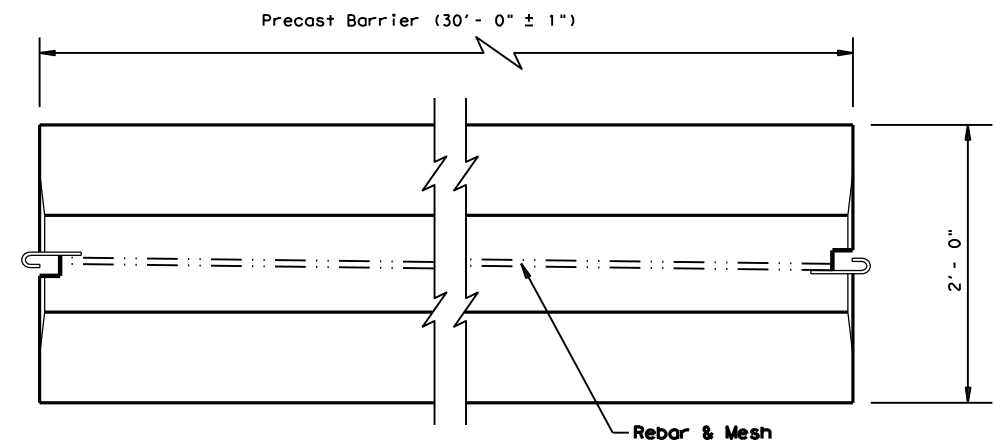

TOP VIEW
 PRECAST (SSCB) WITH J-J HOOKS
 See Manufacturer's shop drawing for additional details

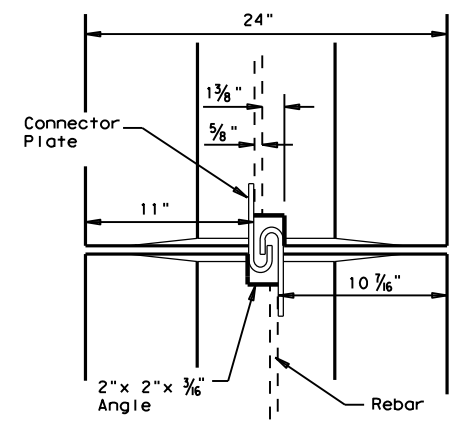

VIEW FROM ABOVE
 J-J HOOK CONNECTION

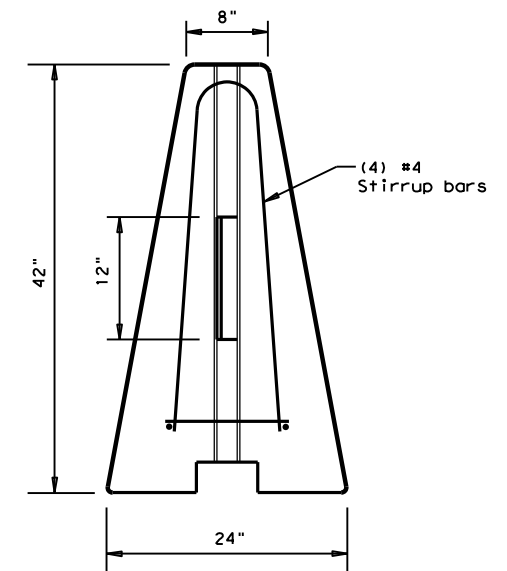


END VIEW

Proprietary Joint Connections (SSCB)


Two proprietary joint connections are acceptable as alternates to the (Type X) connection shown, here on. These joint connections types are:

J-J Hooks by Easi-Set Industries, (800)547-4045
 Quick-Bolt by Bexar Concrete, (210)497-3773


If one of these connection systems are exclusively specified in the plans, prior approval for sole source use must be obtained. Details of the connection components and barrier reinforcement for these systems, will be shown on the manufacturer's shop drawing(s) furnished to the Engineer.

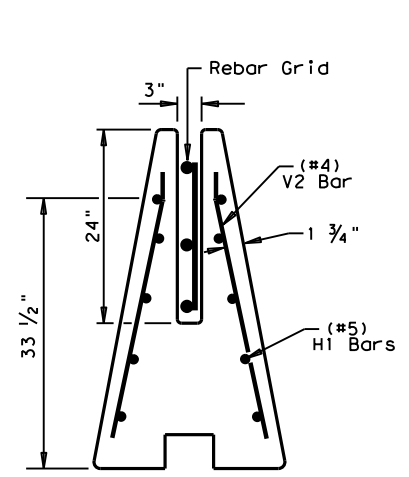


SECTION A-A
 Showing (Type R)
 Rebar Grid

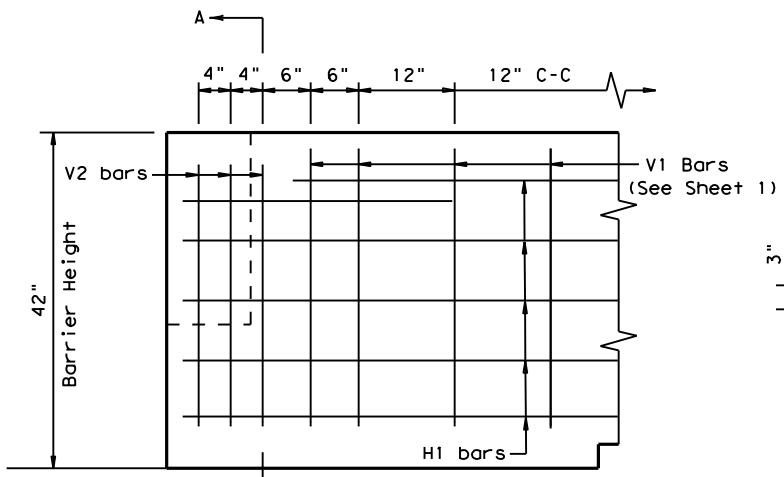


ELEVATION
 V1 Bars (See Sheet 1)

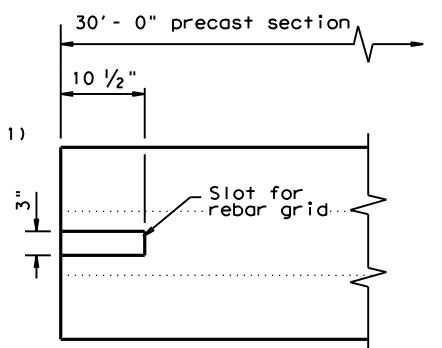

TOP VIEW
 JOINT CONNECTION
 Typical at both ends of barrier segment

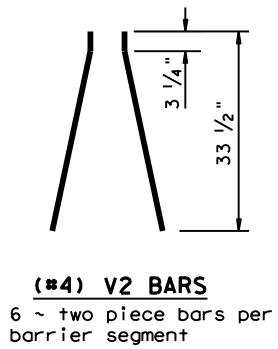

(#4) V2 BARS
 6 ~ two piece bars per barrier segment

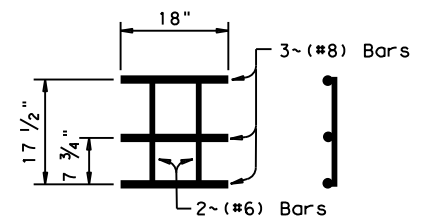

WELDED REBAR GRID

Joint Connection (Type R)

SHEET 2 OF 2


Design Division Standard

SINGLE SLOPE CONCRETE BARRIER
 PRECAST BARRIER (TYPE 1)
SSCB(2)-10


FILE: sscb210.dgn	DN: TxDOT	CK: AM	DW: VP	CK:
©TxDOT December 2010	CONT	SECT	JOB	HIGHWAY
REVISIONS	2311	01	044	FM 3051
	DIST	COUNTY	SHEET NO.	
	WAC	MCLENNAN	39	

DISCLAIMER: The use of this standard is governed by the "Texas Engineering Practice Act". No warranty of any kind is made by TxDOT for any purpose whatsoever. TxDOT assumes no responsibility for the conversion of this standard to other formats or for incorrect results or damages resulting from its use.


DATE: 10/5/2022
 FILE: \\txdot.projectwiseonline.com:TXDOT3\Documents\09 - WAC\Design Projects\231101044\4 - Design\Plan Set\3 - Roadway Standards\SSCB(5)-10.dgn

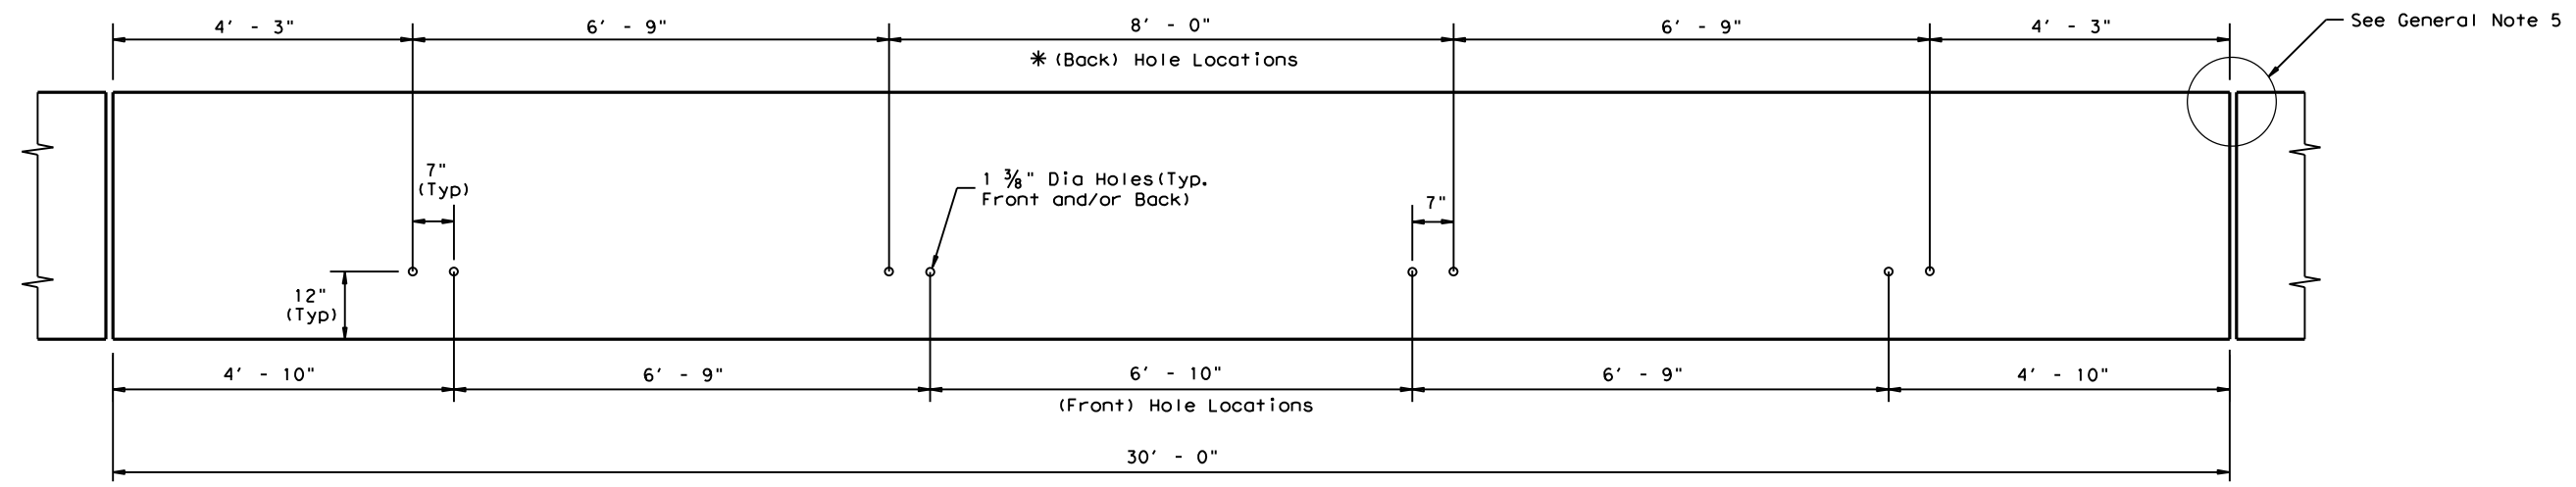

DETAIL 1
 Precast SSCB (42")
 Showing hole locations

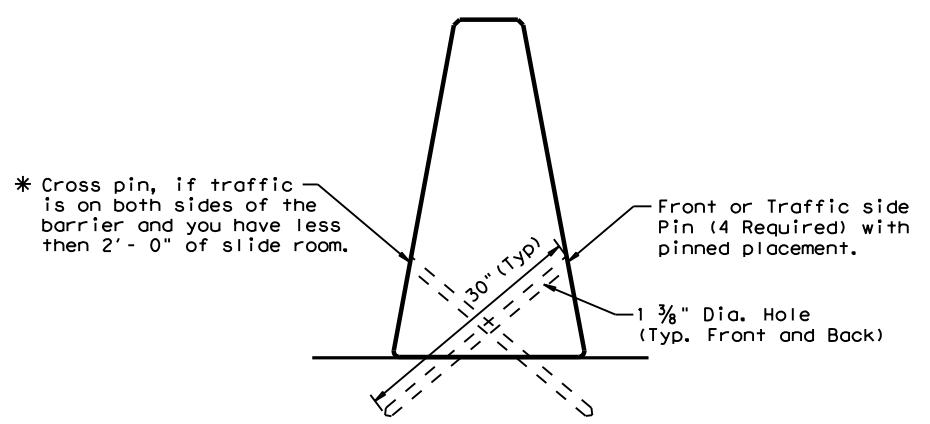

DETAIL 2
 Placement on (ACP)
 Asphalt Conc. Pavement
 or Treated Base Material
 (30" Pin required)

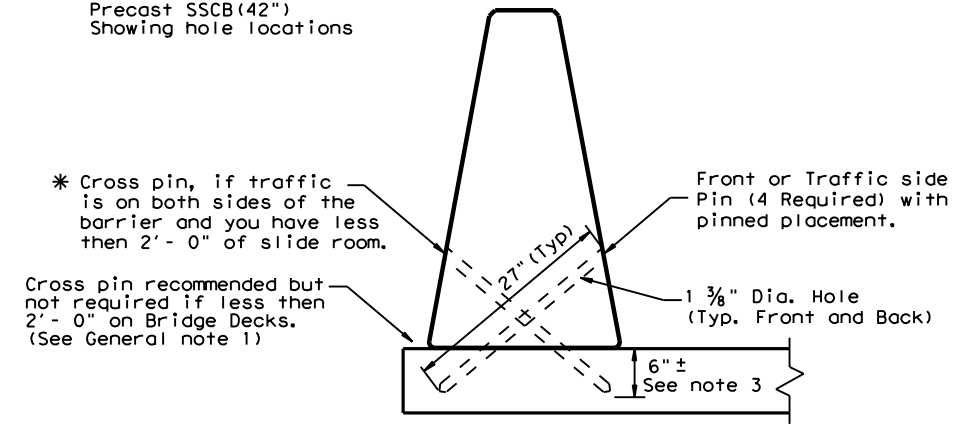


DETAIL 3
 Bridge Deck or CRCP
 (27" Pin required).

GENERAL NOTES


1. These details provide a method of laterally restraining precast concrete barrier to limit deflections under normally expected passenger vehicle impacts. These details are intended for use in work zones, primarily on bridge decks, or pavement where temporary barrier must be placed less than 2 ft. from the longitudinal edge of the deck or dropoff and parallel to the direction of travel. Other applications of these details are acceptable as directed by the Engineer.
2. Each precast concrete barrier section shall have a minimum of four or total of eight 1 3/8 in. ID holes formed or cored through the barrier. The center lines of the holes are shown in the hole location detail. If rebar is encountered, the entry point may be shifted 2" plus or minus longitudinally along the barrier. The eight holes are spaced along the length of the barrier as shown in Detail 1.
3. The drilling of the travel surface is accomplished by placing the pre-drilled barrier section on the travel surface in the desired position. Then the hole is drilled with the bit passing through the hole in the barrier. The bit is to be inserted into the hole in the barrier so that the travel surface is drilled to a point which is slightly more than the pin length.
4. Note that steel washers have been welded to the top of the steel pins to aid in the removal of the pins, when the barrier is removed.
5. See SSCB(2) standard sheet for reinforcement requirements and joint connection types.
6. The forming or coring of holes in the barrier, drilling of holes in bridge deck or pavement, fabrication and materials for the 1/4 in. pins, installation of pins, and any repair to the barrier shall be considered as subsidiary to the barrier bid items.
7. The barrier and travel surface will be repaired as directed by the Engineer in accordance with Item 429, "Concrete Structure Repair."
8. All steel pins shall be galvanized after fabrication in accordance with Item 445, "Galvanizing."
9. Weight of barrier is approx. 700 lbs per foot.

CORE DRILLING EXISTING BARRIER


Core drilling existing concrete barrier is permitted. Holes shall be drilled with coring or masonry drilling type equipment. Percussion (star) drilling shall not be used. A special drill bit (to cut through existing reinforcing) will likely be required. Spalls in the concrete exceeding 1/2" shall be patched.

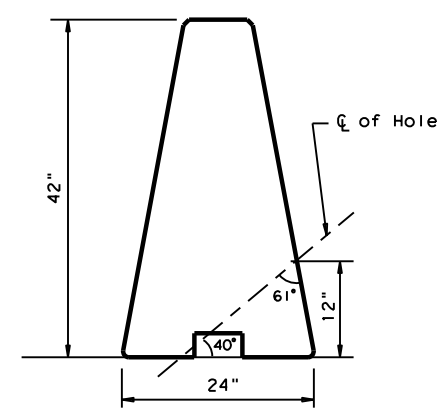


HOLE LOCATION DETAIL

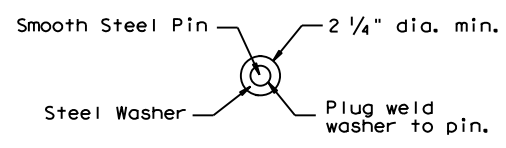


VIEW A-A

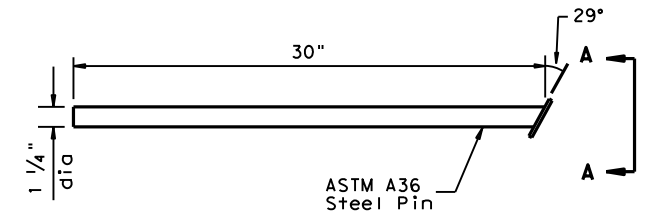

(30") PIN DETAIL
 See Detail 2

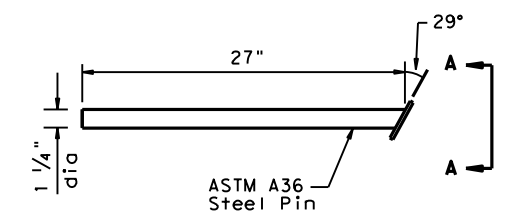

(27") PIN DETAIL
 See Detail 3

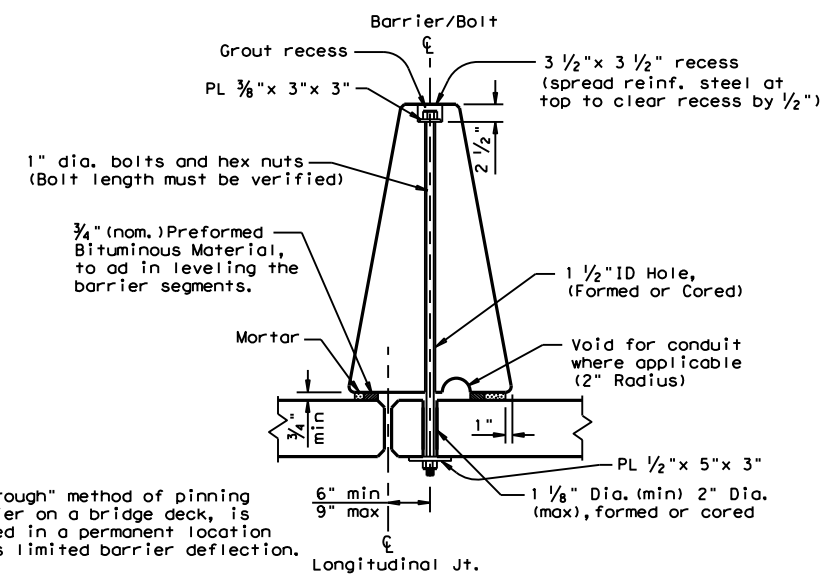

Note:
 The "Bolt Through" method of pinning precast barrier on a bridge deck, is primarily used in a permanent location that requires limited barrier deflection.


PRECAST SSCB (BOLT THROUGH) PLACEMENT OVER LONGITUDINAL EXPANSION JOINT

For bolt through locations, use the (Front) hole locations shown on Detail 1.

		Design Division Standard	
SINGLE SLOPE CONCRETE BARRIER PRECAST BARRIER (TYPE 1) PINNED PLACEMENT SSCB(5) - 10			
FILE: sscb510.dgn	DN: TxDOT	CK: AM	DW: BD
© TxDOT December 2010	CONT: 2311	SECT: 01	JOB: 044
REVISIONS	2311	01	FM 3051
DIST: WAC	COUNTY: MCLENNAN	SHEET NO. 40	


DISCLAIMER: The use of this standard is governed by the "Texas Engineering Practice Act". No warranty of any kind is made by TxDOT for any purpose whatsoever. TxDOT assumes no responsibility for the conversion of any information from a previous version of this standard to a newer version.

DATE: 10/5/2022
 FILE: \\twdot\project\wiseonline.com\TXDOT3\Documents\09 - WAC\Design Projects\09044\09044.dgn



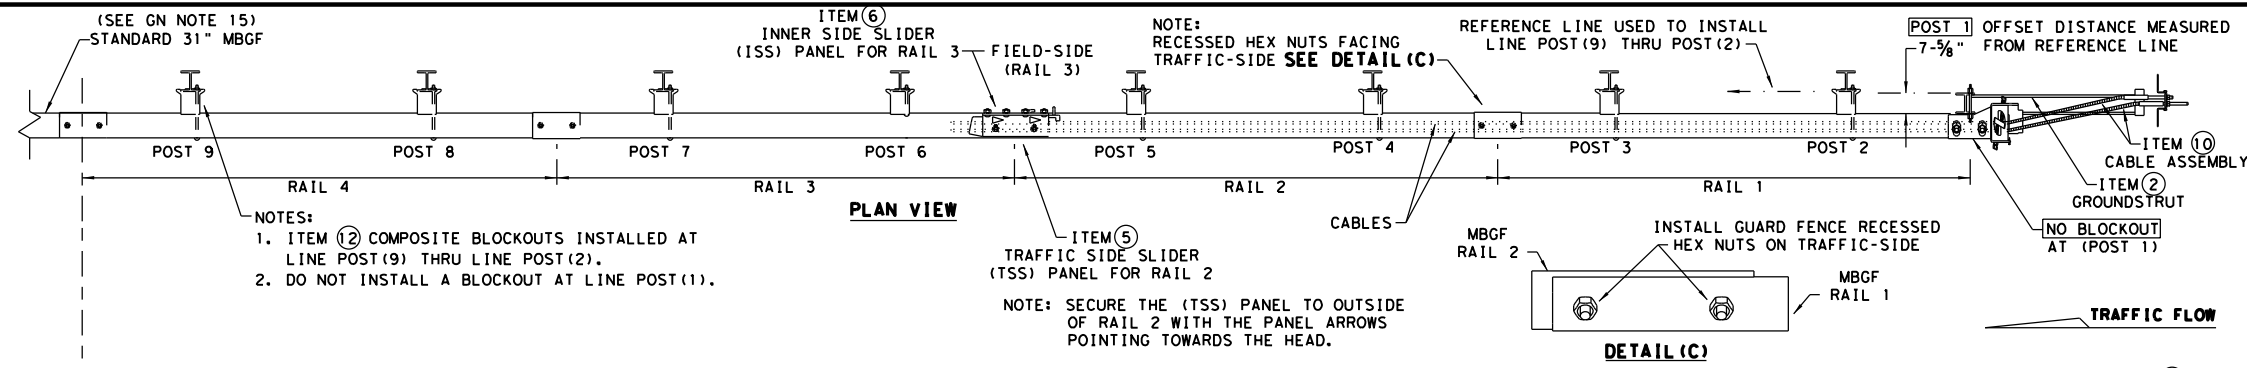


NOTES:
 1. ITEM (2) COMPOSITE BLOCKOUTS INSTALLED AT LINE POST (9) THRU LINE POST (2).
 2. DO NOT INSTALL A BLOCKOUT AT LINE POST (1).


NOTE: RECESSED HEX NUTS FACING TRAFFIC-SIDE SEE DETAIL (C)
 NOTE: SECURE THE (TSS) PANEL TO OUTSIDE OF RAIL 2 WITH THE PANEL ARROWS POINTING TOWARDS THE HEAD.

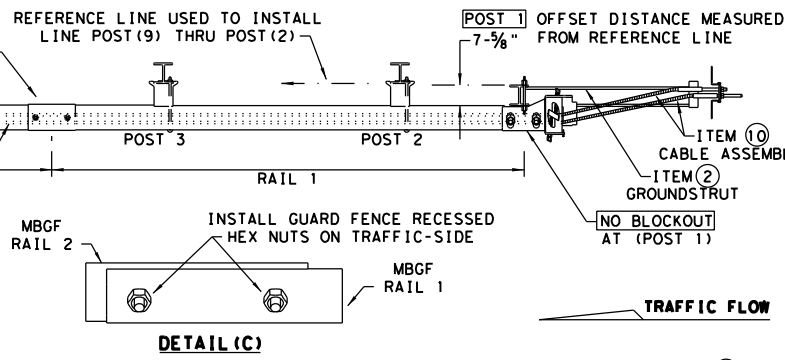


- GENERAL NOTES**
- FOR SPECIFIC INFORMATION REGARDING INSTALLATION AND TECHNICAL GUIDANCE OF THE SYSTEM, CONTACT: LINDSAY TRANSPORTATION SOLUTIONS (LTS) - BARRIER SYSTEMS, INC. AT (707) 374-6800
 - FOR INSTALLATION, REPAIR, & MAINTENANCE REFER TO THE: MAX-TENSION INSTALLATION INSTRUCTION MANUAL, P/N MANMAX REV D (ECN 3516).
 - APPLY HIGH INTENSITY REFLECTIVE SHEETING, "OBJECT MARKER" ON THE FRONT FACE OF THE DEVICE PER MANUFACTURER'S RECOMMENDATIONS. OBJECT MARKER SHALL CONFORM TO THE STANDARDS REQUIRED IN TEXAS MUTCD.
 - FOR POST (LEAVE-OUT) INSTALLATION AND GUIDANCE SEE TXDOT'S LATEST ROADWAY MOW STRIP STANDARD.
 - ALL STEEL COMPONENTS ARE GALVANIZED PER ASTM A123 OR EQUIVALENT UNLESS OTHERWISE STATED.
 - SYSTEM SHOWN USING STEEL WIDE FLANGE POST WITH COMPOSITE BLOCKOUTS.
 - COMPOSITE MATERIAL BLOCKOUT THAT MEETS THE REQUIREMENTS OF DMS-7210, MAY BE SUBSTITUTED FOR BLOCKOUTS SIMILAR DIMENSIONS. SEE CONSTRUCTION DIVISION MATERIAL PRODUCER LIST (MPL) FOR CERTIFIED PRODUCERS.
 - REFER TO INSTALLATION MANUAL FOR SPECIFIC PANEL LAPPING GUIDANCE.
 - IF SOLID ROCK IS ENCOUNTERED SEE THE MANUFACTURER'S INSTALLATION MANUAL FOR INSTALLATION GUIDANCE.
 - POSTS SHALL NOT BE SET IN CONCRETE.
 - A DRIVING CAP WITH A TIMBER OR PLASTIC INSERT SHALL BE USED WHEN DRIVING POST TO PREVENT DAMAGE TO THE GALVANIZING ON TOP OF THE POST.
 - MAX-TENSION SYSTEM SHALL NEVER BE INSTALLED WITHIN A CURVED SECTION OF GUARDRAIL.
 - IF A DELINEATION MARKER IS REQUIRED, MARKER SHALL BE IN ACCORDANCE WITH TEXAS MUTCD.
 - THE SYSTEM IS SHOWN WITH 12'-6" MBGF PANELS, 25'-0" MBGF PANELS ARE ALSO ALLOWED.
 - A MINIMUM OF 12'-6" OF 12GA. MBGF IS REQUIRED IMMEDIATELY DOWNSTREAM OF THE MAX-TENSION SYSTEM.

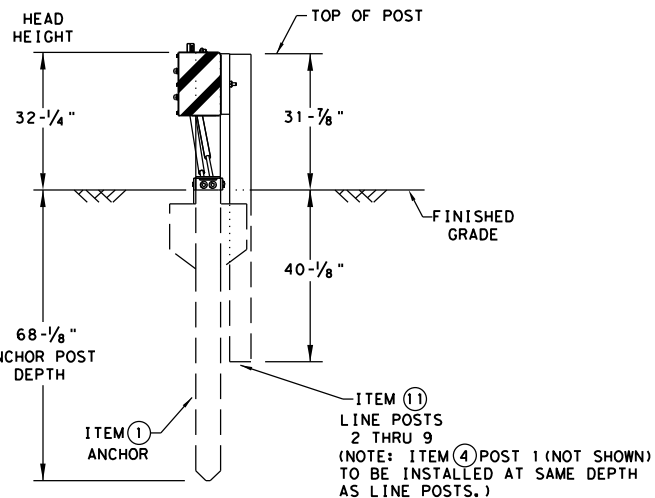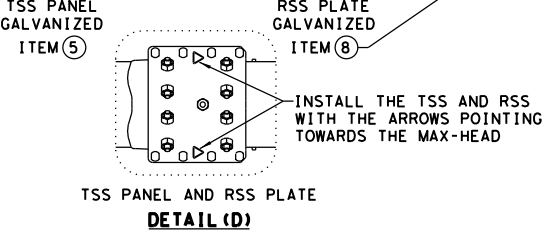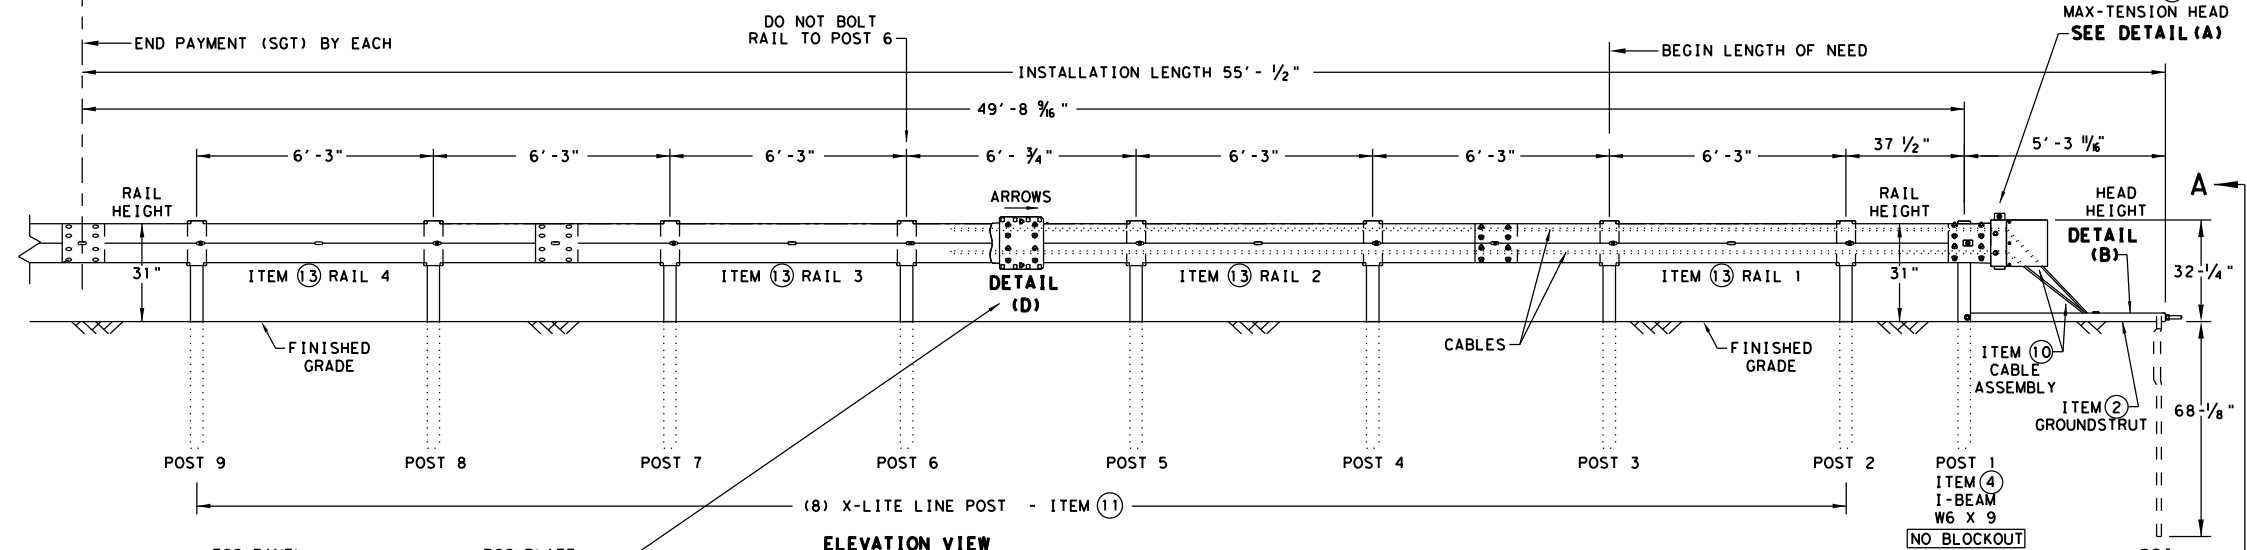

SECTION VIEW A-A
 SOIL ANCHOR, POST 1 & LINE POST 2 THRU 9

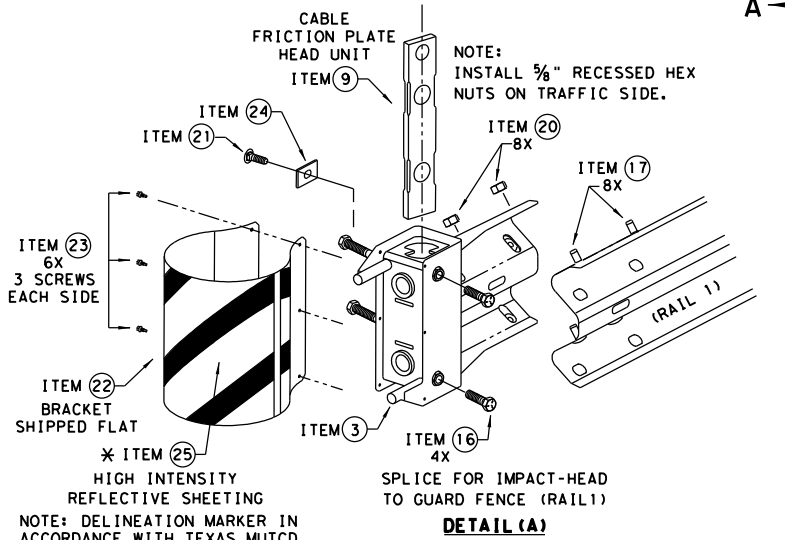

ITEM #	PART NUMBER	DESCRIPTION	QTY
1	BSI-1610060-00	SOIL ANCHOR - GALVANIZED	1
2	BSI-1610061-00	GROUND STRUT - GALVANIZED	1
3	BSI-1610062-00	MAX-TENSION IMPACT HEAD	1
4	BSI-1610063-00	W6x9 I-BEAM POST 6FT. -GALVANIZED	1
5	BSI-1610064-00	TSS PANEL - TRAFFIC SIDE SLIDER	1
6	BSI-1610065-00	ISS PANEL - INNER SIDE SLIDER	1
7	BSI-1610066-00	TOOTH - GEOMET	1
8	BSI-1610067-00	RSS PLATE - REAR SIDE SLIDER	1
9	B061058	CABLE FRICTION PLATE - HEAD UNIT	1
10	BSI-1610069-00	CABLE ASSEMBLY - MASH X-TENSION	2
11	BSI-1012078-00	X-LITE LINE POST-GALVANIZED	8
12	B090534	8" W-BEAM COMPOSITE-BLOCKOUT XT110	8
13	BSI-4004386	12'-6" W-BEAM GUARD FENCE PANELS 12GA.	4
14	BSI-1102027-00	X-LITE SQUARE WASHER	1
15	BSI-2001886	5/8" X 7" THREAD BOLT HH (GR.5)GEOMET	1
16	BSI-2001885	3/4" X 3" ALL-THREAD BOLT HH (GR.5)GEOMET	4
17	4001115	5/8" X 1 1/4" GUARD FENCE BOLTS (GR.2)MGAL	48
18	2001840	5/8" X 10" GUARD FENCE BOLTS MGAL	8
19	2001636	5/8" WASHER F436 STRUCTURAL MGAL	2
20	4001116	5/8" RECESSED GUARD FENCE NUT (GR.2)MGAL	59
21	BSI-2001888	5/8" X 2" ALL THREAD BOLT (GR.5)GEOMET	1
22	BSI-1701063-00	DELINEATION MOUNTING (BRACKET)	1
23	BSI-2001887	1/4" X 3/4" SCREW SD HH 410SS	7
24	4002051	GUARDRAIL WASHER RECT AASHTO FWRO3	1
25	SEE NOTE BELOW	HIGH INTENSITY REFLECTIVE SHEETING	1
26	4002337	8" W-BEAM TIMBER-BLOCKOUT, PDB01B	8
27	BSI-4004431	25' W-BEAM GUARDRAIL PANEL, 8-SPACE, 12GA.	2
28	MANMAX Rev-(D)	MAX-TENSION INSTALLATION INSTRUCTIONS	1

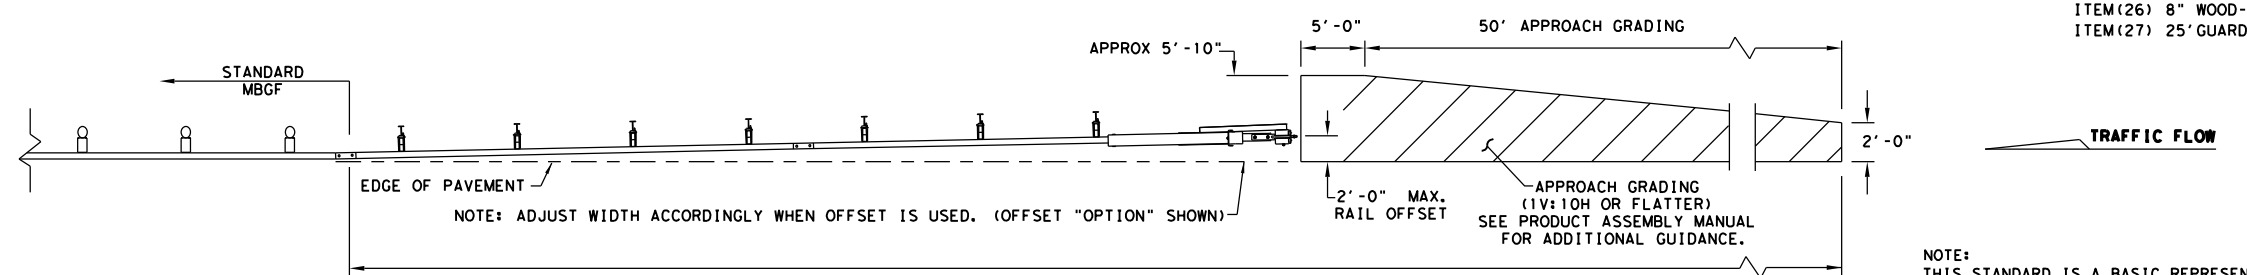

APPROACH GRADING AT GUARDRAIL END TREATMENTS


NOTE: THIS STANDARD IS A BASIC REPRESENTATION OF THE MAX-TENSION END TERMINAL, IT IS NOT INTENDED TO REPLACE THE PRODUCT DESCRIPTION ASSEMBLY MANUAL.

Texas Department of Transportation
 Design Division Standard

MAX-TENSION END TERMINAL
MASH - TL-3
SGT (11S) 31-18

FILE: sg11s3118.dgn	DN: TxDOT	CK: KM	DW: TxDOT	CK: CL
© TxDOT: FEBRUARY 2018	CONT	SECT	JOB	HIGHWAY
REVISIONS	2311	01	044	FM 3051
	DIST	COUNTY		SHEET NO.
	WAC	MCLENNAN		41



DATE: 10/5/2022
 FILE: \\txdot\projectwiseonline.com:TXDOT3\Documents\09 - WAC\Design Projects\231101044\4 - Design\Plan Set\3 - RoadwayStandards\SGT(12S)31-18.dgn
 DISCLAIMER: THIS STANDARD IS GOVERNED BY THE "TEXAS ENGINEERING PRACTICE ACT". NO WARRANTY OF ANY KIND IS MADE BY TXDOT FOR ANY PURPOSE WHATSOEVER. TXDOT ASSUMES NO RESPONSIBILITY FOR THE CONVERSION OF THIS STANDARD TO OTHER FORMATS OR FOR INCORRECT RESULTS OR DAMAGES RESULTING FROM ITS USE.

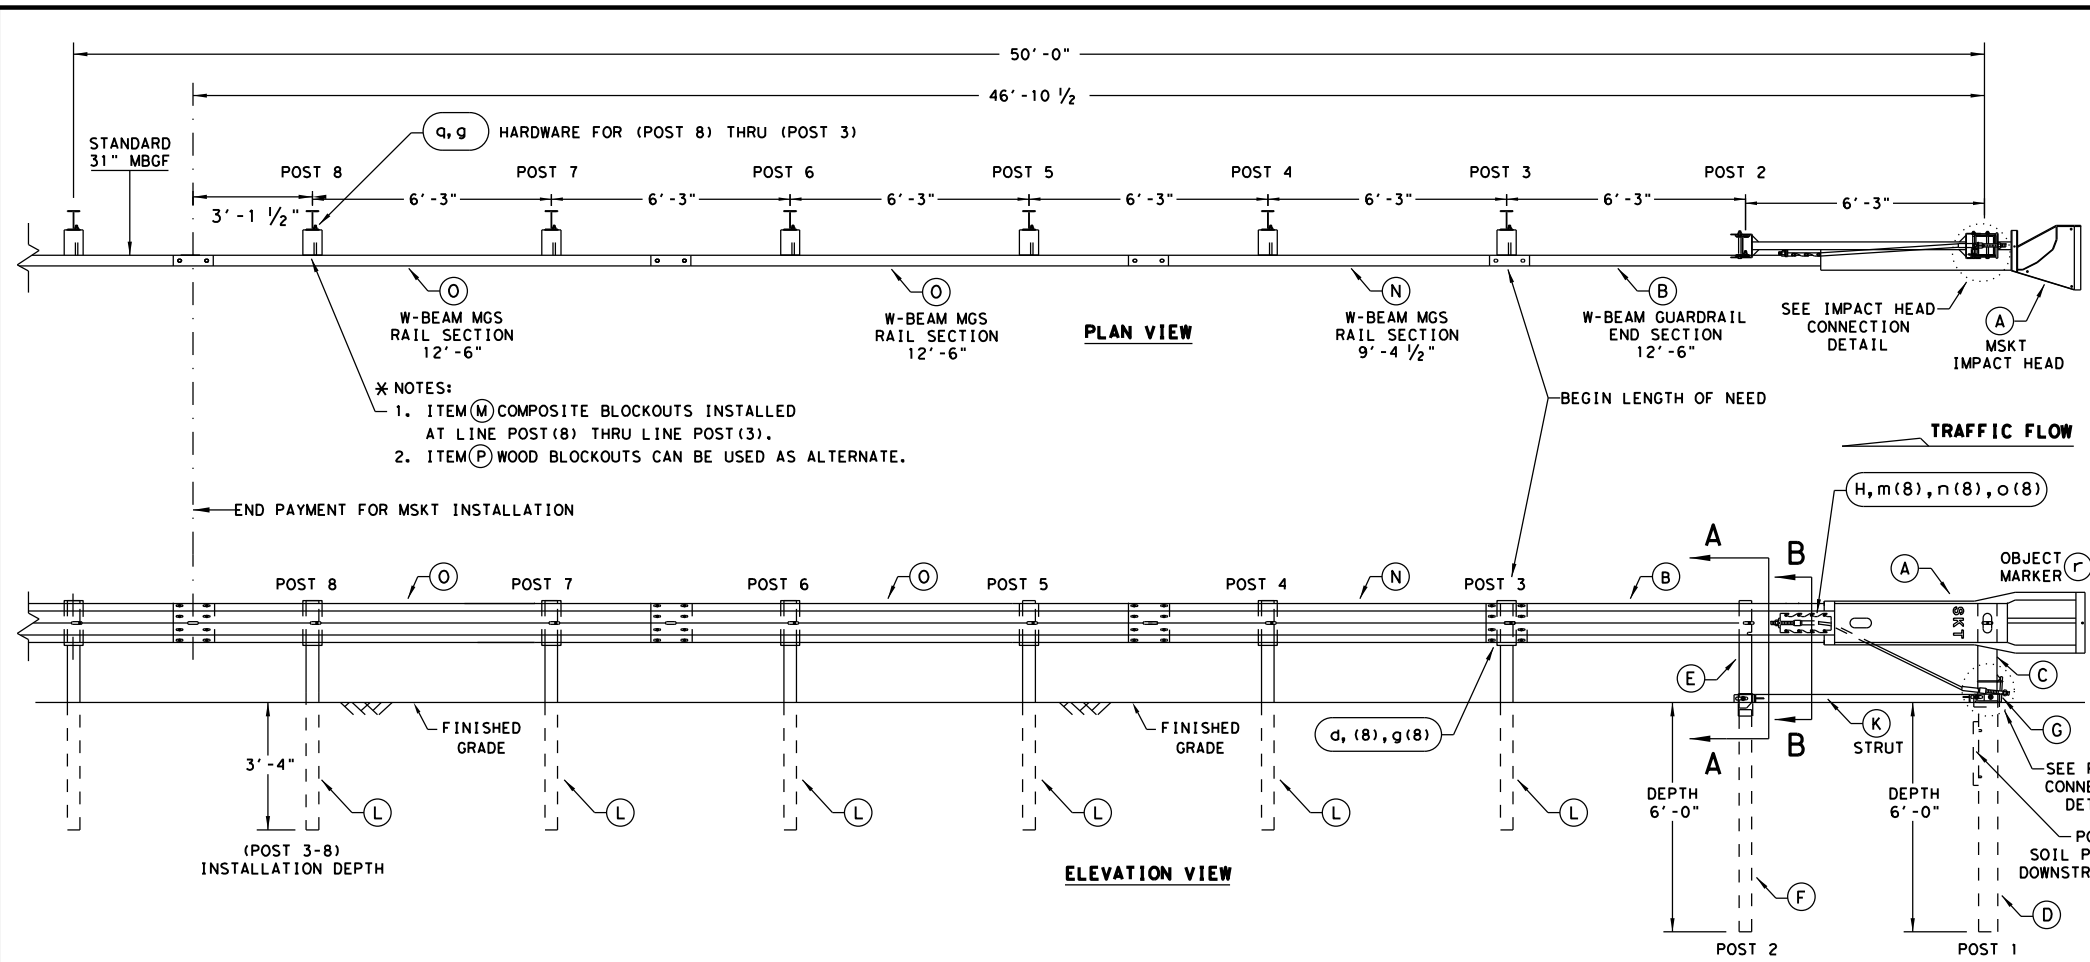


- * NOTES:**
- ITEM (M) COMPOSITE BLOCKOUTS INSTALLED AT LINE POST (8) THRU LINE POST (3).
 - ITEM (P) WOOD BLOCKOUTS CAN BE USED AS ALTERNATE.

- GENERAL NOTES**
- FOR SPECIFIC INFORMATION REGARDING INSTALLATION AND TECHNICAL GUIDANCE OF THE SYSTEM, CONTACT: ROAD SYSTEMS, INC. (432)263-2435. 3616 OLD HOWARD COUNTY AIRPORT, BIG SPRING, TX 79720
 - FOR INSTALLATION, REPAIR AND MAINTENANCE REFER TO THE: MSKT END TERMINAL, PRODUCT DESCRIPTION ASSEMBLY MANUAL (PUBLICATION-062717).
 - APPLY HIGH INTENSITY REFLECTIVE SHEETING, "OBJECT MARKER" ON THE FRONT FACE OF THE DEVICE PER MANUFACTURER'S RECOMMENDATIONS. OBJECT MARKER SHALL CONFORM TO THE STANDARDS REQUIRED IN TEXAS MUTCD.
 - FOR POST (LEAVE-OUT) INSTALLATION AND GUIDANCE SEE TXDOT'S LATEST ROADWAY MOW STRIP STANDARD.
 - HARDWARE (BOLTS, NUTS, & WASHERS) SHALL BE GALVANIZED IN ACCORDANCE WITH ITEM 445, "GALVANIZING". FITTINGS SHALL BE SUBSIDIARY TO THE BID ITEM.
 - SYSTEM SHOWN USING STEEL WIDE FLANGE POSTS WITH COMPOSITE BLOCKOUTS.
 - A COMPOSITE MATERIAL BLOCKOUTS THAT MEETS THE REQUIREMENTS OF DMS-7210, MAY BE SUBSTITUTED FOR BLOCKOUTS OF SIMILAR DIMENSIONS. SEE CONSTRUCTION DIVISION MATERIAL PRODUCER LIST (MPL) FOR CERTIFIED PRODUCERS.
 - IF SOLID ROCK IS ENCOUNTERED IN THE AREA OF (POST 1) AND / OR (POST 2) CONTACT THE MANUFACTURER, & REFER TO THE LATEST ROADWAY MBSGF STANDARD FOR INSTALLATION GUIDANCE.
 - POSTS SHALL NOT BE SET IN CONCRETE.
 - SYSTEM MUST BE ATTACHED TO STANDARD 31" MBSGF.
 - UNDER NO CIRCUMSTANCES SHALL THE GUARDRAIL WITHIN THE MSKT SYSTEM BE CURVED.
 - A FLARE RATE OF UP TO 25:1 MAY BE USED TO PREVENT THE TERMINAL HEAD FROM ENCRANCHING ON THE SHOULDER. THE FLARE MAY BE DECREASED OR ELIMINATED FOR SPECIFIC INSTALLATIONS, IF DIRECTED BY THE ENGINEER.
 - THE SYSTEM IS SHOWN WITH TWO 12'-6" MBSGF PANELS, ONE 25'-0" MBSGF PANEL IS ALSO ALLOWED IN ITS PLACE.
 - A DRIVING CAP WITH A TIMBER OR PLASTIC INSERT SHALL BE USED WHEN DRIVING POSTS 3-8 TO PREVENT DAMAGE TO THE GALVANIZING ON TOP OF THE POST. SPECIAL DRIVING CAP TO BE USED ON LOWER POSTS 1 & 2 TO PREVENT DAMAGE TO THE WELDED PLATES.

ITEM	QTY	MAIN SYSTEM COMPONENTS	ITEM NUMBERS
A	1	MSKT IMPACT HEAD	MS3000
B	1	W-BEAM GUARDRAIL END SECTION, 12 Go.	SF1303
C	1	POST 1 - TOP (6" X 6" X 1/8" TUBE)	MTPHP1A
D	1	POST 1 - BOTTOM (6' W6X15)	MTPHP1B
E	1	POST 2 - ASSEMBLY TOP	UHP2A
F	1	POST 2 - ASSEMBLY BOTTOM (6' W6X9)	HP2B
G	1	BEARING PLATE	E750
H	1	CABLE ANCHOR BOX	S760
J	1	BCT CABLE ANCHOR ASSEMBLY	E770
K	1	GROUND STRUT	MS785
L	6	W6X9 OR W6X8.5 STEEL POST	P621
M	6	COMPOSITE BLOCKOUTS	CBSP-14
N	1	W-BEAM MGS RAIL SECTION (9'-4 1/2")	G12025
O	2	W-BEAM MGS RAIL SECTION (12'-6")	G1203A
P	6	WOOD BLOCKOUT 6" X 8" X 14"	P675
Q	1	W-BEAM MGS RAIL SECTION (25'-0")	G1209
SMALL HARDWARE			
a	2	5/8" x 1" HEX BOLT (GRD 5)	B5160104A
b	4	5/8" WASHER	W0516
c	2	5/8" HEX NUT	N0516
d	25	5/8" Dia. x 1 1/4" SPLICE BOLT (POST 2)	B580122
e	2	5/8" Dia. x 9" HEX BOLT (GRD A449)	B580904A
f	3	5/8" WASHER	W050
g	33	5/8" Dia. H.G.R NUT	N050
h	1	3/4" Dia. x 8 1/2" HEX BOLT (GRD A449)	B340854A
j	1	3/4" Dia. HEX NUT	N030
k	2	1 ANCHOR CABLE HEX NUT	N100
l	2	1 ANCHOR CABLE WASHER	W100
m	8	1/2" x 1 1/4" A325 BOLT WITH CAPTIVE WASHER	SB12A
n	8	1/2" STRUCTURAL NUTS	N012A
o	8	1 1/8" O.D. x 3/8" I.D. STRUCTURAL WASHERS	W012A
p	1	BEARING PLATE RETAINER TIE	CT-100ST
q	6	5/8" x 10" H.G.R. BOLT	B581002
r	1	OBJECT MARKER 18" X 18"	E3151

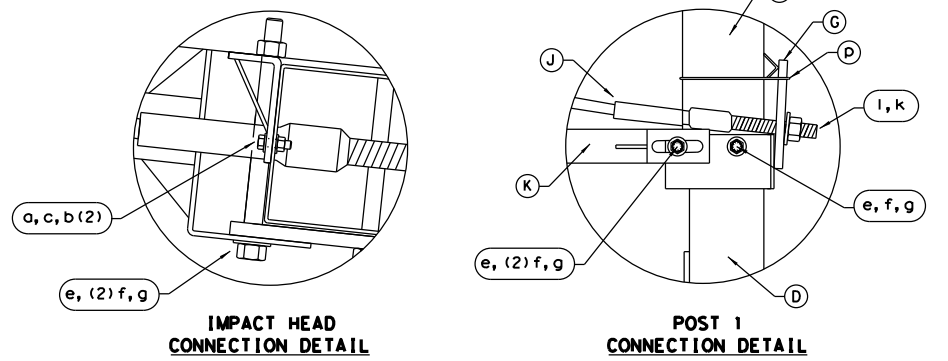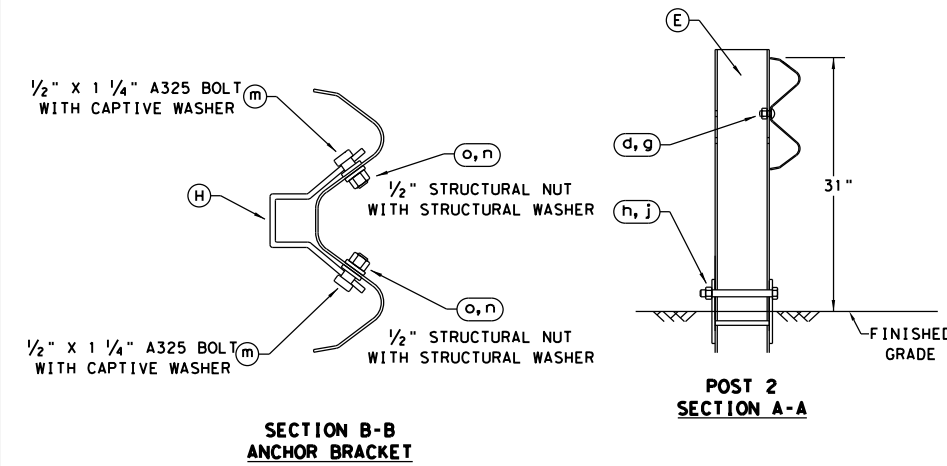

ALTERNATIVE ITEMS NOT SHOWN. *
 * ITEM (P) 8" WOOD-BLOCKOUT
 ** ITEM (Q) 25' GUARD FENCE PANEL

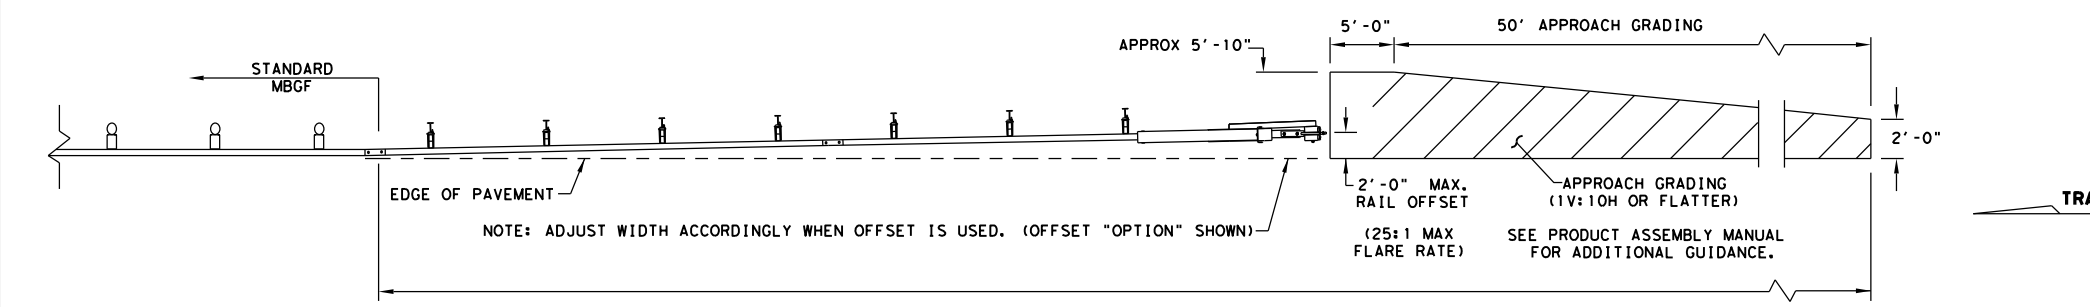

NOTE: TXDOT GENERIC APPROACH GRADING LAYOUT USED FOR ALL TANGENT TYPE END TREATMENTS.

NOTE: THIS STANDARD IS A BASIC REPRESENTATION OF THE MSKT END TERMINAL, IT IS NOT INTENDED TO REPLACE THE PRODUCT DESCRIPTION ASSEMBLY MANUAL.

Design Division Standard


SINGLE GUARDRAIL TERMINAL

MSKT-MASH-TL-3

SGT (12S) 31-18






FILE: sgt12s3118.dgn	DN: TXDOT	CK: KM	DW: VP	CK: CL
© TXDOT: APRIL 2018	CONT SECT	JOB	HIGHWAY	
REVISIONS	2311	01	044	FM 3051
	DIST	COUNTY	SHEET NO.	
	WAC	MCLENNAN		42

DATE: 10/5/2022
 FILE: \\txdot\project\wiseonline.com\TXDOT3\Documents\09 - WAC\Design Projects\231101044.4 - Design\Plan Set\3. RoadwayStandards\SGT (15)31-20.dgn
 DISCLAIMER: THE USE OF THIS STANDARD IS GOVERNED BY THE "TEXAS ENGINEERING PRACTICE ACT". NO WARRANTY OF ANY KIND IS MADE BY TXDOT FOR ANY PURPOSE WHATSOEVER. TXDOT ASSUMES NO RESPONSIBILITY FOR THE CONVERSION OF THIS STANDARD TO OTHER FORMATS OR FOR INCORRECT RESULTS OR DAMAGES RESULTING FROM ITS USE.

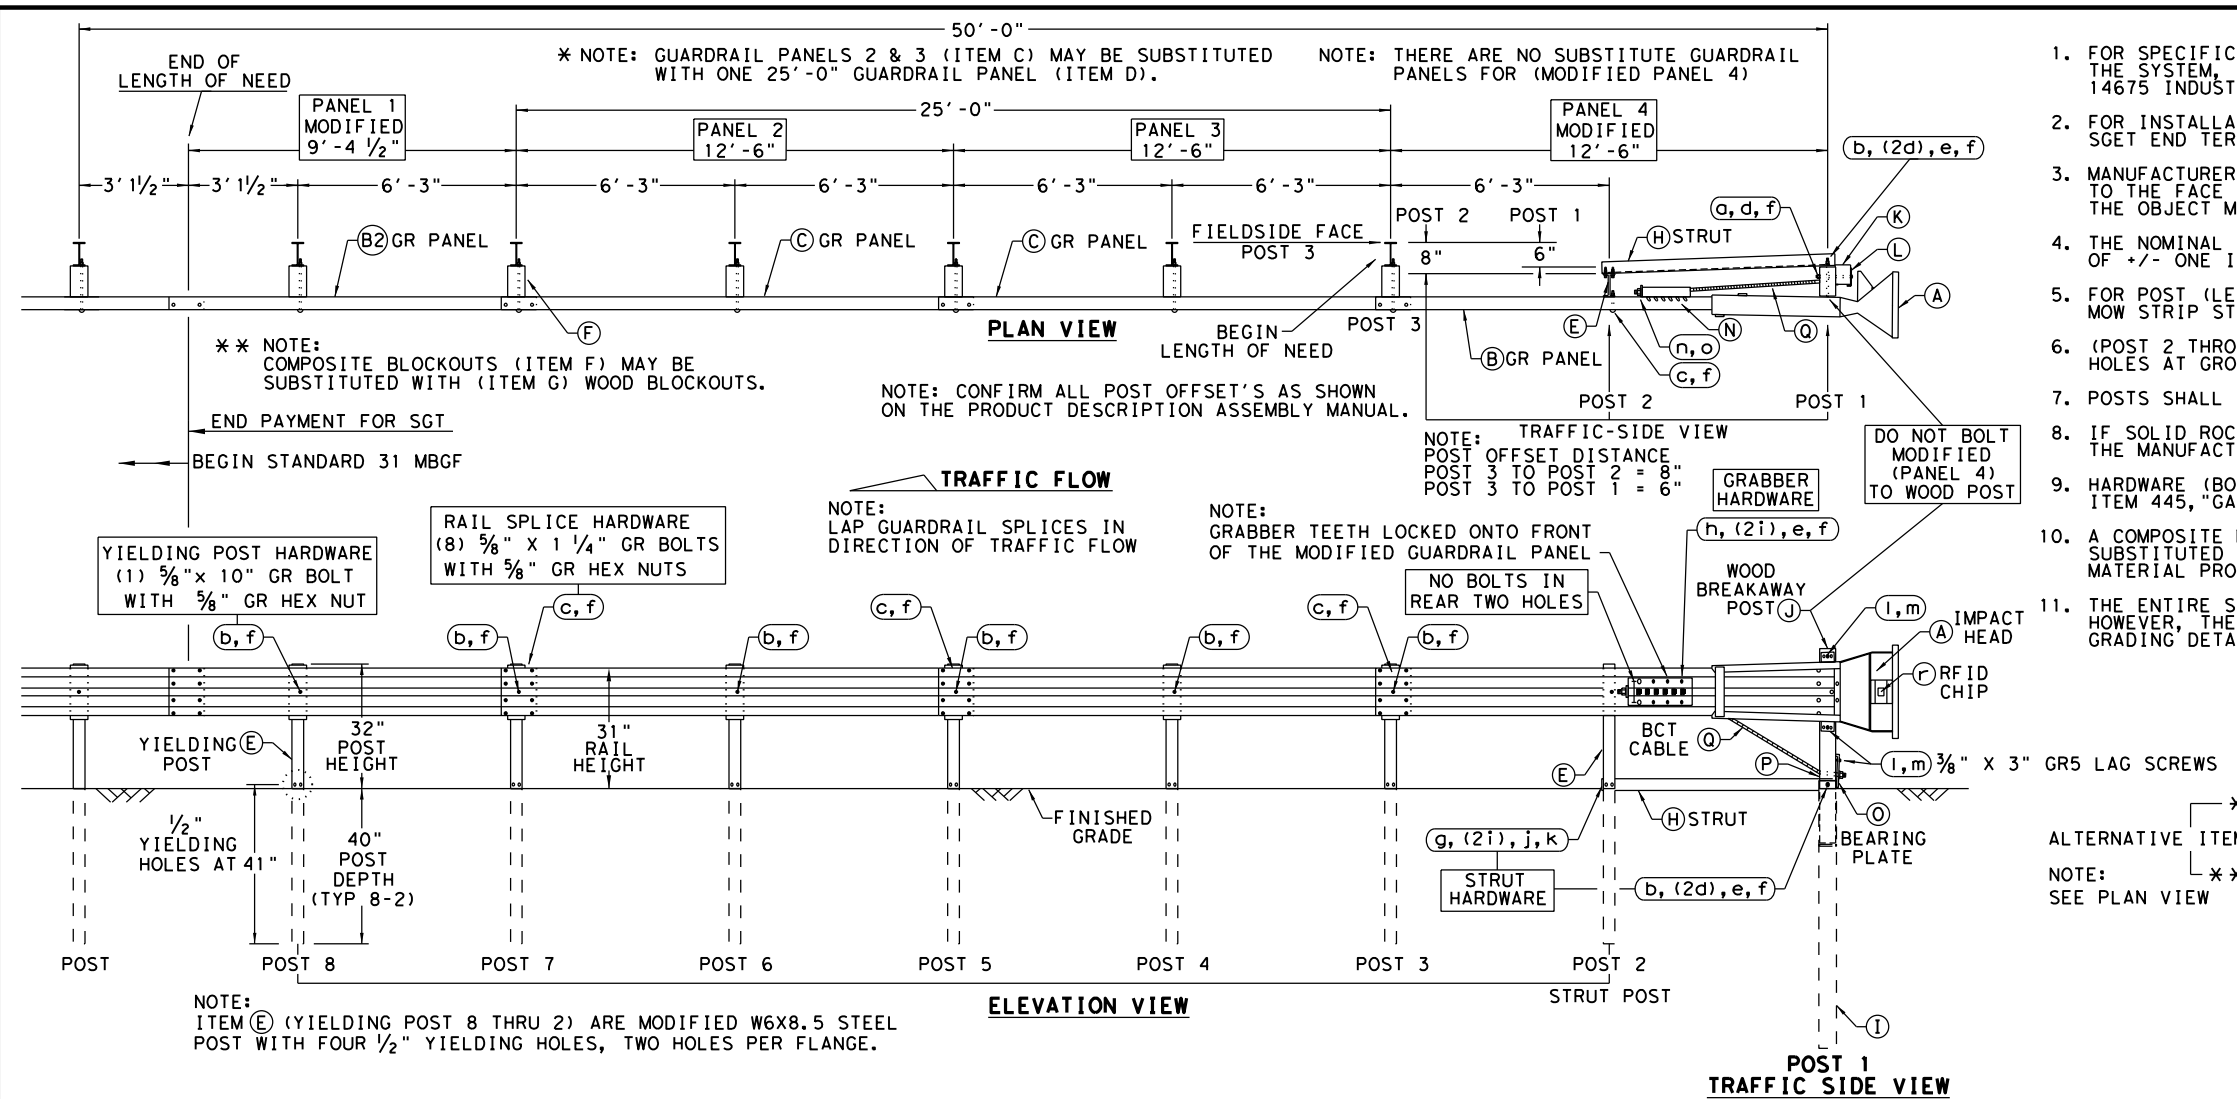

- ### GENERAL NOTES
- FOR SPECIFIC INFORMATION REGARDING INSTALLATION AND TECHNICAL GUIDANCE OF THE SYSTEM, CONTACT: SPIG INDUSTRY, INC. AT 1(267) 644-9510. 14675 INDUSTRIAL PARK RD; BRISTOL, VA 24202
 - FOR INSTALLATION, REPAIR AND MAINTENANCE REFER TO THE MANUFACTURER'S; SGET END TERMINAL, PRODUCT DESCRIPTION ASSEMBLY MANUAL.
 - MANUFACTURER WILL APPLY HIGH INTENSITY REFLECTIVE SHEETING, "OBJECT MARKER" TO THE FACE PLATE OF THE DEVICE PER MANUFACTURER'S RECOMMENDATIONS. THE OBJECT MARKER SHALL CONFORM TO THE STANDARDS REQUIRED IN TEXAS MUTCD.
 - THE NOMINAL HEIGHT OF THE GUARDRAIL BEAM IS 31 INCHES WITH A TOLERANCE OF +/- ONE INCH.
 - FOR POST (LEAVE-OUT) INSTALLATION AND GUIDANCE SEE TXDOT'S LATEST ROADWAY MOW STRIP STANDARD.
 - (POST 2 THROUGH POST 8) ARE MODIFIED STEEL-YIELDING POSTS WITH YIELDING HOLES AT GROUND LEVEL. THERE ARE NO SUBSTITUTE POSTS.
 - POSTS SHALL NOT BE SET IN CONCRETE.
 - IF SOLID ROCK IS ENCOUNTERED FOR ANY OF THE POSTS IN THE SYSTEM, CONTACT THE MANUFACTURER FOR SPECIFIC INSTALLATION GUIDANCE.
 - HARDWARE (BOLTS, NUTS, & WASHERS) SHALL BE GALVANIZED IN ACCORDANCE WITH ITEM 445, "GALVANIZING". FITTINGS SHALL BE SUBSIDIARY TO THE BID ITEM.
 - A COMPOSITE MATERIAL BLOCKOUT THAT MEETS DMS-7210 REQUIREMENTS MAY BE SUBSTITUTED FOR AN APPROVED WOOD BLOCKOUT. SEE CONSTRUCTION DIVISION MATERIAL PRODUCER LIST (MPL) FOR CERTIFIED PRODUCERS.
 - THE ENTIRE SYSTEM MUST BE INSTALLED IN A STRAIGHT LINE WITHOUT ANY CURVE. HOWEVER, THE SYSTEM CAN BE OFFSET BY TWO FEET AS SHOWN ON THE APPROACH GRADING DETAIL TO HELP OFF-SET THE IMPACT HEAD FROM SHOULDER OF THE ROAD.

ITEM	QTY	MAIN SYSTEM COMPONENTS	ITEM #
A	1	SGET IMPACT HEAD	SIH1A
B	1	MODIFIED GUARDRAIL PANEL 12'-6" 12GA	126SPZGP
B2	1	MODIFIED GUARDRAIL PANEL 9'-4 1/2" 12GA	GP94
C	2	STANDARD GUARDRAIL PANEL 12'-6" 12GA	GP126
D	1	STANDARD GUARDRAIL PANEL 25'-0" 12GA	GP25
E	7	MODIFIED YIELDING I-BEAM POST W6x8.5	YP6MOD
F	6	COMPOSITE BLOCKOUT 6" X 8" X 14"	CBO8
G	6	WOOD BLOCKOUT 6" X 8" X 14"	WBO8
H	1	STRUT 3" X 3" X 80" X 1/4" A36 ANGLE	STR80
I	1	FOUNDATION TUBE 6" X 8" X 72" X 3/8"	FNDT6
J	1	WOOD BREAKAWAY POST 5 1/2" X 7 1/2" X 50"	WBRK50
K	1	WOOD STRIKE BLOCK	WSBLK14
L	1	STRIKE PLATE 1/4" A36 BENT PLATE	SPLT8
M	1	REINFORCEMENT PLATE 12 GA. GR55	REPLT17
N	1	GUARDRAIL GRABBER 2 1/2" X 2 1/2" X 16 1/2"	GGR17
O	1	BEARING PLATE 8" X 8 5/8" X 5/8" A36	BPLT8
P	1	PIPE SLEEVE 4 1/4" X 2 3/8" O.D. (2 1/8" I.D.)	PSLV4
Q	1	BCT CABLE 3/4" X 81" LENGTH	CBL81
SMALL HARDWARE			
o	1	5/8" X 12" GUARDRAIL BOLT 307A HDG	12GRBLT
b	7	5/8" X 10" GUARDRAIL BOLT 307A HDG	10GRBLT
c	33	5/8" X 1 1/4" GR SPlice BOLTS 307A HDG	1GRBLT
d	3	5/8" FLAT WASHER F436 A325 HDG	58FW436
e	1	5/8" LOCK WASHER HDG	58LW
f	39	5/8" GUARDRAIL HEX NUT HDG	58HN563
g	2	1/2" X 2" STRUT BOLT A325 HDG	2BLT
h	6	1/2" X 1 1/4" PLATE BOLT A325 HDG	125BLT
i	16	1/2" FLAT WASHER F436 A325 HDG	12FWF436
j	8	1/2" LOCK WASHER HDG	12LW
k	8	1/2" HEX NUT A563 HDG	12HN563
l	4	3/8" X 3" HEX LAG SCREW GR5 HDG	38LS
m	4	3/8" FLAT WASHER F436 A325 HDG	38FW844
n	2	1" FLAT WASHER F436 A325 HDG	1FWF436
o	2	1" HEX NUT A563DH HDG	1HN563
p	1	18" TO 24" LONG ZIP TIE RATED 175-200LB	ZPT18
q	1	1 1/2" X 4" SCH-40 PVC PIPE	PSPCR4
r	1	RFID CHIP RATED MIL-STD-810F	RFID810F
s	1	IMPACT HEAD REFLECTIVE SHEETING	RS30M

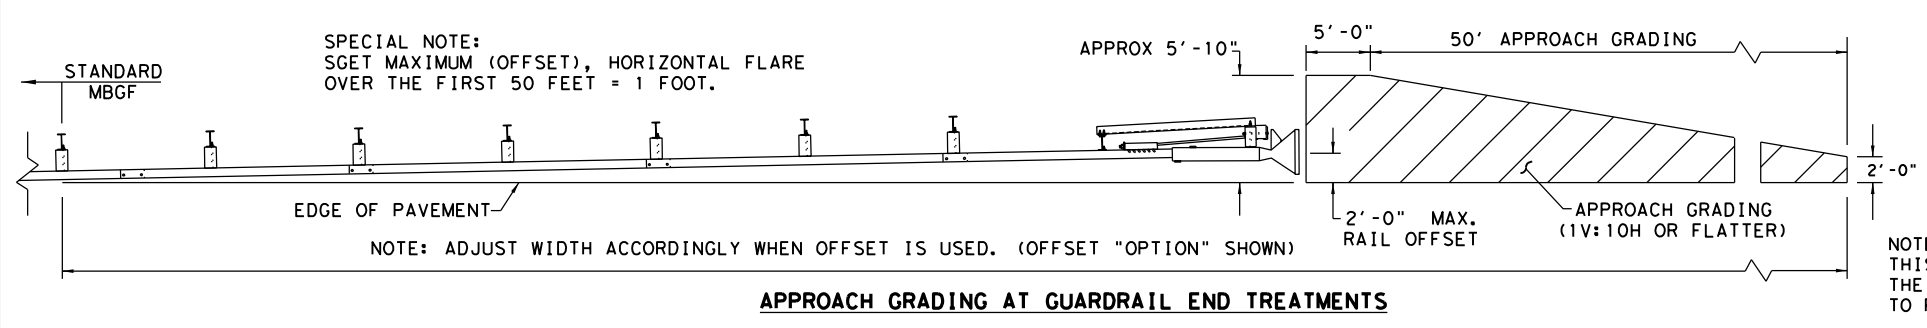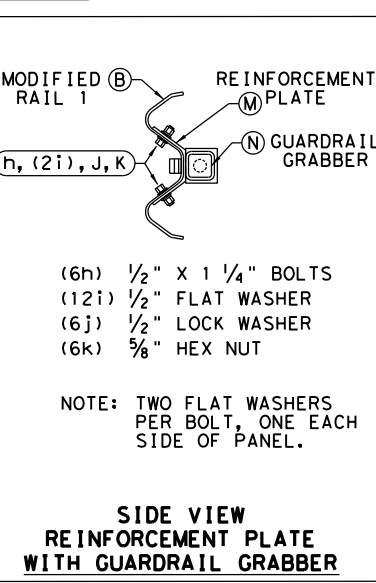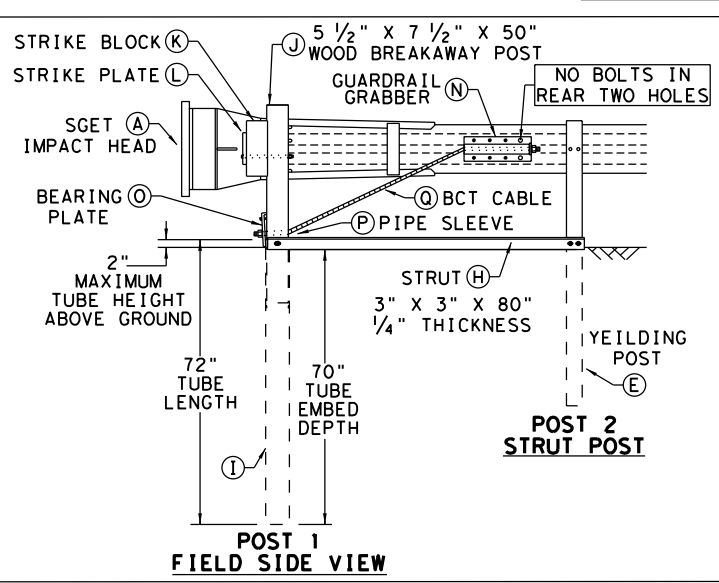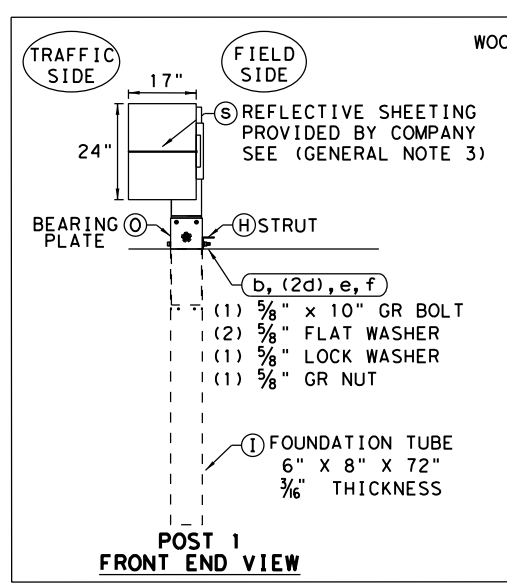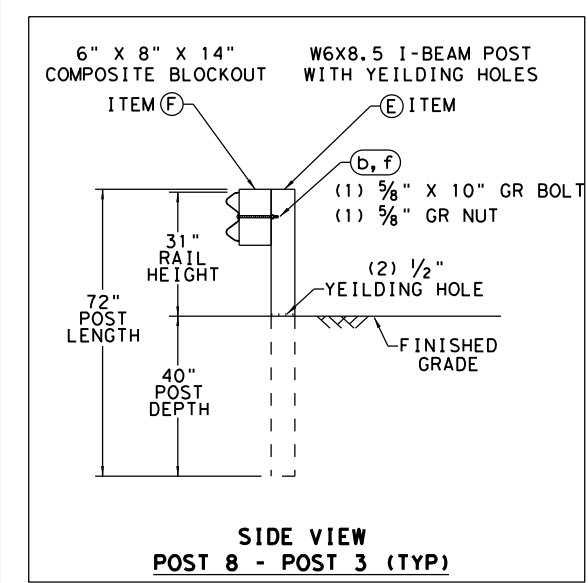

NOTE: THIS STANDARD IS A BASIC REPRESENTATION OF THE SGET TERMINAL SYSTEM AND IS NOT INTENDED TO REPLACE THE MANUFACTURER'S ASSEMBLY MANUAL.


SPIG INDUSTRY, LLC
SINGLE GUARDRAIL TERMINAL
SGET - TL-3 - MASH
SGT (15)31-20

FILE: sg153120.dgn	DN: TXDOT	CK: KM	DW: VP	CK: VP
© TXDOT: APRIL 2020	CONT: 2311	SECT: 01	JOB: 044	HIGHWAY: FM 3051
REVISIONS	DIST: WAC	COUNTY: MCLENNAN	SHEET NO. 43	

DATE: 10/5/2022
 FILE: \\txdot\project\wiseonline.com\TXDOT3\Documents\09 - WAC\Design Projects\231101044.4 - Design\Plan Set\3. Roadway\Standards\QOGE LITE (M10) (N) -20.dgn
 DISCLAIMER: THE USE OF THIS STANDARD IS GOVERNED BY THE "TEXAS ENGINEERING PRACTICE ACT". NO WARRANTY OF ANY KIND IS MADE BY TXDOT FOR ANY PURPOSE WHATSOEVER. TXDOT ASSUMES NO RESPONSIBILITY FOR THE CONVERSION OF THIS STANDARD TO OTHER FORMATS OR FOR INCORRECT RESULTS OR DAMAGES RESULTING FROM ITS USE.

NOTE:
A TRANSITION MAY BE REQUIRED TO INSTALL THE QUADGUARD ELITE M10 TO THE OBJECT BEING SHIELDED.

QUADGUARD ELITE M10 24" WIDE (8 BAY) SYSTEM

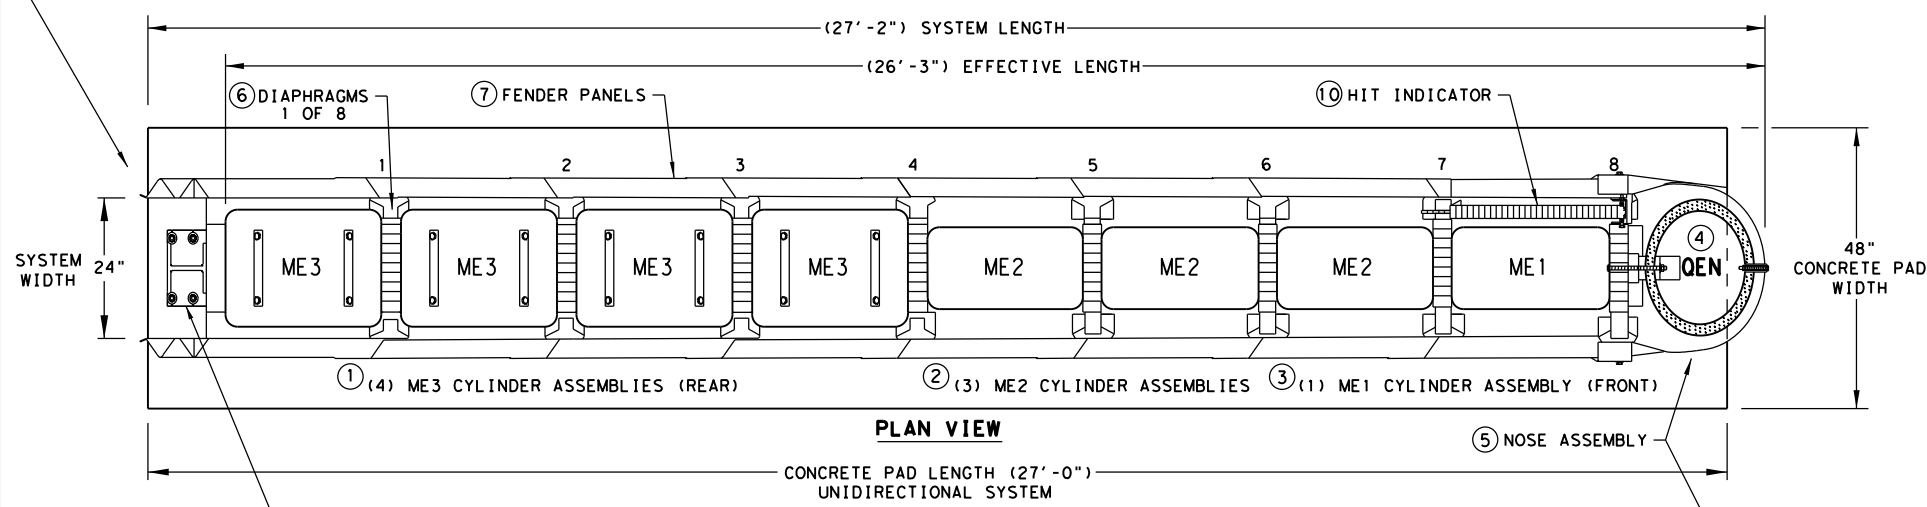


KEY	KEY	KEY
① ME3 CYLINDER ASSEMBLIES	⑥ DIAPHRAGMS	⑩ HIT INDICATOR
② ME2 CYLINDER ASSEMBLIES	⑦ FENDER PANELS	
③ ME1 CYLINDER ASSEMBLY	⑧ MONORAILS	
④ QEN CYLINDER	⑨ TYPE OF BACKUP	
⑤ NOSE BELT ASSEMBLY		

⑨ SHOWN WITH TENSION STRUT BACKUP ASSEMBLY

NOTE: PROVISION SHALL BE MADE FOR REAR FENDER SIDE PANELS TO SLIDE REARWARD UPON IMPACT, 25" MIN.

NOTE: HIT INDICATOR WILL RAISE UPON IMPACT.

④ QEN CYLINDER INSTALLED INSIDE OF NOSE BELT ASSEMBLY ⑤

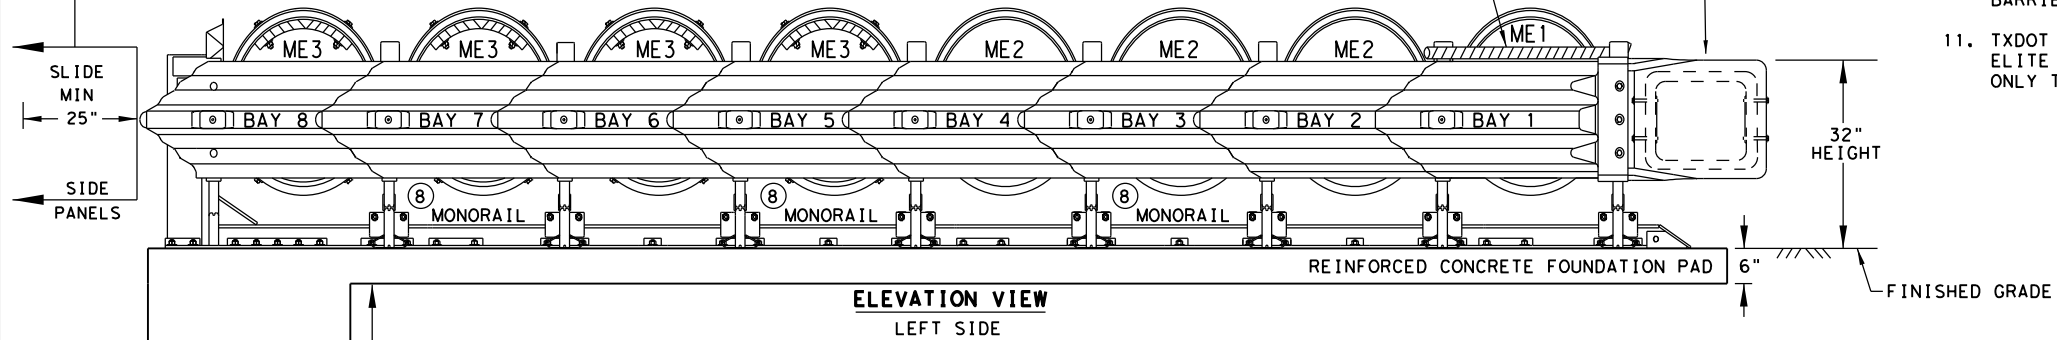

NOTES:
CONTACT THE MANUFACTURER WITH SITE SPECIFIC DATA (SSD) FOR CONCRETE PAD AND ANCHOR BLOCK INSTALLATION REQUIREMENTS.

A MANUFACTURER'S DRAWING PACKAGE UNIQUE AND SPECIFIC FOR THE QUADGUARD ELITE M10 FIELD INSTALLATION AND INFORMATION REGARDING THE TYPE OF BACKUP ASSEMBLY REQUIRED FOR THE TRANSITION WILL BE PROVIDED BY THE MANUFACTURER TO THE ENGINEER AND INSTALLER.

6" REINFORCED CONCRETE PAD REQUIRES THE INSTALLATION OF AN ANCHOR BLOCK AS SHOWN ON THE MANUFACTURER'S DRAWING PACKAGE.

8" NON-REINFORCED CONCRETE PAD MAY NOT REQUIRE AN ANCHOR BLOCK, IF THE PAD IS INSTALLED AGAINST AN IMMOVABLE CONCRETE BACKUP.

CONCRETE PAD AND ANCHOR BLOCK COMBINATIONS SHALL BE CONFIRMED WITH THE MANUFACTURER BASED UPON SITE SPECIFIC DATA (SSD).

NOTE:
THE QUADGUARD ELITE M10 8-BAY, 24" WIDE - NARROW SYSTEM TESTED TO MASH TEST LEVEL 3.

TL-3 MODEL #	QM10024E	CYLINDER TYPES IN BAYS			
BAYS	8	TYPE-ME3	TYPE-ME2	TYPE-ME1	TYPE-QEN
DIAPHRAGMS	8	4	3	1	1
WIDTH	24"	REAR	FRONT		NOSE

BACKUP ASSEMBLY TYPES FOR SYSTEM TRANSITIONS

SEE GENERAL NOTE 10 FOR CLEARANCE LIMITATIONS

⑨ TENSION STRUT BACKUP

⑨ CONCRETE BACKUP

SYSTEM TRANSITIONS TYPES	
1	QUAD-BEAM TO CONCRETE SAFETY BARRIER
2	QUAD-BEAM TO CONCRETE BRIDGE RAIL
3	QUAD-BEAM TO CONCRETE END SHOE
4	QUAD-BEAM TO THRIE-BEAM RAIL
5	QUAD-BEAM TO W-BEAM RAIL

NOTE:
TRANSITION ASSEMBLIES FOR THE QUADGUARD ELITE M10 TO THRIE-BEAM OR W-BEAM FENCE REQUIRES I-BEAM POSTS:
ALL POSTS W6X8.5/9 I-BEAMS (78" LONG).

NOTES:
CONTACT THE MANUFACTURER WITH SITE SPECIFIC DATA (SSD) FOR THE CORRECT BACKUP ASSEMBLY AND TRANSITION PANELS OR SIDE PANELS USED FOR STANDARD AND BI-DIRECTIONAL INSTALLATIONS: AT DIVIDED-HIGHWAY MEDIANS OR UNDIVIDED ROADWAYS WHERE THE SYSTEM IS EXPOSED TO IMPACTS FROM ONE OR TWO DIFFERENT DIRECTIONS OF TRAFFIC FLOW.

NOTE:
THIS STANDARD IS A BASIC REPRESENTATION OF THE QUADGUARD ELITE M10 SYSTEM AND IS NOT INTENDED TO REPLACE THE PRODUCT DESCRIPTION ASSEMBLY MANUAL.

GENERAL NOTES

- FOR SPECIFIC INFORMATION REGARDING INSTALLATION AND TECHNICAL GUIDANCE OF THE SYSTEM, CONTACT: TRINITY HIGHWAY - ENERGY ABSORPTION INC. AT 1 (888) 323-6374.
- SEE THE RECENT QUADGUARD ELITE M10 PRODUCT DESCRIPTION ASSEMBLY MANUAL FOR IMPACT PERFORMANCE CHARACTERISTICS AND DESIGN LIMITATIONS AND THE DRAWING PACKAGE FOR THE NARROW 24" SYSTEM BEFORE INSTALLING THE QUADGUARD ELITE M10 AT ANY GIVEN LOCATION.
- FOR BI-DIRECTIONAL TRAFFIC: THE LOCATION AND OR WIDTH OF THE QUADGUARD ELITE M10 IS RESTRICTED. AS BI-DIRECTIONAL TRAFFIC APPROACHES THE REAR OF THE QUADGUARD ELITE M10, THE QUADGUARD ELITE M10 SHOULD NOT EXTEND FURTHER INTO THE TRAFFIC-SIDE OF THE BARRIER THAN THE OBSTACLE. ANY TRANSITION INSTALLED MUST EITHER BE TANGENT TO BOTH QUADGUARD ELITE M10 AND OBSTACLE OR MUST ANGLE TOWARD FIELD SIDE OF THE BARRIER.
- SYSTEM TRANSITION: APPROPRIATE TRANSITION PANELS OR SIDE PANELS WILL BE REQUIRED FOR PROPER IMPACT PERFORMANCE. THE CORRECT PANEL(S) TO USE WILL DEPEND ON THE DIRECTION OF TRAFFIC FLOW AND WHAT TYPE OF BARRIER OR ROAD FEATURE THE QUADGUARD ELITE M10 SYSTEM IS SHIELDING. SEE THE QUADGUARD ELITE M10 PRODUCT DESCRIPTION & ASSEMBLY MANUAL FOR FURTHER DETAILS.
- COMPONENTS FOR THE QUADGUARD ELITE (M10) BACKUP AND REINFORCING DETAILS ARE SHOWN ON THE QUADGUARD ELITE M10 PRODUCT DESCRIPTION & ASSEMBLY MANUAL.
- CONCRETE PAD SHALL BE 6" MIN. REINFORCED 28MPa [4,000 PSI] (P.C.) OR 8" MIN. NON-REINFORCED 28MPa [4,000 PSI] CONCRETE ROADWAY MEASURING AT LEAST 12'-0" WIDE BY 50'-0" LONG. ANCHOR BLOCK IS NOT REQUIRED WHEN USING 8" CONCRETE PAD INSTALLED AGAINST AN IMMOVABLE STRUCTURE, E.G. CONCRETE WALL.
- IF THE CROSS-SLOPE VARIES MORE THAN 2% OVER THE LENGTH OF THE SYSTEM, THE CONCRETE PAD WILL REQUIRE LEVELING. MAXIMUM PERMISSIBLE CROSS-SLOPE IS 8%.
- THE INSTALLATION AREA SHOULD BE FREE OF CURBS, ELEVATED OBJECTS, OR DEPRESSIONS.
- THE QUADGUARD ELITE M10 SYSTEM SHOULD BE INSTALLED APPROXIMATELY PARALLEL WITH THE BARRIER.
- FOR THE TENSION STRUT BACKUP THE DISTANCE BETWEEN THE BACK OF BACKUP AND THE BARRIER WALL SHOULD NOT EXCEED 7" IN ANY CASE.
- TXDOT HAS ONLY APPROVED THE 24" WIDE QUADGUARD ELITE M10 SYSTEM. THE QUADGUARD ELITE M10 PRODUCT DESCRIPTION AND ASSEMBLY MANUAL INCLUDES SYSTEM WIDTH OF 24". ONLY THE 24" SYSTEM IS ALLOWED TO BE INSTALLED ON TEXAS ROADWAYS.

FOUNDATION & ANCHORING REQUIREMENTS	
FOUNDATION TYPES: A, B, C, & D	
FOUNDATION TYPE: A	REINFORCED CONCRETE PAD OR ROADWAY
FOUNDATION:	6" MINIMUM DEPTH (P.C.C.)
ANCHORAGE:	7" STUDS EMBEDDED 5 1/2" - APPROVED ADHESIVE
FOUNDATION TYPE: B	ASPHALT OVER P.C.C.
FOUNDATION:	3" MIN. (A.C.) OVER 3" MIN. (P.C.C.)
ANCHORAGE:	18" THREADED ROD EMBEDDED 16 1/2" - APPROVED ADHESIVE
FOUNDATION TYPE: C	ASPHALT OVER SUBBASE
FOUNDATION:	6" MIN. (A.C.) OVER 6" MIN. (C.S.)
ANCHORAGE:	18" THREADED ROD EMBEDDED 16 1/2" - APPROVED ADHESIVE
FOUNDATION TYPE: D	ASPHALT ONLY
FOUNDATION:	8" MIN. (A.C.)
ANCHORAGE:	18" THREADED ROD EMBEDDED 16 1/2" - APPROVED ADHESIVE

KEY:
ASPHALT CONCRETE (A.C.)
COMPACTED SUBBASE (C.S.)
PORTLAND CEMENT CONCRETE (P.C.C.)

NOTE: SEE TRINITY'S PRODUCT DESCRIPTION ASSEMBLY MANUAL FOR THE APPROVED ADHESIVE.

IF THE UNIT IS ANCHORED TO ASPHALTIC CONCRETE, IT SHOULD BE RELOCATED TO FRESH, UNDISTURBED ASPHALT AND RE-ANCHORED AFTER EACH IMPACT TO ENSURE ADEQUATE FUTURE PERFORMANCE.

TENSION STRUT BACKUP MAY BE USED IN CONSTRUCTION ZONES ON ASPHALT CONCRETE (A.C.) FOR TEMPORARY USE ONLY.

Design Division Standard


**TRINITY HIGHWAY
ENERGY ABSORPTION
QUADGUARD ELITE M10
(MASH TL-3)
QOGE LITE (M10) (N) -20**

FILE: qge11em10n20.dgn	DN: TXDOT	CK: KM	DW: VP	CK: AG
© TXDOT: NOVEMBER 2020	CONT SECT	JOB	HIGHWAY	
REVISIONS	2311 01	044	FM 3051	
	DIST	COUNTY	SHEET NO.	
	WAC	MCLENNAN	44	


LOW MAINTENANCE

DISCLAIMER: The use of this standard is governed by the "Texas Engineering Practice Act". No warranty of any kind is made by TxDOT for any purpose whatsoever. TxDOT assumes no responsibility for the conversion of this standard to other formats or for incorrect results or damages resulting from its use.

DATE: FILE:

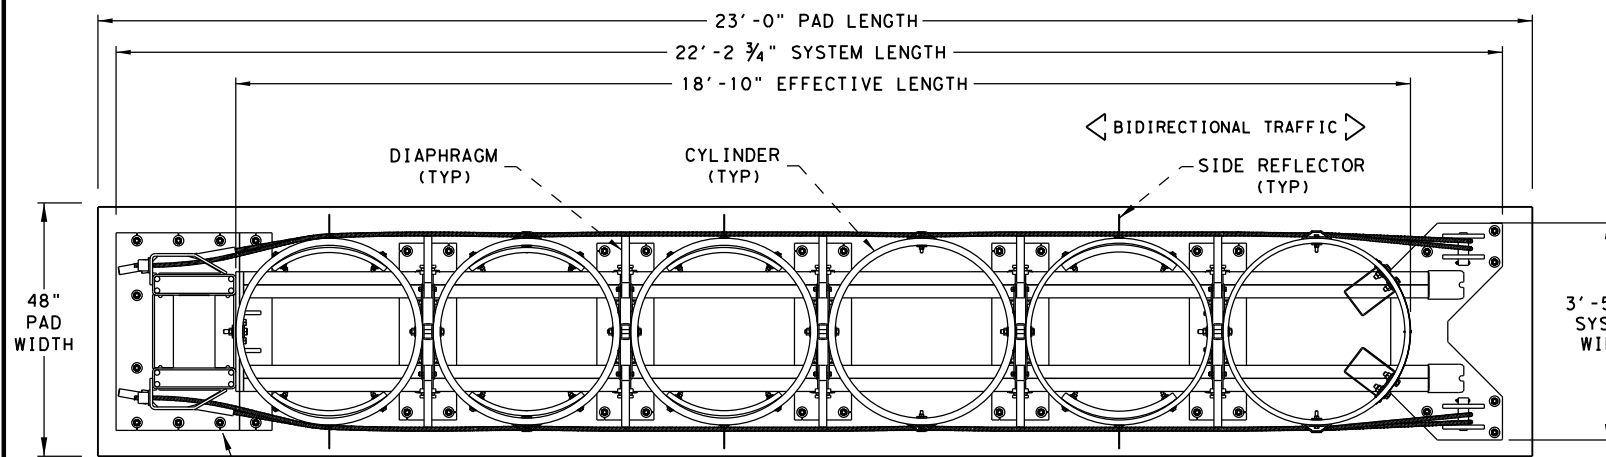


PLAN VIEW

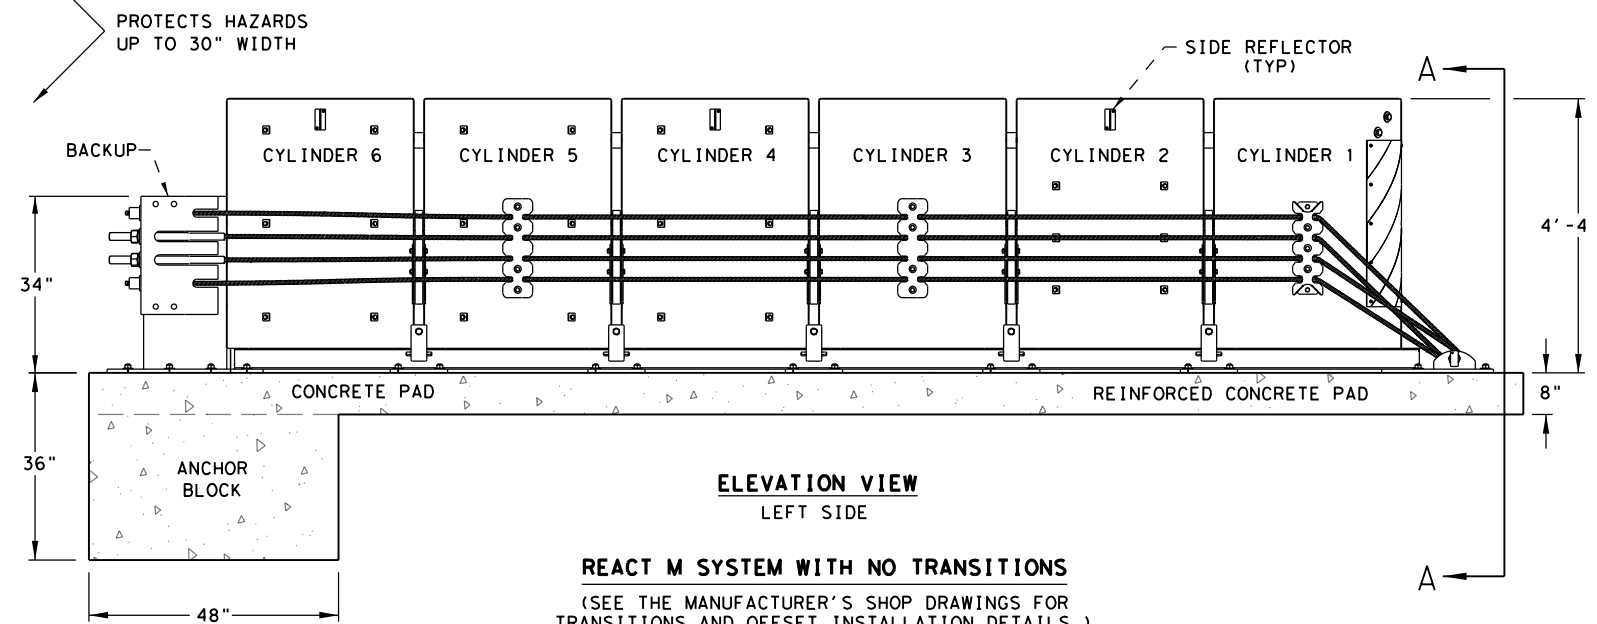


**ELEVATION VIEW
LEFT SIDE**

REACT M SYSTEM WITH NO TRANSITIONS
(SEE THE MANUFACTURER'S SHOP DRAWINGS FOR TRANSITIONS AND OFFSET INSTALLATION DETAILS.)

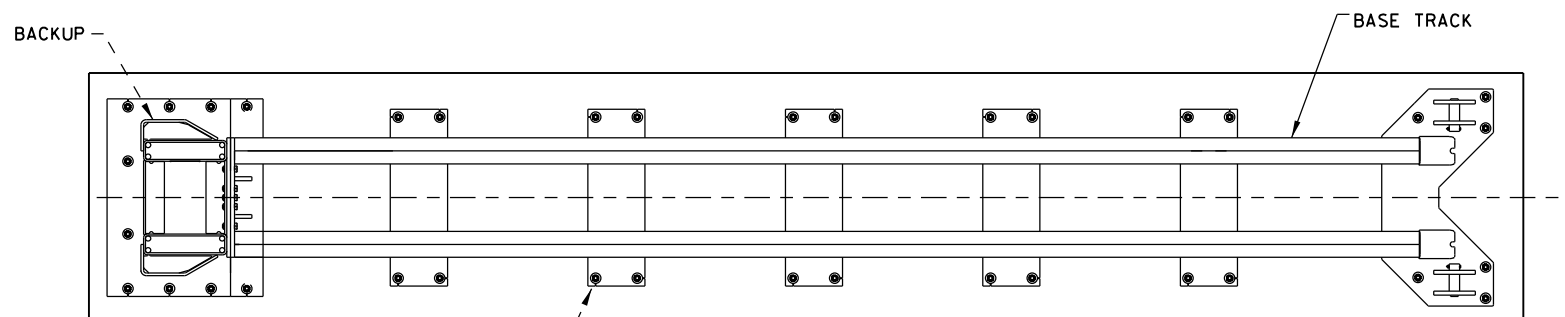


PLAN VIEW

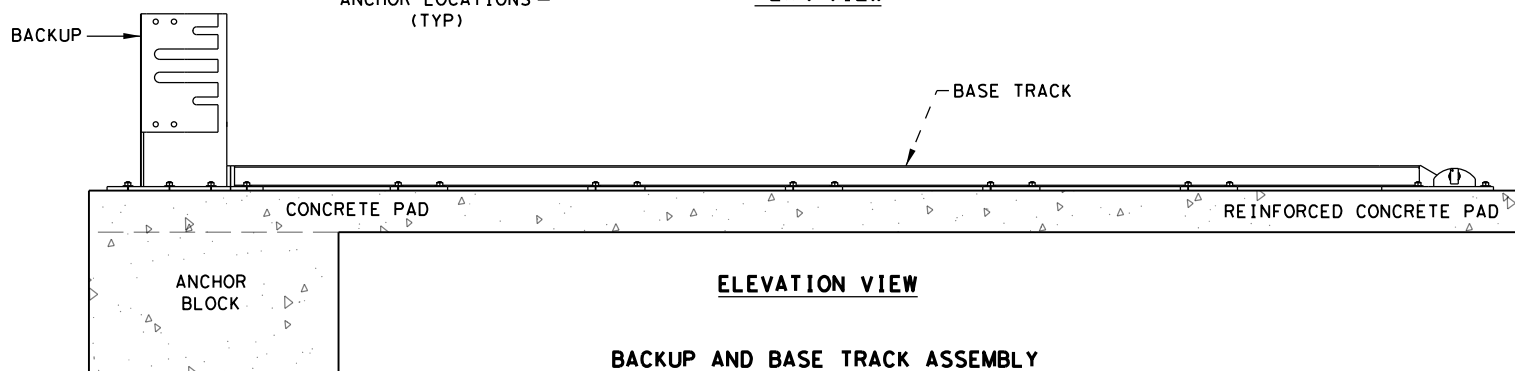

ELEVATION VIEW

BACKUP AND BASE TRACK ASSEMBLY


(SEE THE MANUFACTURER'S SHOP DRAWINGS FOR TRANSITIONS, OFFSETS, BIDIRECTIONAL AND UNIDIRECTIONAL INSTALLATION DETAILS.)

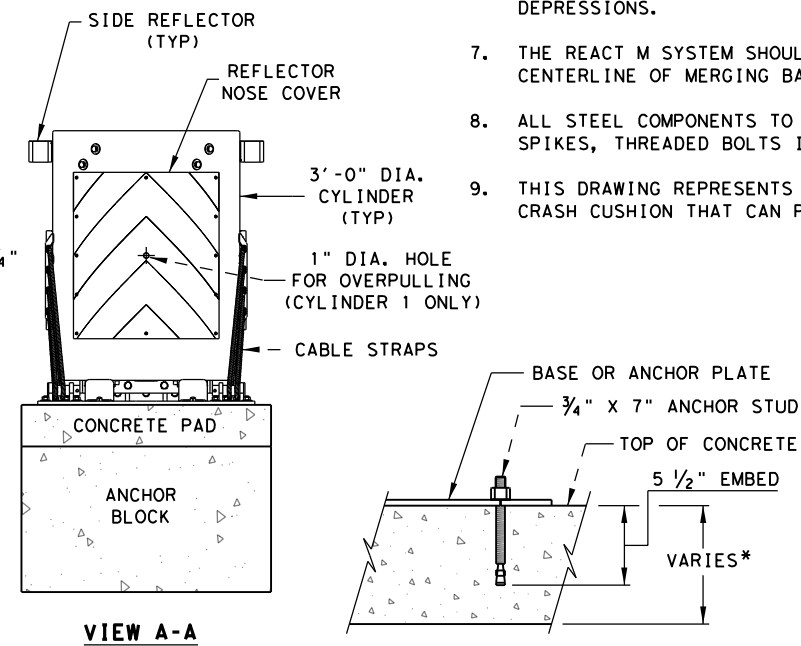

VIEW A-A

ANCHORING DETAIL

*SEE FOUNDATION TYPES TABLE

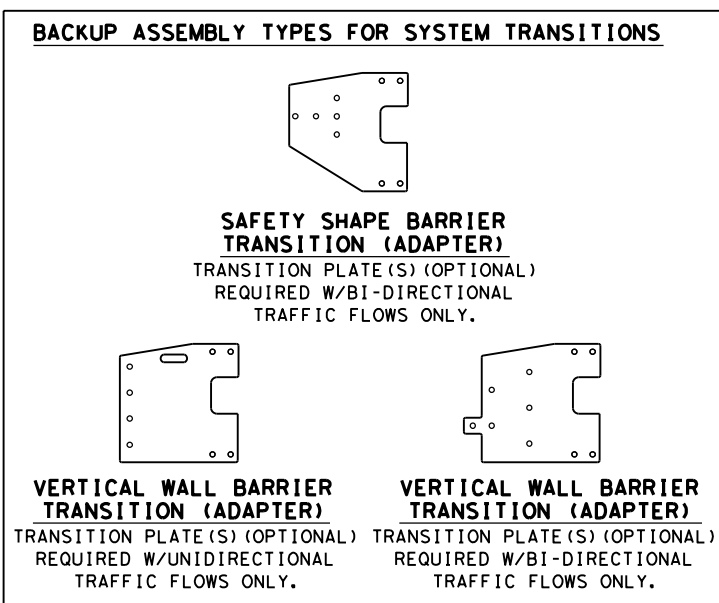

NOTES:
CONTACT THE MANUFACTURER WITH SITE SPECIFIC DATA (SSD) FOR THE CORRECT BACKUP ASSEMBLY AND TRANSITION PANELS OR SIDE PANELS USED FOR STANDARD AND BI-DIRECTIONAL INSTALLATIONS: AT DIVIDED-HIGHWAY MEDIANS OR UNDIVIDED ROADWAYS WHERE THE SYSTEM IS EXPOSED TO IMPACTS FROM ONE OR TWO DIFFERENT DIRECTIONS OF TRAFFIC FLOW.

GENERAL NOTES

- FOR SPECIFIC INFORMATION REGARDING INSTALLATION AND TECHNICAL GUIDANCE OF THE SYSTEM, CONTACT: TRINITY HIGHWAY - ENERGY ABSORPTION AT 1(888)323-6374 OR WEBSITE: www.trinityhighway.com.
- THE NOSE OF THE REACT M SHALL BE CLAD WITH A PLASTIC WRAP WITH STANDARD DELINEATION ADHERED TO THE WRAP AND SHALL HAVE A SERIES OF SIDE MARKER REFLECTORS ON BOTH SIDES OF THE UNIT. SEE SITE PLAN VIEWS FOR MARKER AND PLASTIC WRAP COLOR ORIENTATION.
- FOR BI-DIRECTIONAL TRAFFIC, APPROPRIATE TRANSITION DETAILS WILL BE AS SHOWN ON THE MANUFACTURER'S SHOP DRAWINGS.
- DETAILS OF COMPONENTS FOR THE REACT M, BACKUPS AND REINFORCING DETAILS WILL BE SHOWN ON THE MANUFACTURER'S SHOP DRAWINGS FURNISHED TO THE ENGINEER.
- IF THE CROSS-SLOPE VARIES MORE THAN 2% OVER THE LENGTH OF THE SYSTEM, THE CONCRETE PAD WILL REQUIRE LEVELING. MAXIMUM PERMISSIBLE CROSS-SLOPE IS 8%.
- THE INSTALLATION AREA SHOULD BE FREE FROM CURBS, ELEVATED OBJECTS, OR DEPRESSIONS.
- THE REACT M SYSTEM SHOULD BE APPROXIMATELY PARALLEL WITH THE BARRIER OR CENTERLINE OF MERGING BARRIERS.
- ALL STEEL COMPONENTS TO BE HOT DIPPED GALVANIZED EXCEPT STAKES, DRIVE SPIKES, THREADED BOLTS IN BACKUP UNIT, AND WEDGE FITTINGS ON CABLES.
- THIS DRAWING REPRESENTS THE REACT M TL-3 SYSTEM, RE-DIRECTIVE, NON-GATING CRASH CUSHION THAT CAN PROTECT HAZARDS UP TO 30-INCHES IN WIDTH.

DESIGN DATA TABLE FOR REACT M

TEST NUMBER	TEST LEVEL	OVERALL LENGTH	TRANSITION LENGTH	SYSTEM WIDTH
3-30 To 3-36	TL-3	22'-2 3/4"	-	3'-5 3/4"
3-37A	TL-3	22'-2 3/4"	9'-10 3/4"	3'-5 3/4"
3-38	TL-3	22'-2 3/4"	-	3'-5 3/4"

ANCHOR SYSTEM TYPE

APPROVED ADHESIVE, 7" STUDS, 5.5" EMBEDMENT

FOUNDATION TYPES

MINIMUM 8" REINFORCED PORTLAND CEMENT CONCRETE PAD (REQUIRED REINFORCING STEEL FOR CONCRETE PAD SHALL BE SHOWN ON THE MANUFACTURER'S SHOP DRAWINGS.)

MINIMUM 8" NON-REINFORCED PORTLAND CEMENT CONCRETE ROADWAY MEASURING AT LEAST 12' WIDE BY 50' LONG)

MINIMUM 7" CONCRETE DECK STRUCTURE, OR MINIMUM 6" REINFORCED CONCRETE ROADWAY

NOTE:
THIS STANDARD IS A BASIC REPRESENTATION OF THE REACT M SYSTEM AND IS NOT INTENDED TO REPLACE THE PRODUCT DESCRIPTION ASSEMBLY MANUAL.

Design Division Standard


**TRINITY HIGHWAY
ENERGY ABSORPTION
CRASH CUSHION
REACT M (NARROW)
(MASH TL-3)
REACT (M) -21**

FILE: reactm21.dgn	DN: TxDOT	CK: KM	DW: SS	CK: CL
© TxDOT: JULY 2021	CONT	SECT	JOB	HIGHWAY
REVISIONS	2311	01	044	FM 3051
DIST	COUNTY		SHEET NO.	
WAC	MCLENNAN		45	


LOW MAINTENANCE

DISCLAIMER: This standard is governed by the "Texas Engineering Practice Act". No warranty of any kind is made by TxDOT for any purpose whatsoever. TxDOT assumes no responsibility for the conversion of this standard to other formats or for incorrect results or damages resulting from its use.

DATE: 10/5/2022
 FILE: \\txdot\projectwiseonline.com:TXDOT3\Documents\09 - WAC\Design Projects\231101044\4 - Design\Plan Set\3. Roadway\Standards\SMTC(N) - 16.dgn

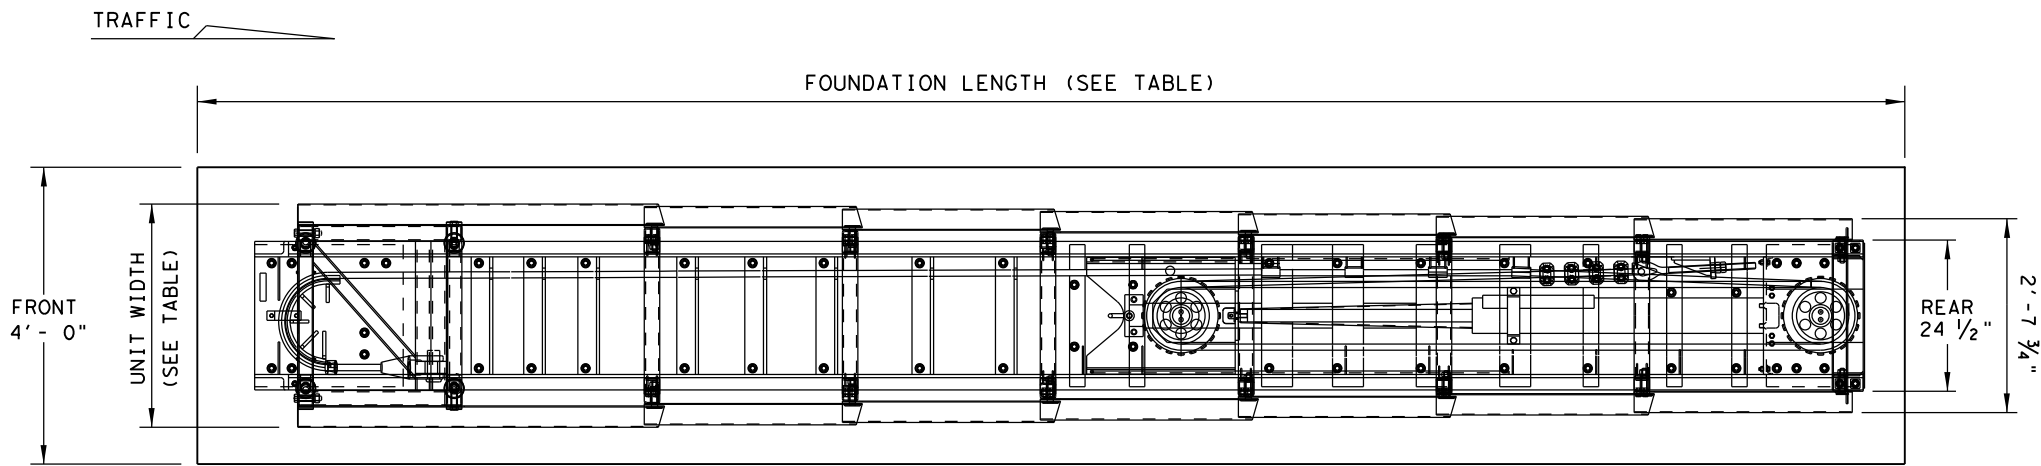

PLAN VIEW

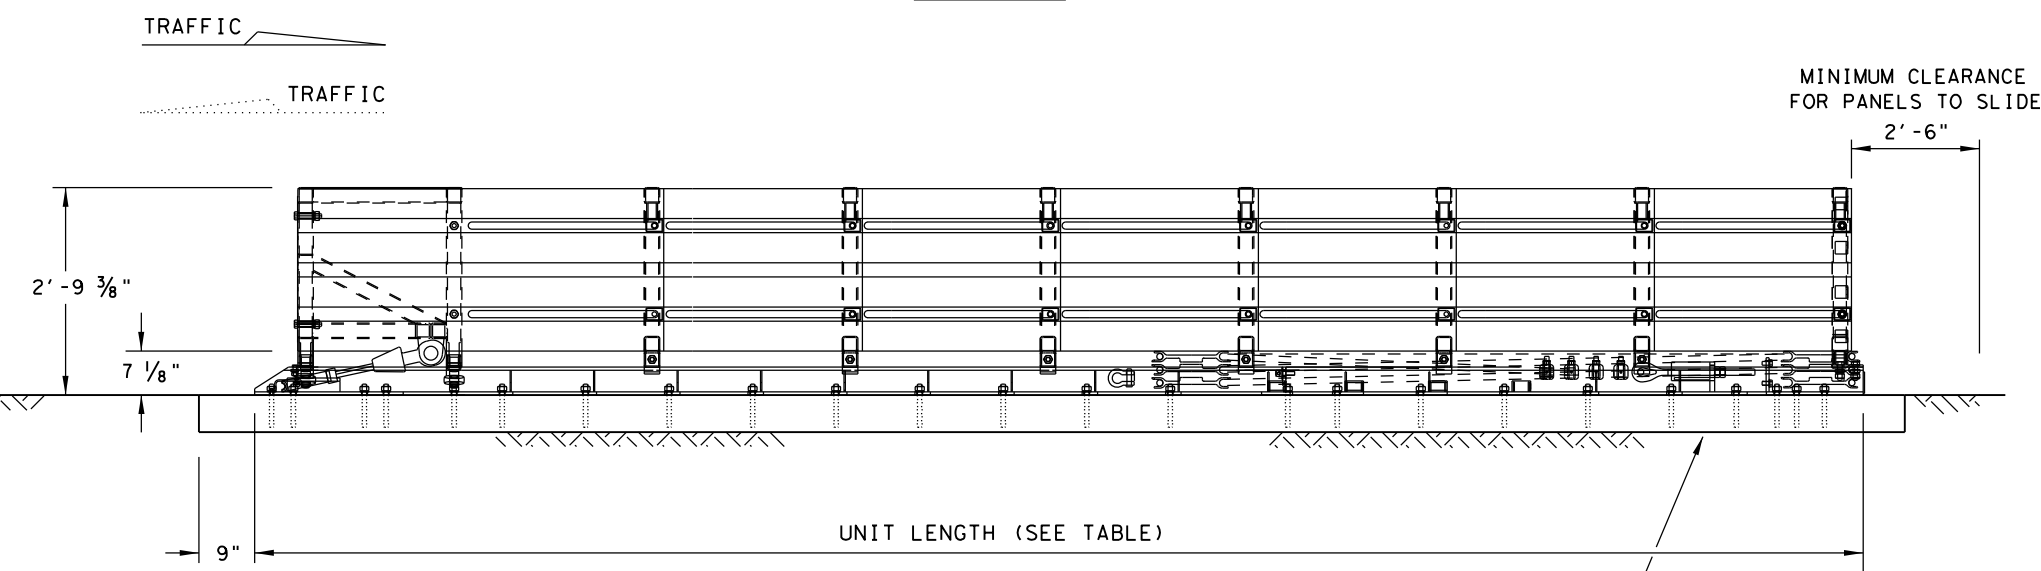

ELEVATION VIEW

6" REINFORCED PAD SHOWN (SEE FOUNDATION OPTIONS)

GENERAL NOTES

1. FOR SPECIFIC INFORMATION REGARDING INSTALLATION AND TECHNICAL GUIDANCE OF THE SYSTEM, CONTACT: WORK AREA PROTECTION, CORP. AT (800) 327-4417, OR (630) 377-9100.
2. FOR BI-DIRECTIONAL TRAFFIC, APPROPRIATE TRANSITION PANELS WILL BE REQUIRED.
3. ADDITIONAL DETAILS FOR THE TRANSITION OPTION AND FOUNDATION OPTION WILL BE SHOWN ON THE MANUFACTURER'S SHOP DRAWINGS FURNISHED TO THE ENGINEER.
4. CONCRETE SHALL BE CLASS "S" WITH A MINIMUM COMPRESSIVE STRENGTH OF 4,000 PSI.
5. MAXIMUM PERMISSIBLE CROSS-SLOPE IS 8%.
6. THE INSTALLATION AREA SHOULD BE FREE FROM CURBS, ELEVATED OBJECTS, OR DEPRESSIONS.
7. THE SCI100GM & SCI70GM SYSTEMS SHOULD BE APPROXIMATELY PARALLEL WITH THE BARRIER OR CENTERLINE OF MERGING BARRIERS.

NOTE:
 FOR ATTACHMENT AND TRANSITIONS TO OTHER SHAPES, BARRIERS, RAILINGS AND BI-DIRECTIONAL TRAFFIC FLOWS ARE AVAILABLE. (SEE MANUFACTURER'S PRODUCT MANUAL)

NOTE:
 SIDE PANELS CAN TRAVEL 30" BEYOND THE LAST TERMINAL BRACE AT THE REAR OF THE CUSHION. ALL OBJECTS THAT MAY INTERFERE WITH THIS MOTION CAN AFFECT PERFORMANCE OF AND MAY CAUSE UNDUE DAMAGE TO THE CRASH CUSHION.

MODEL	TEST LEVEL	UNIT LENGTH (approx.)	UNIT WIDTH	FOUNDATION LENGTH	OBSTACLE WIDTH
SCI70GM	TL-2	13'-6"	2'-10 5/8"	15'- 6 1/4"	24" to 36"
SCI100GM	TL-3	21'-6"	3'-1 1/2"	23'- 0"	24" to 36"

SYSTEM AND PAD LENGTHS VARY DEPENDING ON BACKUP TYPE.

FOUNDATION OPTIONS
6" REINFORCED CONCRETE (5 1/2" ANCHOR EMBEDMENT)
8" UNREINFORCED CONCRETE (5 1/2" ANCHOR EMBEDMENT)
3" MIN. ASPHALT OVER 3" MIN. CONCRETE (16 1/2" ANCHOR EMBED.)
6" ASPHALT OVER 6" COMPACT SUBBASE (16 1/2" ANCHOR EMBED.)
8" MINIMUM ASPHALT (16 1/2" ANCHOR EMBEDMENT)

FOR STEEL PLACEMENT IN CONCRETE FOUNDATIONS, SEE MANUFACTURER'S PRODUCT MANUAL.

TRANSITION OPTIONS
CONCRETE VERTICAL WALL
CONCRETE TRAFFIC BARRIERS
GUARDRAIL (W-BEAM)
GUARDRAIL (THRIE-BEAM)


TRANSITION TYPES ARE SHOWN ELSEWHERE ON THE PLANS (I.E. ATTENUATOR LOCATION DETAILS OR IN THE GENERAL NOTES).

FOR BI-DIRECTIONAL TRANSITION PANEL AND END SHOE DETAILS, SEE MANUFACTURER'S PRODUCT MANUAL.


				Design Division Standard	
WORK AREA PROTECTION CORP (SMART-NARROW) SMTC (N) - 16					
FILE: smtcn16.dgn	DN: TxDOT	CK: KM	DW: VP	CK: VP	
©TxDOT: February 2006	CONT	SECT	JOB	HIGHWAY	
REVISIONS	2311	01	044	FM	3051
REVISED 06, 2013 (VP)	DIST	COUNTY			SHEET NO.
REVISED 03, 2016 (VP)	WAC	MCLENNAN			46

LOW MAINTENANCE

DATE: 10/5/2022
 FILE: \\txdot\projectwiseonline.com:TXDOT3\Documents\09 - WAC\Design Projects\231101044\4 - Design\Plan Set\3. RoadwayStandards\TAU-II-R(N)-16.dgn
 DISCLAIMER: The use of this standard is governed by the "Texas Engineering Practice Act". No warranty of any kind is made by TxDOT for any purpose whatsoever. TxDOT assumes no responsibility for the conversion of this standard to other formats or for incorrect results or damages resulting from its use.

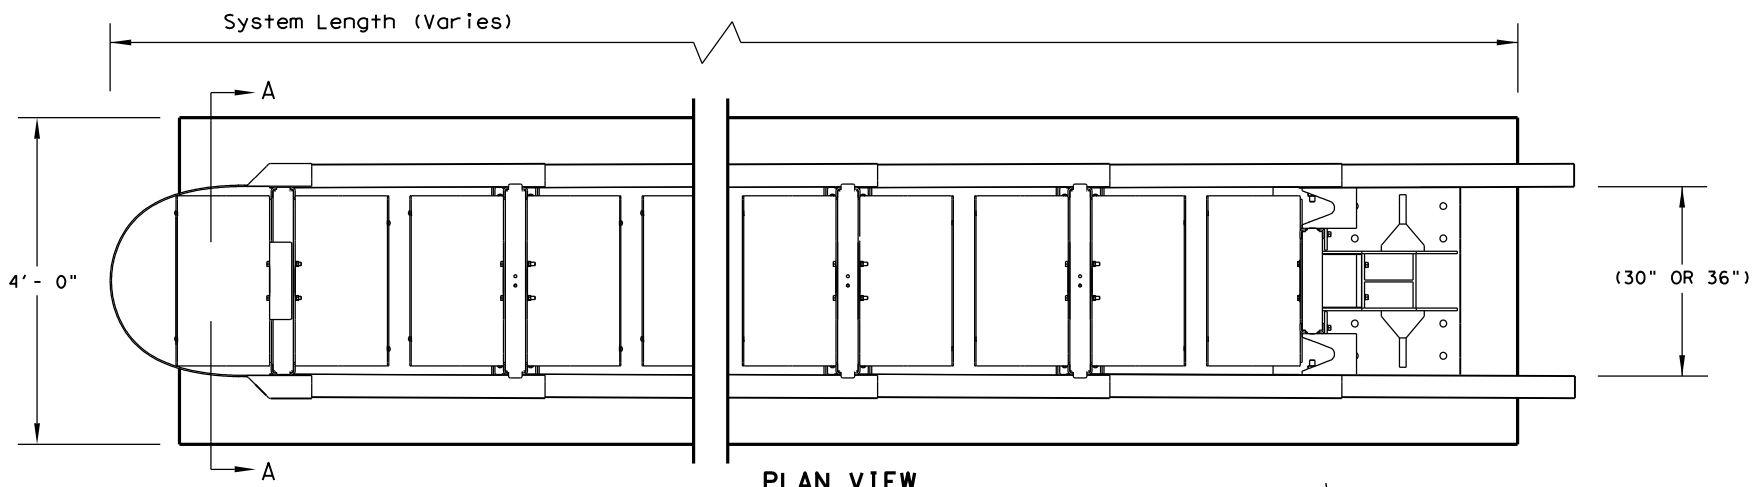


PLAN VIEW

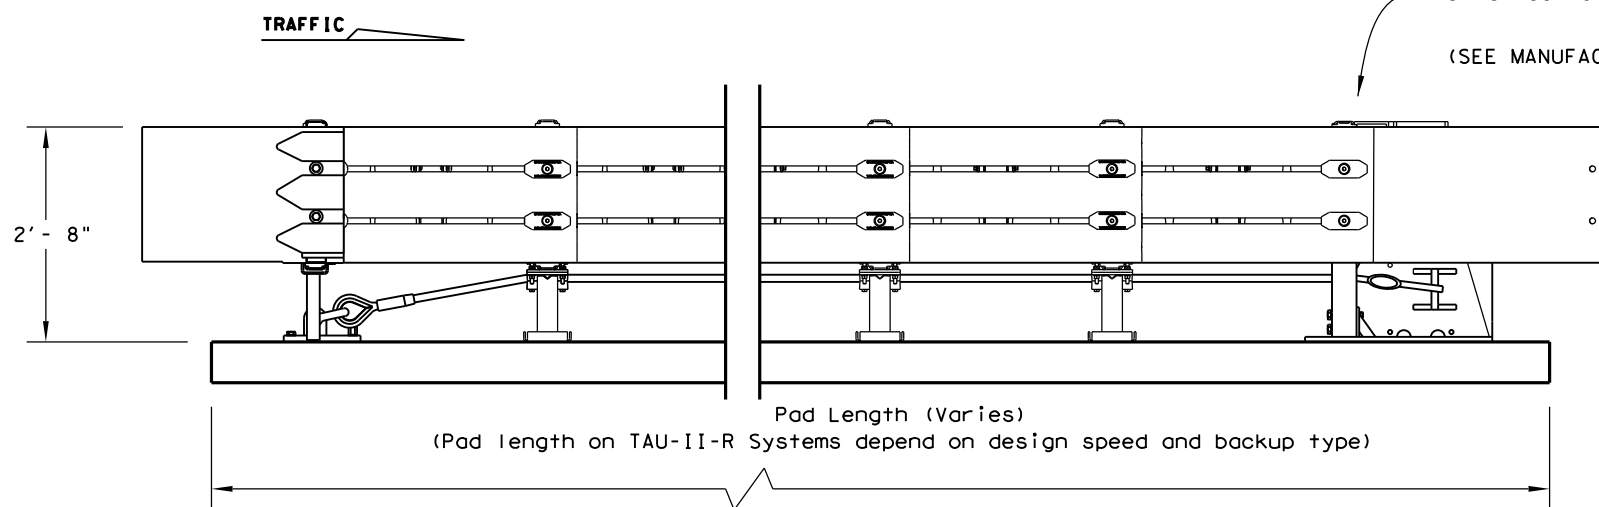

ELEVATION VIEW

Attachments and transitions to various barrier shapes, barrier railings and bi-directional traffic flows are available.
 (SEE MANUFACTURER'S PRODUCT MANUAL)

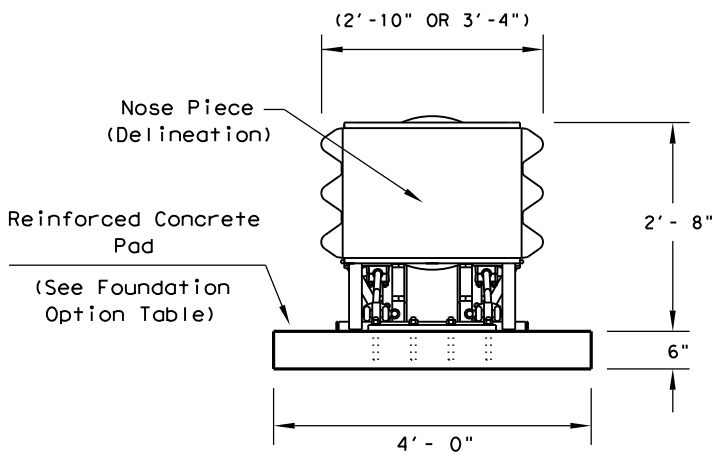

SECTION A-A


Nose Piece delineation orientation, is shown elsewhere on the plans.

TRANSITION OPTIONS
Vertical Wall
Concrete Traffic Barriers
W-Beam Guardrail
Thrie Beam Guardrail

For bi-directional transition panel and end shoe details. (See manufacturer's product manual.)

FOUNDATION OPTIONS
6" Reinforced Concrete
8" Unreinforced Concrete
Asphalt over Concrete with Minimum 6" Embedment in Concrete
6" Asphalt over 6" Compact Subbase
8" Minimum Asphalt

For steel placement in concrete foundations. (See manufacturer's product manual)

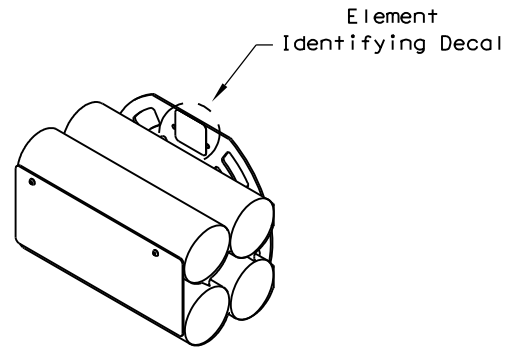

ENERGY ABSORBING ELEMENTS (EAE)

BACKUP SUPPORT OPTIONS
Compact (Stand Alone)
Flush Mount
PCB (Concrete Barrier)

TAU-II-R (NARROW) SYSTEM LENGTHS			
BACKSTOP	TL-2	TL-3	70 mph
PCB	13'-7"	27'-10"	30'-7"
Flush Mount	14'-0"	28'-3"	31'-0"
Compact	15'-3"	29'-6"	32'-3"

Backup and Transition types are shown elsewhere on the plans, (i.e. Attenuator location details or in the general notes).

Note: System lengths are ± 2"

GENERAL NOTES

- For specific information regarding installation and technical guidance of the system, contact: Lindsay Transportation Solutions - Barrier Systems, Inc. at (707) 374-6800. 180 River Road, Rio Vista, CA 94571
- For bi-directional traffic, appropriate transition panels will be required.
- Additional details for the backup support option, transition options and foundation option will be shown on the manufacturer's shop drawings furnished to the Engineer.
- Concrete shall be class "S" with a minimum compressive strength of 4,000 psi.
- Maximum permissible cross-slope is 8%.
- The installation area should be free from curbs, elevated objects, or depressions.
- The TAU-II-R system should be approximately parallel with the barrier or center of merging barriers.
- Refer to Universal TAU-II-R configuration chart for specific systems configuration number and location of each type of energy absorbing element.
- 30-inch (30") model shown, also available in 36-inch (36") configuration.

BILL OF MATERIAL

PRODUCT CODE	QTY	DESCRIPTION
B030704	1	Front Support
B030703	TBD	Mid Support
TBD	1	Backstop Assembly (See Table)
TBD	1	Front Cable Anchor
TBD	1	Nose Assembly
B010202	TBD	Sliding Panel
B010659	2	End Panel
K001003	1	Slider Assembly Kit
BSI-1202006-KT	TBD	TAU-II-R Slider Kit
BSI-1107131-KT	TBD	TAU-II-R EAE Mounting Hw Kit
BSI-1012069-00	TBD	Energy Absorbing Element, Type 1
BSI-1012070-00	TBD	Energy Absorbing Element, Type 2
BSI-1012071-00	TBD	Energy Absorbing Element, Type 3
BSI-1110009-00	TBD	Energy Absorbing Element, Type 3N
TBD	TBD	Cable Assembly
K001004	TBD	Cable Guide Kit
K001005	2	Front Support Leg Kit
B010651	4	Pipe Panel Mount
TBD	1	Anchoring Package

(TBD) = To Be Determined, depending on Backup Type and System Length.

(See manufacturer's product manual for details)




LTS-BARRIER SYSTEMS
CRASH CUSHION
(R-NARROW)
TAU-II-R(N)-16

FILE: tauirr16.dgn	DN: TxDOT	CK: KM	DW: VP	CK: CGL
©TxDOT: January 2013	CONT	SECT	JOB	HIGHWAY
REVISIONS	2311	01	044	FM 3051
REVISED 06, 2013 (VP)	DIST	COUNTY	SHEET NO.	
REVISED 03, 2016 (VP)	WAC	MCLENNAN	47	

LOW MAINTENANCE


DISCLAIMER: The use of this standard is governed by the "Texas Engineering Practice Act". No warranty of any kind is made by TxDOT for any purpose whatsoever. TxDOT assumes no responsibility for the conversion of this standard to other formats or for incorrect results or damages resulting from its use.

DATE: 10/5/2022
 FILE: pw:\txdot\projectwiseonline.com:TXDOT3\Documents\09 - WAC\Design Projects\231101044\4 - Design\Plan Set\3. Roadway Standards\TE (HMAC) - 11.dgn

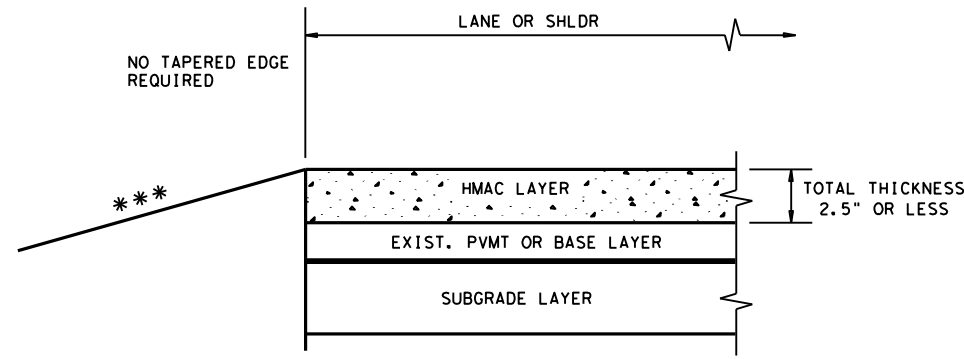

*** SEE TYPICAL SECTION FOR ROADSIDE DETAILS


CONDITION - 1
 THIN HMAC SURFACES OR HMAC OVERLAY
 WITH THICKNESS OF 2.5" OR LESS

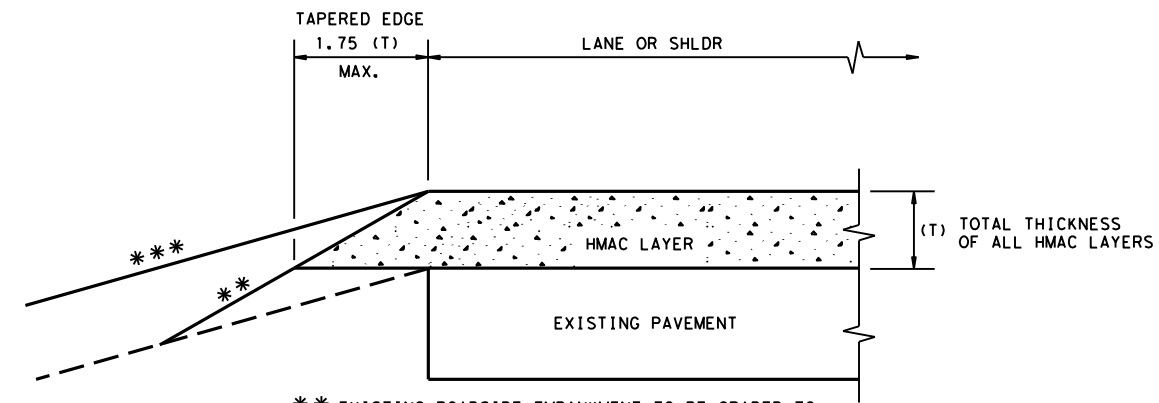

** EXISTING ROADSIDE EMBANKMENT TO BE GRADED TO PRODUCE A SMOOTH LEVEL SURFACE FOR PLACEMENT OF TAPERED EDGE. THIS WORK IS SUBSIDIARY TO THE VARIOUS BID ITEMS.


*** SEE TYPICAL SECTION FOR ROADSIDE DETAILS

CONDITION - 2
 OVERLAY OF EXISTING PAVEMENT
 HMAC THICKNESS 2.5" TO 5"

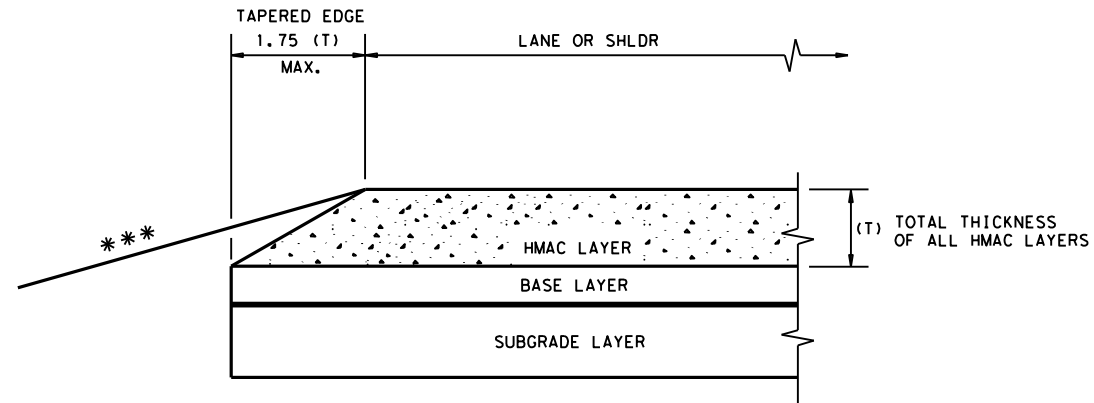

*** SEE TYPICAL SECTION FOR ROADSIDE DETAILS

CONDITION - 3
 NEW OR RECONSTRUCTED PAVEMENT
 HMAC THICKNESS 2.5" TO 5"

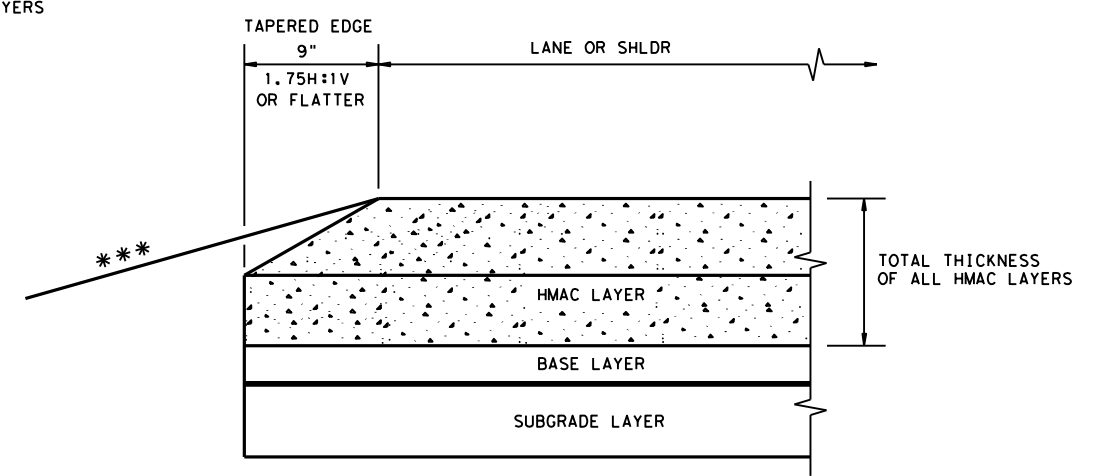

*** SEE TYPICAL SECTION FOR ROADSIDE DETAILS

CONDITION - 4
 NEW OR RECONSTRUCTED PAVEMENT
 HMAC THICKNESS 5" OR GREATER


GENERAL NOTES

1. UNLESS OTHERWISE SHOWN IN THE PLANS, A VERTICAL EDGE IS PERMISSIBLE FOR HMAC PLACED GREATER THAN 5" BELOW THE EDGE OF PAVEMENT AND FOR THICKNESS OF HMAC LESS THAN 2.5".
2. FOR FURTHER INFORMATION REGARDING THE ROADSIDE AND PAVEMENT DETAILS, SEE TYPICAL SECTIONS.
3. PAYMENT FOR TAPERED EDGE WILL BE IN ACCORDANCE WITH APPLICABLE ITEMS IN THE CONTRACT.
4. THE SLOPE OF THE TAPERED EDGE SHALL BE 1.75H:1V OR FLATTER.
5. THE TAPERED EDGE SHALL BE PRODUCED BY USE OF A SCREED ATTACHMENT CAPABLE OF PRODUCING A SMOOTH COMPACTED SURFACE. ADDITIONAL COMPACTING EFFORT BEHIND THE SCREED IS NOT REQUIRED.


(NOT TO SCALE)

				Design Division Standard	
TAPERED EDGE DETAILS HMAC PAVEMENT					
TE (HMAC) - 11					
FILE: tehmac11.dgn	DN: TxDOT	CK: RL	DW: KB	CK:	
© TxDOT January 2011	CONT: 2311	SECT: 01	JOB: 044	HIGHWAY: FM 3051	
REVISIONS		DIST: WAC	COUNTY: MCLENNAN	SHEET NO.:	48


DATE: 10/5/2022
 FILE: \\txdot.projectwiseonline.com:TXDOT3\Documents\09 - WAC\Design Projects\231101044\4 - Design\Plan Set\3. RoadwayStandards\MBGF-19.dgn
 DISCLAIMER: The use of this standard is governed by the "Texas Engineering Practice Act". No warranty of any kind is made by TxDOT for any purpose whatsoever. TxDOT assumes no responsibility for the conversion of this standard to other formats or for incorrect results or damages resulting from its use.

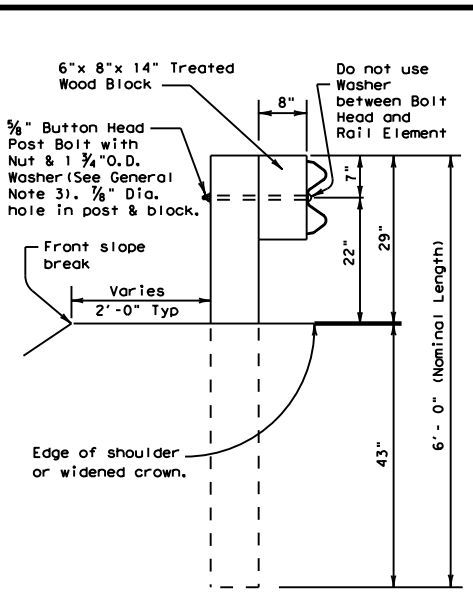


TYPICAL POST

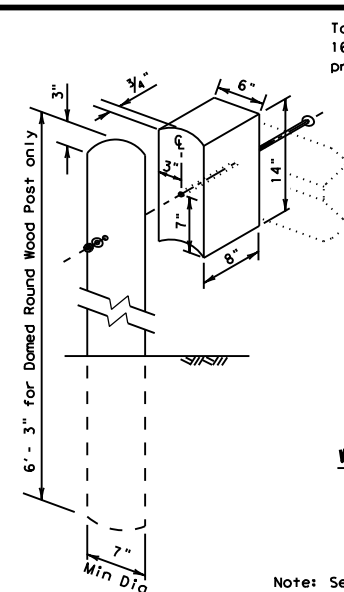

WOOD BLOCK TO ROUND WOOD POST

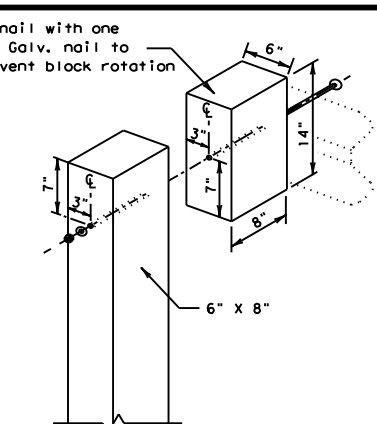


WOOD BLOCK TO RECTANGULAR WOOD POST

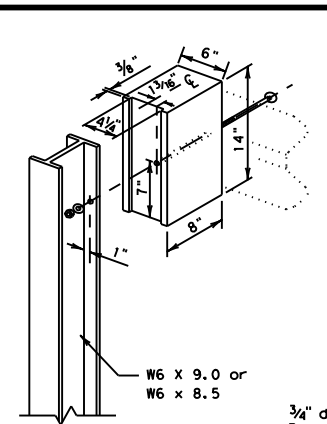


WOOD BLOCK TO STEEL POST


Note: See Rail Splice Detail for the required hardware.

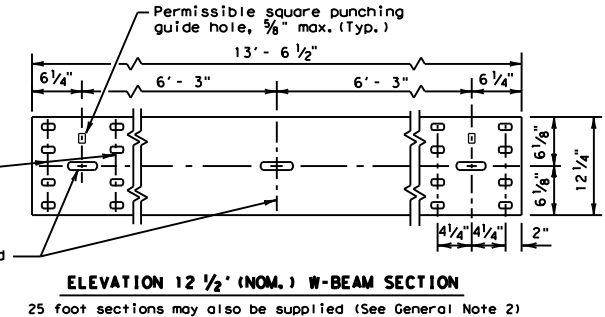

ELEVATION 12 1/2' (NOM.) W-BEAM SECTION
25 foot sections may also be supplied (See General Note 2)

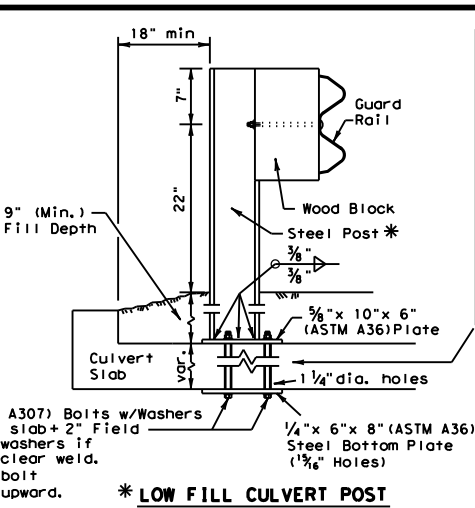


*** LOW FILL CULVERT POST**
FOR USE ON NON-BRIDGE CLASS CULVERTS ONLY

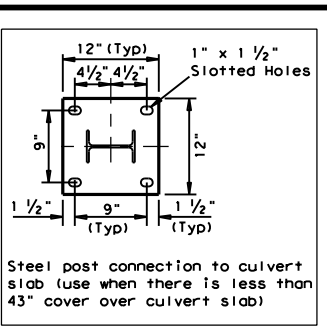

Steel post connection to culvert slab (use when there is less than 43 inch cover over culvert slab)


* Post(s) may require field modifications to ensure proper guardrail height.

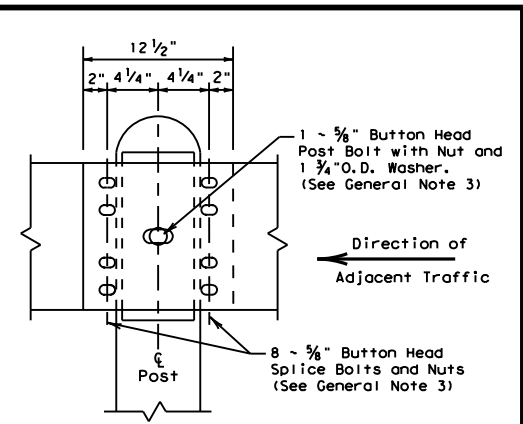


RAIL SPLICE DETAIL

GENERAL NOTES

- The type of post (round wood post, rectangular wood post, or steel post) will be shown elsewhere in the plans. The exact position of MBSG shall be shown elsewhere in the plans or as directed by the Engineer. Steel posts to be galvanized in accordance with Item 445, "Galvanizing."
- Rail element shall meet the requirements of Item 540, "Metal Beam Guard Fence" except as modified on the plans. The Contractor may furnish rail elements of 12 1/2 or 25 foot nominal lengths.
- Button head "post" bolts (ASTM A307) shall be of sufficient length to extend through the full thickness of the nut (ASTM A563) and Type A (1 3/4 inch O.D.) washer and not more than 1 inch beyond it. Button head "splice" bolts (ASTM A307) are 3/8 inch x 1 1/4 inch (or 2 inch long at triple rail splices) with a 3/8 inch double recessed nut (ASTM A563).
- Fittings (bolts, nuts, and washers) shall be galvanized in accordance with Item 445, "Galvanizing." Fittings shall be subsidiary to the bid item.
- Crown shall be widened to accommodate the Metal Beam Guard Fence.
- The lateral approach to the guard fence, shall have a slope rate of not more than 1V:10H.
- Unless otherwise shown in the plans, guard fence placed in the vicinity of curbs shall be positioned so that the face of curb is located directly below or behind the face of the block. Rail placed over curbs shall be installed so that the post bolt is located approximately 21 inches above the gutter pan or roadway surface.
- If solid rock is encountered within 0 to 18 inch of the finished grade, drill a 22 inch dia. hole, 24 inch into the rock, or drill two 12 inch dia. front to back overlapping holes, 24 inch into the rock. If solid rock is encountered below 18 inch, drill a 12 inch dia. hole, 12 inch into the rock or to the standard embedment depth, whichever is less. Any excess post length, after meeting these depths, may be field cut to ensure proper guardrail mounting height. Backfill with a cohesionless material.
- Posts shall not be set in concrete, of any depth.
- Special fabrication will be required at installations having a curvature of less than 150 ft. radius.
- The terminal anchor section (TAS) post shall be set in Class A concrete (unless otherwise shown in the plans) in accordance with Item 421, "Hydraulic Cement Concrete." Concrete shall be subsidiary to the bid item requiring construction of the terminal anchor section (TAS). Terminal anchor post to be galvanized in accordance with Item 445, "Galvanizing."
- Unless otherwise shown in the plans, a composite material post and/or block that meets the requirements of DMS-7210, "Composite Material Posts and Blocks for Metal Beam Guard Fence" may be substituted for posts and/or blocks of similar dimensions. The Construction Division, TxDOT maintains a Material Producer List (MPL) for producers of materials conforming to DMS-7210. Only producers on the MPL can furnish composite material posts and/or blocks.

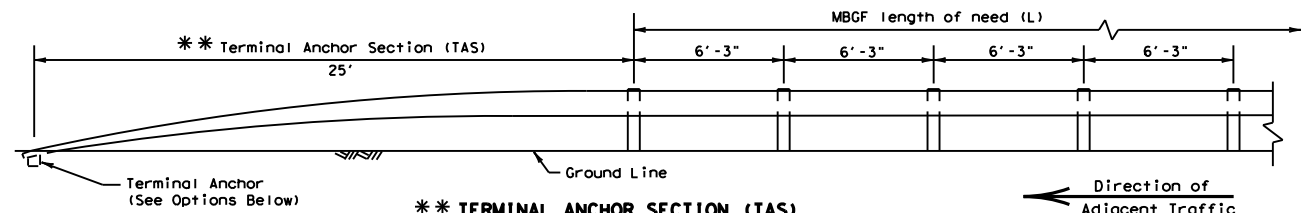


**** TERMINAL ANCHOR SECTION (TAS)**
Terminal anchor sections are only for downstream use, when located outside the horizontal clearance area of opposing traffic.

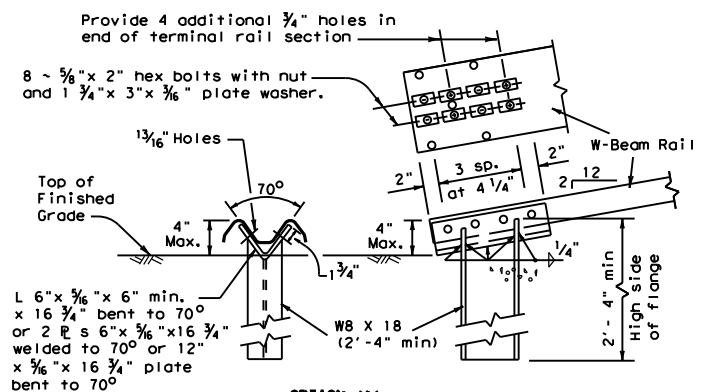


OPTION (1)

Note: This anchor post requires four additional 3/4 inch holes (shop or field) in the rail member with eight 5/8 inch hex bolts with nut and plate washer.

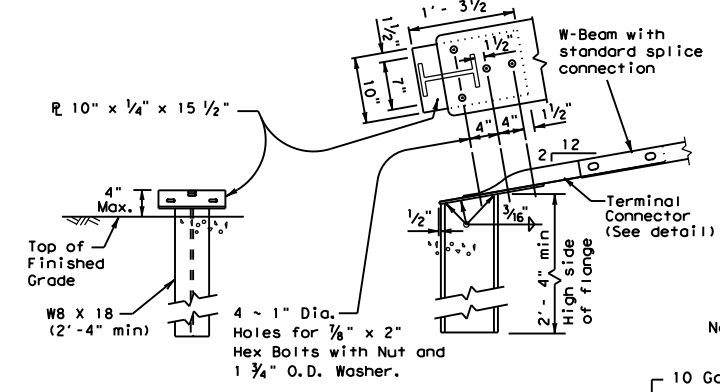


OPTION (2)

Note: This anchor post requires the use of the 10 ga. terminal connector with four 5/8 inch hex bolts with nut and washer.

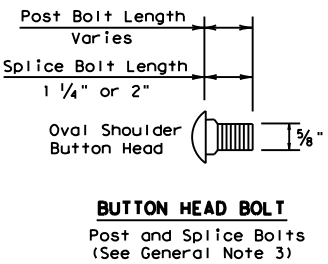


BUTTON HEAD BOLT
Post and Splice Bolts (See General Note 3)

Note: Terminal Connector to be used with terminal anchor post options 2.

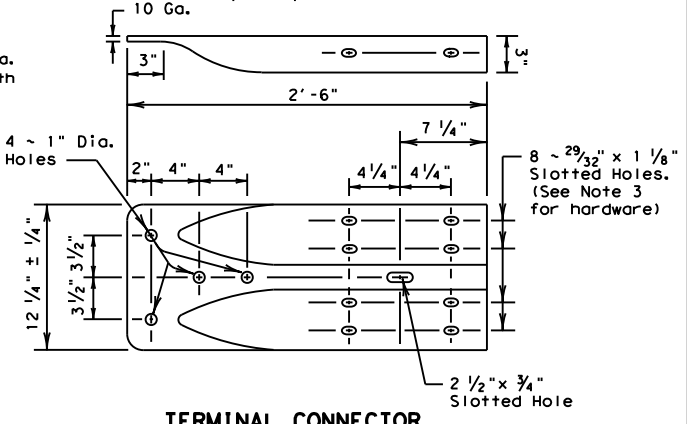


TERMINAL CONNECTOR

For connection hardware to concrete rails, see the MBSG transition standards.

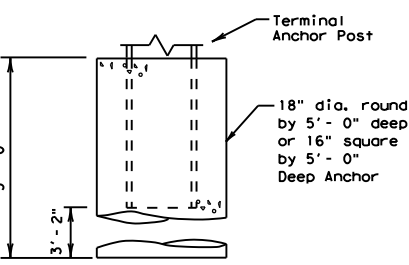

TERMINAL CONCRETE ANCHOR OPTIONS
(See General Note 11)

Notes:
 Either concrete anchor may be used with either post option above.
 No construction joint is allowed in the concrete anchor.
 Terminal rail may be bolted to post and in twist position prior to placing concrete anchor.
 If concrete anchor is precast, the area should be compacted as directed by the Engineer, when placed in the field.

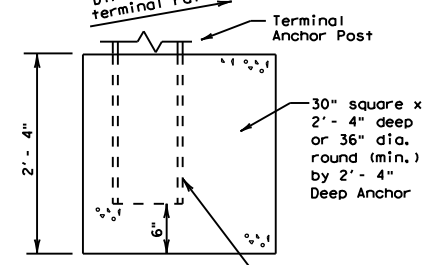

Place face of post approx. on center of anchor

ONLY FOR USE IN MAINTENANCE REPAIRS OR HIGHLY CONSTRAINED SITE CONDITIONS.







METAL BEAM GUARD FENCE


MBGF-19

FILE: mbgf19.dgn	DN: TxDOT	CK: KM	DW: BD	CK: VP
© TxDOT NOVEMBER 2019	CONT	SECT	JOB	HIGHWAY
REVISIONS	2311	01	044	FM 3051
	DIST	COUNTY		SHEET NO.
	WAC	MCLENNAN		49

DATE: 10/5/2022
 FILE: \\txdot.projectwiseonline.com:TXDOT3\Documents\09 - WAC\Design Projects\2311010444 - Design\Plan Set\3. RoadwayStandards\MBGF (TR) -19.dgn
 DISCLAIMER: THE USE OF THIS STANDARD IS COVERED BY THE "TEXAS ENGINEERING PRACTICE ACT". NO WARRANTY OF ANY KIND IS MADE BY TXDOT FOR ANY PURPOSE WHATSOEVER. TXDOT ASSUMES NO RESPONSIBILITY FOR THE CONVERSION OF THIS STANDARD TO OTHER FORMATS OR FOR INCORRECT RESULTS OR DAMAGES RESULTING FROM ITS USE.

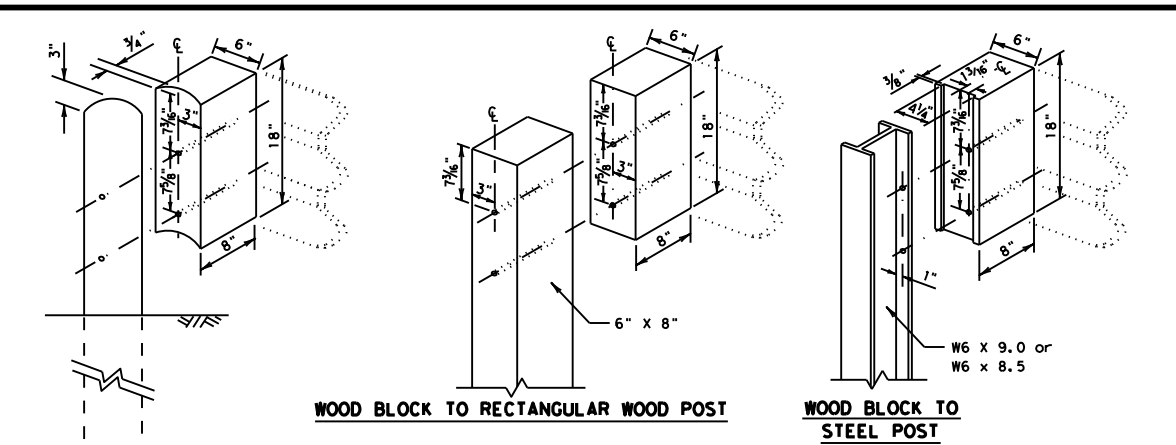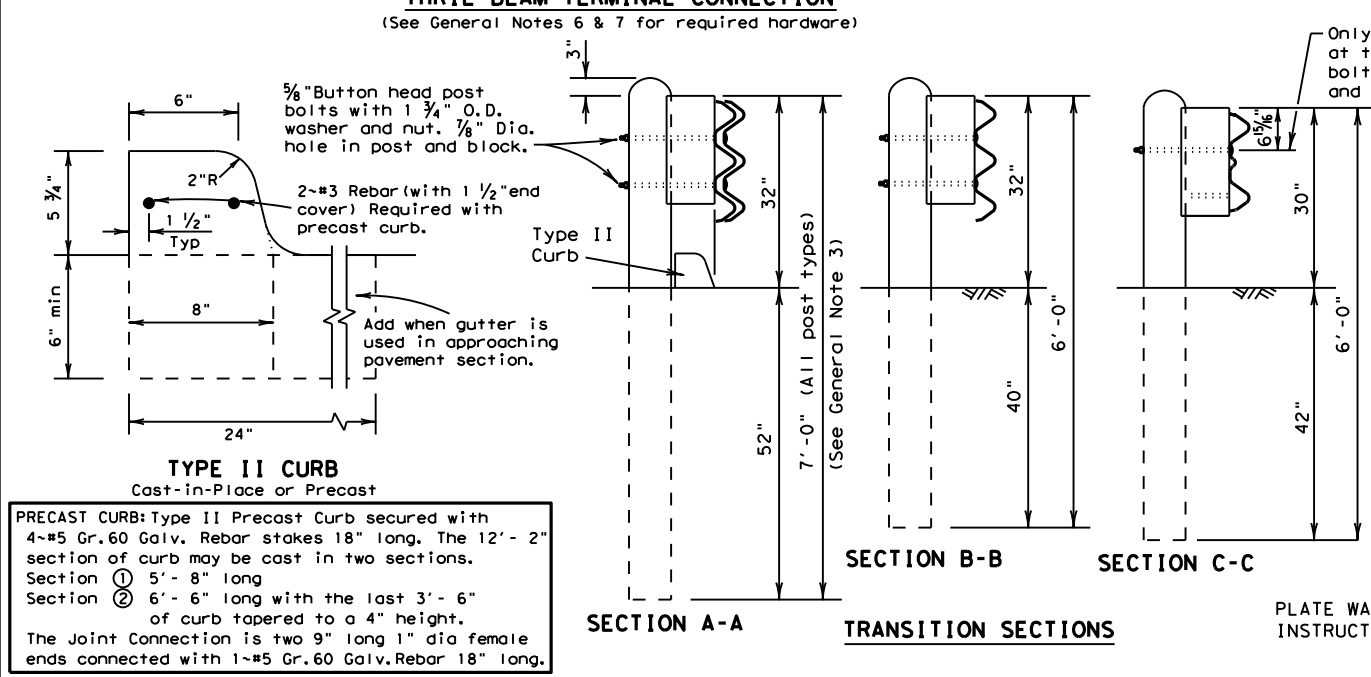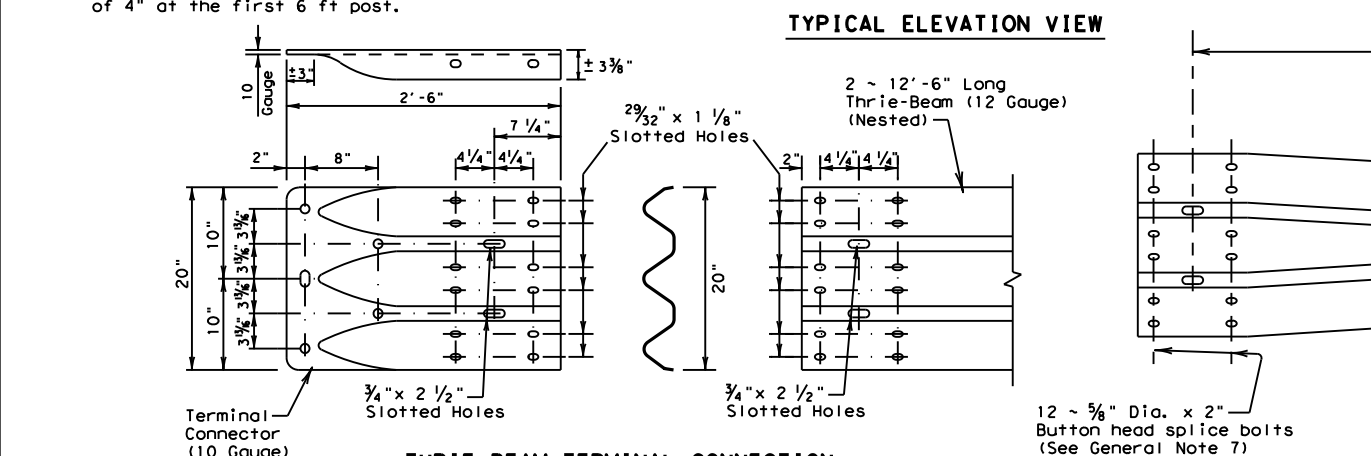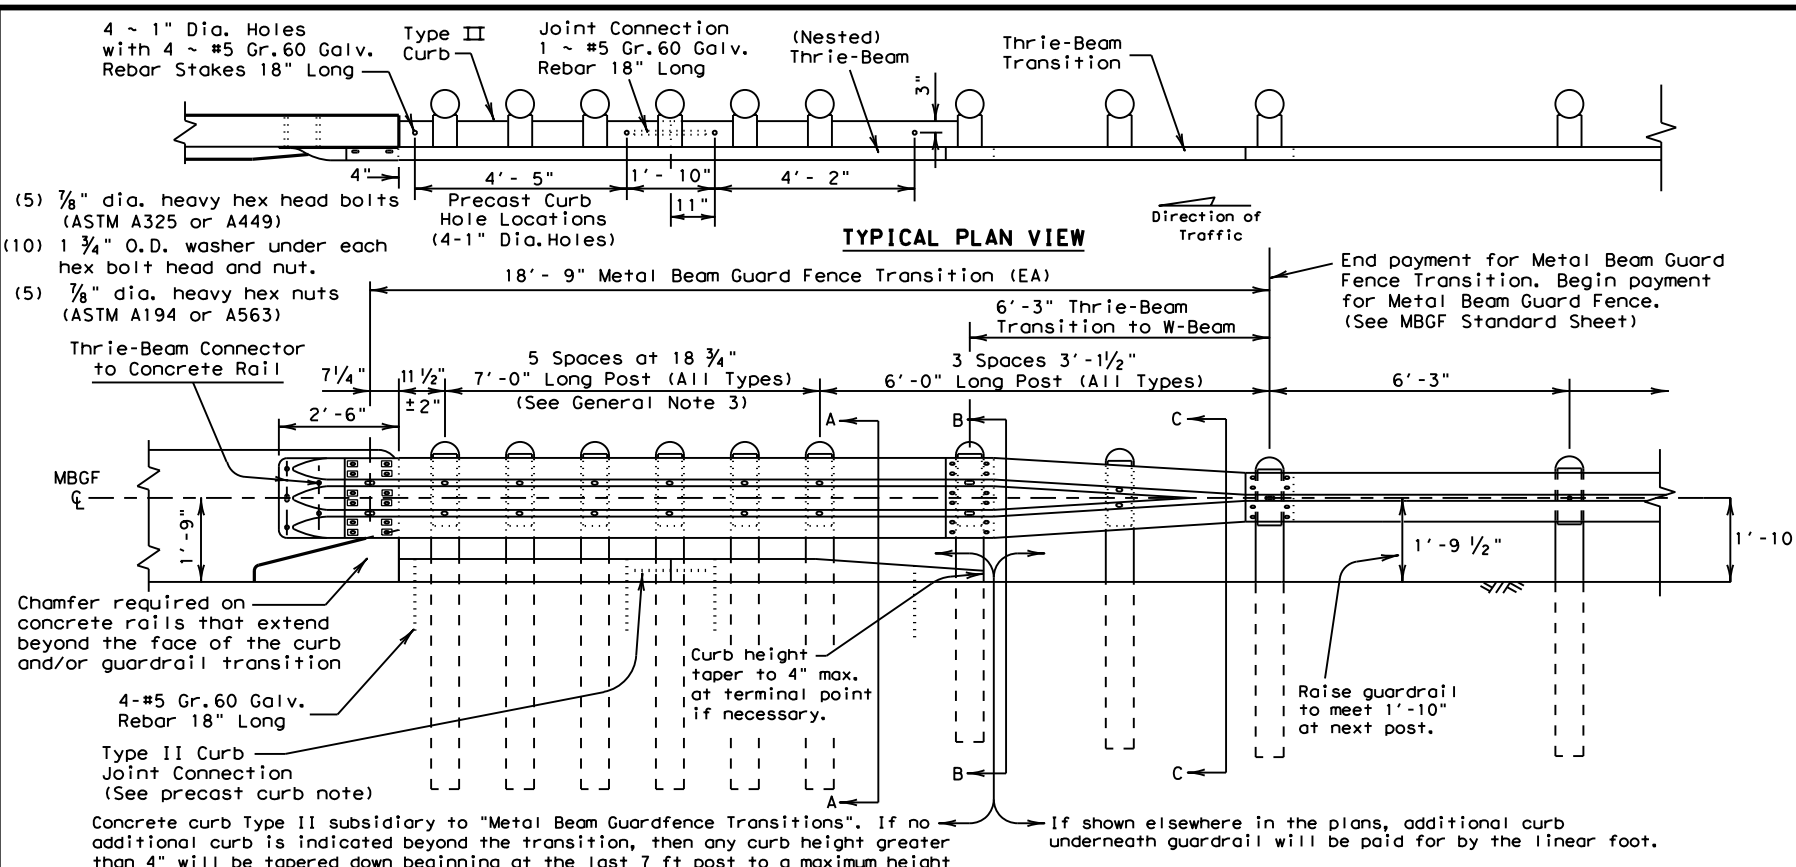

- WOOD BLOCK TO ROUND WOOD POST**
- 7" Min Dia
- GENERAL NOTES**
- Concrete curb may be cast-in-place or precast as shown on this sheet. When used in conjunction with thrie-beam guard fence transitions, curb shall be Type II (Typically 5 3/4" height above surface; See CCCC standard sheet) unless otherwise shown in the plans. If other curb heights are shown in the plans in conjunction with the transition, the curb height may be from 4" to 8" with a relatively vertical face. Concrete curb shall be continuous to the seventh post.
 - Contact the Design Division for drainage cut options needed within the curb section of the transition.
 - The type of post (round wood, rectangular wood or steel) will be shown elsewhere in the plans.
 - The post length shall be marked on all 7' - 0" long posts by the Manufacturer. The mark shall be located within the top 1 ft. region of the post, at least 3/8" in height, and visible after installation. Wooden posts shall be marked with a brand, and steel posts with a stencil before galvanizing.
 - Rail element shall meet the requirements of Item 540, "Metal Beam Guard Fence" except as modified on the plans. The thrie-beam terminal connector and the thrie-beam transition to w-beam shall be of the same material, but shall not be less than 10 gauge.
 - Contractor shall verify that the locations of bolt holes match those in the thrie-beam terminal connector prior to ordering materials.
 - Unless otherwise shown in the plans, transitions shall be placed with the block face in front of or directly above the curb face.
 - Install terminal connector with (12) rectangular guardrail plate washers: (FWR03) and (12) 5/8" x 2" button head splice bolts with recessed nuts.
 - Button head "post bolts & nuts" shall meet the requirements of (ASTM A307), and shall be of sufficient length to extend through the full thickness of the nut and 5/8" washer (FWC16a) and not more than 1" beyond it. Trim remaining bolt length to meet required length.
 - Fittings (bolts, nuts, and washers) shall be galvanized in accordance with Item 445, "Galvanizing". Fittings shall be subsidiary to the bid item.
 - Crown shall be widened to accommodate transitions.
 - If solid rock is encountered. See the MBGF standard sheet for the proper installation guidance.
 - Posts shall not be set in concrete.
 - Unless otherwise shown in the plans, a composite material post and/or block that meets the requirements of DMS-7210, "Composite Material Posts and Blocks for Metal Beam Guard Fence" may be substituted for posts and/or blocks of similar dimensions. The Construction Division, TXDOT, maintains a Material Producer List (MPL) for producers of materials conforming to DMS-7210. Only producers on the MPL can furnish composite material posts and/or blocks.

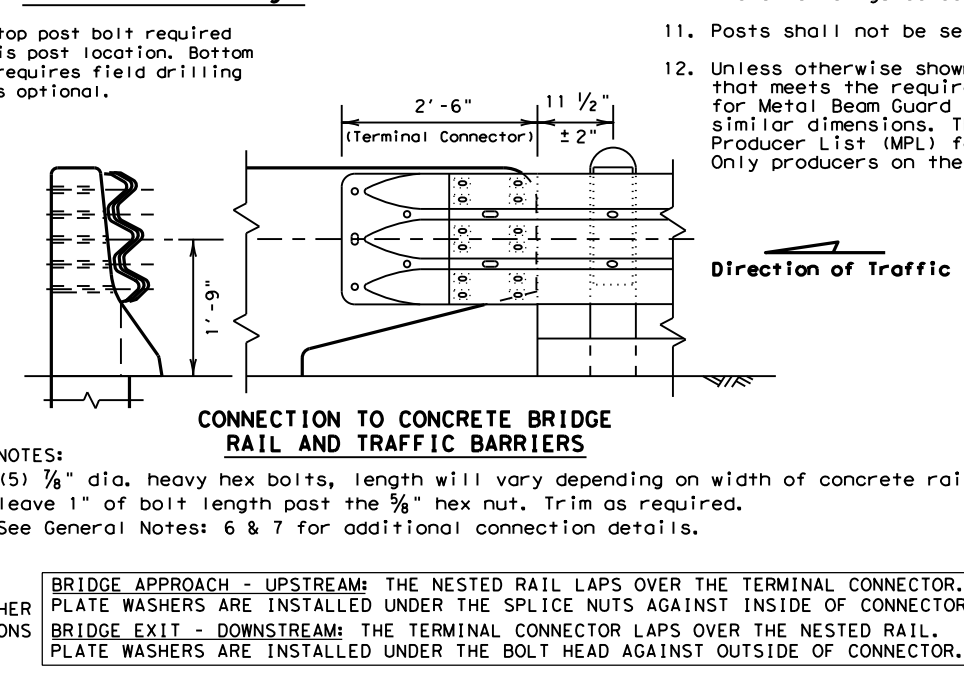


ONLY FOR USE IN MAINTENANCE REPAIRS.

Texas Department of Transportation
 Design Division Standard

METAL BEAM GUARD FENCE TRANSITION (THRIE-BEAM TRANSITION) MBGF (TR) -19


FILE: mbgfr19.dgn	DN: TXDOT	CK: KM	DW: BD	CK: VP
© TXDOT NOVEMBER 2019	CONT	SECT	JOB	HIGHWAY
REVISIONS	2311	01	044	FM 3051
	DIST	COUNTY	SHEET NO.	
	WAC	MCLENNAN	50	

DATE: 10/5/2022
 FILE: \\txdot.projectwiseonline.com\TXDOT3\Documents\09 - WAC\Design Projects\231101044\4 - Design\Plan Set\3. RoadwayStandards\MBGF (MS) - 19.dgn
 DISCLAIMER: THE USE OF THIS STANDARD IS COVERED BY THE "TEXAS ENGINEERING PRACTICE ACT". NO WARRANTY OF ANY KIND IS MADE BY TXDOT FOR ANY PURPOSE WHATSOEVER. TXDOT ASSUMES NO RESPONSIBILITY FOR THE CONVERSION OF THIS STANDARD TO OTHER FORMATS OR FOR INCORRECT RESULTS OR DAMAGES RESULTING FROM ITS USE.

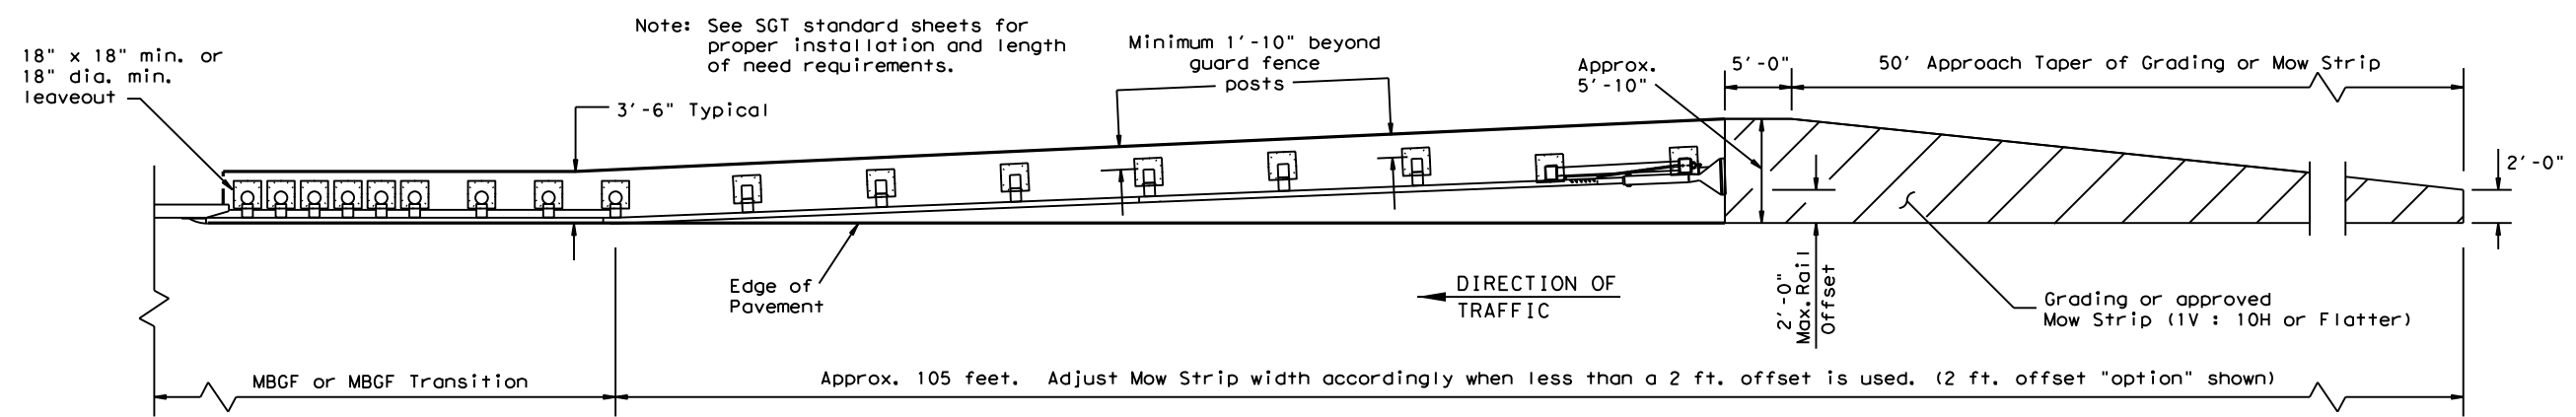


GRADING AND MOW STRIP AT GUARDRAIL END TREATMENTS

Note: Site Condition(s)
 Site conditions may exist where grading is required for the proper installation of metal guard fence and end treatments.
 Approach grading or mow strip may be decreased or eliminated. As directed by the Engineer.

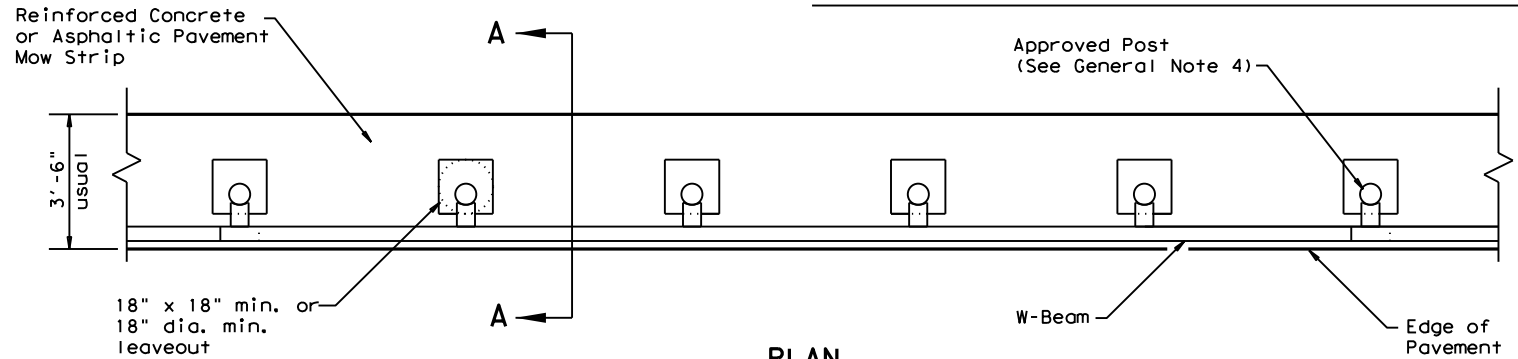


PLAN

Regular MBGF shown with Mow Strip

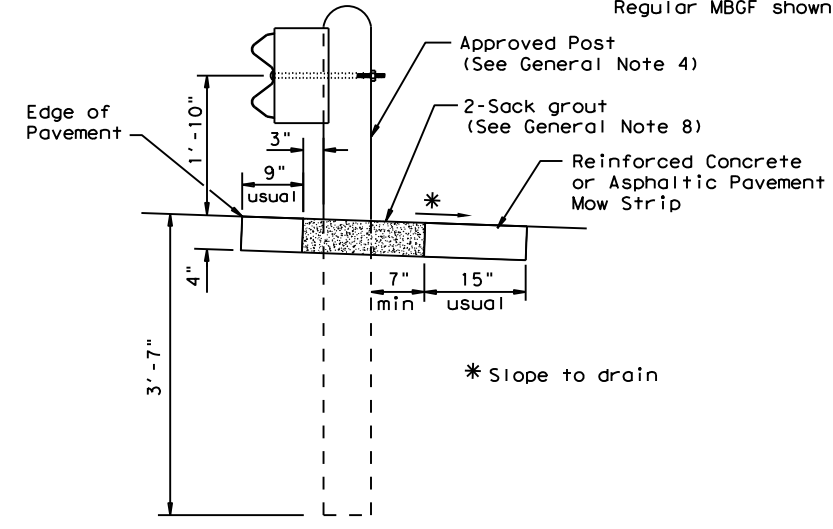

SECTION A-A

Typical

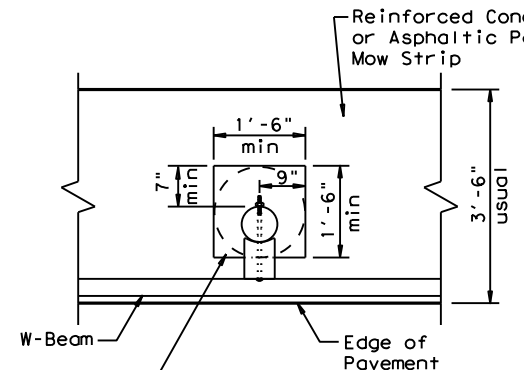


MOW STRIP DETAIL

Reinforced Concrete or Asphaltic Pavement Mow Strip with 18" x 18" or 18" dia. minimum leaveout.

Fill leaveout with 2-Sack grout. (See General Note 8)


GENERAL NOTES

1. This mow strip design is for use with metal beam guard fence, guard fence transitions, and guard fence end treatments (See SGT standards for proper SGT installation).
2. Mow strips shall be asphaltic pavement or reinforced concrete (wire mesh or synthetic fiber), as shown on the plans and will be paid for under the pertinent bid item of work. Asphaltic pavement shall meet the requirements of the item, and be placed in accordance with the pertinent bid item as shown on the plans. Reinforced concrete shall be placed in accordance with Item 432, "Riprap." The use of the synthetic fiber in lieu of steel reinforcing is acceptable, provided the fiber producer is on the Department Material Producer List (MPL), maintained by TxDOT, Construction Division.
3. The leaveout behind the post shall be a minimum of 7".
4. The type of approved post will be shown elsewhere in the plans. See the applicable standard sheets for additional details and information.
5. Other curb placement options may be used. Curbs are not considered part of the mow strip and will be paid for under other pertinent bid item.
6. Depth of mow strip will be 4".
7. The limits of payment for asphaltic pavement or reinforced concrete will include leaveouts for posts.
8. The leave-outs shall be filled with no more than a 2-sack grout mixture (1 part cement, 5 parts water, and 14 parts sand by volume) with a 28-day compressive strength of approximately 120 psi or less. Provide grout of a consistency that will flow into and completely fill all voids. Due to auger size, larger leave-out dimensions are acceptable from both an impact performance and maintenance repair standpoint (Suggested maximum leave-out of 20"). Payment for furnishing and placing the grout mixture will be subsidiary to the pay item of rip rap mow strip.

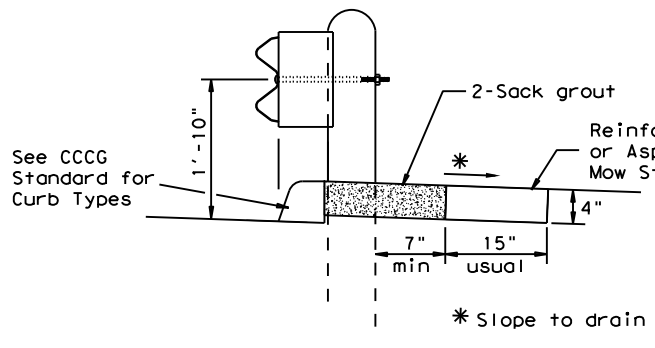


CURB OPTION (1)

This option will increase the post embedment through out the system.

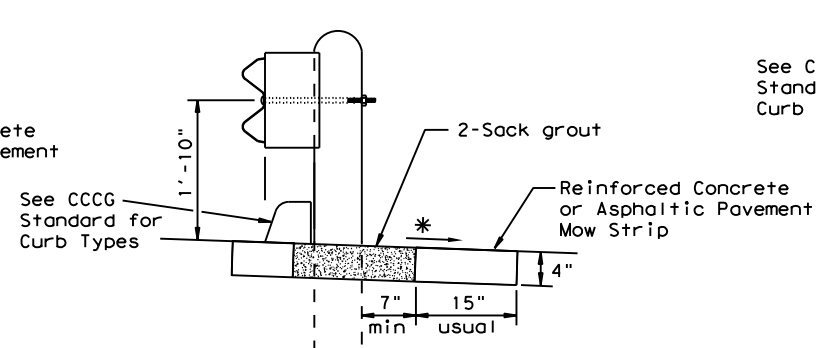

CURB OPTION (2)

Curb shown on top of mow strip

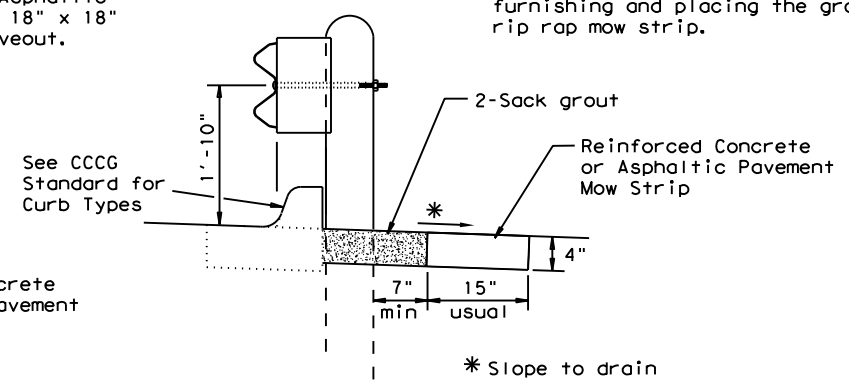

CURB OPTION (3)

ONLY FOR USE IN MAINTENANCE REPAIRS.






METAL BEAM GUARD FENCE (MOW STRIP) MBGF (MS) - 19

FILE: mbgfms19.dgn	DN: TXDOT	CK: KM	DW: TXDOT	CK: CL
© TXDOT NOVEMBER 2019	CONT	SECT	JOB	HIGHWAY
REVISIONS	2311	01	044	FM 3051
	DIST	COUNTY	SHEET NO.	
	WAC	MCLENNAN	51	



DISCLAIMER: THIS STANDARD IS COVERED BY THE "TEXAS ENGINEERING PRACTICE ACT". NO WARRANTY OF ANY KIND IS MADE BY TXDOT FOR ANY PURPOSE WHATSOEVER. TXDOT ASSUMES NO RESPONSIBILITY FOR THE CONVERSION OF THIS STANDARD TO OTHER FORMATS OR FOR INCORRECT RESULTS OR DAMAGES RESULTING FROM ITS USE.

DATE: 10/5/2022 11:59:24 AM
 FILE: \\txdot.projectwiseonline.com:TXDOT3\Documents\09 - WAC\Design Projects\231101044\4 - Design\Plan Set\3. RoadwayStandards\BED(28) -19.dgn

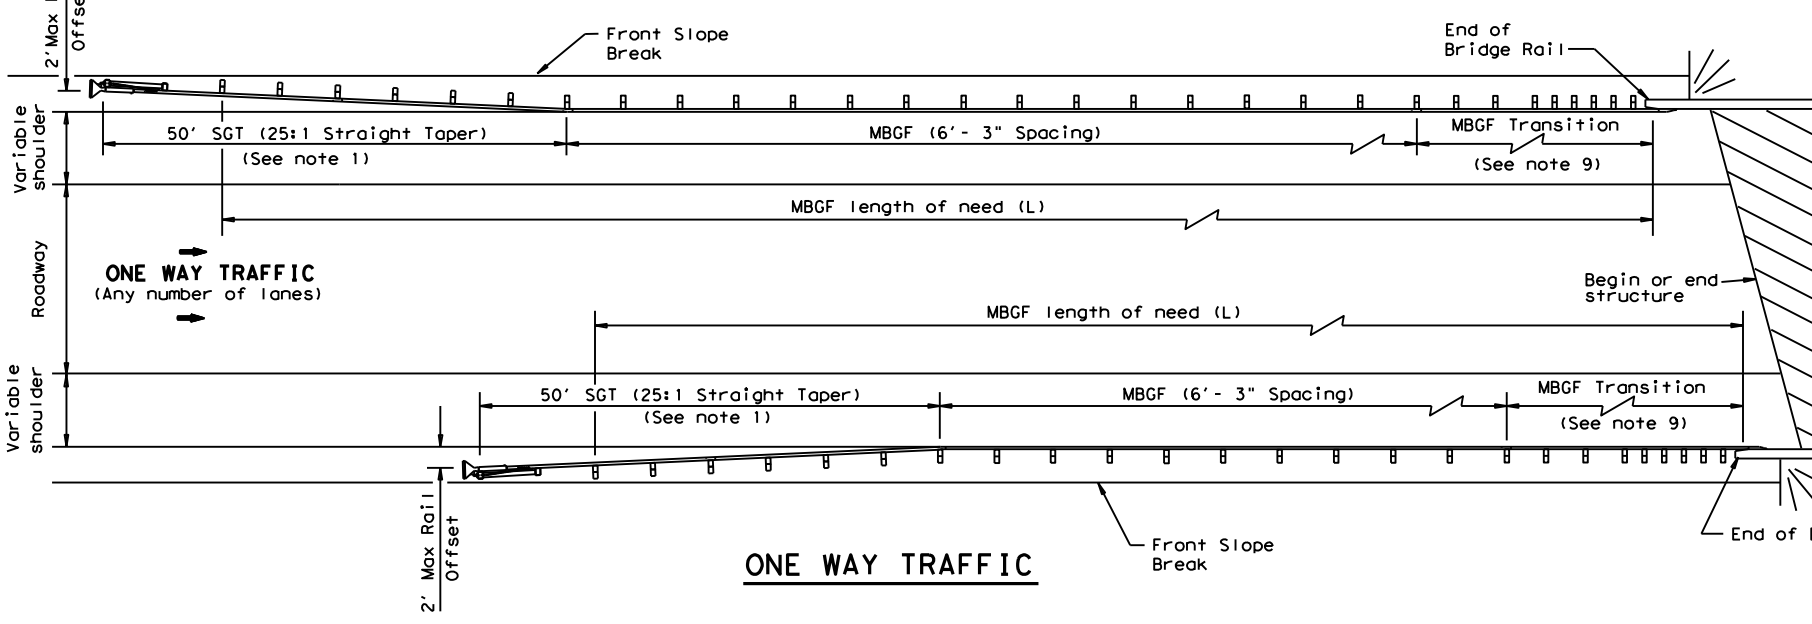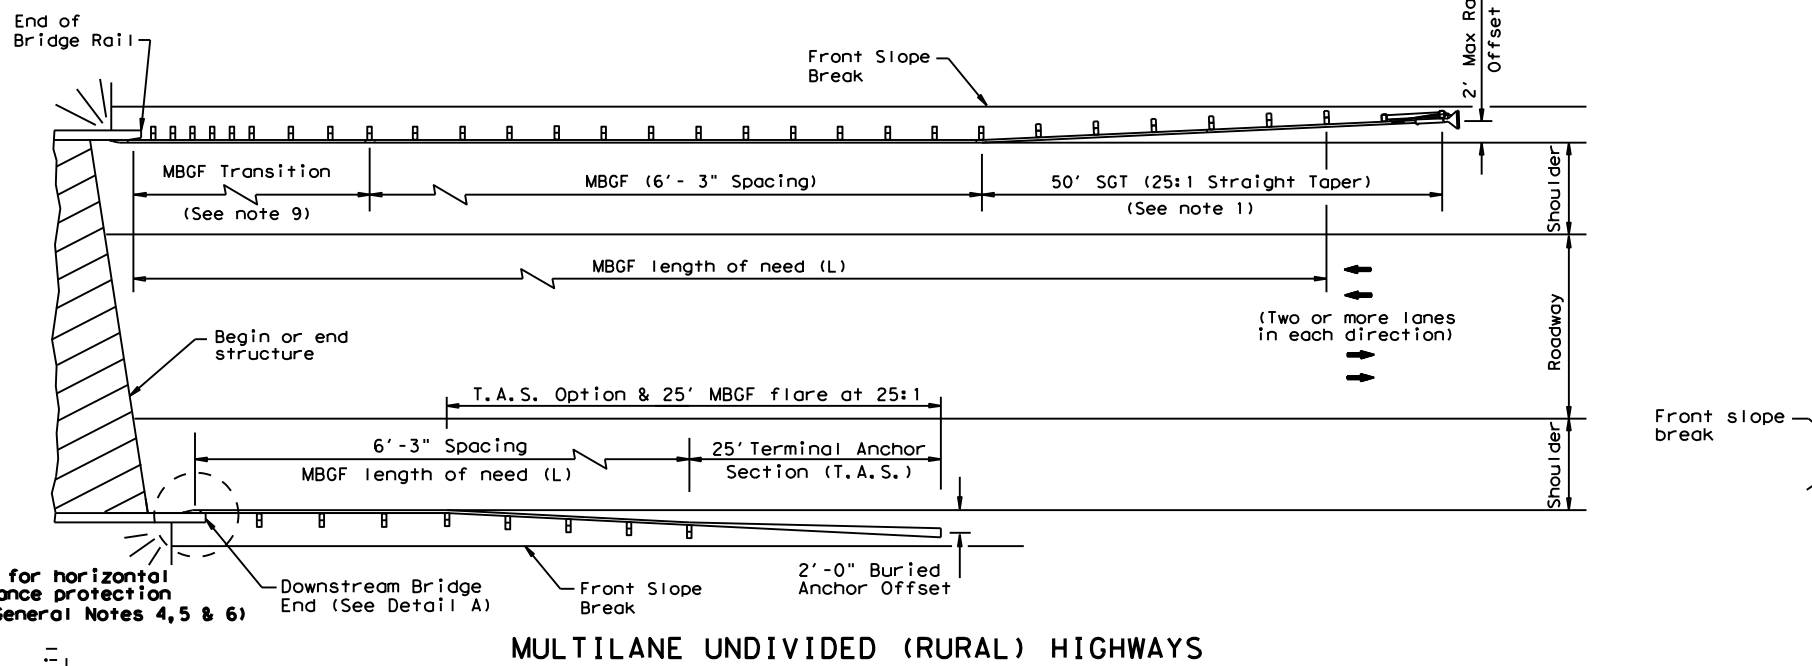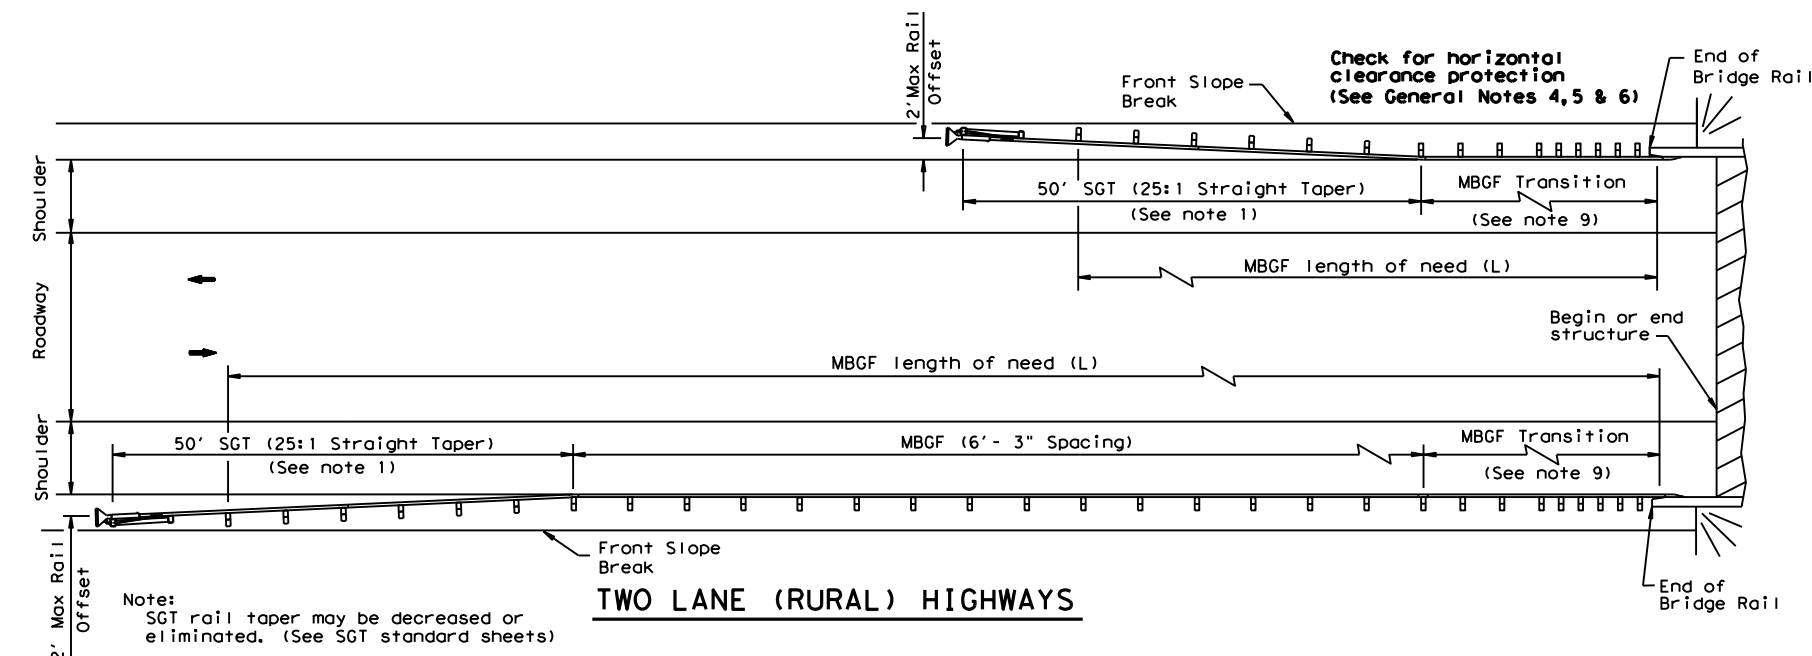

GENERAL NOTES

1. For more detail: See MBGF, SGT, and MBGF Transition standard sheets.
2. Quantities of metal beam guard fence (MBGF) at individual bridge ends are shown elsewhere in plans.
3. Use average daily traffic (ADT) for the current year to determine MBGF length of need in accordance with the Roadway Design Manual unless otherwise specified. Where significant traffic volume growth is anticipated on low volume (0-750 ADT) highways, use length determinations for the higher volume category.
4. MBGF may not be required to shield departure end of bridge unless other obstacles within the horizontal clearance limits or opposing traffic indicate a MBGF consideration.
5. Terminal anchor sections (TAS) are only for downstream end anchorage use, outside the horizontal clearance area of opposing traffic.
6. Direct connection of MBGF (at 6'-3" post spacing without transition) to concrete rail are only for downstream rail connections outside the horizontal clearance area of opposing traffic. (See Detail A)
7. The crown shall be widened to accommodate MBGF. Typically the "front slope" break should be 2'-0" from the back of the MBGF post. This applies to new construction on new alignment or where existing roadway cross section is to be widened to increase roadway width. This does not apply to rehabilitation work where existing roadway crown width is to be retained (See Typical Cross Section at MBGF).
8. For restrictive bridge widths: The MBGF should be properly transitioned from the existing bridge rail to the adjoining MBGF (See MBGF Transition Standards). Metal beam guard fence at these bridge location(s) shall be flared at the rate of 25:1 or flatter, and be of the length necessary to locate the terminal end at the 2 ft. "maximum" offset from the shoulder edge.
9. Transition length and post spacing will vary depending on the transition type. Transition type will be shown elsewhere in the plans.

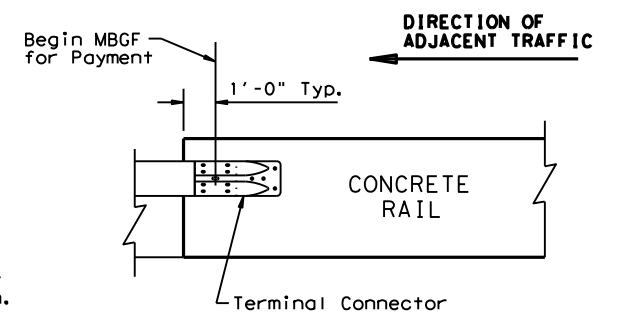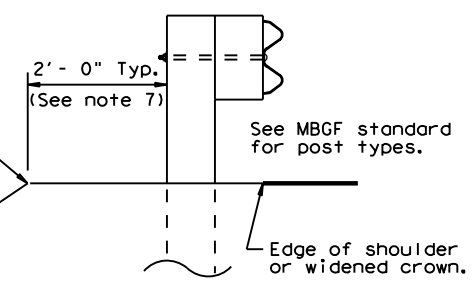

All rail elements shall be lapped in the direction of adjacent traffic.

ONLY FOR USE IN MAINTENANCE REPAIRS.

		Design Division Standard	
BRIDGE END DETAILS (28" METAL BEAM GUARD FENCE APPLICATIONS TO RIGID RAILS) BED(28) - 19			
FILE: bed2819.dgn	DN: TXDOT	CK: KM	DW: BD
© TXDOT NOVEMBER 2019	CONT: 2311	SECT: 01	JOB: 044
REVISIONS	DIST: WAC	COUNTY: MCLENNAN	HIGHWAY: FM 3051
			SHEET NO. 52

DISCLAIMER: The use of this standard is governed by the "Texas Engineering Practice Act". No warranty of any kind is made by TxDOT for any purpose whatsoever. TxDOT assumes no responsibility for the conversion of units of measurement. The use of this standard is governed by the "Texas Engineering Practice Act". No warranty of any kind is made by TxDOT for any purpose whatsoever. TxDOT assumes no responsibility for the conversion of units of measurement.

REFLECTOR UNIT SIZES FOR DELINEATORS AND OBJECT MARKERS

Table with 4 columns: SIZE 1, SIZE 2, SIZE 3, SIZE 4. Includes dimensions for reflector units and a note about sheeting and application (flexible post vs wing channel).

DELINEATORS

Table with 4 columns: SINGLE (Size 2, Size 1) and DOUBLE (Size 2, Size 1). Includes diagrams of reflector units and a table for SHEETING, POST TYPE, and MOUNT TYPE.

D & OM DESCRIPTIVE CODES

Code structure for Delineator and Object Marker assemblies. Includes fields for INSTL DEL ASSM, NUMBER OF REFLECTORS, COLOR OF REFLECTORS, REFLECTOR UNIT SIZE, TYPE OF POST OR DELINEATOR, TYPE OF MOUNT, and DIRECTION.

OBJECT MARKERS

Table for Object Markers with 4 main types (OM-1 to OM-4). Includes diagrams for diamond, rectangular, and chevron markers and their specifications.

Table for Object Marker descriptive codes. Includes fields for INSTL OM ASSM, TYPE OF OBJECT MARKER, NUMBER OF REFLECTORS OR DIRECTION, TYPE OF POST, TYPE OF MOUNT, and DIRECTION. Also includes a DEPARTMENTAL MATERIAL SPECIFICATIONS table.

BARRIER REFLECTORS (BRF)

Table for Barrier Reflectors showing GF1, GF2, and CTB types with diagrams and a note about requirements and reflective sheeting.

CHEVRONS

Table for Chevrons showing W1-8 signs with diagrams and a note about installation and mounting height.

ONE DIRECTION LARGE ARROW

Table for One Direction Large Arrow showing W1-6 signs with diagram and a note about installation and mounting height.

NOTE: Delineator and object marker substrates and sign substrates shall be 0.080" Aluminum sign blank to conform to ASTM B-209 Alloy 6061-T6 or approved alternative.



DELINEATOR & OBJECT MARKER MATERIAL DESCRIPTION D & OM(1)-20

Revision table with columns for FILE, DWT, CKT, DWT, CKT, REVISIONS, CONT, SECT, JOB, HIGHWAY, DIST, COUNTY, SHEET NO.

DISCLAIMER: The use of this standard is governed by the "Texas Engineering Practice Act". No warranty of any kind is made by TxDOT for any purpose whatsoever. TxDOT assumes no responsibility for the conversion of units or the accuracy of any information derived from its use.

DATE: 10/5/2022 11:59:30 AM
 FILE: \\txdot.projectwiseonline.com:TXDOT3\Documents\09 - WAC\Design Projects\0904\090401\09040101\0904010101\0904010101.dgn

POST TYPE AND SUPPORT FOUNDATION DETAILS				TYPE OF BARRIER MOUNTS	
WING CHANNEL (WC)	FLEXIBLE POSTS (YFLX, WFLX)		WEDGE ANCHOR SYSTEMS		GUARD FENCE ATTACHMENT
GND	GND	SRF	WAS	WAP	GF 1
	EMBEDDED		SURFACE MOUNT	STEEL	PLASTIC
NOTES 1. Embedded Wing Channel (WC) post option may be used for Type 2 Object Markers and Delineators only. 2. 1.12 lbs/ft steel per ASTM A 1011 SS Gr. 50, or ASTM A499.	NOTES 1. See "Flexible Delineator and Object Marker Posts" Material Producer List for approved devices. 2. Install per manufacturer's recommendations. 3. Post length may vary to meet field conditions. 4. When using yellow delineators with flexible posts to separate opposing direction of travel, such as centerline or median use, the flexible posts shall be yellow.		NOTE 1. Install per manufacturer's recommendations.		CONCRETE TRAFFIC BARRIER (CTB)
TYPES 1,3, AND 4 OBJECT MARKERS AND CHEVRONS 	CHEVRONS AND ONE DIRECTION LARGE ARROW SIGN 	DELINEATORS AND TYPE 2 OBJECT MARKERS 		GENERAL NOTES 1. Place delineators on a section of roadway at a consistent distance from the edge of pavement. 2. Where a restriction prevents consistent placement from the pavement edge, place the affected object markers in line with the innermost edge of the obstruction. 3. When Type 2 object markers and delineators are more than 8'-0" from the edge of the pavement, it may not be possible to maintain a height of approximately 4'-0". If this is the case, place the object marker or delineator as close to the desired height as possible. 4. Install all delineators, object markers and barrier reflectors in accordance with the manufacturer's recommendation. 5. Barrier reflectors should be installed a minimum of 18 inches above the edge of the pavement surface. 6. Diagonal stripes on Type 3 object markers shall slope down toward the intended travel lane.	
NOTE Mounting at 4 feet to the bottom of the chevron is permitted for chevrons that will not exceed a height of 6'-6" to the top of the chevron (sizes 24" x 30" and smaller)	NOTE Chevrons 30" x 36" and larger shall be mounted at a height of 7' to the bottom of the chevron. Chevron sign and ONE DIRECTION LARGE ARROW sign (W1-9T) shall be installed per SMD standard sheets and paid under item 644.	See general notes 1, 2 and 3.			
DELINEATOR & OBJECT MARKER INSTALLATION D & OM(2)-20					
FILE: dom2-20.dgn © TxDOT August 2004 REVISIONS 10-09 3-15 4-10 7-20		DNE: TXDOT CONT: 2311 SECT: 01 DIST: WAC		CK: TXDOT JOB: 044 COUNTY: MCLENNAN SHEET NO.: 54	


DISCLAIMER: The use of this standard is governed by the "Texas Engineering Practice Act". No warranty of any kind is made by TxDOT for any purpose whatsoever. TxDOT assumes no responsibility for the conversion of units of measurements, or for the accuracy of the information presented herein. The user shall be responsible for the accuracy of the information presented herein.

DATE: 10/5/2022 11:59:34 AM
 FILE: \\txdot.com\projectwise\online.com\TXDOT3\Documents\09 - WAC\Design\Projects\09-09-09\09-09-09.dgn

MINIMUM WARNING DEVICES AT CURVES WITH ADVISORY SPEEDS


Amount by which Advisory Speed is less than Posted Speed	Curve Advisory Speed	
	Turn (30 MPH or less)	Curve (35 MPH or more)
5 MPH & 10 MPH	<ul style="list-style-type: none"> RPMs 	<ul style="list-style-type: none"> RPMs
15 MPH & 20 MPH	<ul style="list-style-type: none"> RPMs and One Direction Large Arrow sign 	<ul style="list-style-type: none"> RPMs and Chevrons; or RPMs and One Direction Large Arrow sign where geometric conditions or roadside obstacles prevent the installation of chevrons.
25 MPH & more	<ul style="list-style-type: none"> RPMs and Chevrons; or RPMs and One Direction Large Arrow sign where geometric conditions or roadside obstacles prevent the installation of chevrons 	<ul style="list-style-type: none"> RPMs and Chevrons

SUGGESTED SPACING FOR DELINEATORS ON HORIZONTAL CURVES

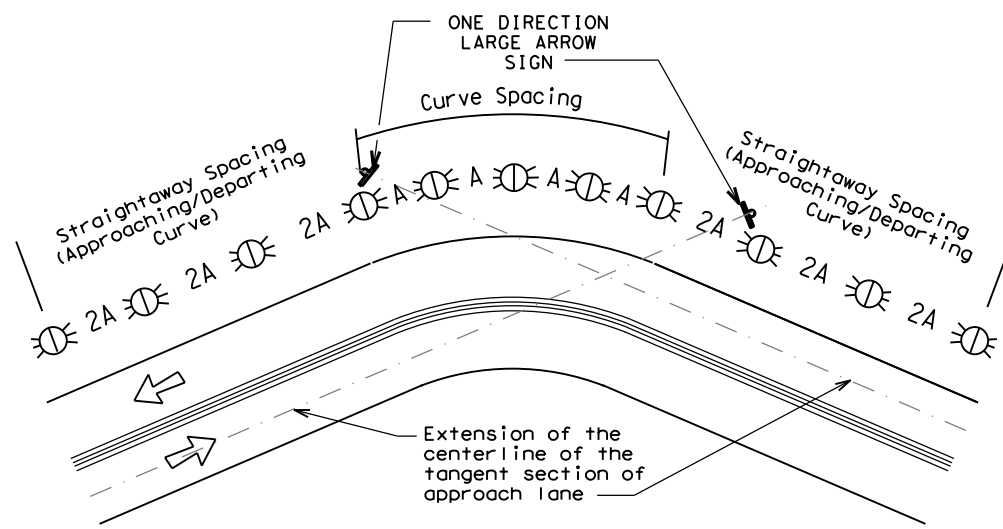

NOTE
 ONE DIRECTION LARGE ARROW (W1-6) sign should be located at approximately and perpendicular to the extension of the centerline of the tangent section of approach lane.

SUGGESTED SPACING FOR CHEVRONS ON HORIZONTAL CURVES

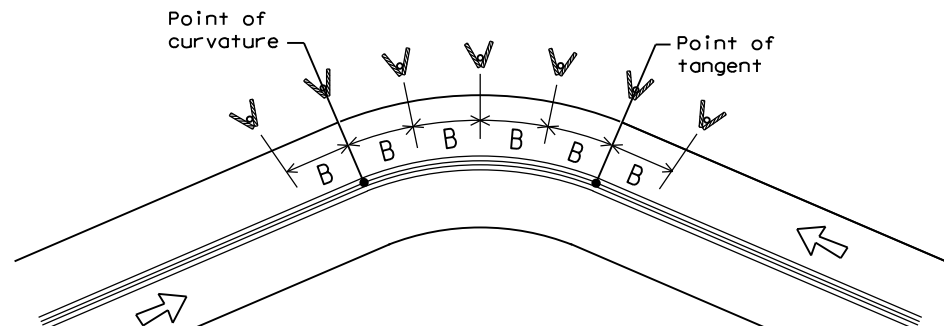

NOTE
 At least one chevron pair is installed beyond the point of tangent in tangent section.

DELINEATOR AND CHEVRON SPACING

WHEN DEGREE OF CURVE OR RADIUS IS KNOWN				
Degree of Curve	FEET			
	Radius of Curve	Spacing in Curve	Spacing in Straightway	Chevron Spacing in Curve
		A	2A	B
1	5730	225	450	—
2	2865	160	320	—
3	1910	130	260	200
4	1433	110	220	160
5	1146	100	200	160
6	955	90	180	160
7	819	85	170	160
8	716	75	150	160
9	637	75	150	120
10	573	70	140	120
11	521	65	130	120
12	478	60	120	120
13	441	60	120	120
14	409	55	110	80
15	382	55	110	80
16	358	55	110	80
19	302	50	100	80
23	249	40	80	80
29	198	35	70	40
38	151	30	60	40
57	101	20	40	40

Curve delineator approach and departure spacing should include 3 delineators spaced at 2A. This spacing should be used during design preparation or when the degree of curve is known.

DELINEATOR AND CHEVRON SPACING

WHEN DEGREE OF CURVE OR RADIUS IS NOT KNOWN			
Advisory Speed (MPH)	Spacing in Curve	Spacing in Straightway	Chevron Spacing in Curve
	A	2xA	B
65	130	260	200
60	110	220	160
55	100	200	160
50	85	170	160
45	75	150	120
40	70	140	120
35	60	120	120
30	55	110	80
25	50	100	80
20	40	80	80
15	35	70	40

If the degree of curve is not known, delineator spacing may be determined based on the Advisory Speed of the curve. Use the delineator curve spacing for each Advisory Speed (MPH).

DELINEATOR AND OBJECT MARKER APPLICATION AND SPACING

CONDITION	REQUIRED TREATMENT	MINIMUM SPACING
Frwy./Exp. Tangent	RPMs	See PM-series and FPM-series standard sheets
Frwy./Exp. Curve	Single delineators on right side	See delineator spacing table
Frwy./Exp. Ramp	Single delineators on at least one side of ramp (should be on outside of curves) (see Detail 3 on D&OM(4))	100 feet on ramp tangents Use delineator spacing table for ramp curves ("straightway spacing" does not apply to ramp curves)
Acceleration/Deceleration Lane	Double delineators (see Detail 3 on D&OM(4))	100 feet (See Detail 3 on D & OM (4))
Truck Escape Ramp	Single red delineators on both sides	50 feet
Bridge Rail (steel or concrete) and Metal Beam Guard Fence	Bi-Directional Delineators when undivided with one lane each direction Single Delineators when multiple lanes each direction	Equal spacing (100' max) but not less than 3 delineators
Concrete Traffic Barrier (CTB) or Steel Traffic Barrier	Barrier reflectors matching the color of the edge line	Equal spacing 100' max
Cable Barrier	Reflectors matching the color of the edge line	Every 5th cable barrier post (up to 100' max)
Guard Rail Terminus/Impact Head	Divided highway - Object marker on approach end Undivided 2-lane highways - Object marker on approach and departure end	Requires reflective sheeting provided by manufacturer per D & OM (VIA) or a Type 3 Object Marker (OM-3) in front of the terminal end See D & OM (5) and D & OM (6)
Bridges with no Approach Rail	Type 3 Object Marker (OM-3) at end of rail and 3 single delineators approaching rail	See D & OM(5)
Reduced Width Approaches to Bridge Rail	Type 2 and Type 3 Object Markers (OM-3) and 3 single delineators approaching bridge	Requires reflective sheeting provided by manufacturer per D & OM (VIA) or a Type 3 Object Marker (OM-3) in front of the terminal end See D & OM (5)
Culverts without MBGF	Type 2 Object Markers	See Detail 2 on D & OM(4)
Crossovers	Double yellow delineators and RPMs	See Detail 1 on D & OM (4)
Pavement Narrowing (lane merge) on Freeways/Expressway	Single delineators adjacent to affected lane for full length of transition	100 feet

NOTES

- Unless indicated otherwise, the delineator or barrier reflector color shall conform to the color of the pavement edge line on the side of the road where the delineators or barrier reflectors are placed.
- Barrier reflectors may be used to replace required delineators.
- Single red delineators may be mounted on the back side of delineator posts for wrong way driver applications

LEGEND	
	Bi-directional Delineator
	Delineator
	Sign


DELINEATOR & OBJECT MARKER PLACEMENT DETAILS

D & OM(3) - 20

FILE:	dom3-20.dgn	DN:	TXDOT	CK:	TXDOT	DW:	TXDOT	CR:	TXDOT
© TXDOT August 2004		CONT	SECT	JOB	HIGHWAY				
REVISIONS		2311	01	044	FM 3051				
3-15	8-15	DIST	COUNTY		SHEET NO.				
8-15	7-20	WAC	MCLENNAN		55				


DATE: 10/5/2022 11:59:37 AM
 FILE: \\txdot.projectwiseonline.com:TXDOT13\Documents\09 - WAC\Design Projects\0441\0441.dgn
 DISCLAIMER: The use of this standard is governed by the "Texas Engineering Practice Act". No warranty of any kind is made by TxDOT for any purpose whatsoever. TxDOT assumes no responsibility for the conversion of this standard to any other format or for its use.

CROSSOVERS

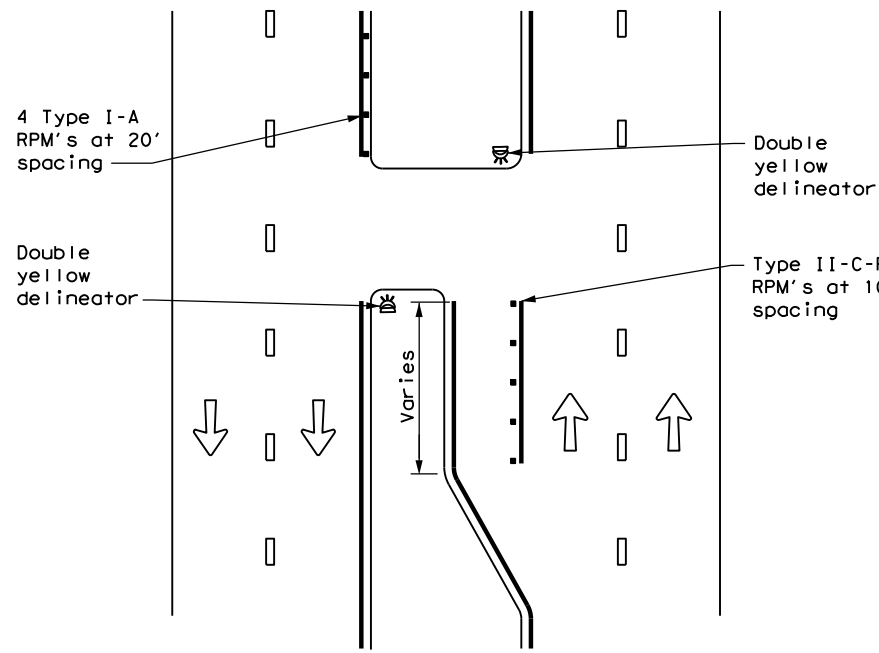


DETAIL 1

FOR CULVERTS WITHOUT MBGF

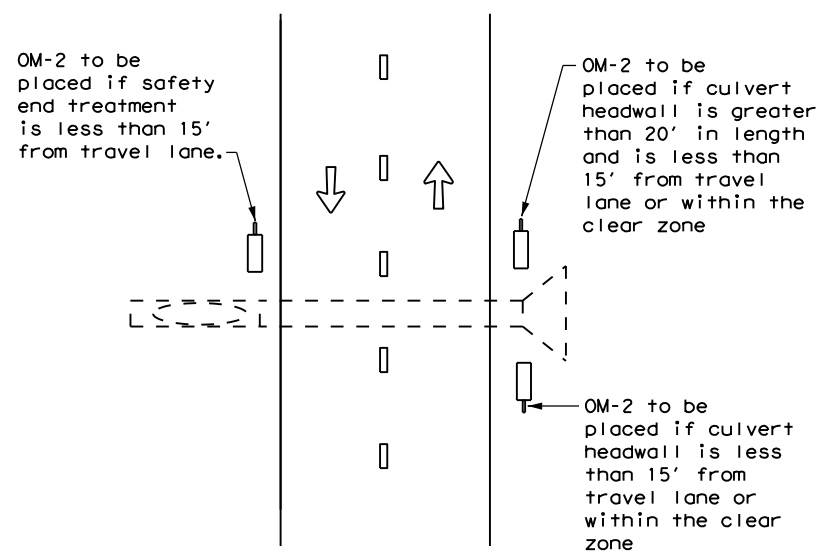


DETAIL 2

FREEWAY DELINEATION FOR RAMPS AND ACCELERATION/DECELERATION LANES

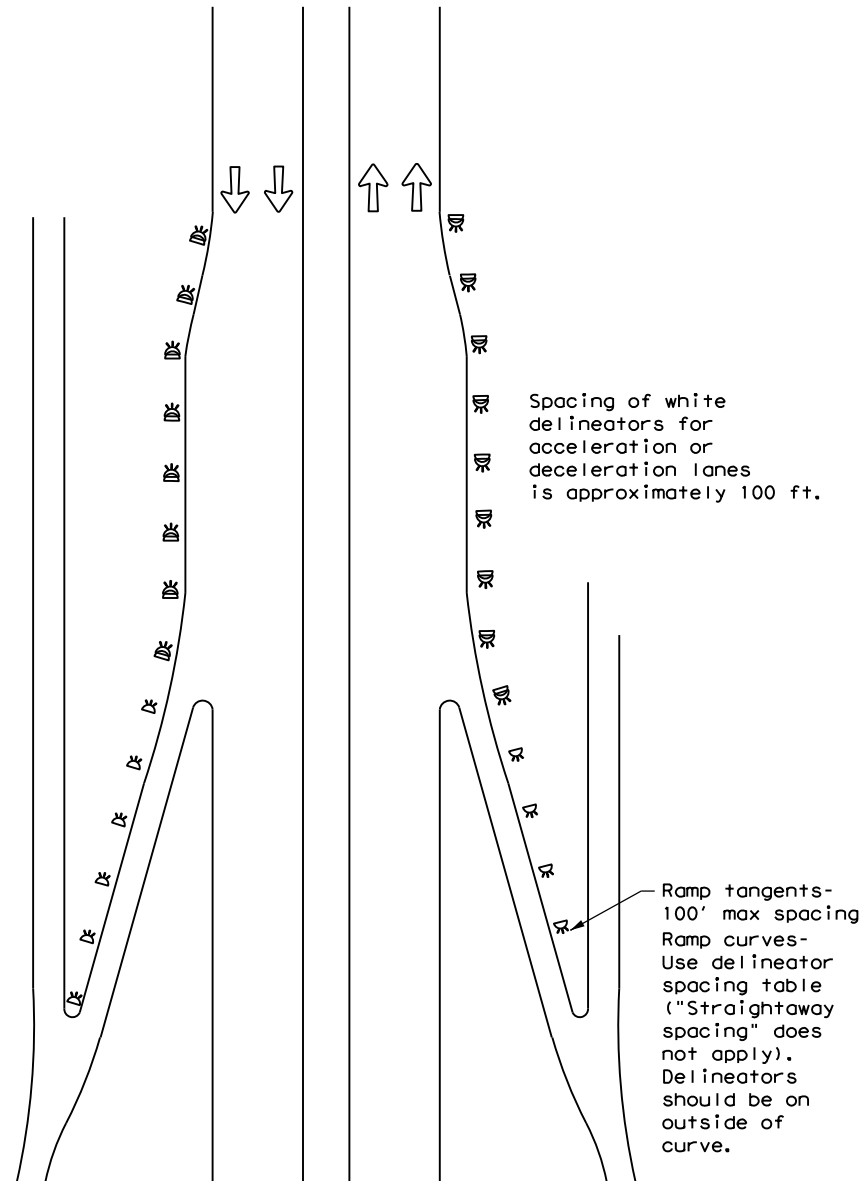


DETAIL 3

TYPICAL APPLICATION OF DEAD END BARRICADE

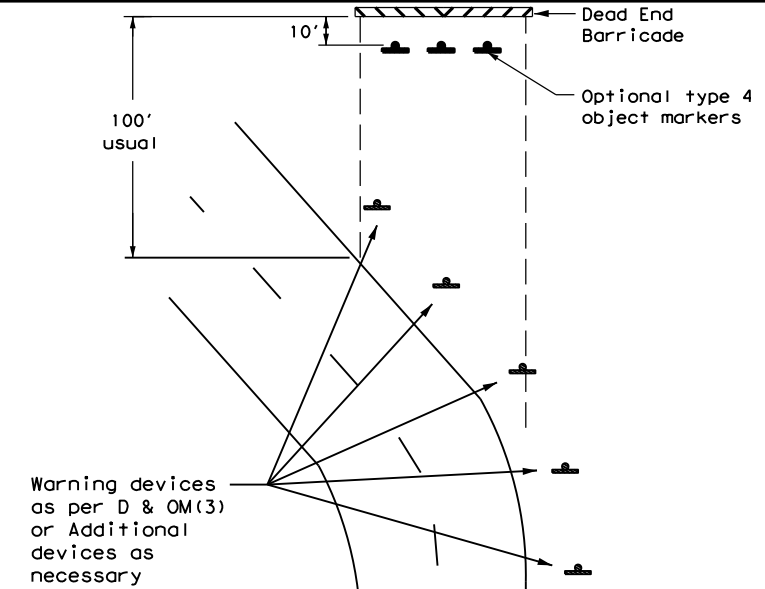

DETAIL 4

TYPICAL DEAD END BARRICADE INSTALLATION

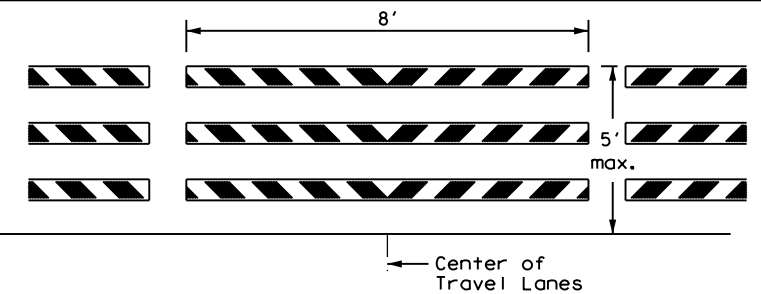

NOTES

- Barricade striping shall be red and white reflective sheeting for all permanent road closures.
- Barricade striping is red and white sloping toward the center of the roadway.
- Type 3 Barricade Supports should be anchored to soil or pavement as described in compliant Work Zone Traffic Control Devices List, section D.2.f and D.2.g.

DETAIL 5

LEGEND	
	Bidirectional Delineator
	Delineator
	OM-3
	Barricade
	Sign
	OM-2
	Double Delineator




DELINEATOR & OBJECT MARKER PLACEMENT DETAILS

D & OM(4) - 20

FILE: dom4-20.dgn	DN: TXDOT	CK: TXDOT	DW: TXDOT	CR: TXDOT
© TXDOT August 2004	CONT	SECT	JOB	HIGHWAY
REVISIONS	2311	01	044	FM 3051
3-15	DIST	COUNTY		SHEET NO.
7-20	WAC	MCLENNAN		56


**TWO-WAY, TWO LANE ROADWAY
WITH REDUCED WIDTH APPROACH RAIL**

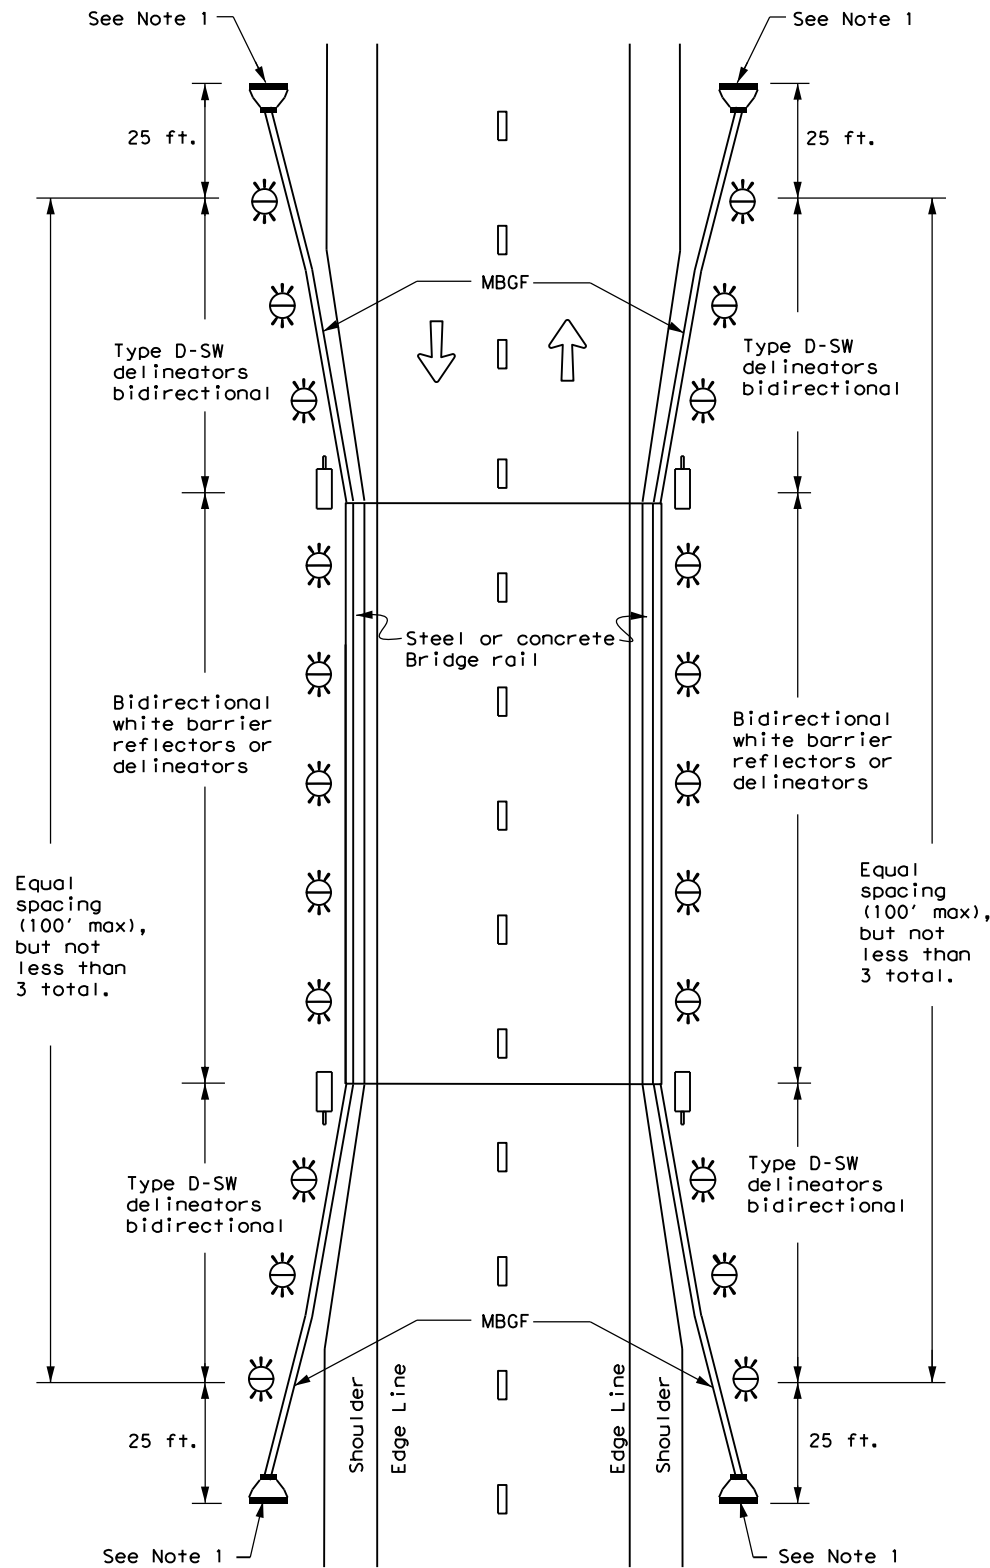

NOTE:

1. Terminal ends require reflective sheeting provided by manufacturer per D & OM (VIA) or a Type 3 Object Marker (OM-3) in front of the terminal end.


**TWO-WAY, TWO LANE ROADWAY
WITH METAL BEAM GUARD FENCE (MBGF)**

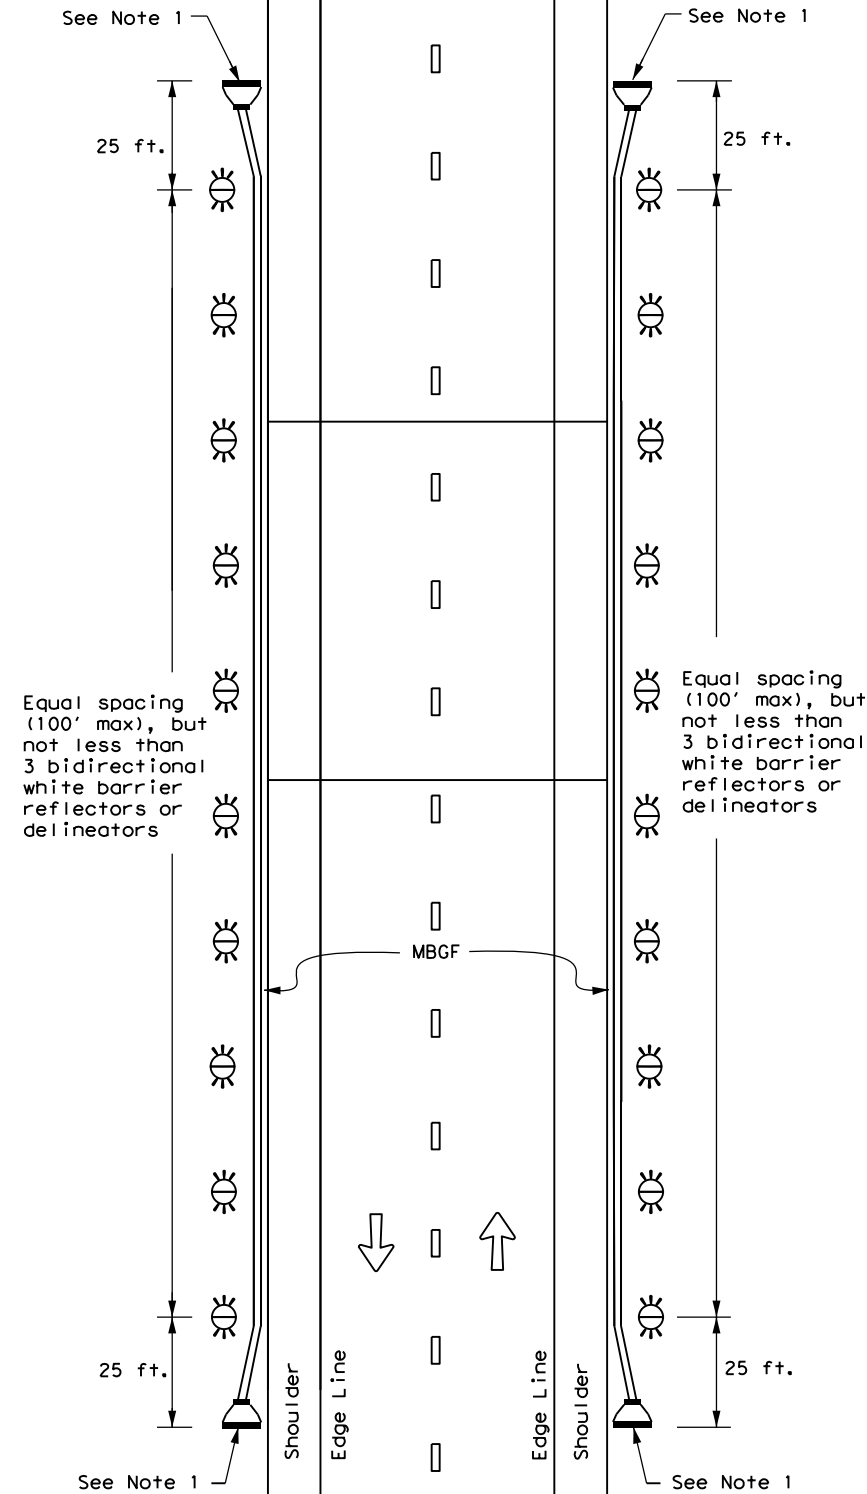

NOTE:

1. Terminal ends require reflective sheeting provided by manufacturer per D & OM (VIA) or a Type 3 Object Marker (OM-3) in front of the terminal end.

**TWO-WAY, TWO LANE ROADWAY
BRIDGE WITH NO APPROACH RAIL**

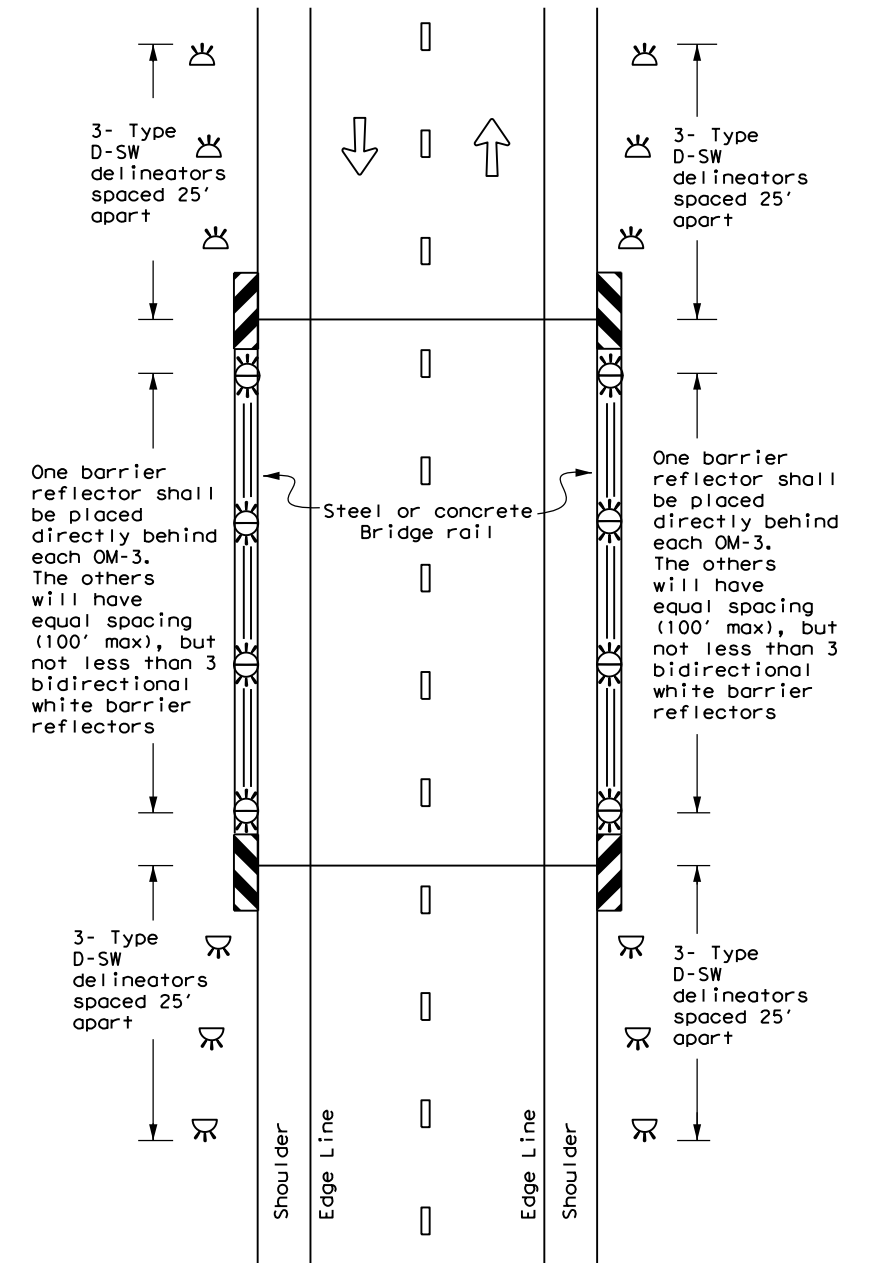

LEGEND

	Bidirectional Delineator
	Delineator
	OM-3
	OM-2
	Terminal End
	Traffic Flow



**DELINEATOR &
OBJECT MARKER
PLACEMENT DETAILS**

D & OM(5) - 20

FILE: dom5-20.dgn	DN: TxDOT	CK: TxDOT	DW: TxDOT	CR: TxDOT
© TxDOT August 2015	CONT	SECT	JOB	HIGHWAY
REVISIONS	2311	01	044	FM 3051
7-20	DIST	COUNTY	SHEET NO.	
	WAC	MCLENNAN	57	


DISCLAIMER: The use of this standard is governed by the "Texas Engineering Practice Act". No warranty of any kind is made by TxDOT for any purpose whatsoever. TxDOT assumes no responsibility for the conversion of this standard to any other format or for any errors or omissions that may appear hereon.

DATE: 10/5/2022 11:59:40 AM
 FILE: \\txdot\projectwiseonline.com\TXDOT13\Documents\09 - WAC\Design Projects\044\044.ctb


DISCLAIMER: The use of this standard is governed by the "Texas Engineering Practice Act". No warranty of any kind is made by TxDOT for any purpose whatsoever. TxDOT assumes no responsibility for the conversion of units or the accuracy of the information presented herein.

DATE: 10/5/2022 11:59:43 AM
 FILE: \\txdot.projectwiseonline.com:TXDOT3\Documents\09 - WAC\Design Projects\0444\0444.ctb


CONTINUOUS CONCRETE OR STEEL BARRIER

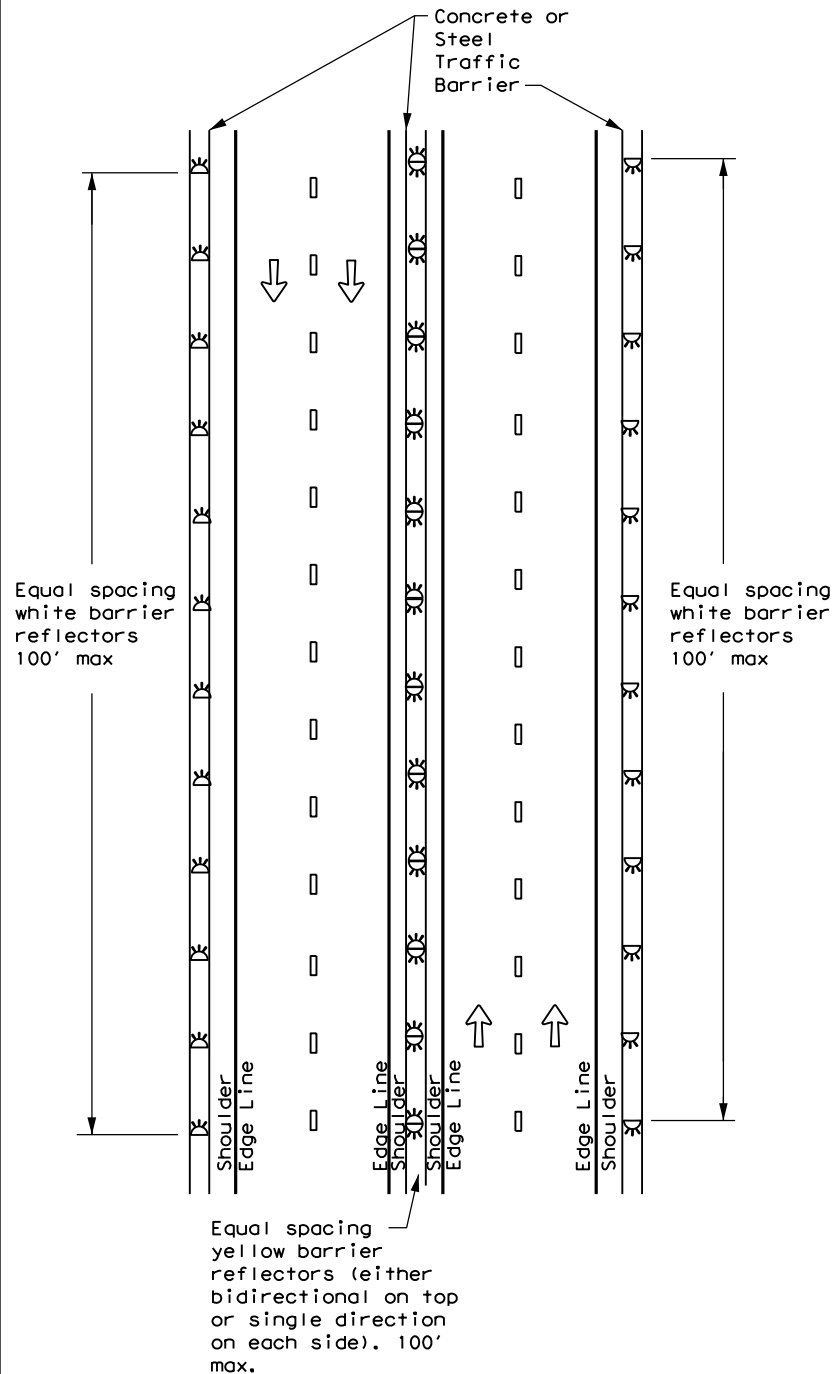


MULTI-LANE UNDIVIDED, TWO-WAY ROADWAY WITH METAL BEAM GUARD FENCE (MBGF)

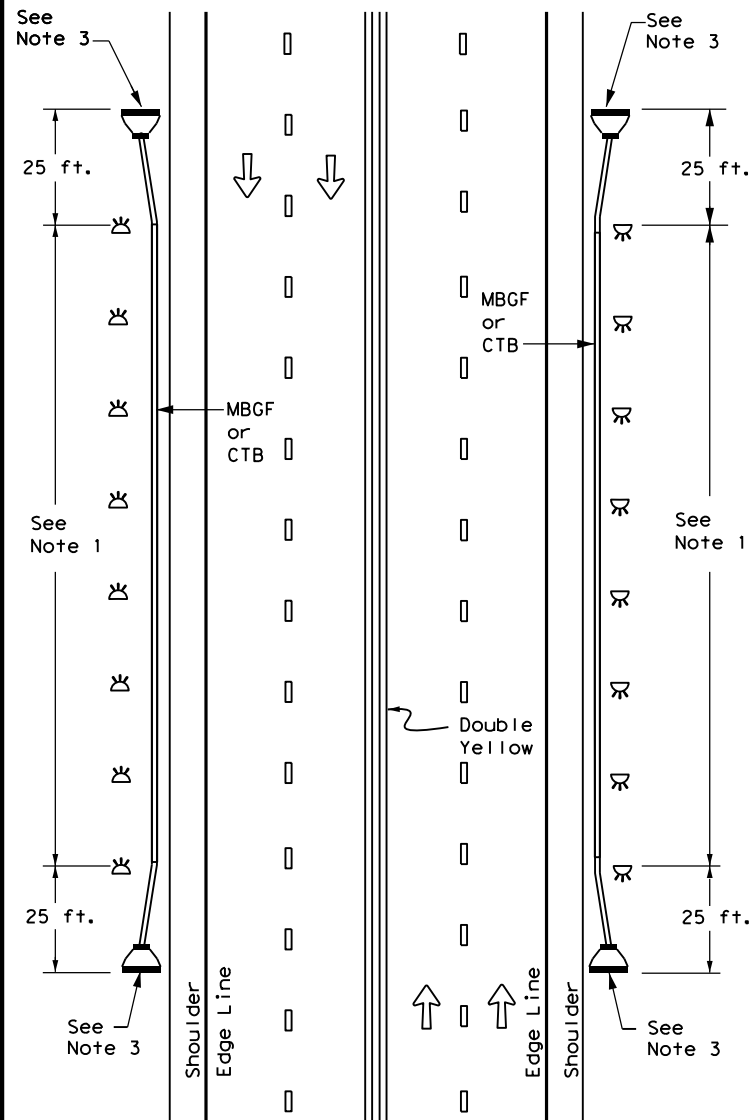

DIVIDED ROADWAY WITH METAL BEAM GUARD FENCE (MBGF)

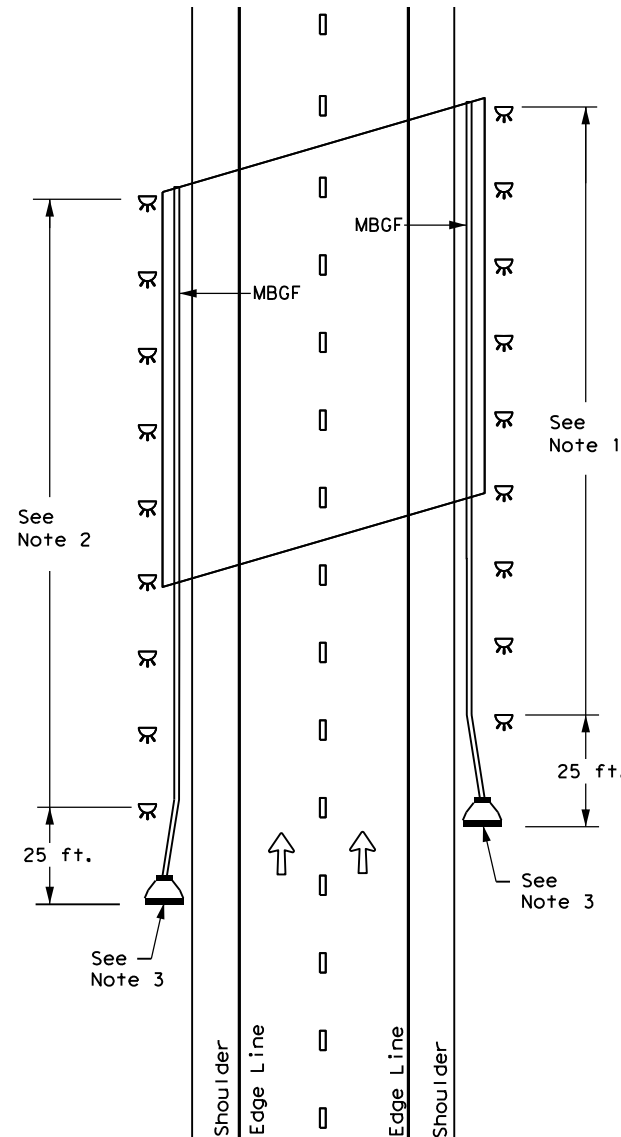

EMERGENCY CROSSOVER

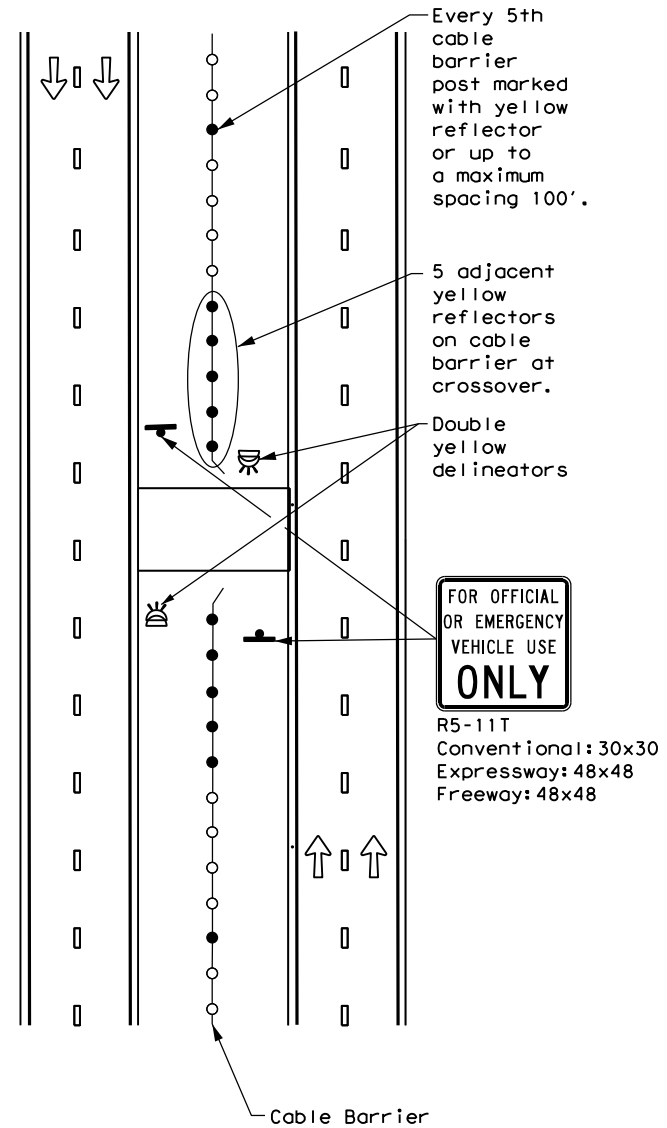

NOTES

1. Equal spacing (100' max), but not less than 3 single directional white barrier reflectors or delineators. On Continuous Barrier, equal spacing (100' max.)
2. Equal spacing (100' max), but not less than 3 single directional yellow barrier reflectors or delineators.
3. Terminal ends require reflective sheeting provided by manufacturer per D & OM (VIA) or a Type 3 Object Marker (OM-3) in front of the terminal end.

LEGEND

	Bidirectional Delineator
	Delineator
	OM-3
	OM-2
	Terminal End
	Traffic Flow










DELINEATOR & OBJECT MARKER PLACEMENT DETAILS

D & OM(6)-20


FILE: dom6-20.dgn	DN: TxDOT	CK: TxDOT	DW: TxDOT	CR: TxDOT
©TxDOT August 2015	CONT	SECT	JOB	HIGHWAY
REVISIONS	2311	01	044	FM 3051
7-20	DIST	COUNTY	SHEET NO.	
	WAC	MCLENNAN	58	

DISCLAIMER: The use of this standard is governed by the "Texas Engineering Practice Act". No warranty of any kind is made by TxDOT for any purpose whatsoever. TxDOT assumes no responsibility for the conversion of units or for the accuracy of any information derived from its use.

DATE: 10/5/2022 11:59:46 AM
 FILE: \\txdot.projectwiseonline.com:TXDOT3\Documents\09 - WAC\Design Projects\0444\444\0444.dgn

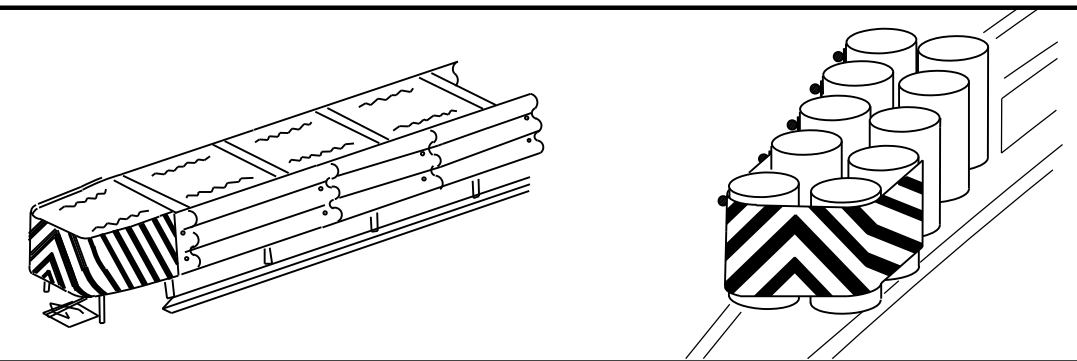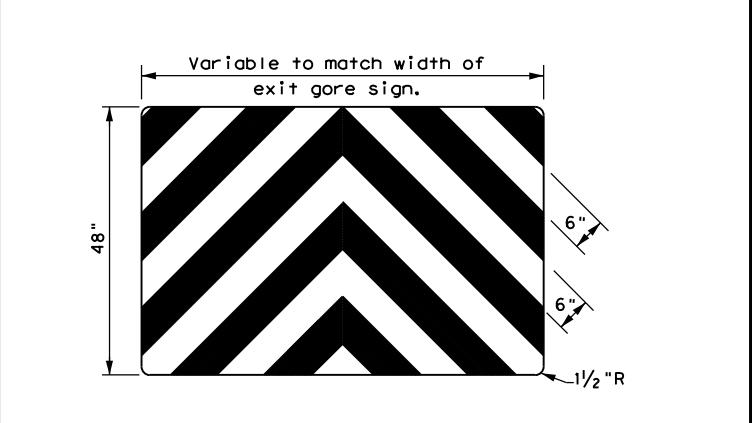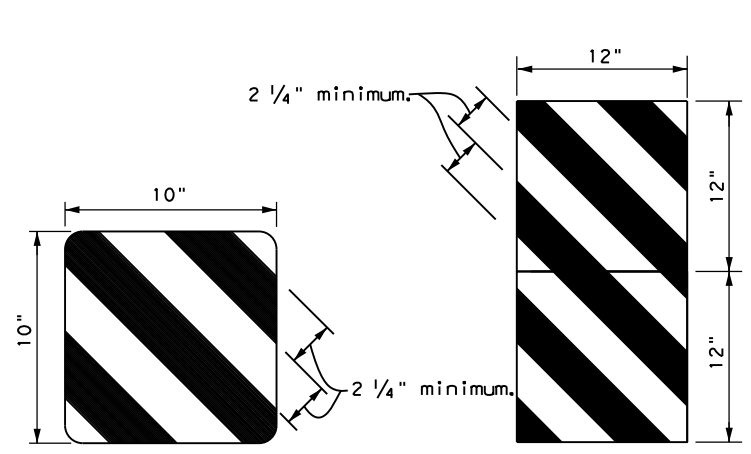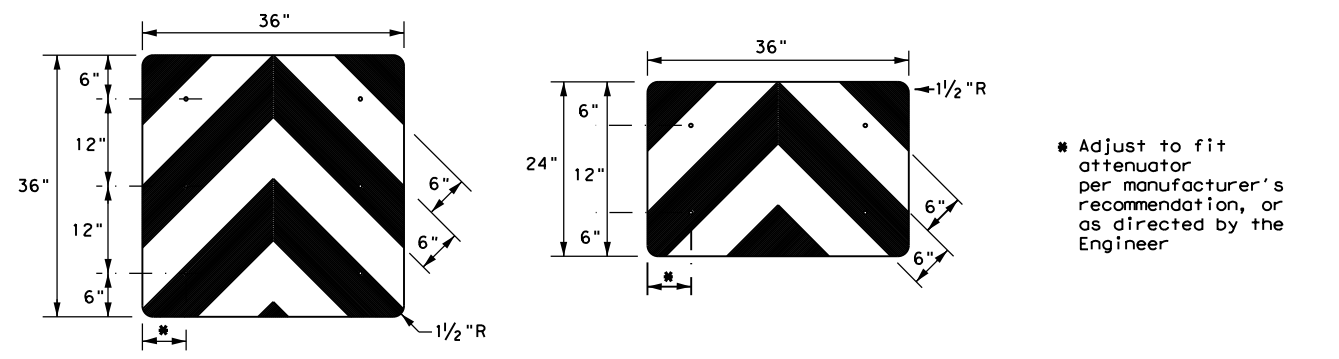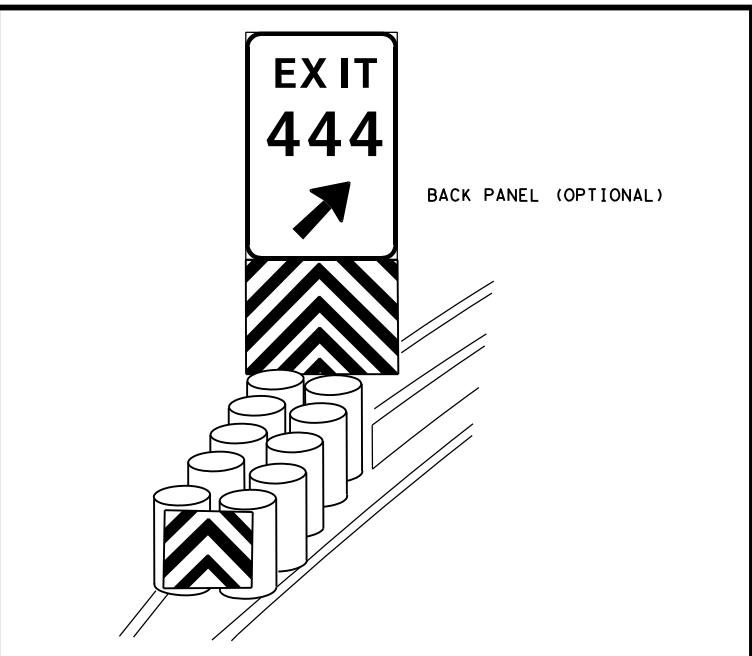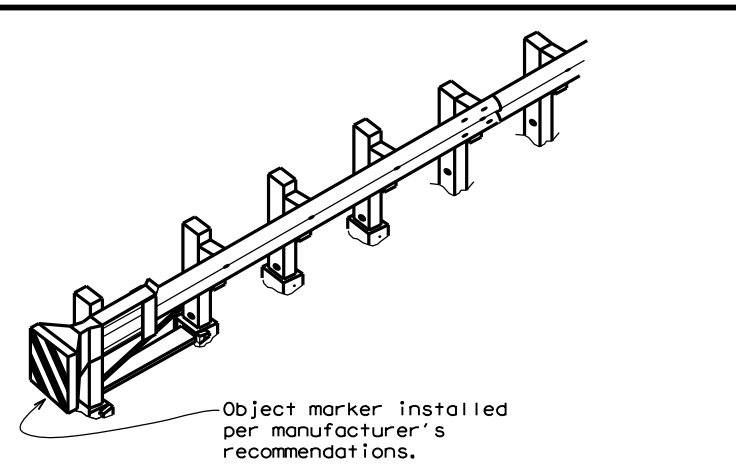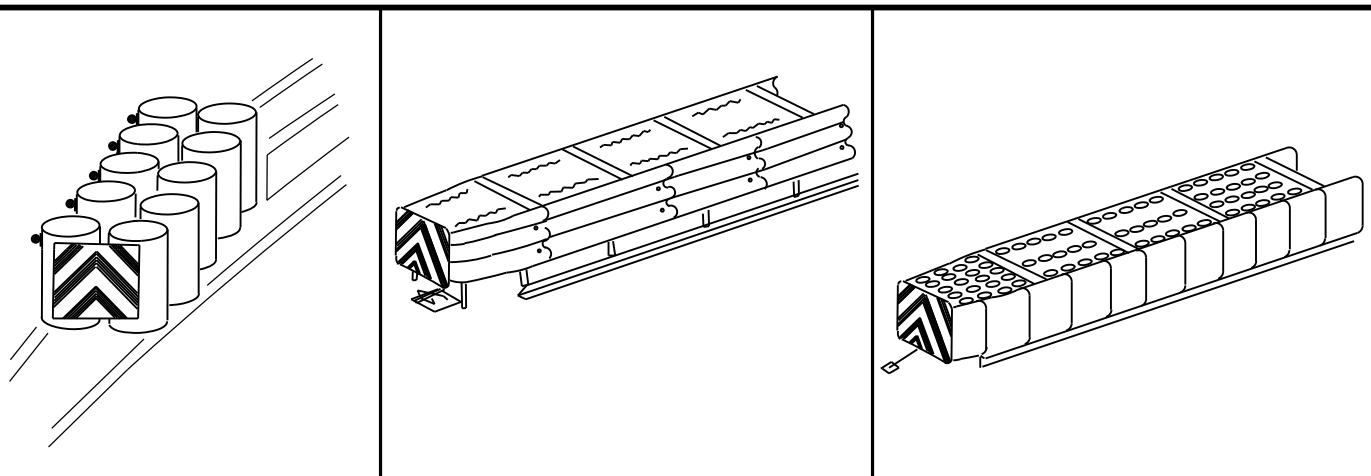

OBJECT MARKERS SMALLER THAN 3 FT²

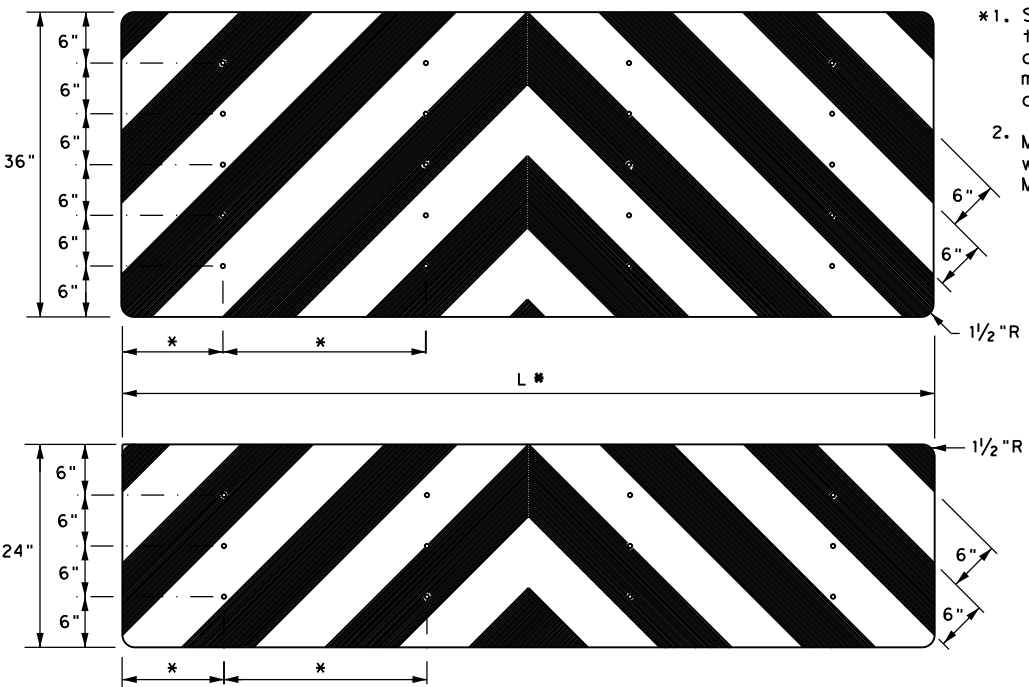

- NOTES**
- Spacing should be adjusted to attach through centerline of drum, per attenuator manufacturer's recommendation, or as directed by the Engineer.
 - Mounting should be flush with top of attenuator. Minimum size 96" x 24".

NOTES

- Object Markers shall conform to the Texas MUTCD and meet the color and reflectivity requirement of Department Material Specification DMS 8300. Background shall be yellow reflective sheeting (Type B or C) and Chevron shall be black.
- Object Markers may be fabricated from adhesive backed reflective sheeting applied directly to guardrail end treatment, or applied directly to an "end cap" as per the manufacturer's recommendation. Direct applied sheeting shall provide a smooth surface and have no wrinkles, air bubbles, cuts or tears. A radius at the corners is not required for direct applied sheeting.
- Object Marker size may be reduced to fit smaller devices. Width of alternating black and yellow stripes are typically 6". Object Markers smaller than 3ft may have reduced width stripes of a minimum of 2 1/4".
- Pop rivets, screws, or nuts and bolts may be used to attach object markers and reflectors. Holes, slots or other openings may be cut or drilled through object markers to allow cable or other attachments.
- Object Marker at nose of attenuator is subsidiary to the attenuator.
- See D & OM (1-4) for required barrier reflectors.

DELINEATOR & OBJECT MARKER FOR VEHICLE IMPACT ATTENUATORS D & OM(VIA) -20			
FILE: domvia20.dgn	DN: TXDOT	CK: TXDOT	OW: TXDOT
© TXDOT December 1989	CONT	SECT	JOB
REVISIONS		2311	01
4-92	8-04	044	FM 3051
8-95	3-15		
4-98	7-20		
DIST	COUNTY	SHEET NO.	
WAC	MCLENNAN	59	
20G			

SITE DESCRIPTION

PROJECT LIMITS:

CSJ 2311-01-044: From 0.15 MI East of Carson Ln to the Brazos River

LOCATION MAPS:

Refer to the TITLE SHEET for project location map

PROJECT DESCRIPTION:

CSJ 2311-01-044 :

FOR THE CONSTRUCTION OF SAFETY CONSISTING OF INSTALLING CABLE MEDIAN BARRIER.

MAJOR SOIL DISTURBING ACTIVITIES:

No major soil disturbing activities on this project.

TOTAL PROJECT AREA:

> 20 AC

TOTAL AREA TO BE DISTURBED:

2.01 AC

EXISTING CONDITION OF SOIL & VEGETATIVE COVER AND % OF EXISTING VEGETATIVE COVER:

CSJ : 2311-01-044

Predominant soil types are Weswood silt loam and Weswood silt clay loam. Vegetative cover is in good condition with 90-95% coverage.

NAME OF RECEIVING WATERS:

CSJ 2311-01-044 : This project runs into the Brazos River within segment 1256 which ultimately drains into the Gulf of Mexico

EROSION AND SEDIMENT CONTROLS

SOIL STABILIZATION PRACTICES:

<input type="checkbox"/>	TEMPORARY SEEDING	<input type="checkbox"/>	SOIL RETENTION BLANKET
<input checked="" type="checkbox"/>	PERMANENT PLANTING, SODDING, OR SEEDING	<input checked="" type="checkbox"/>	NATURAL BARRIERS OR BUFFER ZONES
<input type="checkbox"/>	MULCHING	<input checked="" type="checkbox"/>	PRESERVATION OF NATURAL RESOURCES

OTHER: TXR 150000, Part III, Section G, 2 Stabilization of disturbed areas must, at a minimum, be initiated immediately whenever any clearing, grading, excavating, or other earth disturbing activities have permanently ceased on any portion of the site, or temporarily ceased on any portion of the site and will not resume for a period exceeding 14 calendar days. Temporary stabilization must be completed no more than 14 calendar days after initiation of soil stabilization measures, and final stabilization must be achieved prior to termination of permit coverage.

STRUCTURAL PRACTICES: (Select T = Temporary or P = Permanent, As Applicable)

<input type="checkbox"/>	SILT FENCES	<input type="checkbox"/>	TIMBER MATTING AT CONSTRUCTION EXIT
<input type="checkbox"/>	HAY BALES	<input type="checkbox"/>	CHANNEL LINERS
<input type="checkbox"/>	SANDBAG OR ROCK BERMS	<input type="checkbox"/>	SEDIMENT TRAPS
<input type="checkbox"/>	DIVERSION, INTERCEPTOR, OR PERIMETER DIKES	<input type="checkbox"/>	SEDIMENT BASINS
<input type="checkbox"/>	DIVERSION, INTERCEPTOR, OR PERIMETER SWALES	<input type="checkbox"/>	STORM INLET SEDIMENT TRAP
<input type="checkbox"/>	DIVERSION DIKE AND SWALE COMBINATIONS	<input type="checkbox"/>	STONE OUTLET STRUCTURES
<input type="checkbox"/>	PIPE SLOPE DRAINS	<input type="checkbox"/>	CURBS AND GUTTERS
<input type="checkbox"/>	PAVED FLUMES	<input type="checkbox"/>	STORM SEWERS
<input type="checkbox"/>	ROCK BEDDING AT CONSTRUCTION EXIT	<input type="checkbox"/>	VELOCITY CONTROL DEVICES

OTHER:

NARRATIVE-SEQUENCE OF CONSTRUCTION (STORM WATER MANAGEMENT) ACTIVITIES:


The order of activities will be as follows:

1. Preserve existing vegetative cover as much as possible.
2. Install Cable Median Barrier.
3. Install Mowstrip and Roll Sodding.

STORM WATER MANAGEMENT:

An integral part of the SWPPP for this project includes the EPIC Sheet, Item 506, Waco District Waters of the US Notes, Waco District Typical Applications for Best Management Practices, Form 2118 TxDOT inspection forms, Contractor daily inspection forms, miscellaneous general notes on environmental requirements, TxDOT EC Standards, 2014 Standard Specifications, TxDOT roadway design drawings, SWPPP design and working BMP drawings, Site Manager Data Base, EMS Stage Gate Inspections and the Waco District environmental folders. The requirements of the TxDOT EMS will be fully implemented including training requirements for Contractors and TxDOT staff.

STORM WATER POLLUTION PREVENTION PLAN PERMIT POSTING

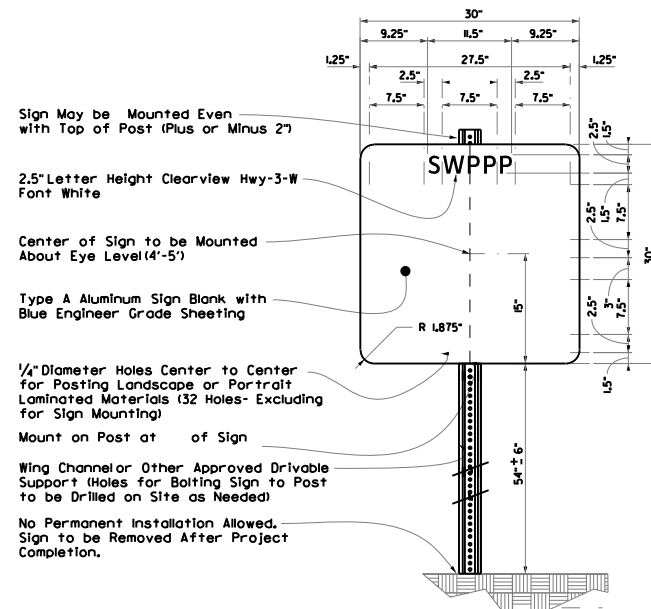

OTHER EROSION AND SEDIMENT CONTROLS:

MAINTENANCE:

All erosion and sediment best management practices (BMPs) will be maintained in good working order per the environmental notes, details and standards included as part of the project plans and contract documents. BMP repairs will be made at the earliest possible date, but no later than seven calendar days after the inspection report has been completed and immediately after the ground has dried sufficiently to allow equipment access. BMPs damaged by the Contractor will be repaired or replaced immediately. The installation and repair of BMPs at creeks and outfalls will be given priority.

INSPECTION:

TxDOT Form 2118 inspections to support TXR150000 and 404 permits will be conducted on a seven day interval on the same day of the week, until permits are terminated. The Contractor will provide daily BMP inspection reports on work days. Stage Gate Inspections and other BMP inspections will be conducted by the District and Area Office Staff based on requirements of the TxDOT Environmental Management System (EMS).

WASTE MATERIALS:

Any waste materials generated during construction will be disposed of in accordance with existing federal, state, and local laws.

HAZARDOUS WASTE (INCLUDING SPILL REPORTING):

At a minimum, any products in the following categories are considered to be hazardous: Fuels, Lubricating products, Asphalt products, or Concrete curing compounds and any additives. In the event of a spill which may be hazardous, clean-up will be done in accordance with federal, state, and local regulations. The Contractor will maintain a list of all chemicals and wastes required for the project, including chemicals used by sub-contractors, and will implement written spill prevention and clean-up plans.

SANITARY WASTE:

Sanitary waste from portable units will be collected by a licensed sanitary waste management contractor.

OFF SITE VEHICLE TRACKING:

<input type="checkbox"/>	HAUL ROADS DAMPENED FOR DUST CONTROL
<input checked="" type="checkbox"/>	LOADED HAUL TRUCKS TO BE COVERED WITH TARPAULIN
<input checked="" type="checkbox"/>	EXCESS DIRT ON ROAD REMOVED DAILY
<input type="checkbox"/>	STABILIZED CONSTRUCTION ENTRANCE

REMARKS:

Disposal areas, stockpiles, and haulroads will be constructed in a manner that will minimize and control the amount of sediment that may enter receiving waters. Disposal areas will not be located in any wetland, waterbody or streambed. Construction staging area and vehicle maintenance area will be constructed by the contractor in a manner to minimize the runoff pollutants.

Furnish one SW3P permit posting sign and sign support as detailed on the SW3P Sheet. Install this sign in a location selected by the Engineer. The sign and support should be removed upon completion of the project and is the property of the Contractor. The purchase of the sign and support, installation, relocations if determined necessary by the Engineer and removal at project end will be subsidiary to Item 506.

SEDIMENTATION BASINS:

Since the area disturbed is less than 10 acres, per outfall location, a sedimentation basin is not required.

BRADLEY MAYES
128276
LICENSED PROFESSIONAL ENGINEER

Bradley Mayes
SIGNATURE OF REGISTRANT & DATE

© 2023
Texas Department of Transportation

**WACO DISTRICT
STORM WATER POLLUTION
PREVENTION PLAN
(SW3P)**

SHEET 1 OF 1

FED. RD. DIV. NO.	STATE	CONT	SECT	JOB	HIGHWAY
6	TEXAS	2311	01	044	FM 3051
		DIST	COUNTY		SHEET NO.
		WAC	MCLENNAN		60

DISCLAIMER: The use of this standard is governed by the "Texas Engineering Practice Act". No warranty of any kind is made by TxDOT for any purpose whatsoever. TxDOT assumes no responsibility for the conversion of this standard to other formats or for incorrect results or damages resulting from its use.

DATE: FILE:

I. STORMWATER POLLUTION PREVENTION-CLEAN WATER ACT SECTION 402

TPDES TXR 150000: Stormwater Discharge Permit or Construction General Permit required for projects with 1 or more acres disturbed soil. Projects with any disturbed soil must protect for erosion and sedimentation in accordance with Item 506.

List MS4 Operator(s) that may receive discharges from this project. They may need to be notified prior to construction activities.

1.
2.
- No Action Required Required Action

Action No.

- Prevent stormwater pollution by controlling erosion and sedimentation in accordance with TPDES Permit TXR 150000
- Comply with the SW3P and revise when necessary to control pollution or required by the Engineer.
- Post Construction Site Notice (CSN) with SW3P information on or near the site, accessible to the public and TCEQ, EPA or other inspectors.
- When Contractor project specific locations (PSL's) increase disturbed soil area to 5 acres or more, submit NOI to TCEQ and the Engineer.

II. WORK IN OR NEAR STREAMS, WATERBODIES AND WETLANDS CLEAN WATER ACT SECTIONS 401 AND 404

USACE Permit required for filling, dredging, excavating or other work in any water bodies, rivers, creeks, streams, wetlands or wet areas.

The Contractor must adhere to all of the terms and conditions associated with the following permit(s):

- No Permit Required
- Nationwide Permit 14 - PCN not Required (less than 1/10th acre waters or wetlands affected)
- Nationwide Permit 14 - PCN Required (1/10 to <1/2 acre, 1/3 in tidal waters)
- Individual 404 Permit Required
- Other Nationwide Permit Required: NWP# _____

Required Actions: List waters of the US permit applies to, location in project and check Best Management Practices planned to control erosion, sedimentation and post-project TSS.

- | | |
|----|----|
| 1. | 5. |
| 2. | 6. |
| 3. | 7. |
| 4. | 8. |

The elevation of the ordinary high water marks of any areas requiring work to be performed in the waters of the US requiring the use of a nationwide permit can be found on the Bridge Layouts.

Best Management Practices:

Erosion	Sedimentation	Post-Construction TSS
<input type="checkbox"/> Temporary Vegetation	<input checked="" type="checkbox"/> Silt Fence	<input type="checkbox"/> Vegetative Filter Strips
<input type="checkbox"/> Blankets/Matting	<input type="checkbox"/> Rock Berm	<input type="checkbox"/> Retention/Irrigation Systems
<input type="checkbox"/> Mulch	<input type="checkbox"/> Triangular Filter Dike	<input type="checkbox"/> Extended Detention Basin
<input type="checkbox"/> Sodding	<input type="checkbox"/> Sand Bag Berm	<input type="checkbox"/> Constructed Wetlands
<input type="checkbox"/> Interceptor Swale	<input type="checkbox"/> Straw Bale Dike	<input type="checkbox"/> Wet Basin
<input type="checkbox"/> Diversion Dike	<input type="checkbox"/> Brush Berms	<input type="checkbox"/> Erosion Control Compost
<input type="checkbox"/> Erosion Control Compost	<input type="checkbox"/> Erosion Control Compost	<input type="checkbox"/> Mulch Filter Berm and Socks
<input type="checkbox"/> Mulch Filter Berm and Socks	<input type="checkbox"/> Mulch Filter Berm and Socks	<input type="checkbox"/> Compost Filter Berm and Socks
<input type="checkbox"/> Compost Filter Berm and Socks	<input type="checkbox"/> Compost Filter Berm and Socks	<input checked="" type="checkbox"/> Vegetation Lined Ditches
	<input type="checkbox"/> Stone Outlet Sediment Traps	<input type="checkbox"/> Sand Filter Systems
	<input type="checkbox"/> Sediment Basins	<input type="checkbox"/> Grassy Swales

III. CULTURAL RESOURCES

Refer to TxDOT Standard Specifications in the event historical issues or archeological artifacts are found during construction. Upon discovery of archeological artifacts (bones, burnt rock, flint, pottery, etc.) cease work in the immediate area and contact the Engineer immediately.

- No Action Required Required Action

Action No.

- SEE STATEMENT ABOVE
-
-
-

IV. VEGETATION RESOURCES

Preserve native vegetation to the extent practical. Contractor must adhere to Construction Specification Requirements Specs 162, 164, 192, 193, 506, 730, 751, 752 in order to comply with requirements for invasive species, beneficial landscaping, and tree/brush removal commitments.

- No Action Required Required Action

Action No.

- SEE STATEMENT ABOVE
-
-
-

V. FEDERAL LISTED, PROPOSED THREATENED, ENDANGERED SPECIES, CRITICAL HABITAT, STATE LISTED SPECIES, CANDIDATE SPECIES AND MIGRATORY BIRDS.

- No Action Required Required Action

Action No.

- SEE STATEMENT BELOW
-
-
-

If any wildlife species are threatened by construction activities, cease work in the immediate area, do not disturb species or habitat and contact the Engineer immediately. The work may not remove active nests from bridges and other structures during nesting season of the birds associated with the nests. If caves or sinkholes are discovered, cease work in the immediate area, and contact the Engineer immediately.

LIST OF ABBREVIATIONS

BMP: Best Management Practice	SPCC: Spill Prevention Control and Countermeasure
CGP: Construction General Permit	SW3P: Storm Water Pollution Prevention Plan
DSHS: Texas Department of State Health Services	PCN: Pre-Construction Notification
FHWA: Federal Highway Administration	PSL: Project Specific Location
MOA: Memorandum of Agreement	TCEQ: Texas Commission on Environmental Quality
MOU: Memorandum of Understanding	TPDES: Texas Pollutant Discharge Elimination System
MS4: Municipal Separate Stormwater Sewer System	TPWD: Texas Parks and Wildlife Department
MBTA: Migratory Bird Treaty Act	TxDOT: Texas Department of Transportation
NOT: Notice of Termination	T&E: Threatened and Endangered Species
NWP: Nationwide Permit	USACE: U.S. Army Corps of Engineers
NOI: Notice of Intent	USFWS: U.S. Fish and Wildlife Service

VI. HAZARDOUS MATERIALS OR CONTAMINATION ISSUES

General (applies to all projects):

Comply with the Hazard Communication Act (the Act) for personnel who will be working with hazardous materials by conducting safety meetings prior to beginning construction and making workers aware of potential hazards in the workplace. Ensure that all workers are provided with personal protective equipment appropriate for any hazardous materials used. Obtain and keep on-site Material Safety Data Sheets (MSDS) for all hazardous products used on the project, which may include, but are not limited to the following categories: Paints, acids, solvents, asphalt products, chemical additives, fuels and concrete curing compounds or additives. Provide protected storage, off bare ground and covered, for products which may be hazardous. Maintain product labelling as required by the Act. Maintain an adequate supply of on-site spill response materials, as indicated in the MSDS. In the event of a spill, take actions to mitigate the spill as indicated in the MSDS, in accordance with safe work practices, and contact the District Spill Coordinator immediately. The Contractor shall be responsible for the proper containment and cleanup of all product spills.

Contact the Engineer if any of the following are detected:

- * Dead or distressed vegetation (not identified as normal)
- * Trash piles, drums, canister, barrels, etc.
- * Undesirable smells or odors
- * Evidence of leaching or seepage of substances

Does the project involve any bridge class structure rehabilitation or replacements (bridge class structures not including box culverts)?

- Yes No

If "No", then no further action is required.

If "Yes", then TxDOT is responsible for completing asbestos assessment/inspection.

Are the results of the asbestos inspection positive (is asbestos present)?

- Yes No

If "Yes", then TxDOT must retain a DSHS licensed asbestos consultant to assist with the notification, develop abatement/mitigation procedures, and perform management activities as necessary. The notification form to DSHS must be postmarked at least 15 working days prior to scheduled demolition.

If "No", then TxDOT is still required to notify DSHS 15 working days prior to any scheduled demolition.

In either case, the Contractor is responsible for providing the date(s) for abatement activities and/or demolition with careful coordination between the Engineer and asbestos consultant in order to minimize construction delays and subsequent claims.

Any other evidence indicating possible hazardous materials or contamination discovered on site. Hazardous Materials or Contamination Issues Specific to this Project:

- No Action Required Required Action

Action No.

- SEE GENERAL STATEMENT ABOVE

VII. OTHER ENVIRONMENTAL ISSUES

(includes regional issues such as Edwards Aquifer District, etc.)

- No Action Required Required Action

Action No.


-
-
-

Design Division Standard


ENVIRONMENTAL PERMITS,
 ISSUES AND COMMITMENTS
 EPIC

FILE: epic.dgn	DN: TxDOT	CK: RG	DW: VP	CK: AR
©TxDOT: February 2015	CONT	SECT	JOB	HIGHWAY
12-12-2011 (DS) REVISIONS	2311	01	044	FM 3051
05-07-14 ADDED NOTE SECTION IV.	DIST	COUNTY	SHEET NO.	
01-23-2015 SECTION I (CHANGED ITEM 1122 TO ITEM 506, ADDED GRASSY SWALES.	09	MCLENNAN	61	

10452022
D:\GIS\txdot_projects\seon\line.com\txdot3\Documents\09 - WAC\Design Projects\231101044\4 - Design\Plan Set\9. Environmental\Standards\ec116.dgn
DISCLAIMER:
The use of this standard is governed by the "Texas Engineering Practice Act". No warranty of any kind is made by TxDOT for any purpose whatsoever.
TxDOT assumes no responsibility for the conversion of this standard to other formats or for incorrect results or damages resulting from its use.

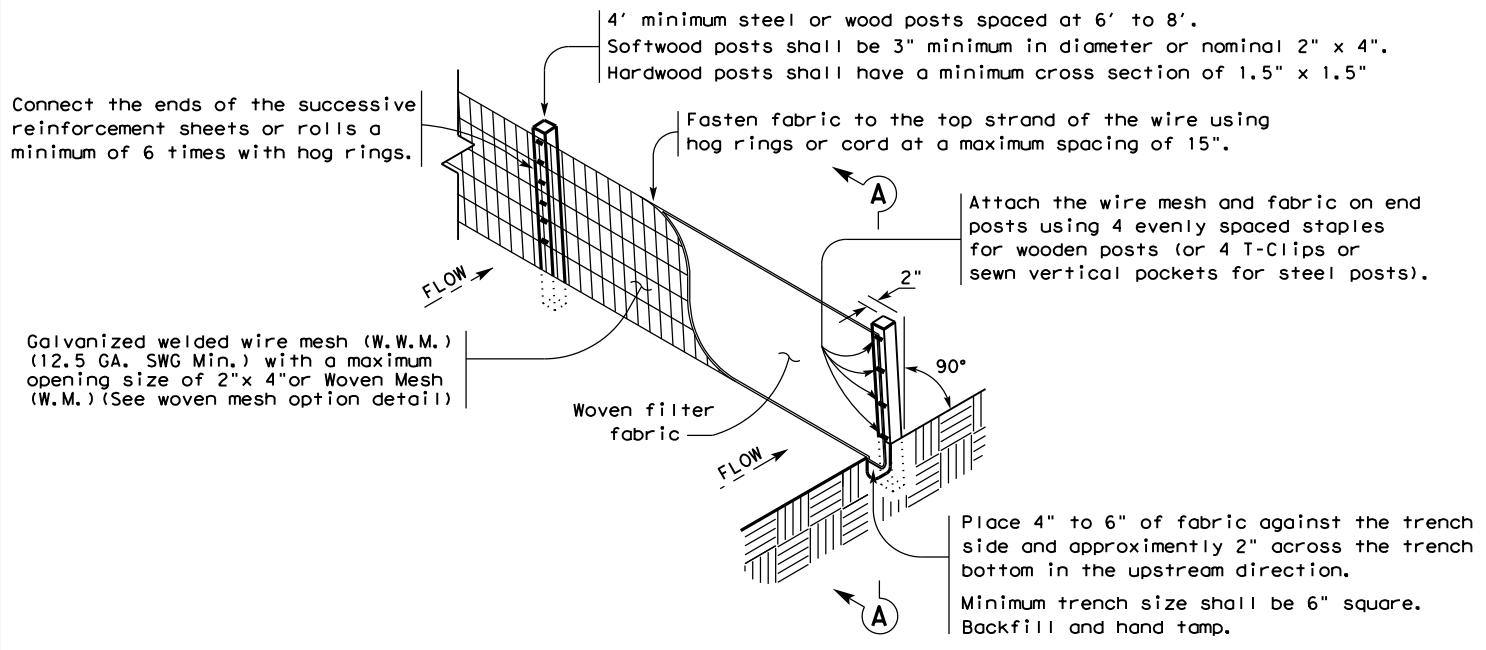


TEMPORARY SEDIMENT CONTROL FENCE

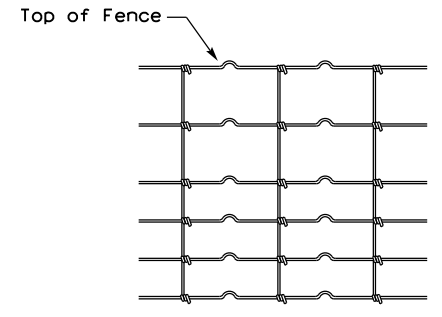

HINGE JOINT KNOT WOVEN MESH (OPTION) DETAIL

Galvanized hinge joint knot woven mesh (12.5 GA. SWG Min.) requires a minimum of five horizontal wires spaced at a maximum of 12 inches apart and all vertical wires spaced at a maximum of 12 inches apart.

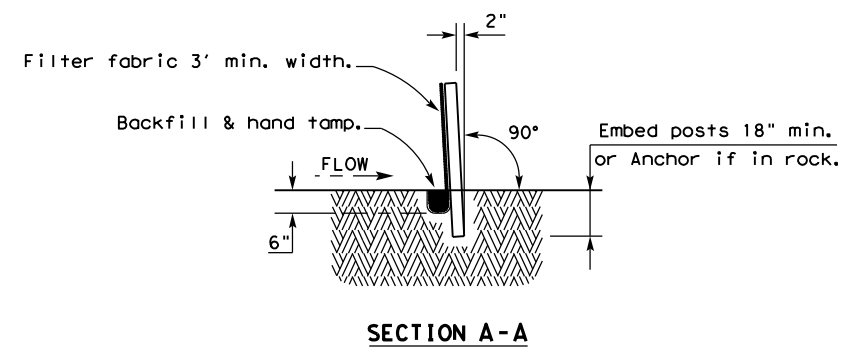


SEDIMENT CONTROL FENCE USAGE GUIDELINES

A sediment control fence may be constructed near the downstream perimeter of a disturbed area along a contour to intercept sediment from overland runoff. A 2 year storm frequency may be used to calculate the flow rate to be filtered.


Sediment control fence should be sized to filter a maximum flow through rate of 100 GPM/FT². Sediment control fence is not recommended to control erosion from a drainage area larger than 2 acres.

 LEGEND



GENERAL NOTES

- 1. Vertical tracking is required on projects where soil distributing activities have occurred unless otherwise approved.
- 2. Perform vertical tracking on slopes to temporarily stabilize soil.
- 3. Provide equipment with a track undercarriage capable of producing linear soil impressions measuring a minimum of 12" in length by 2" to 4" in width by 1/2" to 2" in depth.
- 4. Do not exceed 12" between track impressions.
- 5. Install continuous linear track impressions where the minimum 12" length impressions are perpendicular to the slope or direction of water flow.

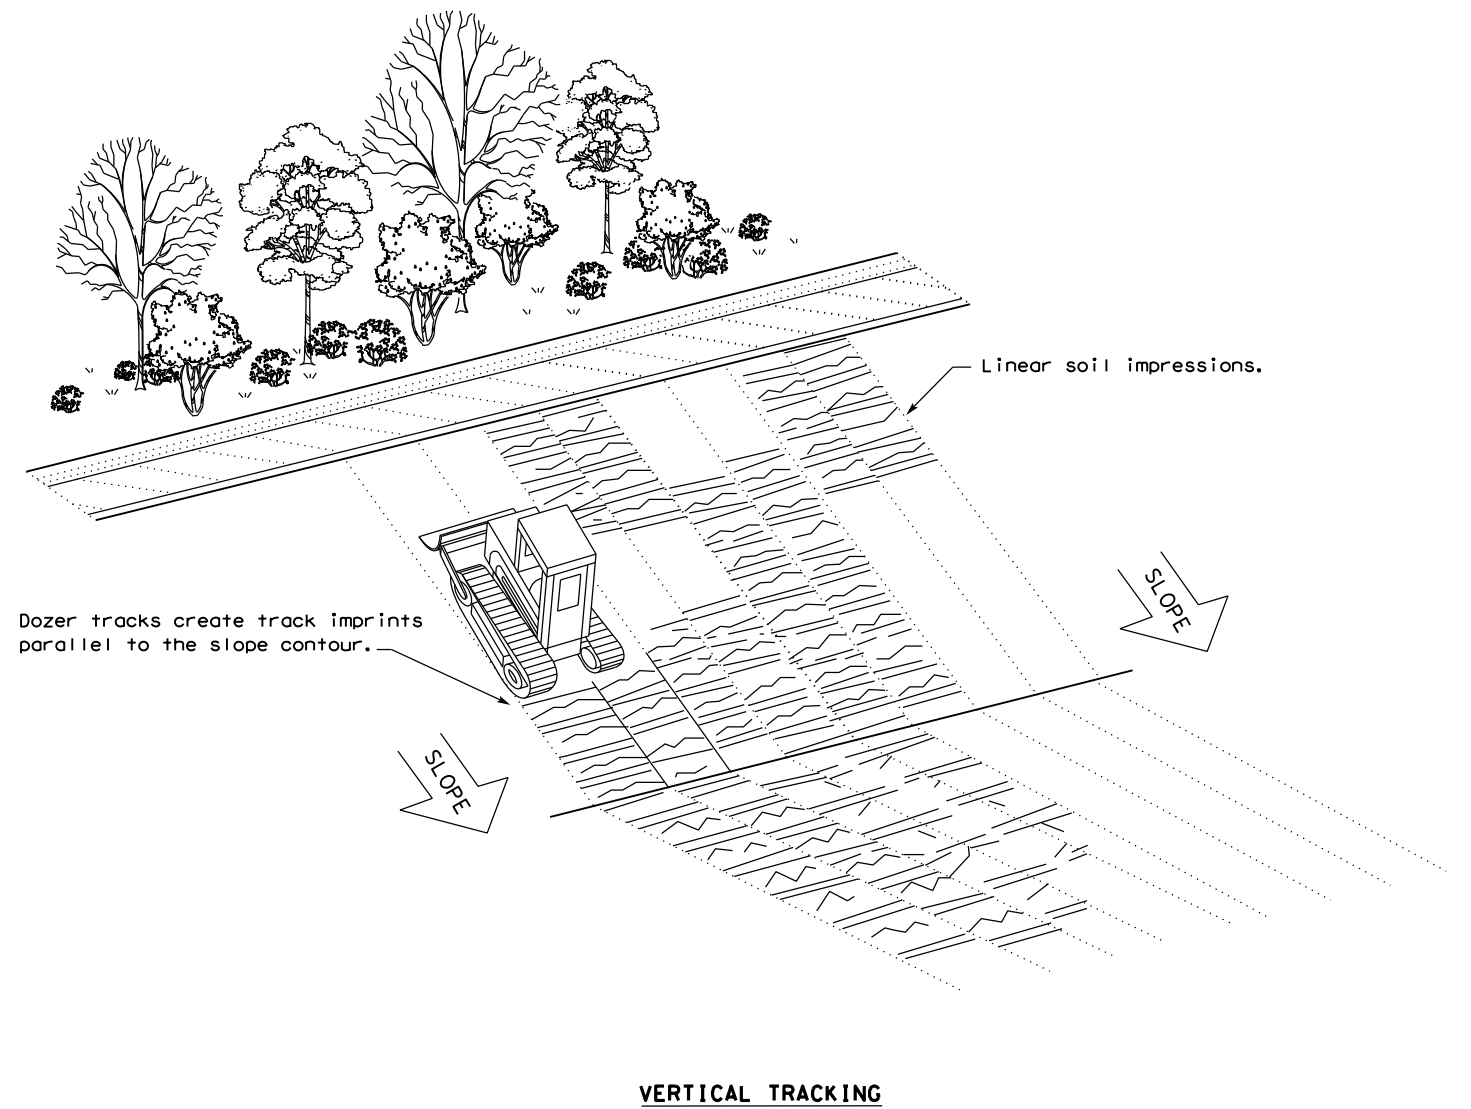

Texas Department of Transportation				Design Division Standard	
TEMPORARY EROSION, SEDIMENT AND WATER POLLUTION CONTROL MEASURES FENCE & VERTICAL TRACKING					
EC(1) - 16					
FILE: ec116	DN: TxDOT	CK: KM	DW: VP	DN/CK: LS	
© TxDOT: JULY 2016	CONT	SECT	JOB	HIGHWAY	
REVISIONS	2311	01	044	FM 3051	
	DIST	COUNTY		SHEET NO.	
	WAC	MCLENNAN		62	

BEST MANAGEMENT PRACTICE (BMP) GENERAL NOTES

1. Prior to TxDOT allowing the Contractor to start construction, the Contractor will provide the required storm water and 404 permit documentation and support activities, including but not limited to the following:
 - Provide a list of all chemicals, construction and waste products that will be generated, stored or brought upon TxDOT ROW. The list includes expected construction debris, sanitary wastes, construction chemicals and petroleum products used or generated by the Contractor and sub-contractors. Along with the list, the Contractor will supply a spill prevention plan and clean up procedures that will include each of these chemical products or generated waste.
 - Provide in the construction schedule the necessary line items that will comply with the schedule and planning requirements of the storm water permit.
 - Post the TxDOT storm water permit and any Contractor permits, per permit requirements.
 - Provide copies of storm water permits for Contractor PSL(s). As new PSL(s) may be obtained for the project, provide copies of new or amended permits to TxDOT. The Contractor will not disturb soil without the proper permits.
 - Provide scale drawings of off ROW PSL's within one mile of the project, for field offices, borrow sources, plant sites or other uses.
 - Provide permit information on any Contractor batch plants or concrete crushing plants to be located at a Contractor PSL(s) within one mile of the project limits or boundaries. Copies of the air and water permits are to be provided to TxDOT before materials will be used on the project. No asphalt or concrete batch plants or concrete crushing plants will be located on TxDOT ROW.
 - Provide a letter indicating a Contractor Responsible Person for environmental compliance (CRP) for the project, and maintain a CRP throughout the project duration.
 - Provide all environmental documentation including certification of compliance and EMS training documents/certificates prior to starting work. The Contractor is to provide daily BMP inspection reports that document all field BMPs needing repair or replacement. The Contractor is to clearly document specific BMPs needing repair and location each work day. The Contractor is encouraged to be proactive in fixing BMPs without TxDOT direction.
 - Provide documentation required for Waters of the US, Note #3 and submittals for Item 496 bridge removal. Bridge removal methods submitted will follow all Waters of the US note requirements. The Contractor is not to start construction within the Ordinary High Water Marks of any stream until receiving approval for stream channel construction methods from TxDOT.
 - Provide a written procedure for managing all chemicals and construction items placed in vertical containment structures. Also, provide methods to be used for the treatment, disposal, collection or release of storm water.
 - Provide an estimated date by letter, for the submittal of marked up bridge drawings, indicating cut locations for any structural steel requiring cutting or torching of steel, coated with lead containing paints.
2. Place and maintain trash cans and portable sanitary facilities at locations where there is active construction. Worker generated trash and construction debris will be kept from being transported by storm water and will be collected daily from the ground and routinely hauled from the work area.
3. Contractor will provide TxDOT copies of all correspondence with MS4s, TCEQ, EPA, DSHS and Corps of Engineers regarding activities on this project.
4. Contractor to conduct storm water inspections and develop SWPPP documents to support Contractor permits obtained for the project including PSL(s).
5. Contractor will maintain written documentation of locations of all portable sanitary facilities. The Contractor is required to document the location and disposition of all spills and cleanups from portable sanitary facilities.
6. Contractor will not store chemicals on TxDOT ROW, unless chemicals are stored following all environmental and safety regulations. Fuels for construction equipment will not be stored on TxDOT ROW.
7. The Contractor will store fuels and bulk chemicals on Contractor PSL(s) using a secondary containment method, such as double lined tanks and/or free standing containment reservoirs made of plastic or steel designed to hold bulk chemicals or drums.
8. The Contractor will not remove sediment controls without the prior approval of TxDOT, except for a sediment control that may back up water and cause safety or traffic problems.

SCALE = NTS SHEET 1 OF 10

 **Texas Department of Transportation**
Waco District Standard

TYPICAL APPLICATIONS FOR BEST MANAGEMENT PRACTICES

TA-BMP

FILE: BMPLAYOUTS.dgn	DN:	CK:	DW:	CK:
© TxDOT 2009	CONT	SECT	JOB	HIGHWAY
REVISIONS	2311	01	044	FM 3051
DEC 2013	DIST	COUNTY		SHEET NO.
FEB 2015	WAC	MCLENNAN		63

BEST MANAGEMENT PRACTICE (BMP) GENERAL NOTES

9. Any sediment controls removed by the Contractor must be re-installed before the next rainfall event or by the end of day, as approved in advance.
10. Vegetative buffer strips may be used in place of temporary sediment controls such as silt fences and rock filter dams. The amount of disturbed soil area will be limited to 1/3 of an acre or less for a minimum of 50 feet of grassed ditch and 2/3 of an acre of disturbed soil for a minimum of 100 feet of grassed ditch.
11. Construction equipment found to be leaking oil, fuel or coolant will be immediately stopped, the leaking fluid collected and the equipment fixed. Equipment continuing to leak will be removed from the project at no cost to TxDOT. Leaking fluids from equipment will be collected and removed from the project or PSL.
12. Earth berms or mounds typically used to stockpile topsoil and used in place of boundary silt fence will be seeded upon being constructed. Long term use of earth berms or mounds will not be continued without establishing grass on the control.
13. The Contractor will inform TxDOT of new areas where soil will be disturbed to facilitate planning for new sediment controls. Areas of vegetated soil will not be disturbed by the Contractor, unless adequate sediment controls can be installed before the next rainfall event. The Contractor will assist TxDOT in keeping an accurate set of working SWPPP drawings that show the locations of all temporary sediment and erosion controls.
14. The Contractor will maintain an adequate amount of temporary sediment controls on hand at the field office or project staging area for critical SWPPP maintenance, including silt fence (minimum of 200 feet) and rock / fabric for rock filter dams (minimum for 100 feet of Type III dams).

The requirement for BMP rock quantities on hand is waived for small projects for on and off system bridge installations. The Contractor having a BMP Subcontractor does not eliminate the requirement for the Contractor to have the required silt fence and rock on hand, typically stored at the Contractor PSL.
15. Failure of a sub-contractor to complete storm water work on time will require the Contractor to start storm water sediment control work immediately and complete the work with high priority, or be subject to stop work on the entire project.
16. Earth materials on roads as a result of soil tracking will not be allowed to be transported off ROW in storm water. Soil or rock material found on roadways deposited from Contractor equipment will be removed daily.
17. Unless approved, completed concrete curb inlets will not be blocked by sediment controls. The contractor will frequently sweep the completed or partially completed roadway to keep sediment out of drainage pipes.
18. The Contractor will be responsible for proper dust control and will route construction traffic in a manner that minimizes dust generation.
19. Water for dust control will contain no pollutants, but may be non-potable from upland stock ponds. No quantity of water to be used for construction purposes may be taken from a 404 stream, prior to the proper authorizations or permits being obtained by the Contractor.
20. Contractor is to direct workers and sub-contractors to use portable sanitary facilities provided by the Contractor and not to trespass off ROW.
21. Contractor will provide written verification to TxDOT that earth borrow pits and disposal sources meet environmental and regulatory requirements, prior to use. Excavations will meet all OSHA requirements and the current safety guidelines established for TxDOT Quarries and Pits.
22. Boundary silt fences that are terminated down slope, with one end being at the lowest elevation, will be installed with an L - hook to contain sediment. Boundary silt fences that are installed on flat ground will have L-hooks on both ends.
23. Rock filter dams across ditches will be constructed where the rock filter dam ends are embedded within the ditch side slopes and ditch bottom. The top center elevation of the rock filter dam will be at least 6 inches lower than the elevations on the rock filter dam ends.
24. Silt fence will be constructed in a U or V pattern across ditch lines and up the ditch side slope to keep storm water from flowing around the ends of the silt fence. Small silt fences that do not adequately span the ditch and allows storm water around the end(s) will not be used. Where there is adequate space, large U pattern silt fences are preferred to facilitate sediment collection and sediment removal with equipment.
25. Sediment controls (RFDs or silt fences) will be located along road ditches as marked on the SWPPP drawings. Modifications to the sediment control spacing will be adjusted during the project based on sediment control effectiveness. The installation and maintenance of sediment controls at or near outfalls, where storm water leaves TxDOT ROW, takes persistent over ditch line sediment controls.

SCALE = NTS SHEET 2 OF 10

 **Texas Department of Transportation**
Waco District Standard

TYPICAL APPLICATIONS FOR BEST MANAGEMENT PRACTICES

TA-BMP

FILE: BMPLAYOUTS.dgn	DN:	CK:	DW:	CK:
© TxDOT 2009	CONT	SECT	JOB	HIGHWAY
REVISIONS	2311	01	044	FM 3051
DEC 2013	DIST	COUNTY		SHEET NO.
FEB 2015	WAC	MCLENNAN		64

BEST MANAGEMENT PRACTICE (BMP) GENERAL NOTES

26. Storm water draining sheet flow over disturbed soil sloped towards the ROW property line, will be intercepted by a boundary silt fence typically installed with L-shaped ends.
27. For ditch grading and shoulder up work, the Contractor is limited during good weather to remove up to one mile (limited to five acres of disturbed soil) of ditch line sediment controls; on one side of the roadway. Outfall controls cannot be removed during this activity. Ditch line controls must be replaced upon completion of work and before the next rain event.
28. Sediment controls damaged by the Contractor, as defined by permit, must be fixed or replaced immediately upon discovery.
29. Notches in silt fences are not typically allowed. Specific silt fences that back up water onto lanes of traffic may be notched if approved.
30. For silt fence maintenance, the Contractor will leave approximately 4 inches of deposited sediment up stream of silt fences and not over excavate around silt fences or rock filter dams.
31. The Contractor will inform TxDOT of new construction areas and where soil is planned to be disturbed. Sediment controls will be installed at outfalls prior to the Contractor beginning soil disturbing activities up slope from the outfall.
32. Water from concrete saw cutting, concrete grinding and concrete coring activities; or fine materials from concrete chipping and salvage will not be allowed to enter storm drains or enter streams.
33. Storm water containing suspended sediment and turbidity needing to be removed from excavations or low areas will be pumped or gravity drained through vegetated buffer strips (50 foot minimum) or placed in ditches with temporary sediment controls, prior to the water being discharged into a stream.
34. Uncontaminated water from natural groundwater seepage, springs, foundations and drains that does not contain suspended sediment or any pollutants may be discharged without storm water controls.
35. Lime or cement if spilled in ditches or outside the defined limits of application is considered a pollutant and will be excavated and removed the same day, to avoid contaminating streams.
36. If located along the project ROW, RAP stockpiles will be located where there is a minimum 100 feet of vegetative buffer strip before storm water will reach a stream. RAP will not be used as a construction material within the Ordinary High Water Marks of a stream channel of a 404 designated stream.
37. If allowed on the project, concrete truck wash out areas will have adequate volume to allow 12 inch freeboard for rain and will be lined with 6 mils of plastic. No concrete will be stored higher than the 12 inch freeboard. Cleaning of truck chutes and equipment does not constitute concrete truck wash out and this activity may be completed at the concrete placement location. Wash out areas will not be located closer than 50 ft from down slope inlets or stream channels.
38. For outfalls near stock ponds closer than 50 foot from disturbed soil at the ROW line, redundant sediment controls will be provided, typically a combination of rock filter dam and a silt fence constructed in line of the flow.
39. Earth stockpiles will utilize silt fence sediment controls, positioned on the low end of the stockpile drainage area with L-hooks or silt fence installed around the entire stockpile.
40. Sediment controls including rock filter dams and silt fences will not be installed across any 404 streams. Sediment controls at 404 streams will be positioned to limit sediment entering the stream from the banks and around structures/culverts, and will allow free flow of storm water to pass through the ROW without being dammed by any sediment controls. Remove loose materials from stream channels prior to each rain event.
41. Sediment controls for non-404 streams may be constructed across the drainage channel in unlimited locations. It is appropriate to use sediment control details typically used for 404 streams for non-404 streams when flow velocities are high. Remove loose material from stream channels prior to each rain event.
42. Incomplete drainage pipe installation across the roadway does not remove the requirement for having sediment controls around the ends of the pipe. To stay within permit requirements, sediment controls should be installed over and around the terminated end and along each side of the banks as soon as construction on the pipe has been completed. Remove loose material from stream channels prior to each rain event.
43. Safety end / headwall construction temporarily will require the removal of part of the sediment control placed over and around the pipe end. Retain in place as much functioning sediment control as possible. Replace the silt fence over and around the top of the pipe, immediately upon concrete placement and form removal. Do not remove culvert sediment controls that cannot be replaced before the next rain event. Sediment control at the ends of culverts must be in place and available for any rain event until the disturbed soil areas are re-vegetated.

SCALE = NTS SHEET 3 OF 10

 **Texas Department of Transportation**
Waco District Standard

TYPICAL APPLICATIONS FOR BEST MANAGEMENT PRACTICES

TA-BMP

FILE: BMPLAYOUTS.dgn	DN:	CK:	DW:	CK:
© TxDOT 2009	CONT	SECT	JOB	HIGHWAY
DEC 2013	2311	01	044	FM 3051
FEB 2015	DIST	COUNTY		SHEET NO.
	WAC	MCLENNAN		65

BEST MANAGEMENT PRACTICE (BMP) GENERAL NOTES

44. Between the Ordinary High Water Marks of a 404 stream channel, the Contractor will disturb only the minimum amount of stream channel that is necessary to complete the work.
45. Rock riprap for erosion control does not replace the requirements to maintain sediment control until vegetation is re-established. Replace sediment controls immediately after installing erosion rock.
46. At the direction of TxDOT, sediment deposited into existing and new culverts will be removed subsidiary to Item 506. Sediment to be removed is either pre-existing material before construction starts or sediment generated as a part of this project.
47. Provide treated 2X4 cross bracing for rectangular inlet silt fence, subsidiary to Item 506.
48. Loose or granular earth materials will not be used to repair silt fence undercuts. Silt fence undercut repairs will be conducted with well compacted soils or the silt fence will be reset in a nearby location.
49. Silt fence steel T posts of approximately 1.25 pounds per foot are allowed at a spacing of 8 feet or less. Silt fence steel T posts between approximately 1.25 pounds per foot and 0.85 pounds per foot are allowed for T post spacing of 5 feet or less.
50. Silt fence to be used to slow the flow of storm water down slopes will be positioned approximately horizontal (on the contour) with L hooks on the ends and limited to approximately 200 feet in length. Multiple sections and levels of silt fence may be required in addition to temporary / permanent erosion control flumes.
51. Soil retention blankets will be installed rolled down the slope with the small dimension side embedded at the top of slope, unless recommended otherwise by the manufacturer. Excess grass, rocks, trash, debris or clods will be removed before seeding and installing soil retention blankets. All installations will be by the manufacturer recommendations. Contractor equipment, including tractor mowers will be kept off areas with soil retention blankets until the grass is established.





SCALE = NTS SHEET 4 OF 10

 **Texas Department of Transportation**
Waco District Standard

TYPICAL APPLICATIONS FOR BEST MANAGEMENT PRACTICES

TA-BMP

FILE: BMPLAYOUTS.dgn	DN:	CK:	DW:	CK:
© TxDOT 2009	CONT	SECT	JOB	HIGHWAY
REVISIONS	2311	01	044	FM 3051
DEC 2013	DIST	COUNTY		SHEET NO.
FEB 2015	WAC	MCLENNAN		66

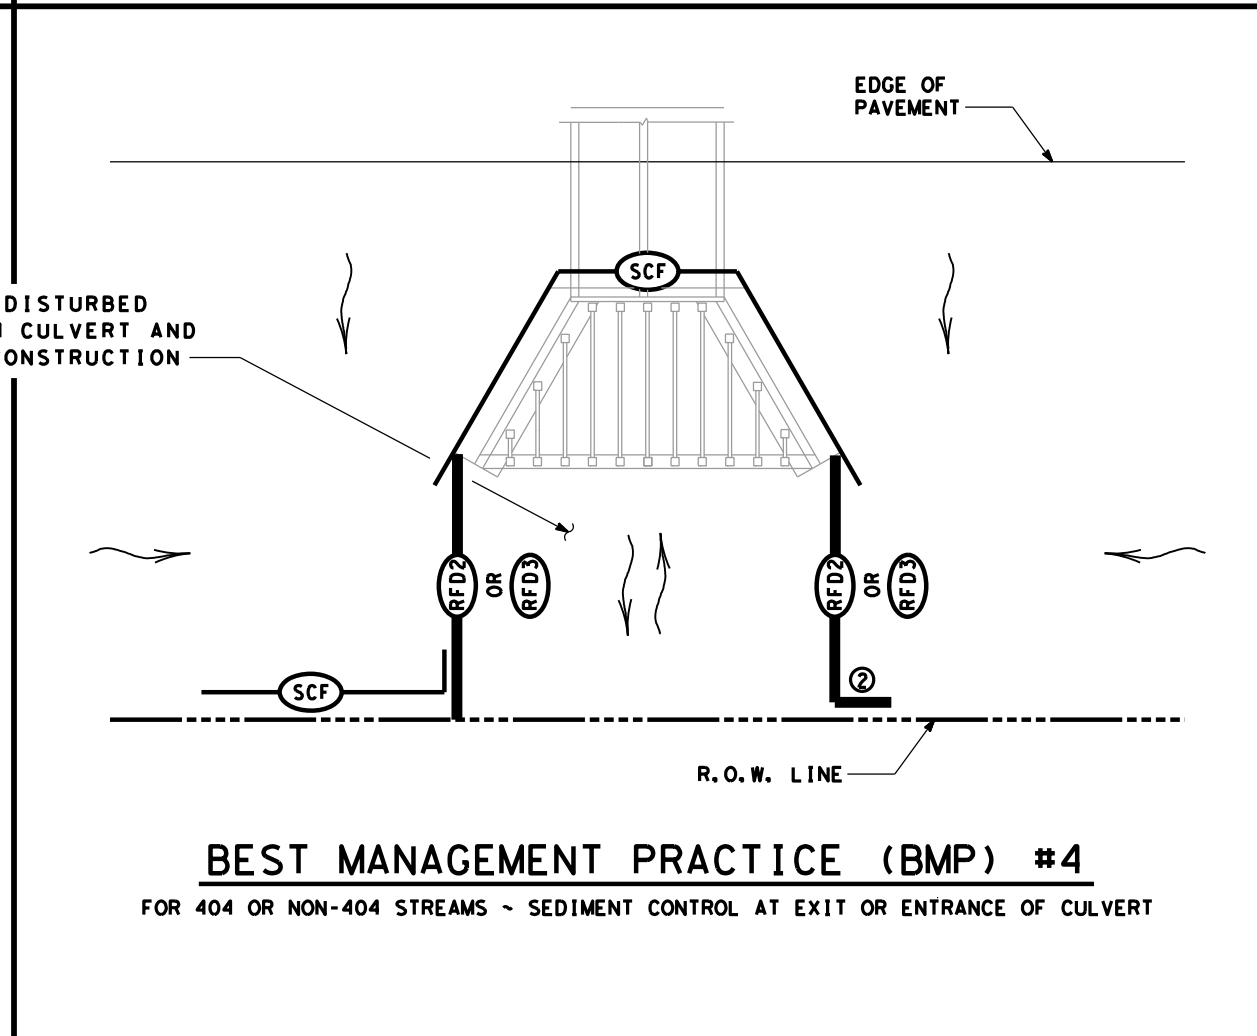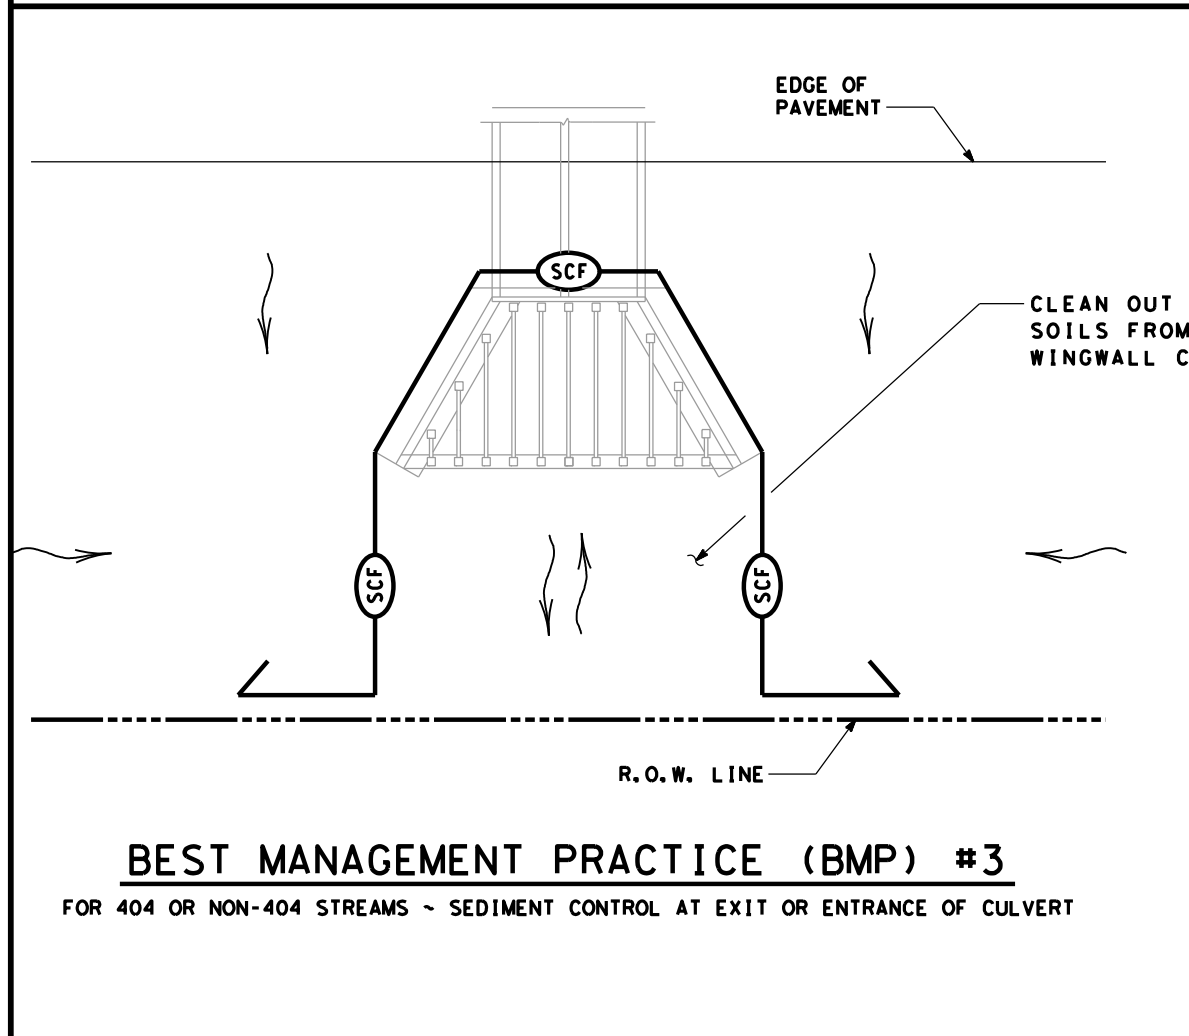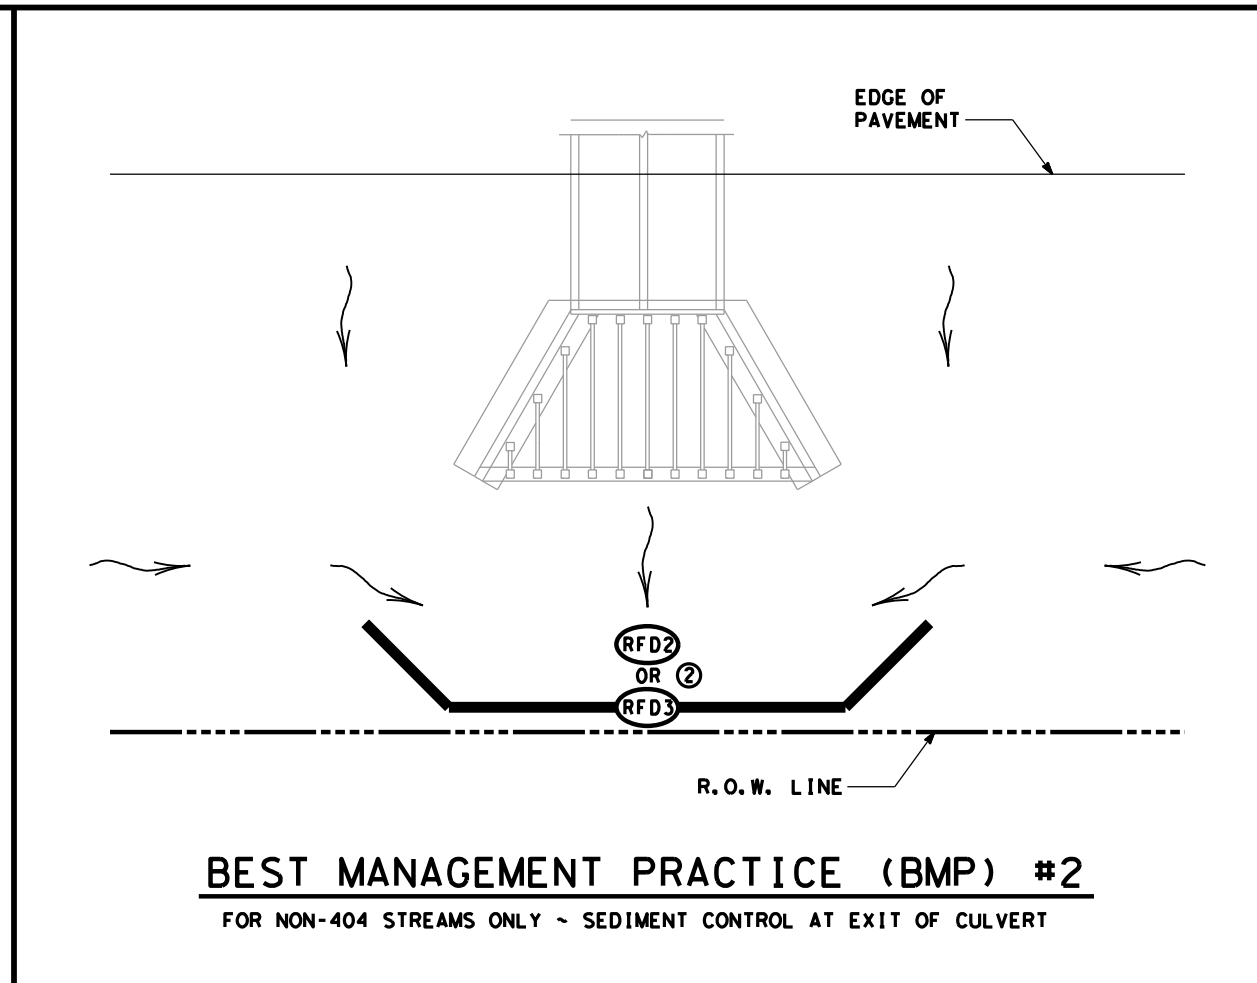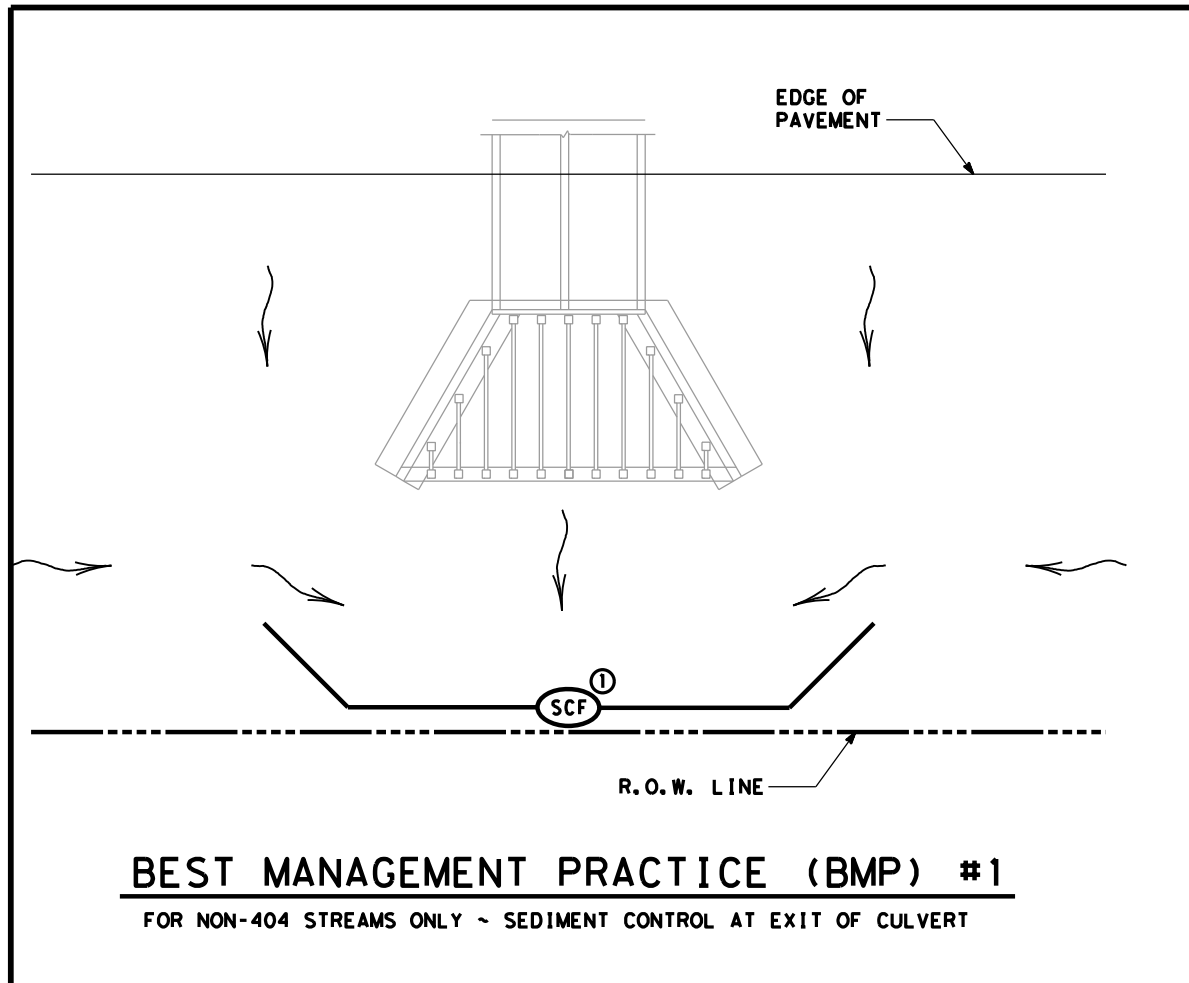

	SEDIMENT CONTROL FENCE
	ROCK FILTER DAM (TY 2)
	ROCK FILTER DAM (TY 3)
	DIRECTION OF FLOW

- NOTES:
- ① EXTEND SILT FENCE SO STORM WATER DOES NOT GO AROUND THE ENDS. USE L-HOOKS ON ENDS AS REQUIRED.
 - ② EXTEND ROCK FILTER DAM SO STORM WATER DOES NOT GO AROUND THE ENDS.





SCALE = NTS SHEET 5 OF 10



TYPICAL APPLICATIONS FOR BEST MANAGEMENT PRACTICES

TA-BMP

FILE: BMPLAYOUTS.dgn	DN: TXDOT	CK: TXDOT	DW: TXDOT	CK: TXDOT
© TXDOT 2009	CONT	SECT	JOB	HIGHWAY
REVISIONS	2311	01	044	FM 3051
DEC 2013	DIST	COUNTY		SHEET NO.
FEB 2015	WAC	MCLENNAN		67

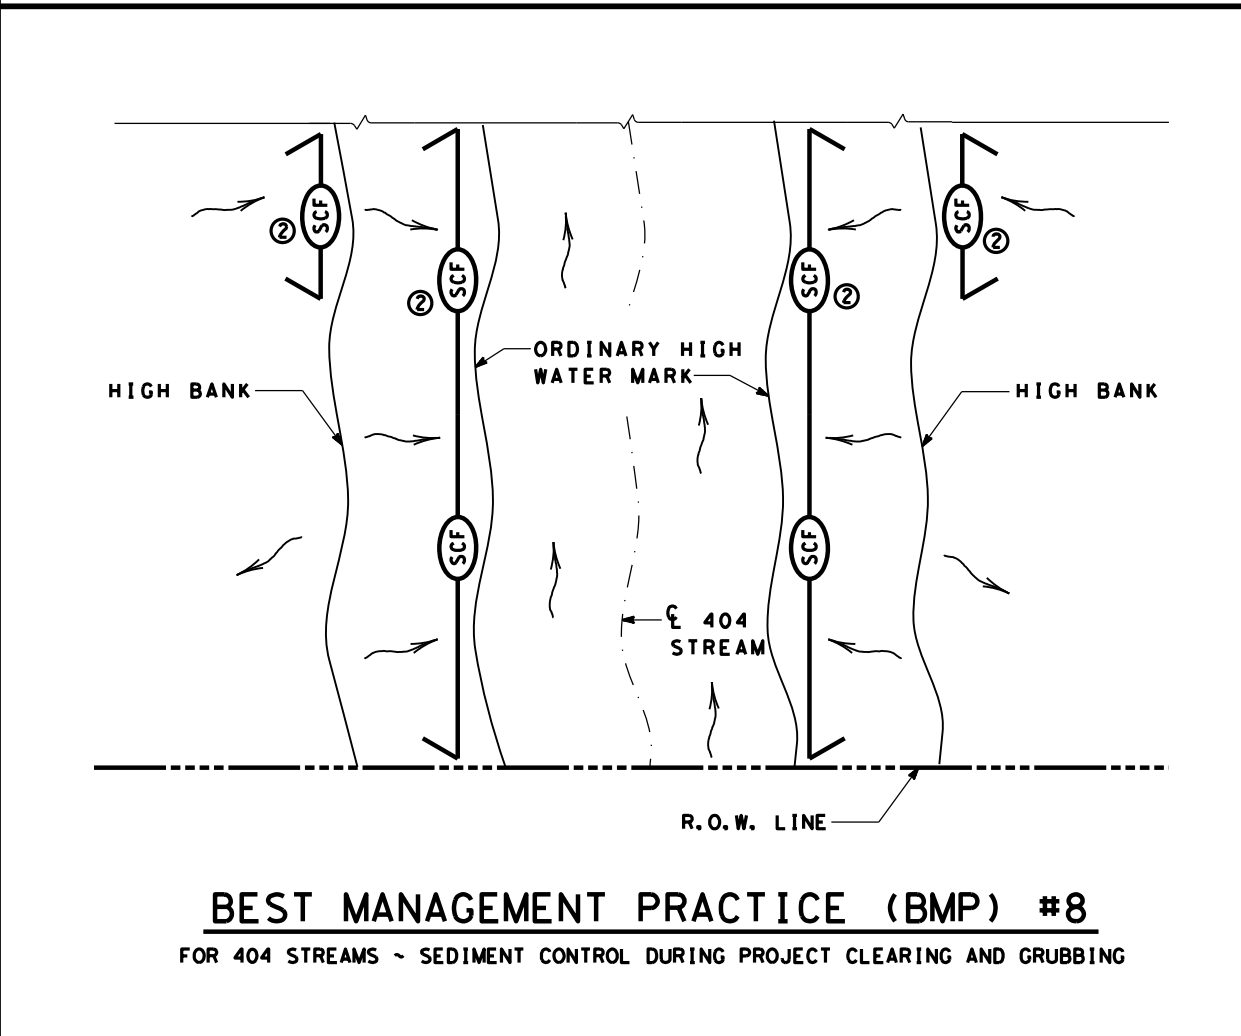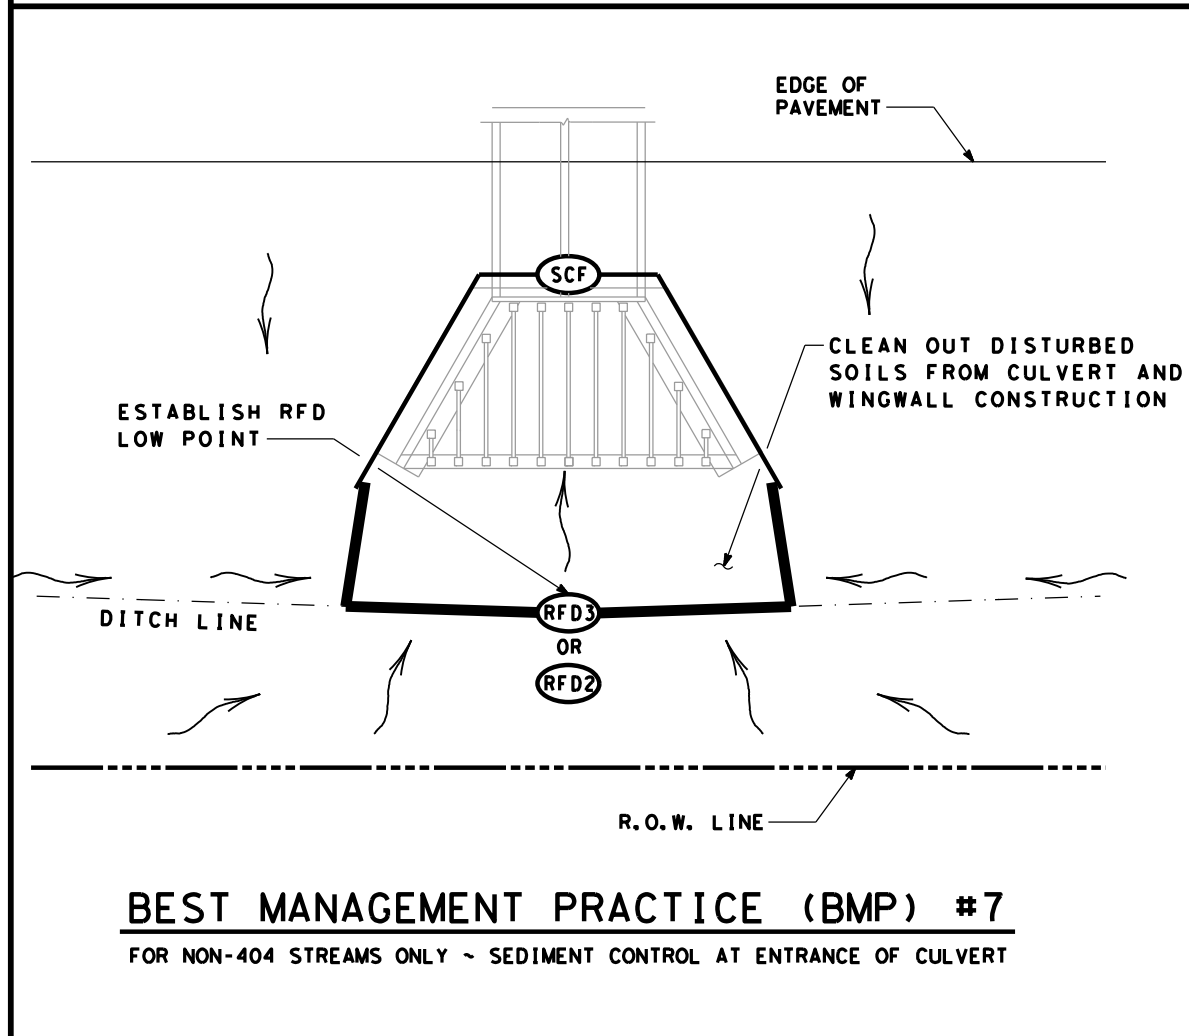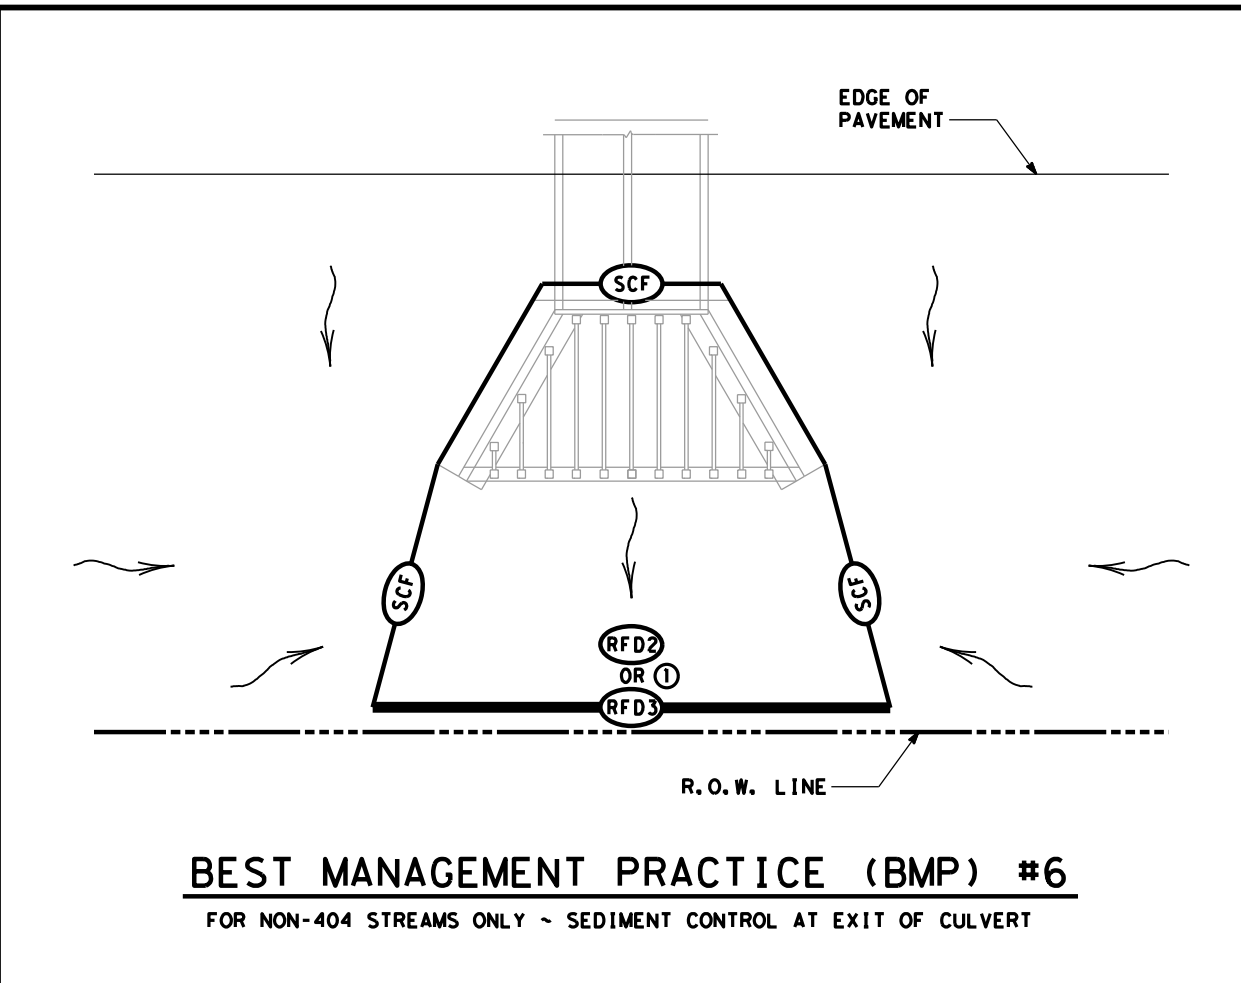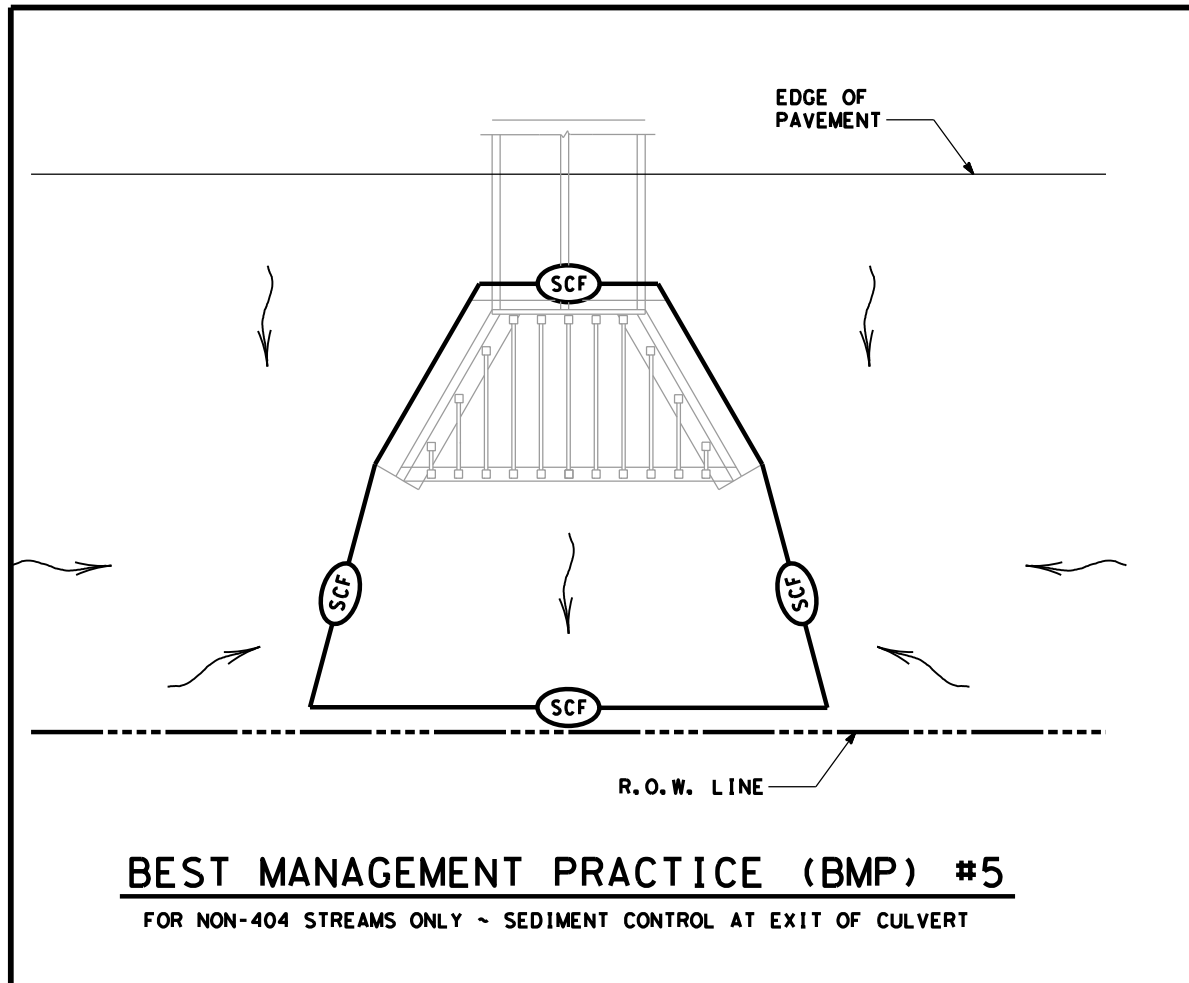

	SEDIMENT CONTROL FENCE
	ROCK FILTER DAM (TY 2)
	ROCK FILTER DAM (TY 3)
	DIRECTION OF FLOW

- NOTES:
- PROVIDE OVERLAP OF SILT FENCE WITH ROCK FILTER DAM.
 - USE SILT FENCE L-HOOKS ON ENDS TO BLOCK STORM WATER SEDIMENT


SCALE = NTS SHEET 6 OF 10

Texas Department of Transportation
Waco District Standard


TYPICAL APPLICATIONS FOR BEST MANAGEMENT PRACTICES

TA-BMP

FILE: BMPLAYOUTS.dgn	DN: TXDOT	CK: TXDOT	DW: TXDOT	CK: TXDOT
© TXDOT 2009	CONT: 2311	SECT: 01	JOB: 044	HIGHWAY: FM 3051
REVISIONS	DIST: WAC	COUNTY: MCLENNAN	SHEET NO. 68	

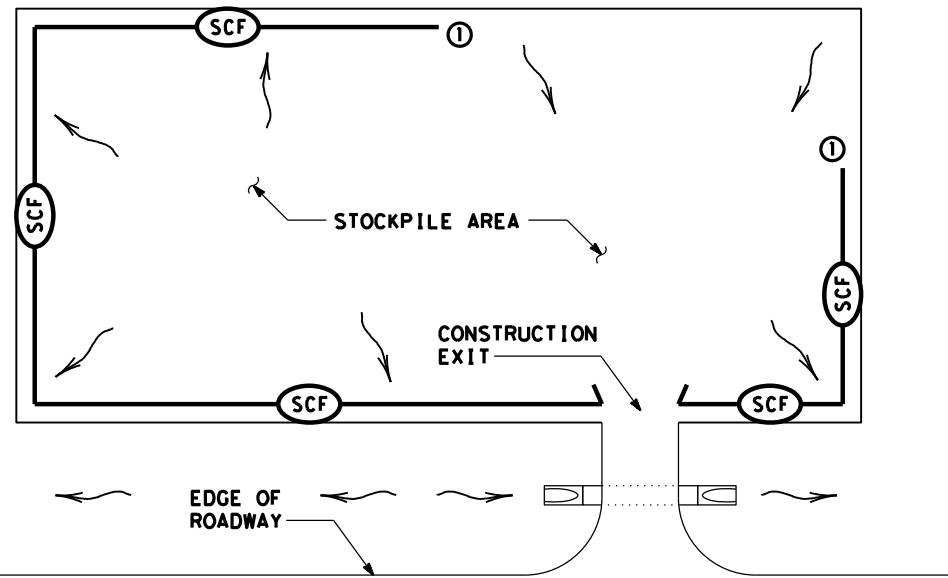


BEST MANAGEMENT PRACTICE (BMP) #9
STOCKPILE SEDIMENT CONTROL

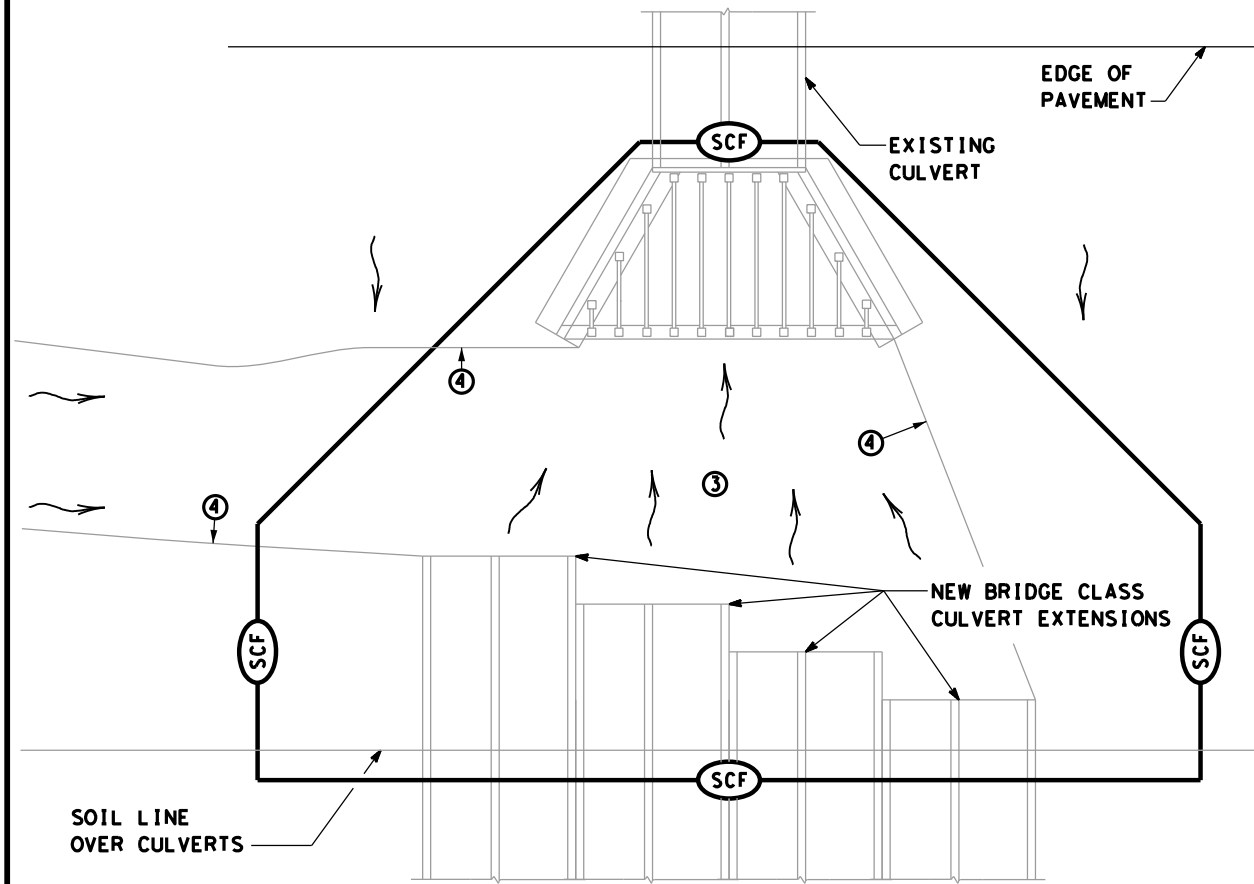


BEST MANAGEMENT PRACTICE (BMP) #10
FOR 404 OR NON-404 STREAMS ONLY ~
SEDIMENT CONTROL AT PHASED CONSTRUCTION OF BRIDGE CLASS CULVERTS

	SEDIMENT CONTROL FENCE
	ROCK FILTER DAM (TY 2)
	ROCK FILTER DAM (TY 3)
	DIRECTION OF FLOW

- NOTES:
- START SEDIMENT CONTROL AT LOCATION SO ALL STORM WATER WITH SEDIMENT IS COLLECTED
 - ROCK FILTER DAMS OR EARTH/GRASSED EMBANKMENTS CAN BE SUBSTITUTED AS DIRECTED.
 - PROVIDE A SMOOTH TRANSITION FROM THE INVERT ELEVATIONS BETWEEN CULVERTS. REMOVE LOOSE SOIL FROM EXCAVATED AREA BETWEEN CULVERTS.
 - PROVIDE AND INSTALL PNEUMATICALLY PLACED CONCRETE ON THE DITCH BOTTOM AND SIDE SLOPES BETWEEN TEMPORARY TERMINATIONS BETWEEN OLD AND NEW CULVERTS. PNEUMATICALLY PLACED CONCRETE WILL BE PLACED TO THE HEIGHT OF THE LARGEST CULVERT ON THE DITCH SIDE SLOPES; AND TO A LIMIT 10 FEET OUTSIDE THE LOCATION OF BMPS ALONG THE DITCH BOTTOM. CEMENT STABILIZED SAND MAY BE SUBSTITUTED FOR PNEUMATICALLY PLACED CONCRETE, IN AREAS WHERE INSTALLATION WORKS AND AT THE OPTION OF TXDOT.

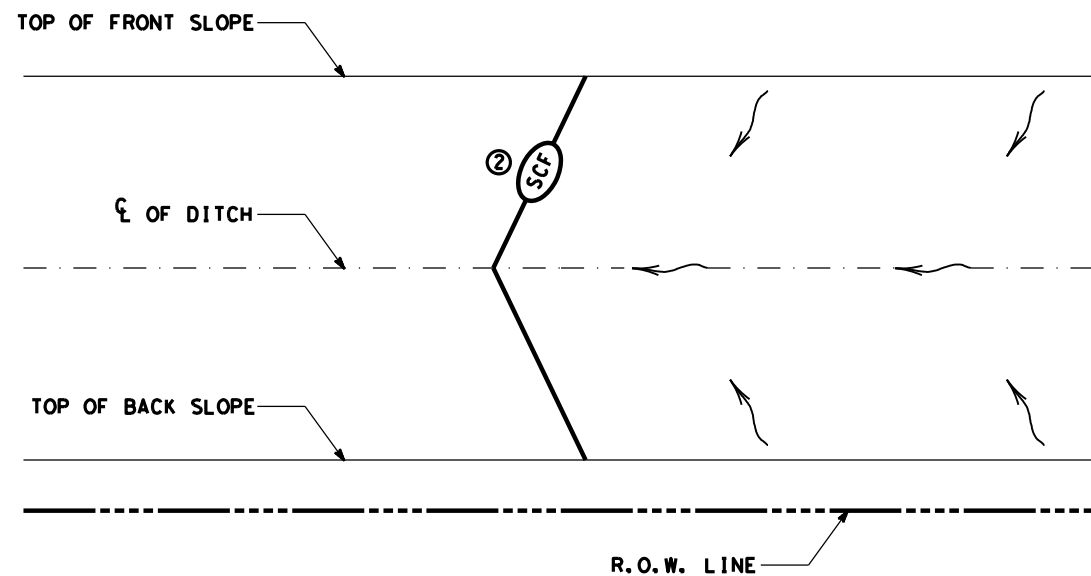

BEST MANAGEMENT PRACTICE (BMP) #11
BOUNDRY SEDIMENT CONTROL ~ BOTH ENDS OF CONTROL TERMINATED UP SLOPE

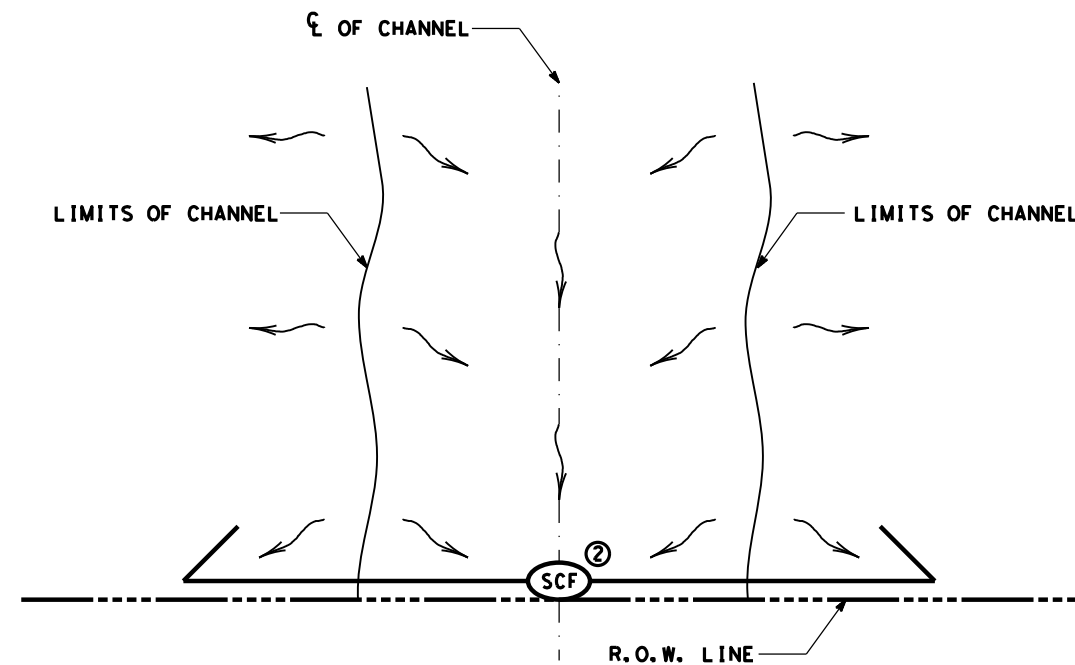

BEST MANAGEMENT PRACTICE (BMP) #12
BOUNDRY SEDIMENT CONTROL ~ BOTH ENDS OF CONTROL TERMINATED DOWN SLOPE


SCALE = NTS SHEET 7 OF 10

Texas Department of Transportation
Waco District Standard

TYPICAL APPLICATIONS FOR BEST MANAGEMENT PRACTICES

TA-BMP

FILE: BMPLAYOUTS.dgn	DN: TXDOT	CK: TXDOT	DW: TXDOT	CK: TXDOT
© TXDOT 2009	CONT	SECT	JOB	HIGHWAY
REVISIONS	2311	01	044	FM 3051
DEC 2013	DIST	COUNTY		SHEET NO.
FEB 2015	WAC	MCLENNAN		69

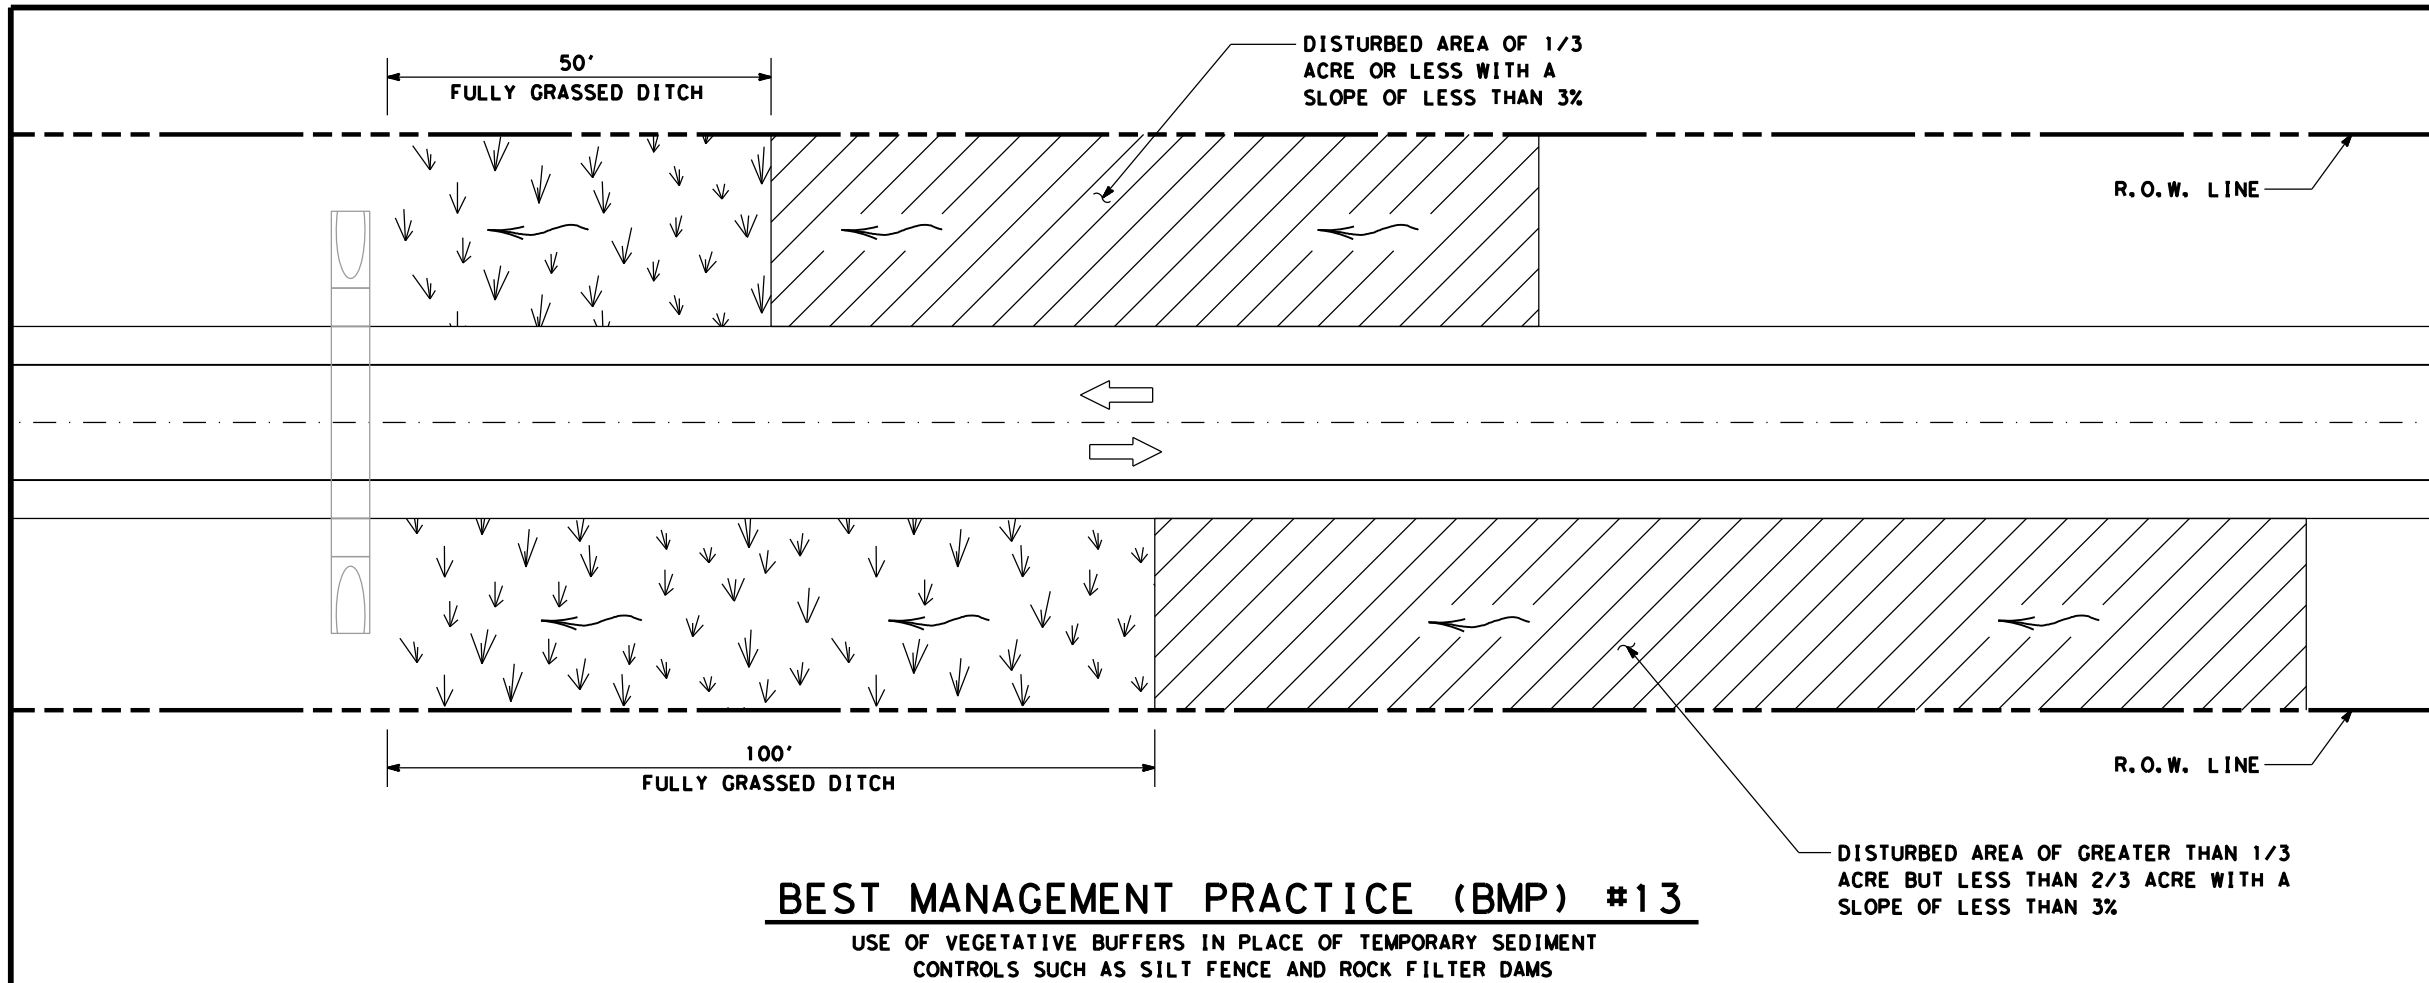


BEST MANAGEMENT PRACTICE (BMP) #13

USE OF VEGETATIVE BUFFERS IN PLACE OF TEMPORARY SEDIMENT CONTROLS SUCH AS SILT FENCE AND ROCK FILTER DAMS

	FULLY GRASSED DITCH
	DISTURBED AREA
	DIRECTION OF FLOW
	SEDIMENT CONTROL FENCE

- ① FOR H DIMENSIONS LESS THAN 1.5' SILT FENCE MAY NEED TO BE NOTCHED AS SHOWN IN VIEW A-A. ADD EXTRA POSTS AT NOTCH.
- ② BMP #14 MAY BE USED AT CROSS DRAINAGE STRUCTURES AS DIRECTED.

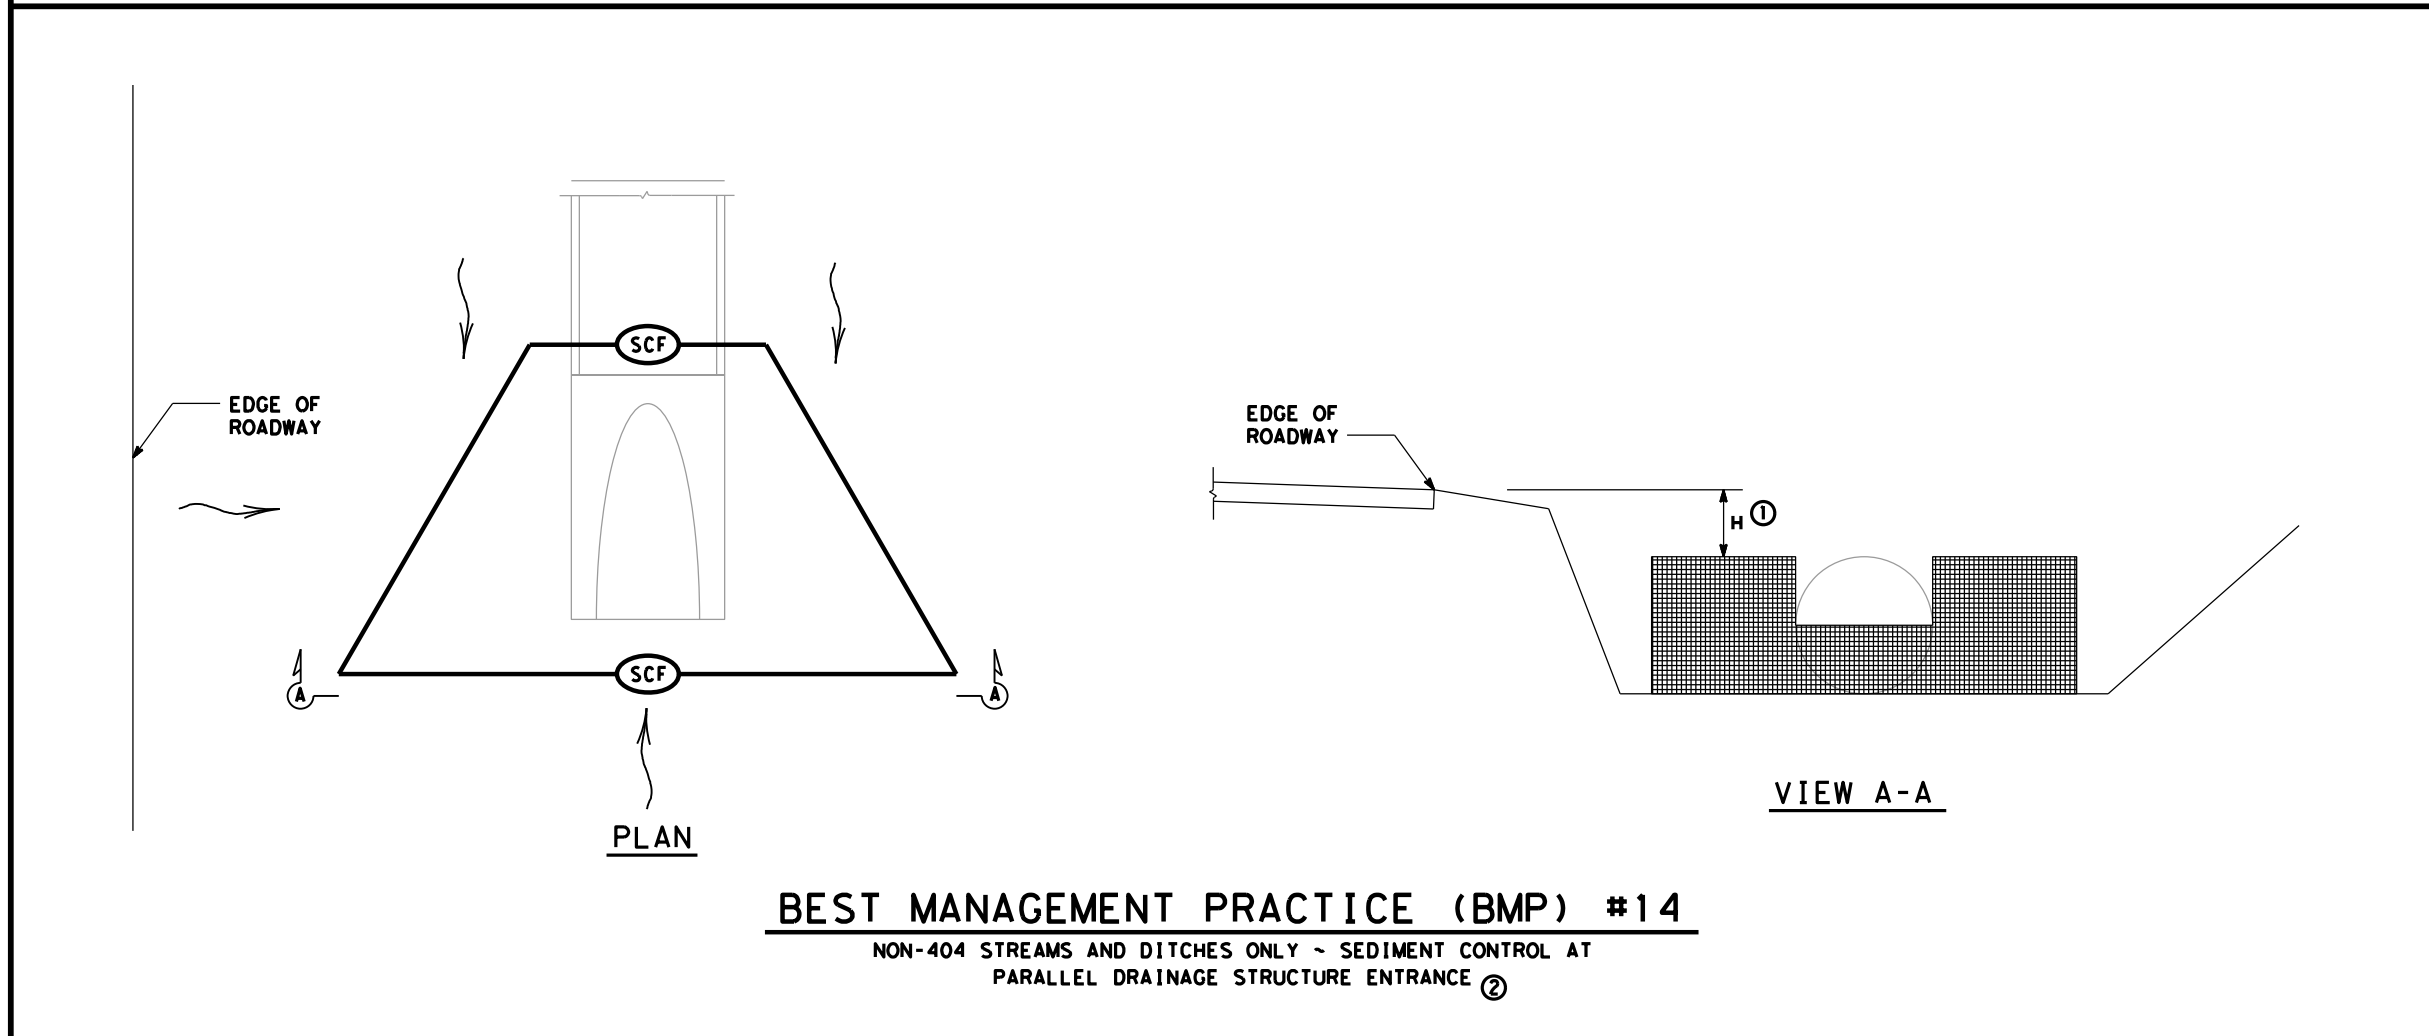

BEST MANAGEMENT PRACTICE (BMP) #14

NON-404 STREAMS AND DITCHES ONLY - SEDIMENT CONTROL AT PARALLEL DRAINAGE STRUCTURE ENTRANCE ②


SCALE = NTS SHEET 8 OF 10




TYPICAL APPLICATIONS FOR BEST MANAGEMENT PRACTICES

TA-BMP

FILE: BMPLAYOUTS.dgn	DN: TXDOT	CK: TXDOT	DW: TXDOT	CK: TXDOT
© TXDOT 2009	CONT	SECT	JOB	HIGHWAY
REVISIONS	2311	01	044	FM 3051
DEC 2013	DIST	COUNTY		SHEET NO.
FEB 2015	WAC	MCLENNAN		70

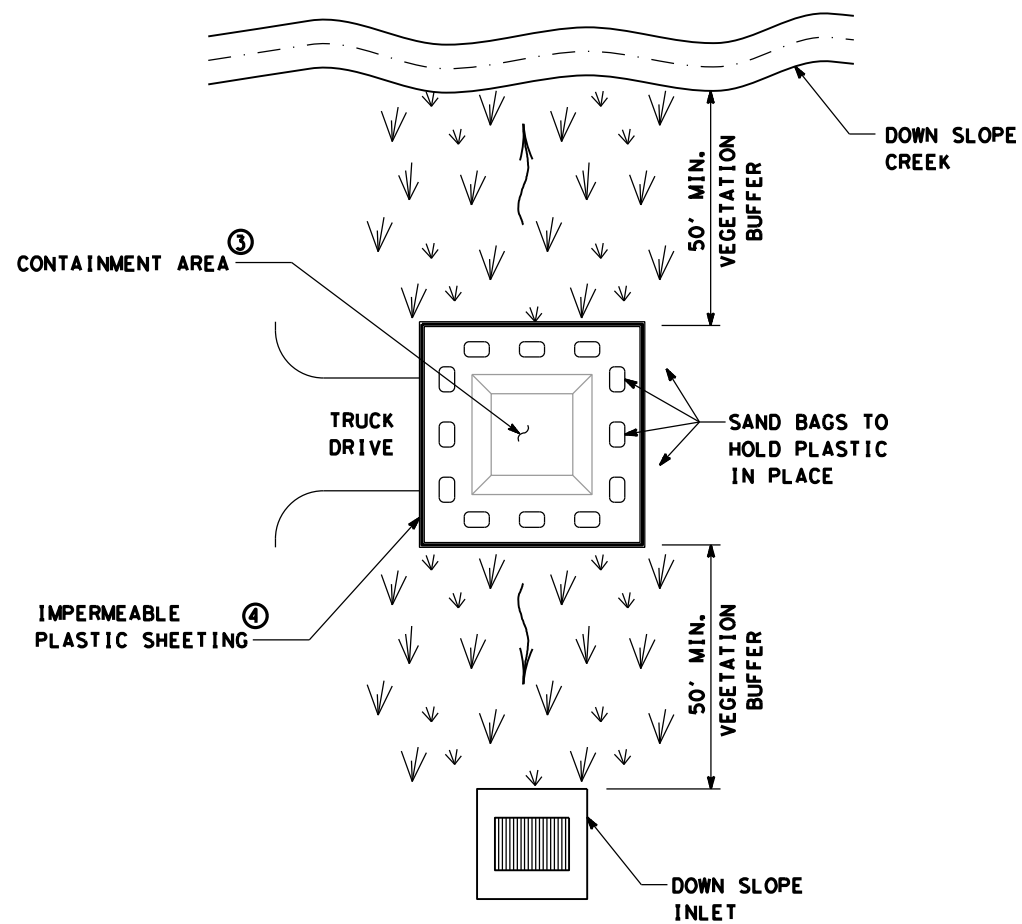


BEST MANAGEMENT PRACTICE (BMP) #15
CONCRETE TRUCK WASHOUT AREA

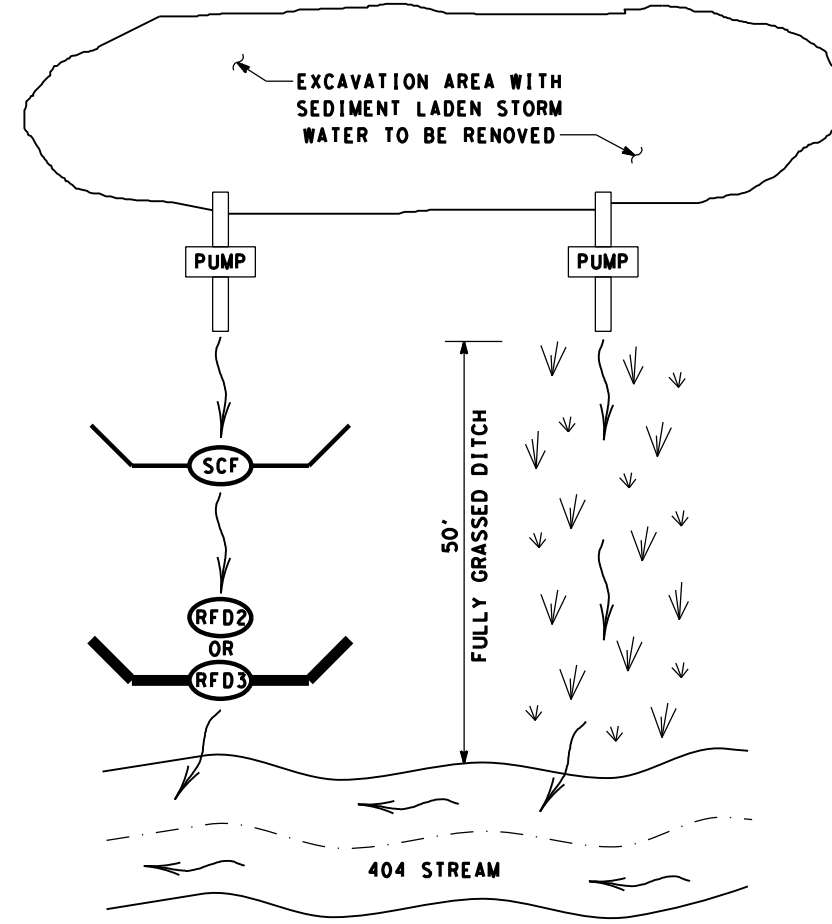


BEST MANAGEMENT PRACTICE (BMP) #16
PUMPED STORM WATER SEDIMENT CONTROLS ①

	FULLY GRASSED DITCH
	DIRECTION OF FLOW
	SEDIMENT CONTROL FENCE
	ROCK FILTER DAM (TY 2)
	ROCK FILTER DAM (TY 3)

- ① PUMPED STORM WATER FROM AN EXCAVATION AREA SHOULD BE DISCHARGED IN A 50' VEGETATIVE BARRIER OR THROUGH TWO TEMPORARY SEDIMENT CONTROLS BEFORE ENTERING A 404 STREAM.
- ② FOR LANDOWNER STOCKPONDS WITHIN 50' OF THE RIGHT OF WAY LINE, PROVIDE REDUNDANT SEDIMENT CONTROLS AT THE CONVEYANCE OF THE POND. MINIMUM OF TWO SEDIMENT CONTROLS.
- ③ WHEN CONTAINMENT AREA REACHES 1' FREEBOARD, DISCONTINUE WASHOUT PLACEMENT AND REMOVE MATERIAL UPON SOLIDIFICATION.
- ④ EACH TIME SOLIDIFIED MATERIAL IS REMOVED REPLACE PLASTIC SHEETING.

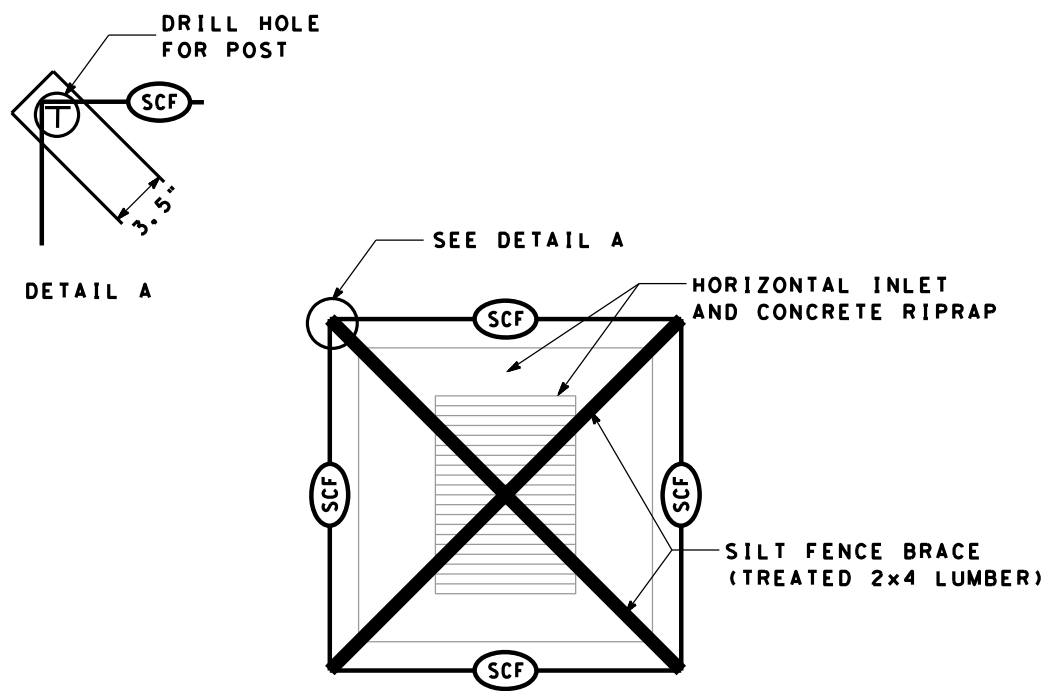

BEST MANAGEMENT PRACTICE (BMP) #17
HORIZONTAL INLET SEDIMENT CONTROL

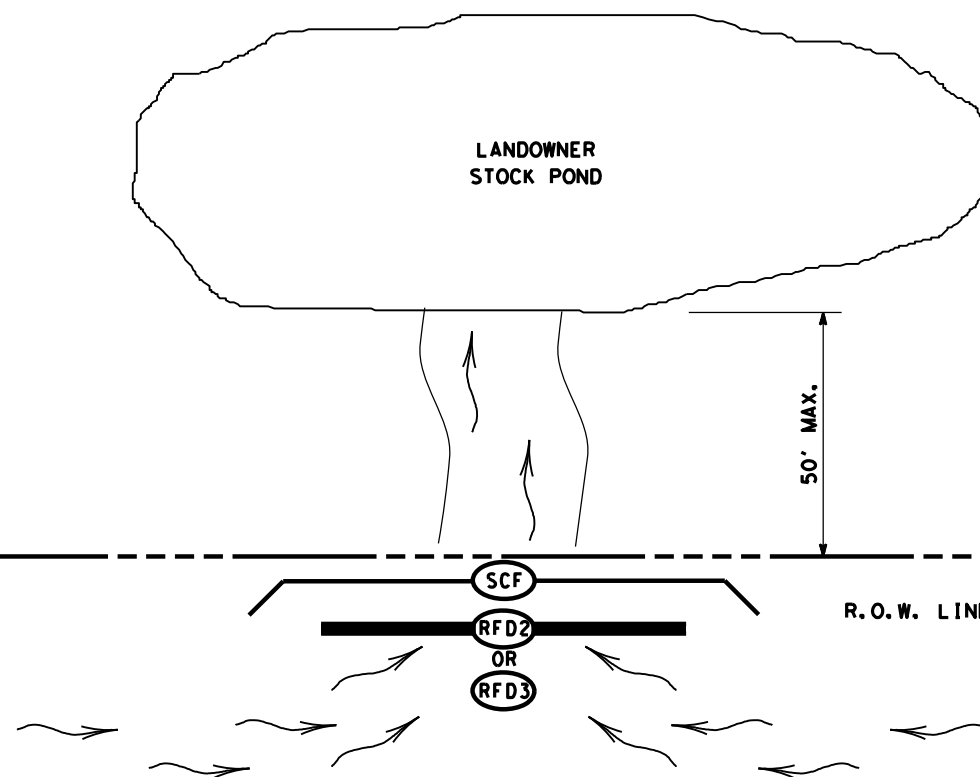

BEST MANAGEMENT PRACTICE (BMP) #18
LANDOWNER STOCKPOND SEDIMENT CONTROL ②


SCALE = NTS SHEET 9 OF 10

Texas Department of Transportation
Waco District Standard

TYPICAL APPLICATIONS FOR BEST MANAGEMENT PRACTICES


TA-BMP

FILE: BMPLAYOUTS.dgn	DN: TXDOT	CK: TXDOT	DW: TXDOT	CK: TXDOT
© TXDOT 2009	CONT	SECT	JOB	HIGHWAY
REVISIONS	2311	01	044	FM 3051
DEC 2013	DIST	COUNTY	SHEET NO.	
FEB 2015	WAC	MCLENNAN	71	

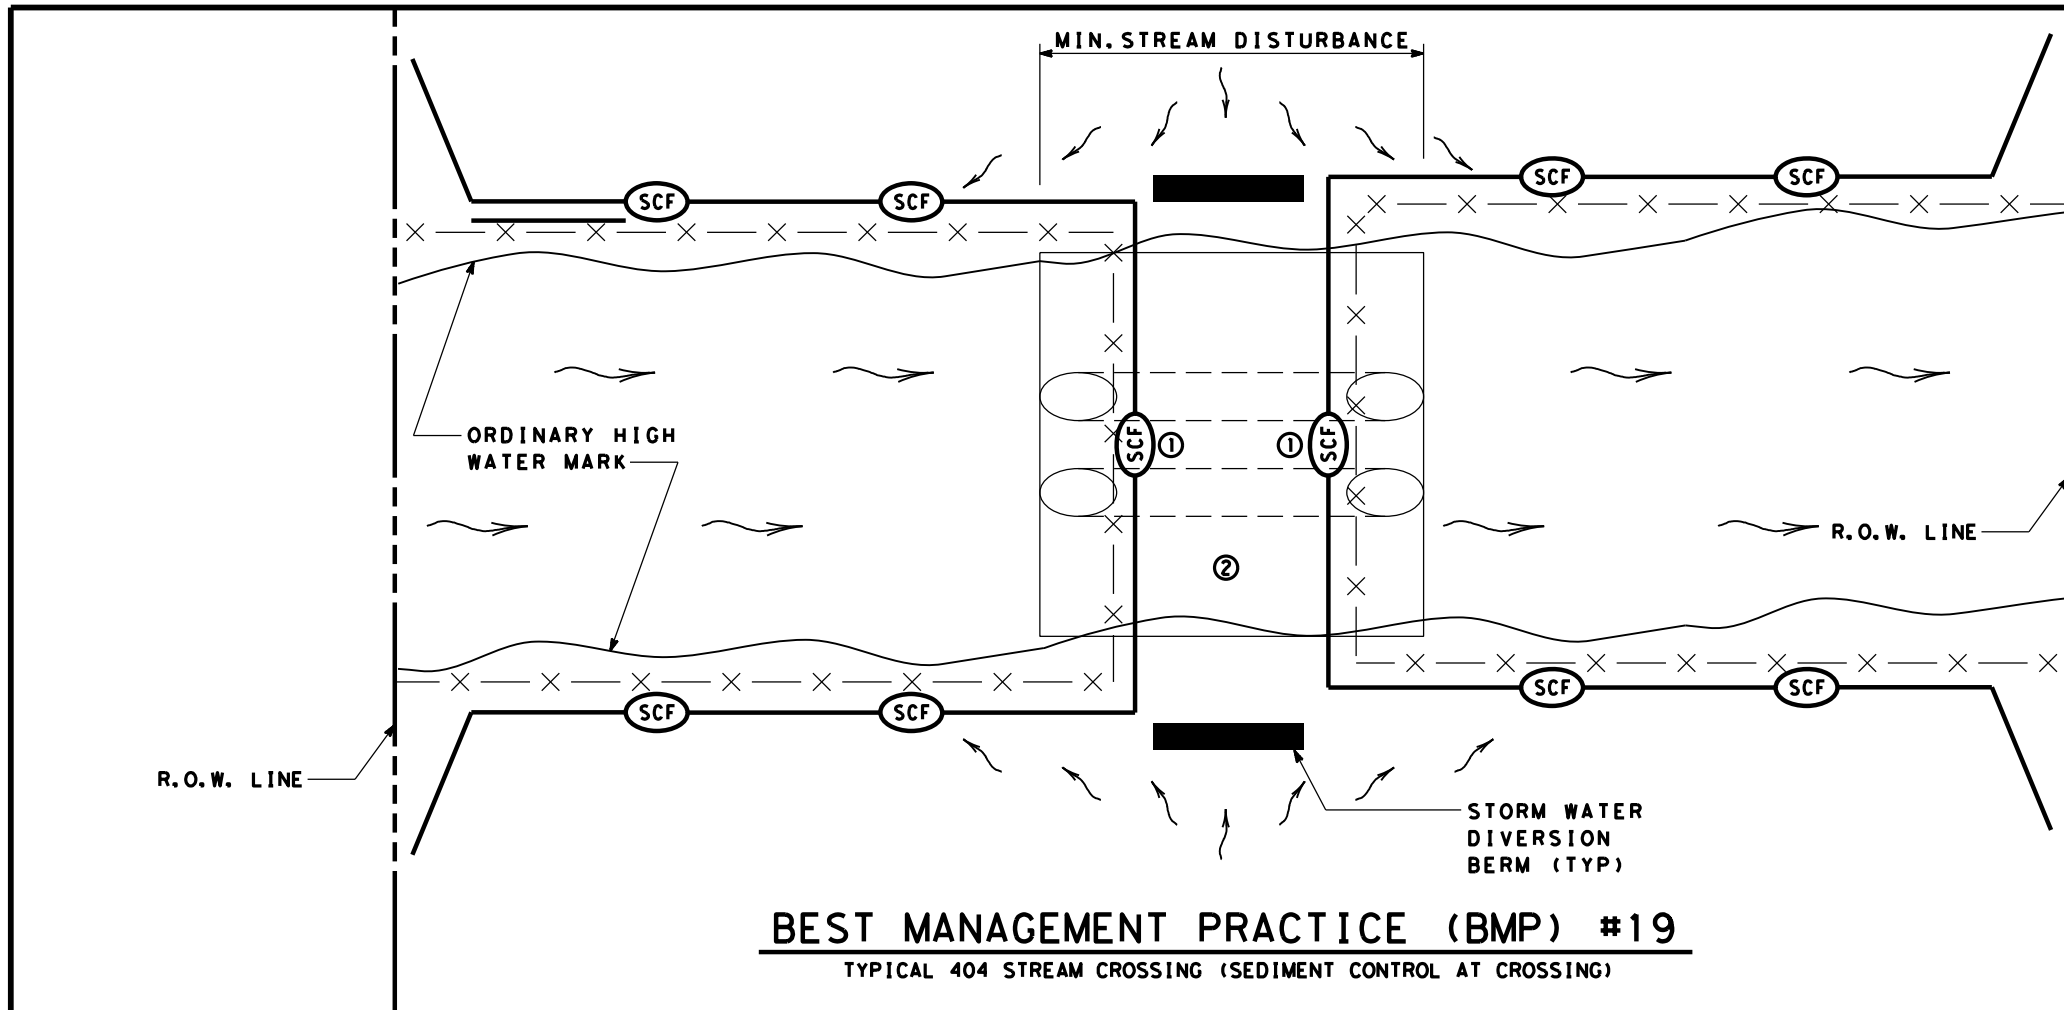

	DIRECTION OF FLOW
	SEDIMENT CONTROL FENCE
	ROCK FILTER DAM
	SECURITY FENCING

- ① HAY BALES MAY BE SUBSTITUTED FOR SILT FENCE OVER THE STREAM CROSSING.
- ② CROSSING WILL BE AS PER REQUIREMENTS OF THE WATERS OF THE US GENERAL NOTES.
- ③ INSTALL SILT FENCE SLIGHTLY UP FROM OHW MARK FROM R.O.W. TO R.O.W.
- ④ USE SILT FENCE L-HOOKS ON LEVEL OR DOWN SLOPING ENDS TO BLOCK STORM WATER SEDIMENT
- ⑤ INSTALL LARGE V OR U SHAPED BMP'S FROM ABUTMENT AS SHOWN. IF THERE IS STEEP DITCH CONDITIONS DECREASE SPACING AND CONSIDER RFD'S. ADD ADDITIONAL BMP'S IF GRADE IS STEEP OR IF FLOW IS HIGH.

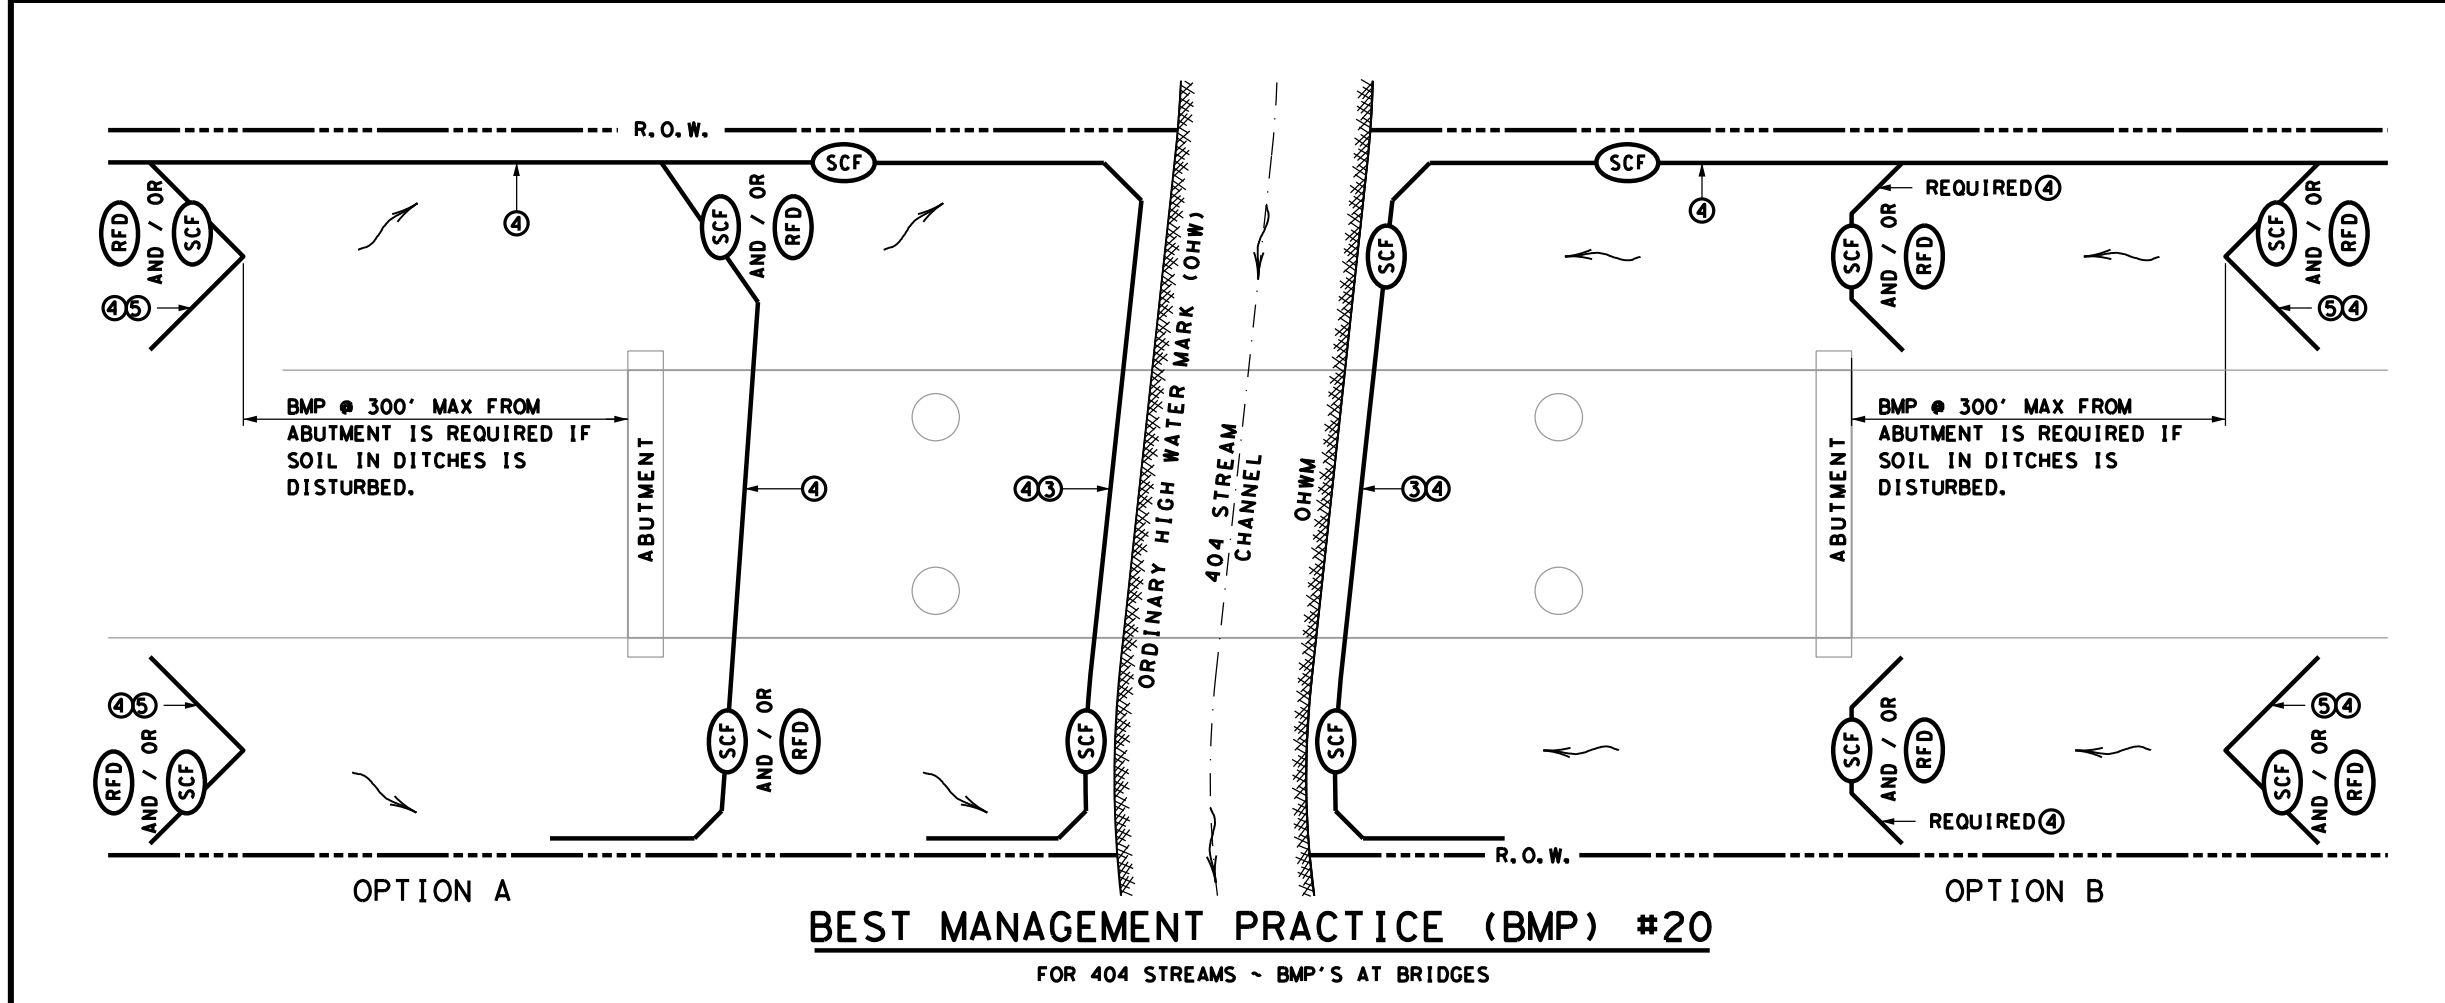

SCALE = NTS SHEET 10 OF 10



TYPICAL APPLICATIONS FOR BEST MANAGEMENT PRACTICES

TA-BMP

FILE: BMPLAYOUTS.dgn	DN: TXDOT	CK: TXDOT	DW: TXDOT	CK: TXDOT
© TXDOT 2009	CONT	SECT	JOB	HIGHWAY
REVISIONS	2311	01	044	FM 3051
DEC 2013	DIST	COUNTY		SHEET NO.
FEB 2015	WAC	MCLENNAN		72